


General Notes:


- NEW
- - - DESIGN TO BE REMOVED

DRAWING NOTES:

- EXISTING AND EXTERIOR LIGHTS FROM NEW PANELS NECESSARY TO MAKE CONNECTIONS SHALL BE SHOWN AS

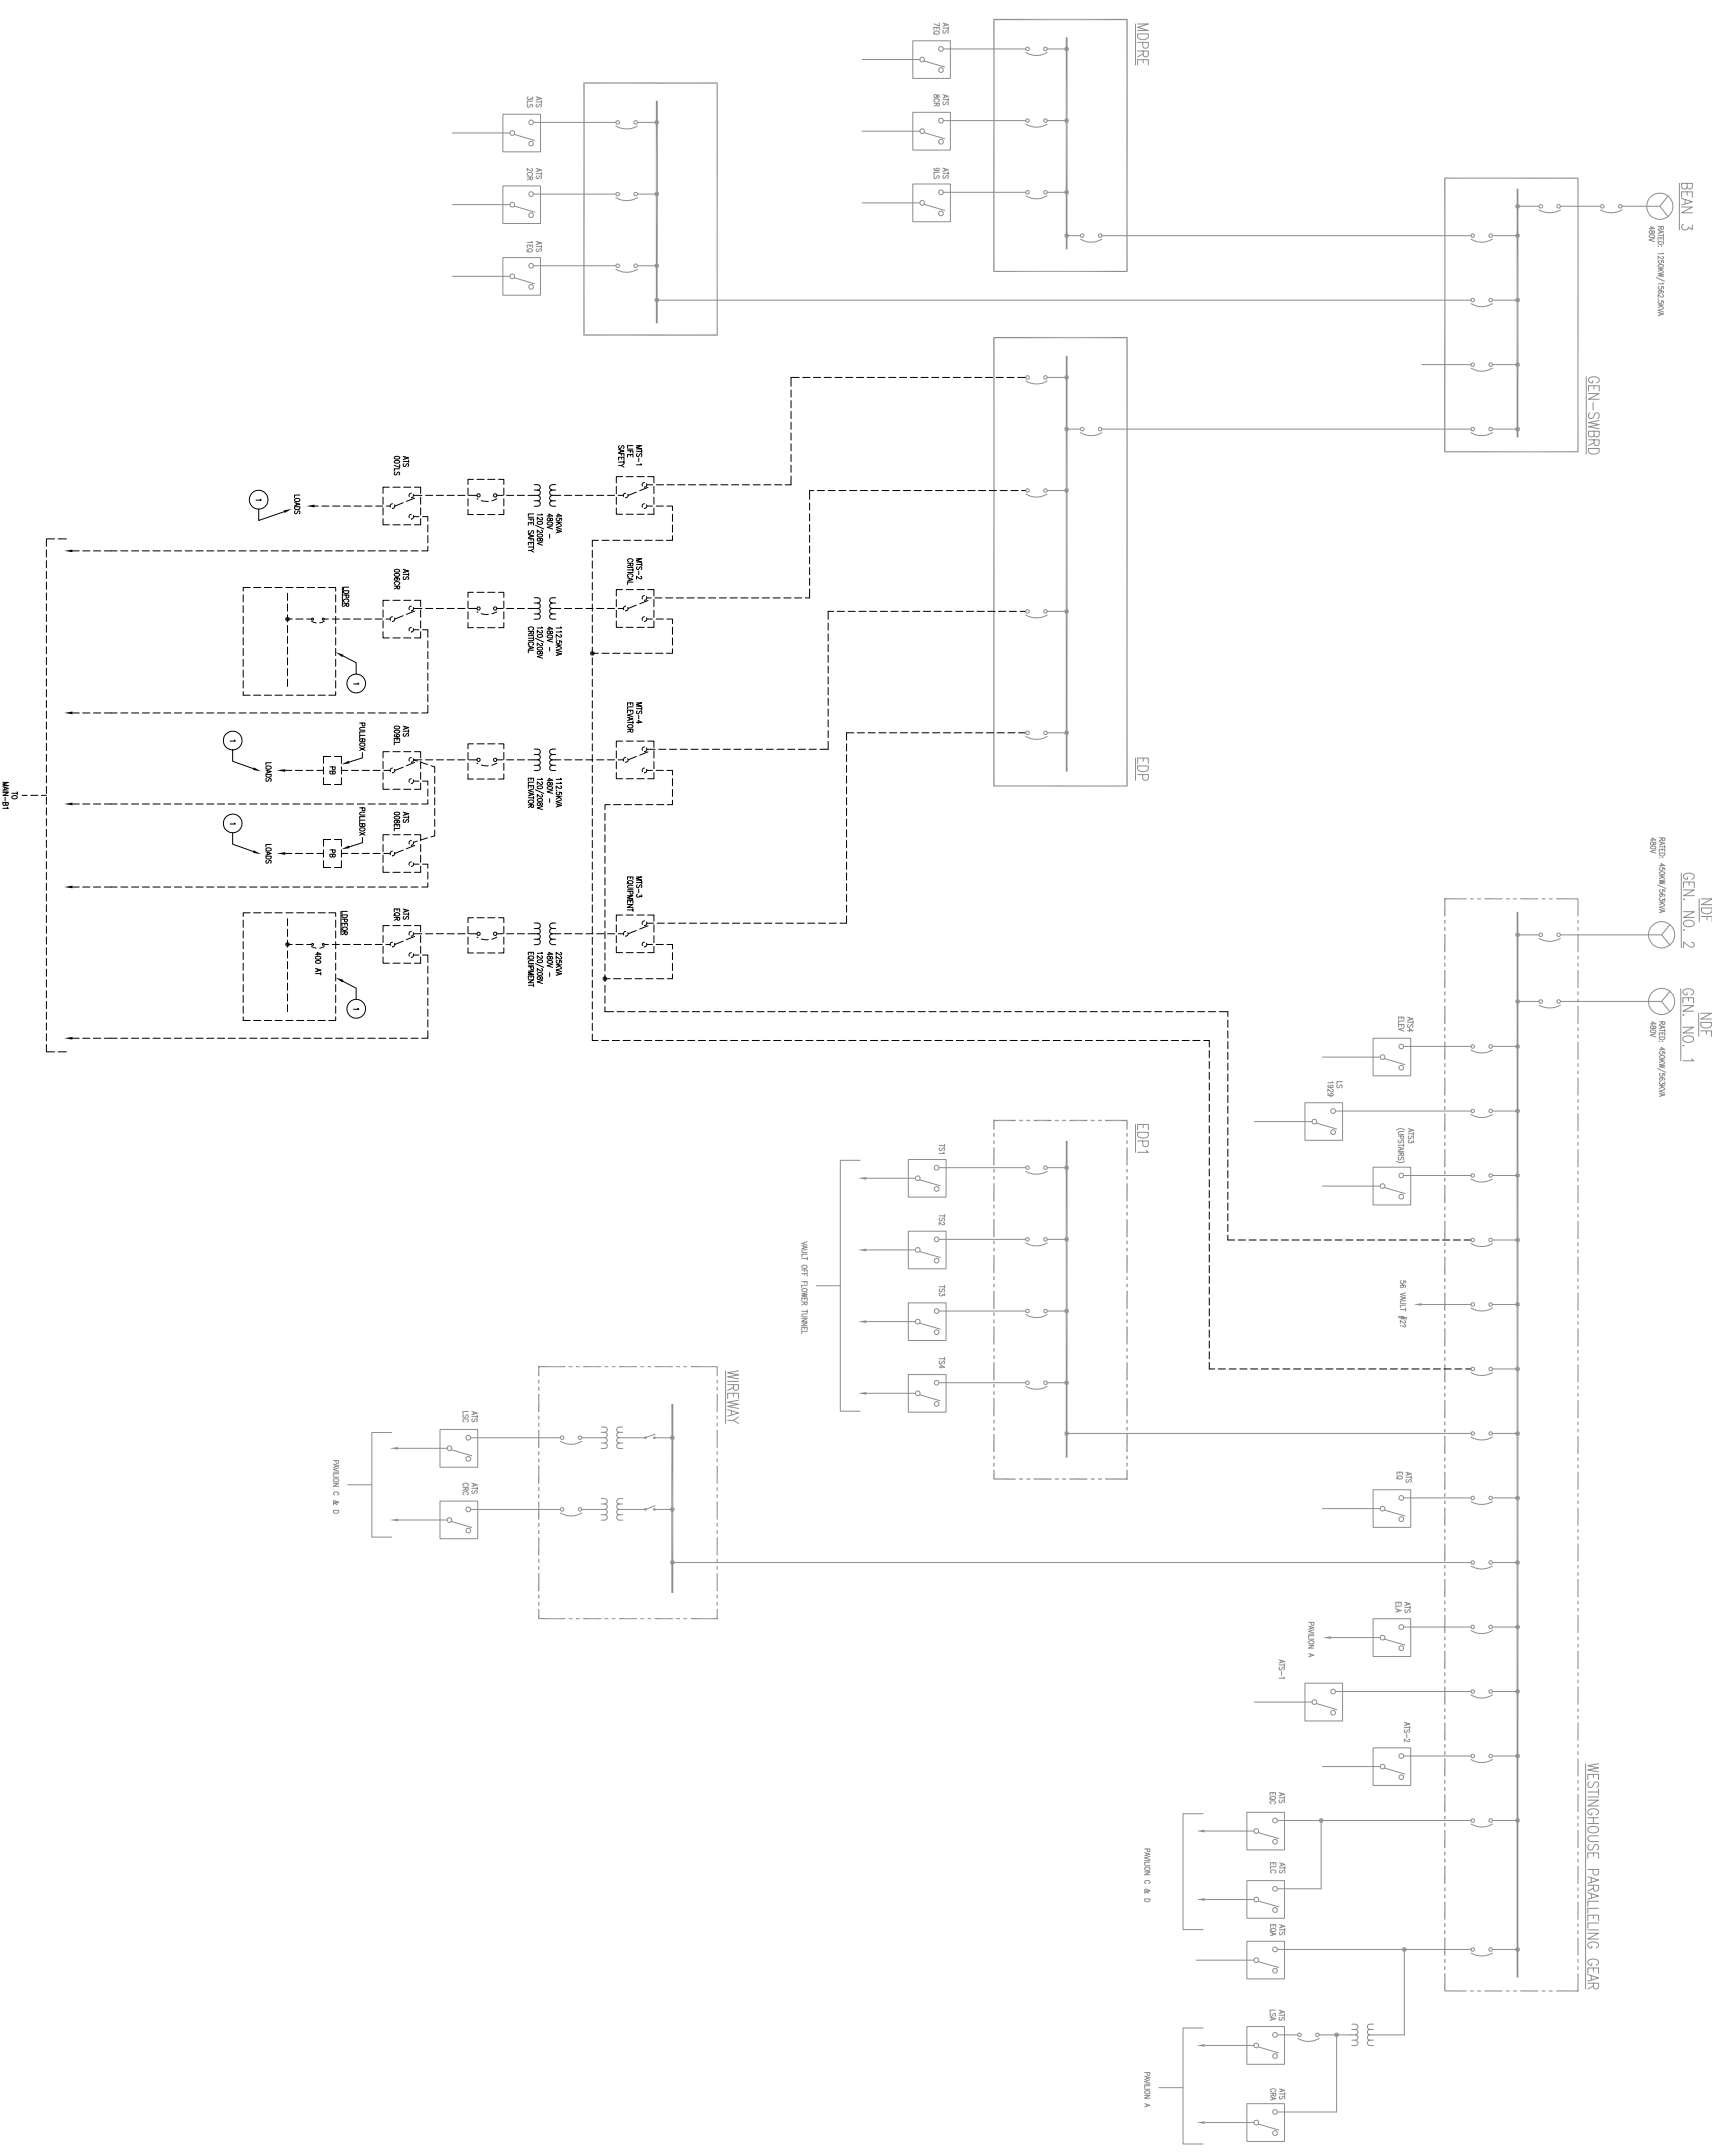

SCALE ONE INCH = ONE FOOT
FOR PERMIT ONLY - NOT FOR CONSTRUCTION
DATE: 09/24/14
PROJECT: CHARLES STREET - WEST FOR CONSTRUCTION
SHEET: 01

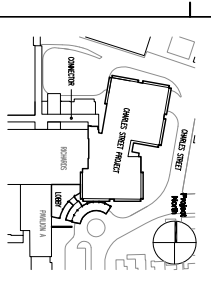

PRO
A ARCHITECTURE
PLANNING
SHOENING
LIVING
The Richards Group
1000 Congress Street
Portland, ME 04101
Tel: 603.761.1111
Fax: 603.761.1112

Maine Medical Center
Charles Street Project
Portland, Maine
MMC Project No. 21841

ELECTRICAL
EXISTING RICHARDS BUILDING
EMERGENCY ONE-LINE DIAGRAM

Commission No. 4822
Scale: 1/8" = 1'-0"
Date: 09/24/14
Project: CHARLES STREET - WEST FOR CONSTRUCTION
Sheet: 01
E621