


General Notes:  
**DRAWING NOTES**  
 1. SEE SHEET 17 AND MAIN NORMAL ELECTRIC ROOM IN SECTION FLOOR PLAN  
 2. SEE SHEET 17 AND MAIN EMERGENCY ELECTRIC ROOM IN SECTION FLOOR PLAN  
 3. SEE SHEET 17 AND MAIN EMERGENCY ELECTRIC ROOM IN SECTION FLOOR PLAN

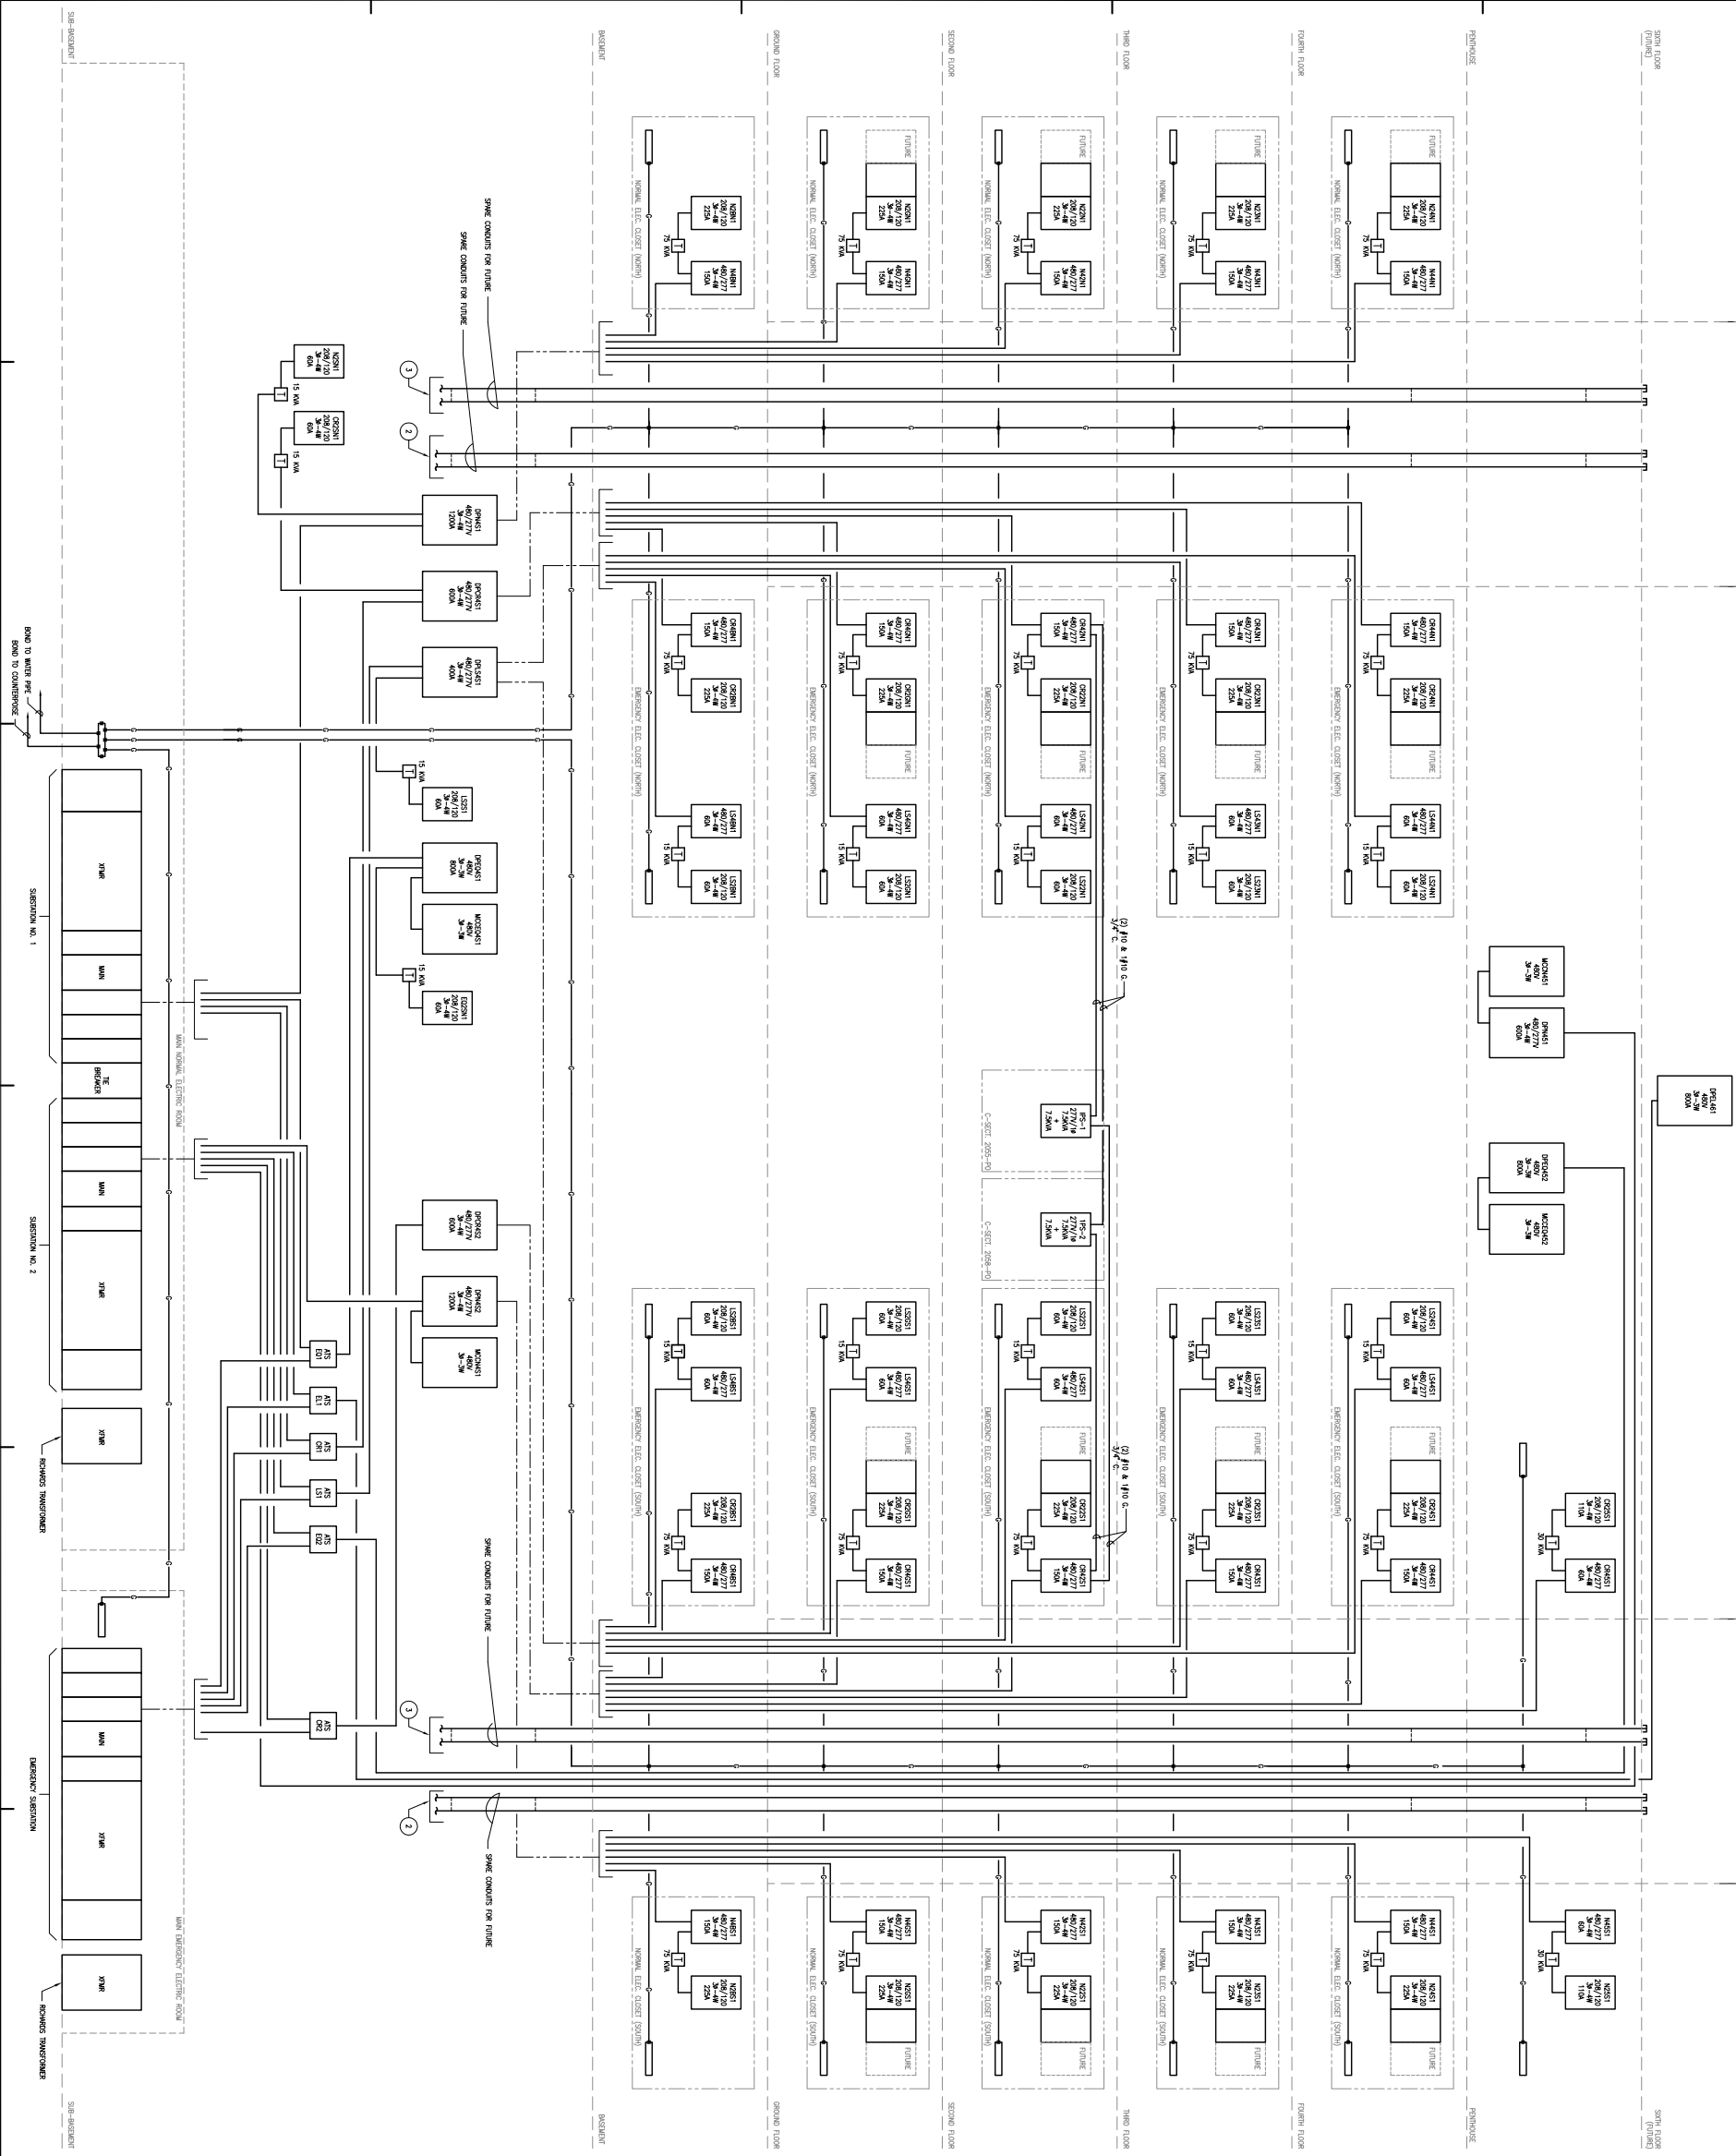

**PRO**  
 A ARCHITECTURE  
 SHOWNESSING  
 1177 South Commercial  
 Portland, ME 04108  
 Phone: 603-761-1100  
 Fax: 603-761-1101

**MAINE MEDICAL CENTER**  
 Charles Street Project  
 Portland, Maine  
 MMC Project No. 21841

**ELECTRICAL POWER**  
**CHARLES ST.**  
**RISER DIAGRAM**

Scale: 1/8" = 1'-0"

DATE: 09/24/14  
 DRAWN BY: [Name]  
 CHECKED BY: [Name]

Sheet No. **E624**