



General Notes:

- 1 REMOVE EXISTING ACQU.
- 2 REMOVE EXISTING WALL EXHAUST FANS AND PROVIDE AIRFLOW AS SHOWN AND FAN PERFORMANCE TESTING FOR FUTURE FANS) (FUTURE FANS)
- 3 PROVIDE AIRFLOW AS SHOWN AND FAN PERFORMANCE TESTING FOR FUTURE FANS) (FUTURE FANS)

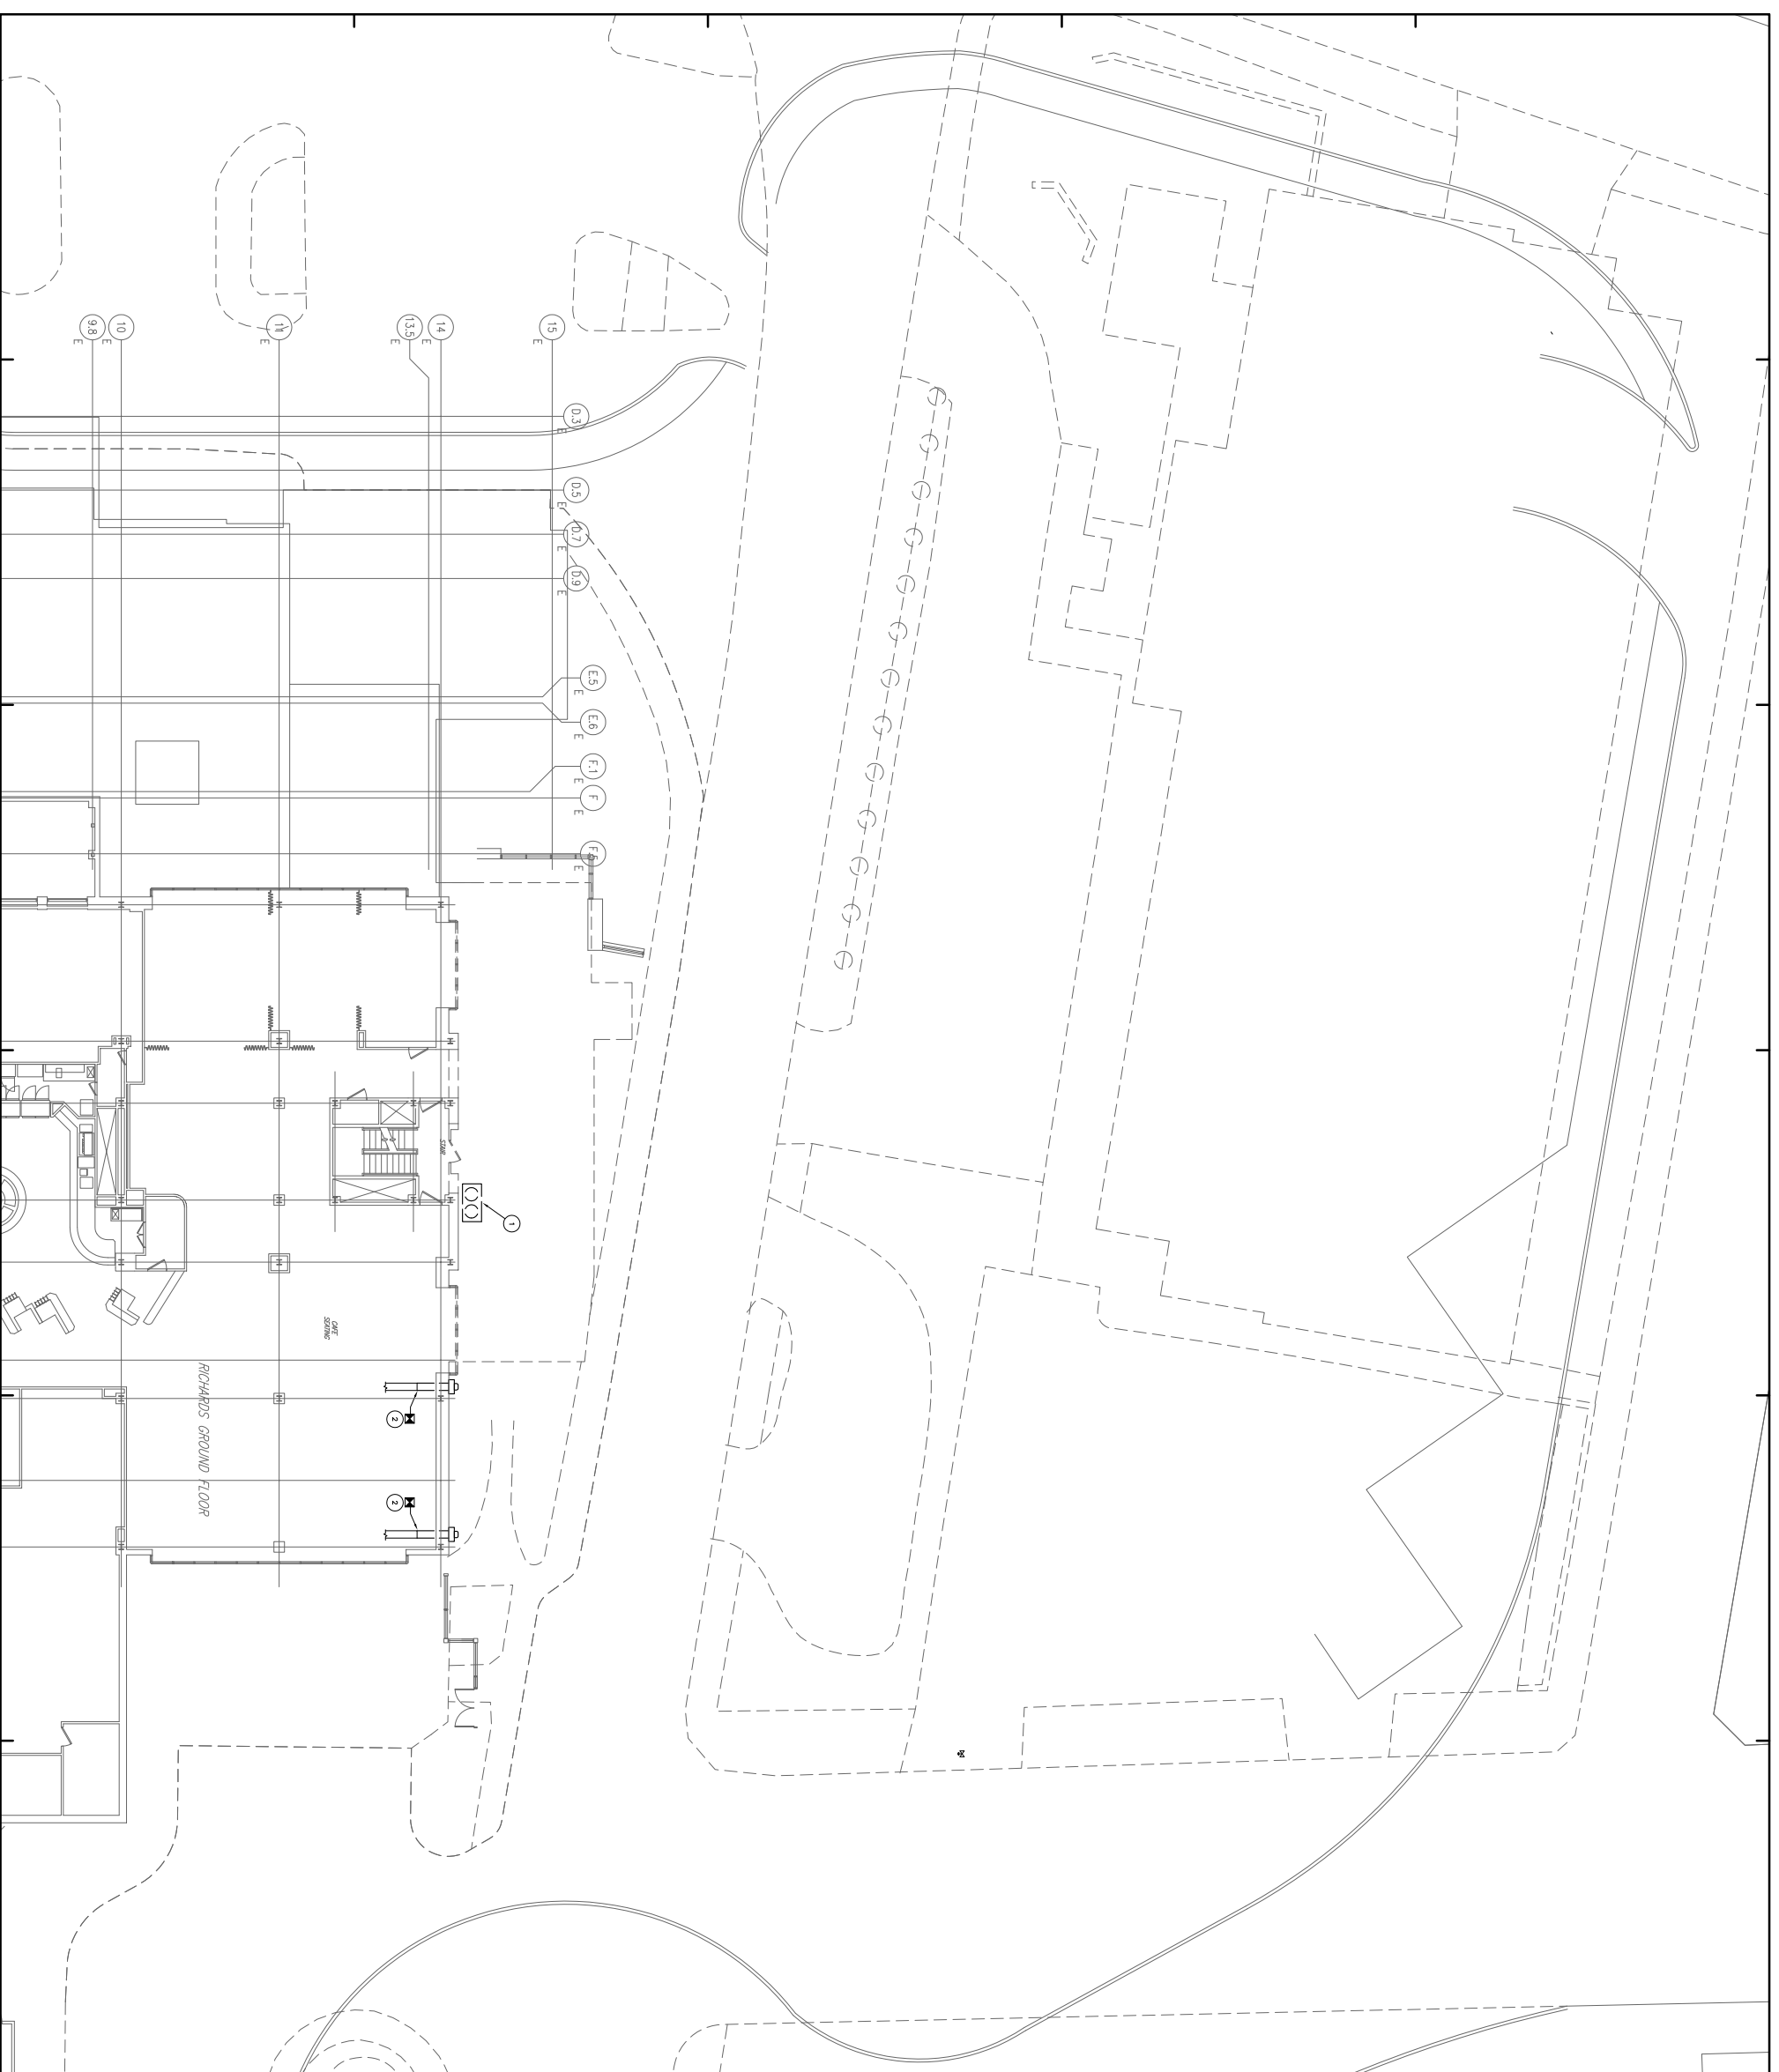

SCALE ONE
 NOT FOR PERMIT ONLY
 NOT FOR CONSTRUCTION

DATE: 09/24/14
 DRAWN BY: [Name]
 CHECKED BY: [Name]
 SCALE: AS SHOWN

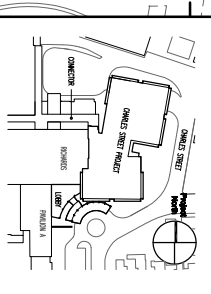

TRO
 ARCHITECTURE
 PLANNING
 INTERIOR DESIGN
 LANDSCAPE ARCHITECTURE
 1500 BROAD STREET
 PORTLAND, ME 04103
 TEL: 603.733.1111
 WWW.TROARCHITECTURE.COM

Maine Medical Center
 Charles Street Project
 Portland, Maine
 HVAC Project No. 21841

**HVAC
 GROUND FLOOR PLAN
 DEMOLITION**



Commission No.	4322	Date Issued	
Drawn By	FK	Scale	1/8" = 1'-0"
Checked By	FK	Project No.	4322
Project No.	4322	Sheet No.	H10G