



General Notes:  
 1 VOLUME DRAWINGS SHALL BE PROVIDED ON ALL LOW BRONCES (TYP.) - REVISION AND DRAWING DATA

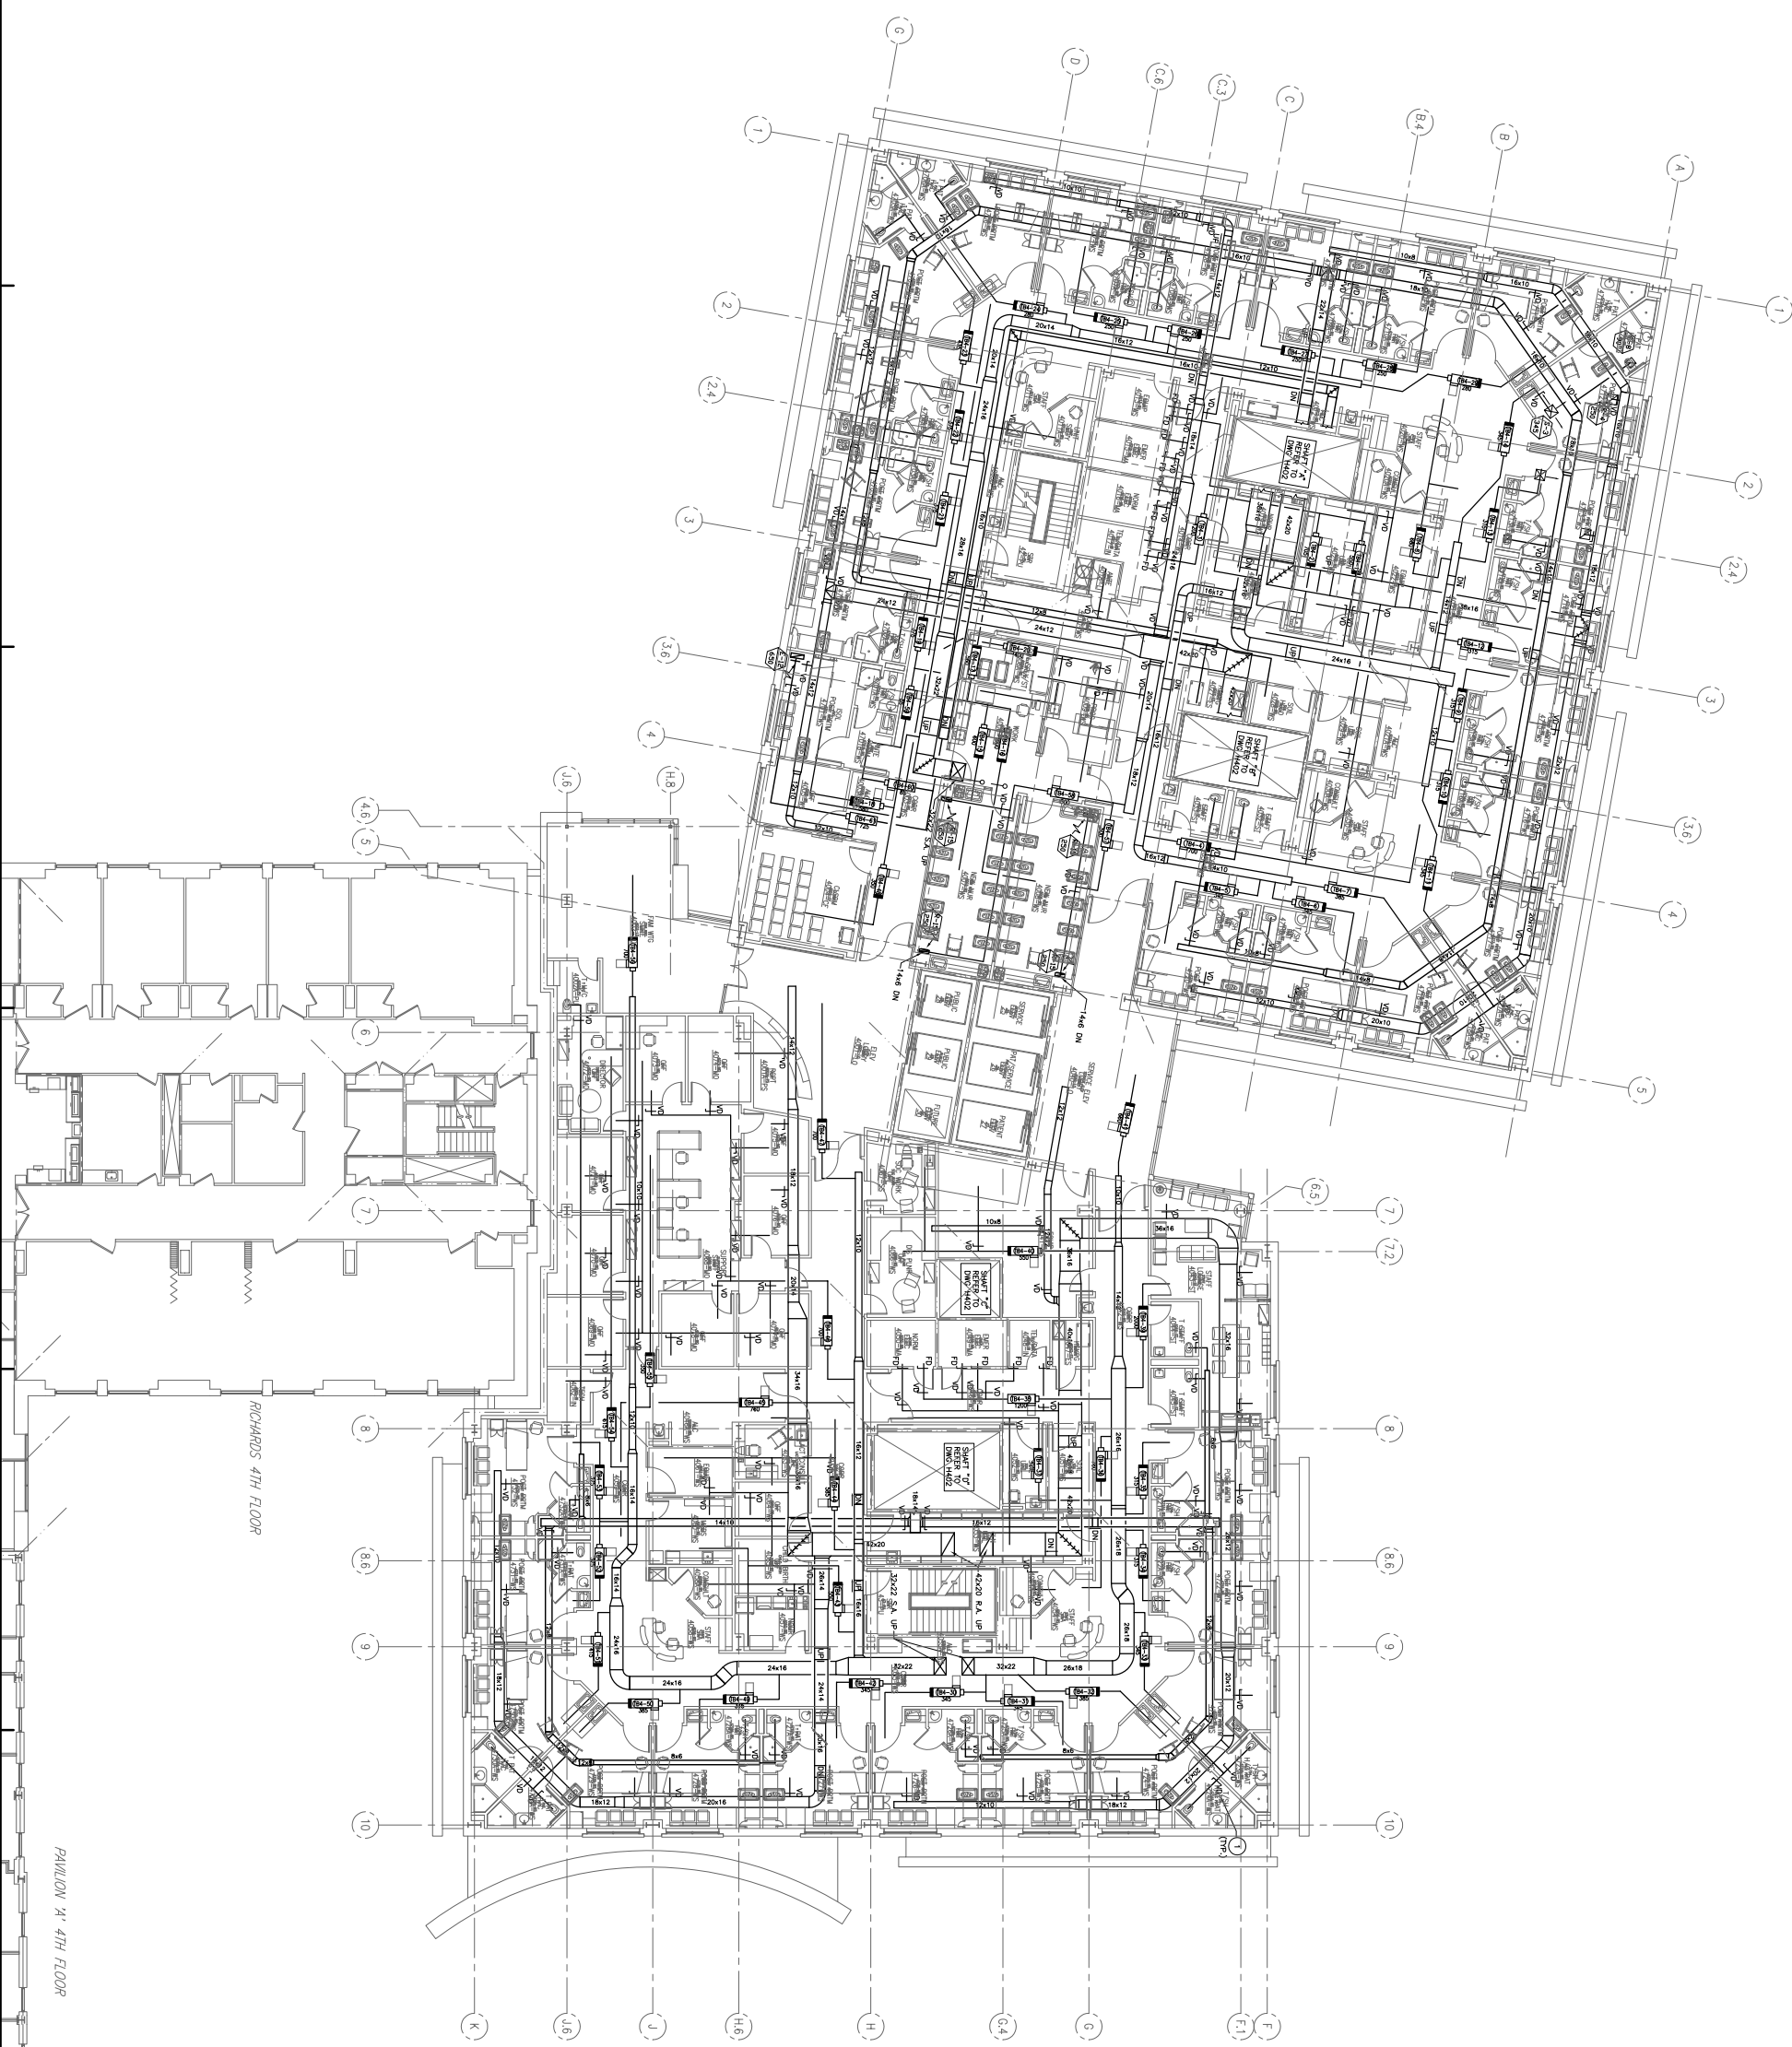

SCALE: AS SHOWN  
 DATE: 09/24/14  
 PROJECT: ST. JOSEPH'S HOSPITAL  
 DRAWING: 4TH FLOOR HVAC DUCTWORK  
 SHEET: H204

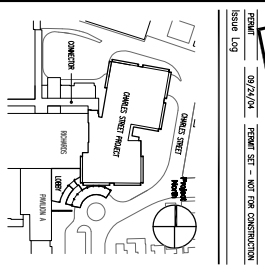

**PRO**  
 ARCHITECTURE  
 PLANNING  
 ENGINEERING  
 INTERIORS  
 LANDSCAPE ARCHITECTURE  
 THEATRE ARCHITECTURE  
 HISTORIC PRESERVATION  
 1000 BROAD STREET  
 PORTLAND, ME 04108  
 TEL: 603.763.1234  
 FAX: 603.763.1235  
 WWW.PROARCHITECTURE.COM

**Maine Medical Center**  
 Charles Street Project  
 Portland, Maine  
 MMC Project No. 21841

ISSUED FOR:  
 HVAC  
 4TH FLOOR PLAN  
 DUCTWORK

CONTRACT NO. 4822  
 DESIGN NUMBER  
 SHEET NO. H204  
 DATE: 09/24/14  
 DRAWN BY: J. BROWN  
 CHECKED BY: M. BROWN  
 PROJECT NO. 4822  
 SHEET NO. H204