



- General Notes:
- 1 AC-1 MOUNTED ON 1" CURB.
 - 2 PROVIDE COOLING COIL CONDENSATE DRAIN RAMP, PVA TRAP, AND MANUFACTURER'S RECOMMENDATIONS.
 - 3 PROVIDE STAINLESS STEEL SUPPORT BRACKETS FOR BRASS STAINLESS STEEL HANGERS TO BE USED FOR CONDENSATE DRAIN PIPING. SEE PIPING ROOF PENETRATION EXPANSION. ALSO SEE PIPING ROOF PENETRATION EXPANSION.

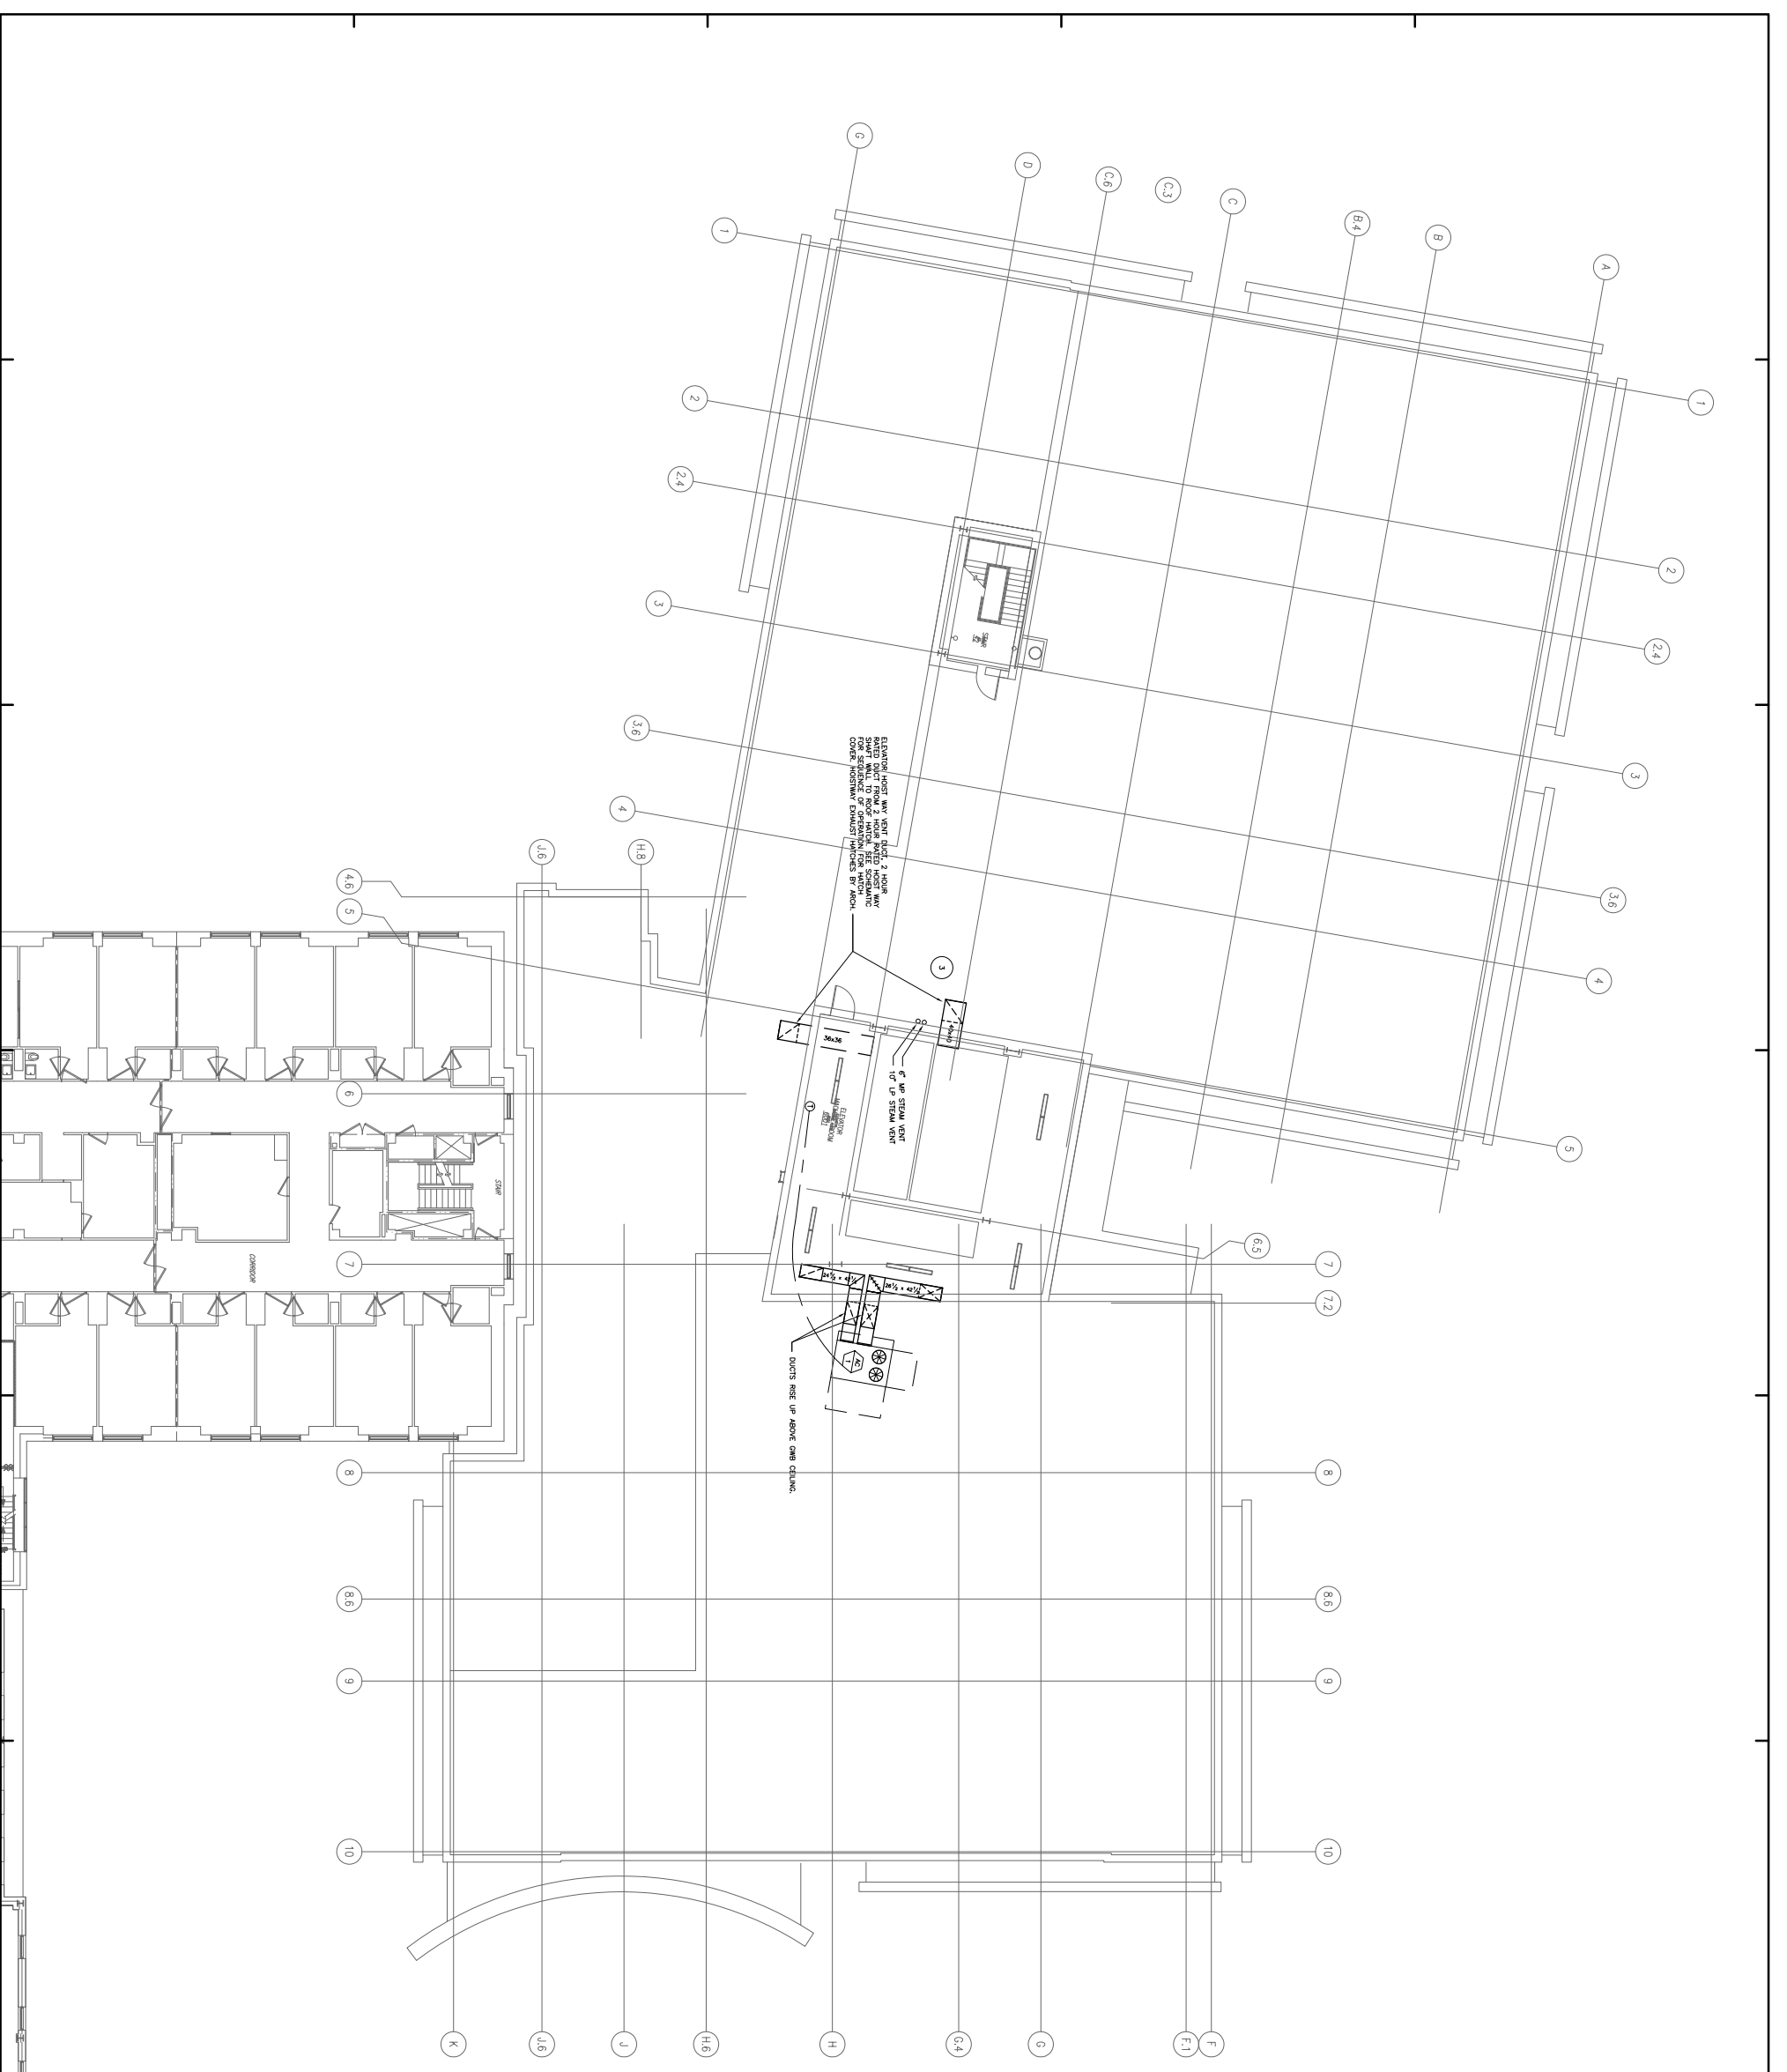

ISSUE DATE: 09/24/14
 FOR PERMIT ONLY
 NOT FOR CONSTRUCTION

SCALE LOG
 09/24/14 FERRY SET - NET FOR CONSTRUCTION
 SCALE LOG

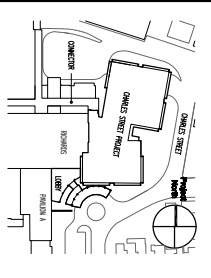

PRO
 ARCHITECTURE
 PLANNING
 ENGINEERING
 INTERIORS
 THE MAINE MEDICAL CENTER
 1000 MAINE STREET
 PORTLAND, ME 04103

MAINE MEDICAL CENTER
 Charles Street Project
 Portland, Maine
 HVAC Project No. 21841

**HVAC ELEVATOR
 MACHINE ROOM / PENTHOUSE
 ROOF PLAN**

Commission No. 4223
 Scale: 1/8" = 1'-0"
 Date: 09/24/14
 Project: H205