


PLUMBING SUB-BASEMENT - DEMOLITION

1/8"=1'-0"

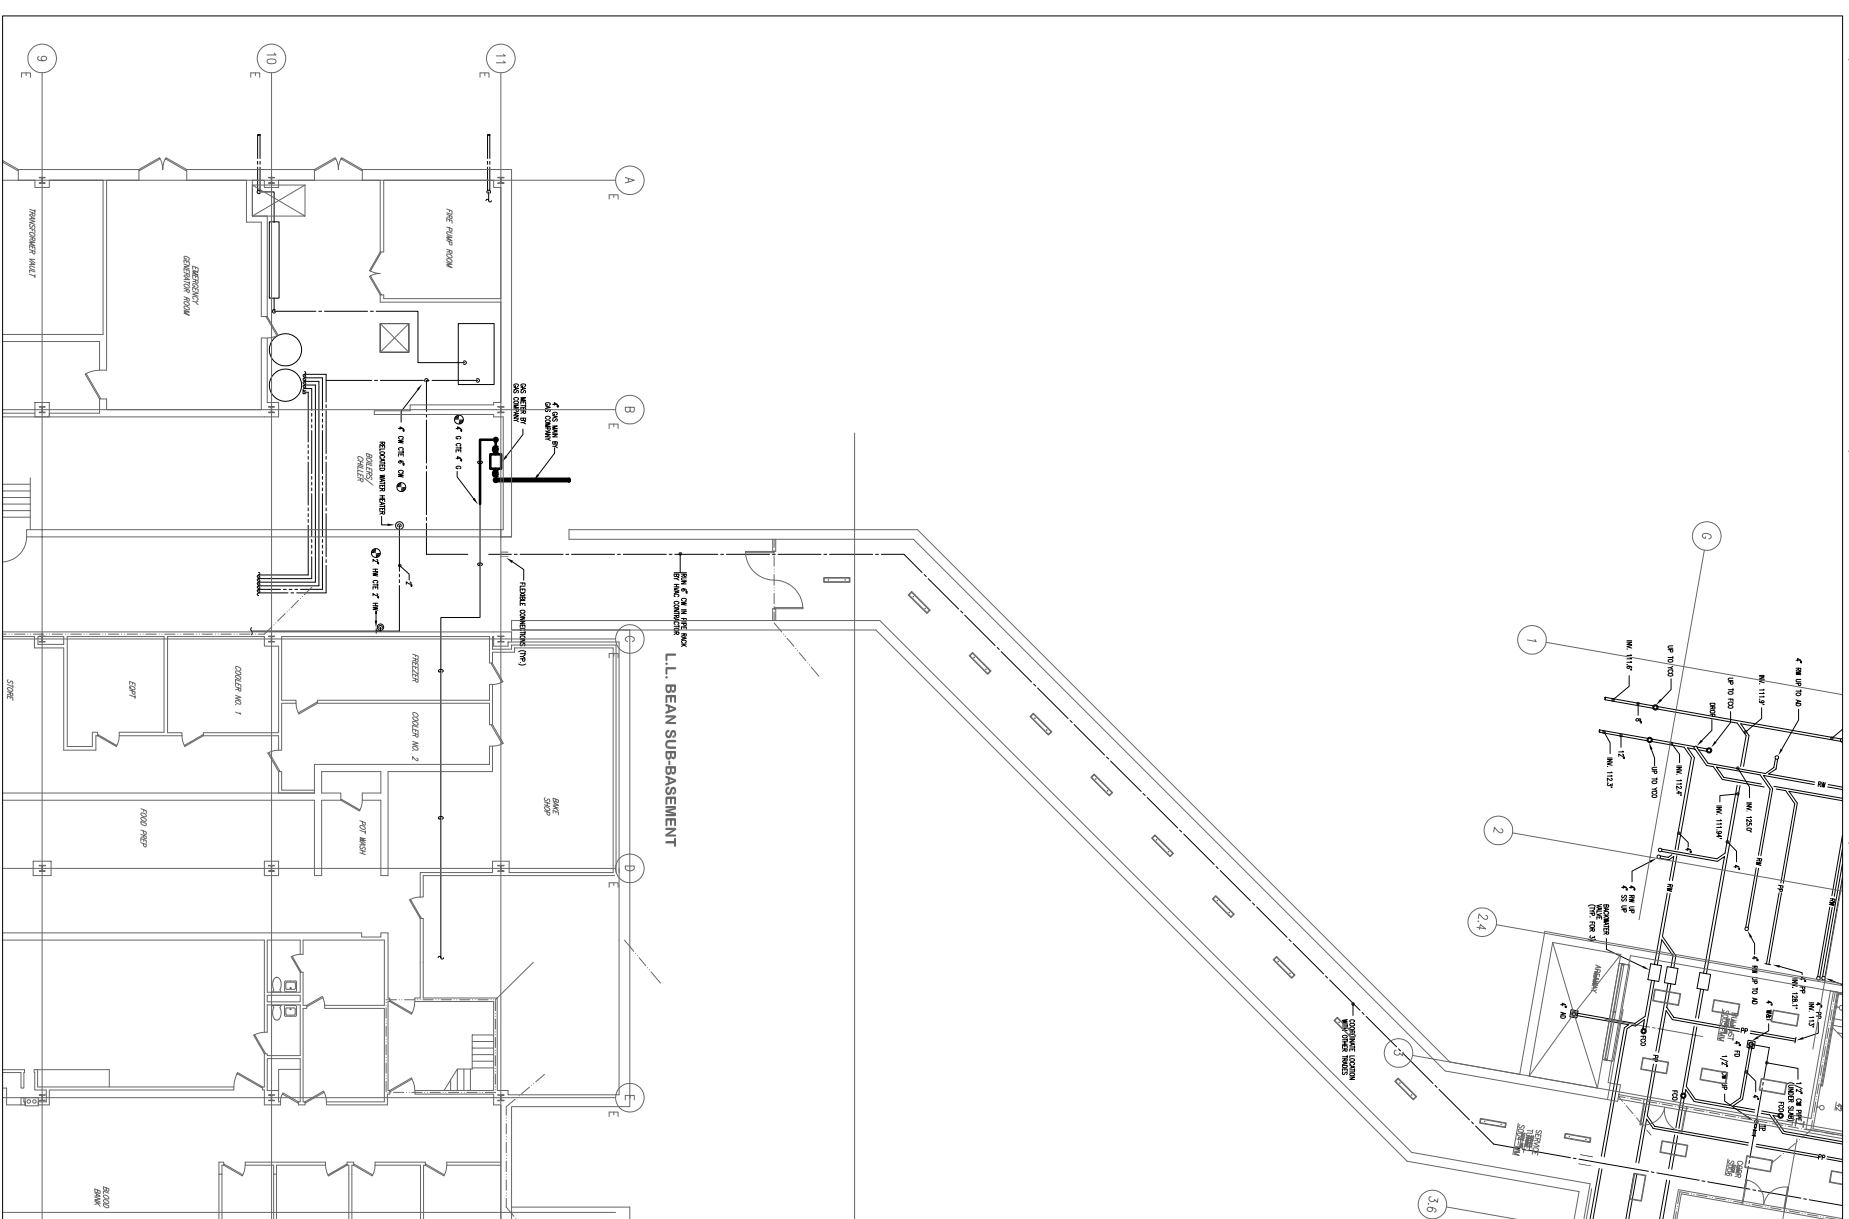


PLUMBING SUB-BASEMENT - RENOVATION

1/8"=1'-0"

SCALE SHEET
 FOR PERMIT ONLY
 NOT FOR CONSTRUCTION

DATE: 09/24/14
 PROJECT: FIRE PUMP ROOM - NOT FOR CONSTRUCTION

SCALE LOG

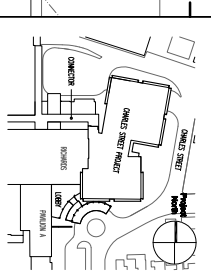

PRO
 ARCHITECTURE
 PLANNING
 1477 Main Street
 Portland, ME 04101
 Phone: 603-761-1111
 Fax: 603-761-1112

Maine Medical Center
 Charles Street Project
 Portland, Maine
 MMC Project No. 21841

PLUMBING SUB-BASEMENT FLOOR PLANS - DEMOLITION/RENOVATION

Commission No. 4933
 Scale 1/8"=1'-0"
 Drawing No. P20SB.2