

NOTE:

1. SEE FP001 FOR THE LEGEND, ABBREVIATIONS, & SPECIFICATIONS.

FIRE PROTECTION NOTES:

1. MODIFY AND REWORK SPRINKLER SYSTEMS IN SCOPE OF WORK PER THE REQUIREMENTS OF NFPA 13.
2. MODIFY AND REWORK EXISTING SPRINKLER SYSTEM TO AVOID CONFLICTS WITH HVAC, CEILING HEIGHT CHANGES AND OTHER NEW INSTALLATIONS.

REV	DESCRIPTION	DATE
0	ISSUED FOR CONSTRUCTION	4-25-17


ISSUED FOR CONSTRUCTION
4-25-17

CURRENT ISSUE STATUS:

PROJECT NORTH:
SMRT Architects and Engineers
144 Fore Street
Portland, Maine 04104
1.877.700.7678
www.smrting.com
ARCHITECTURE | ENGINEERING | PLANNING | INTERIORS | ENERGY

**MAINE MEDICAL PARTNERS
SURGICAL CARE RENOVATIONS**

PORTLAND, MAINE
FIRE PROTECTION PLAN

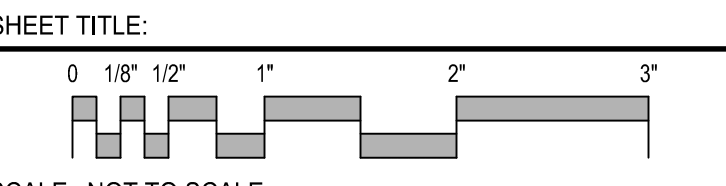

SCALE: NOT TO SCALE

PROJECT MANAGER:	DJV	PROJECT NO.:	17027
A/E OF RECORD:	RMW		
JOB CAPTAIN:	CAH		
DRAWN BY:	CVF		
SMRT FILE:	FP101-17027	SHEET No.:	FP101

LEVEL 4 - FIRE PROTECTION PLAN (A1)
1/8" = 1' - 0"