

MAINE MEDICAL PARTNERS SURGICAL CARE RENOVATIONS


GENERAL NOTES:

- FIELD VERIFY ALL DIMENSIONS AND LAYOUT PRIOR TO PROCEEDING WITH WORK. NOTIFY ARCHITECT IN WRITING OF ANY DISCREPANCIES OR INCONSISTENCIES. FAILURE TO REPORT ANY DISCREPANCIES WITHIN THESE CONSTRUCTION DOCUMENTS TO THE ARCHITECT WILL NOT BE GROUNDS FOR ADDITIONAL COST OR CHANGE ORDERS.
- CONTRACTOR SHALL BE RESPONSIBLE FOR PROVIDING ALL MATERIALS (UNLESS NOTED OTHERWISE), AND WORKMANSHIP IN ACCORDANCE WITH FEDERAL, STATE, CITY, AND LOCAL BUILDING CODES AND THEIR REQUIREMENTS.
- CONTRACTOR AND ALL TRADES SHALL NOTE REQUIREMENTS OF "GENERAL NOTES" ON ALL SHEETS.
- EACH TRADE TO PROVIDE SMOKE OR FIRE SEALANT AT PENETRATIONS AS REQUIRED FOR WALL TYPE (UNLESS NOTED OTHERWISE). ALL SEALANT, FIRE STOPPING AND SMOKE STOPPING ASSEMBLIES SHALL BE U.L. RATED.
- REFER TO ALL CONSTRUCTION DOCUMENTS FOR REQUIREMENTS WHICH MAY AFFECT THE WORK IN ANOTHER AREA AND/OR DISCIPLINE AND COORDINATE.
- PROVIDE BLOCKING IN WALLS AS NECESSARY WHERE CASEWORK, FURNITURE, SHELVES, HANDRAILS, AND/OR OTHER MISC. EQUIPMENT IS LOCATED.
- DO NOT SCALE CONSTRUCTION DOCUMENTS.
- PROVIDE MEANS "FURNISH AND INSTALL".

ABBREVIATIONS:

AB	ANCHOR BOLT	L	ANGLE / LENGTH
A/C	AIR CONDITIONING	LF	LEFT
ACCU	AIR CONDITIONING CONDENSER UNIT	LINO	SHEET LINOLEUM
ACPLAS	ACCOUSTICAL PLASTER	LL	LIVE LOAD
ACT	ACOUSTIC CEILING TILE	LLH	LONG LEG HORIZONTAL
AFI	ABOVE FINISH FLOOR	LLV	LONG LEG VERTICAL
AGG	AGGREGATE	LP	LIGHTING PANEL / LIQUIFIED PROPANE
ALT	ALTERNATE		
AP	ACCESS PANEL	MAX	MAXIMUM
APROX	APPROXIMATE	MB	MARKER BOARD
ARCH	ARCHITECTURAL	MDO	MEDIUM DENSITY OVERLAY
		MECH	MECHANICAL
BCX	BOTTOM CORD EXTENSION	MFR	MANUFACTURER
BD	BOARD	MIN	MINIMUM
BIT	BITUMINOUS	MISC	MISCELLANEOUS
BLDG	BUILDING	MO	MASONRY OPENING
BLP	BLENDED LIGHT PANEL	MR	MOISTURE-RESISTANT
BO	BOTTOM OF	MUA	MAKE-UP AIR
BOF	BOTTOM OF FOOTING		
BOS	BOTTOM OF STEEL	N	NOSING
BOT	BOTTOM	NCB	NEW CATCH BASIN
BRDG	BRIDGING	NDMH	NEW DRAIN MANHOLE
BRG	BEARING	NFM	NEW FORCE MAIN
BS	BOTH SIDES	NIC	NOT IN CONTRACT
BSE	BRICK SHELF ELEVATION	NS	NEAR SIDE
		NSD	NEW STORM DRAIN LINE
C	CHANNEL	NSS	NEW SANITARY SEWER LINE
CB	CATCH BASIN / CHALKBOARD	NTS	NOT TO SCALE
CEM BD	CEMENTITIOUS BACKER BOARD	NW	NEW WATER LINE
CFM	CUBIC FEET PER MINUTE		
CIP	CAST IN PLACE	OC	ON CENTER
CJ	CONTROL JOINT / CONSTRUCTION JOINT	OF	OUTSIDE FACE
CL	CENTER LINE	OH	OVERHEAD
CLL	CONTRACT LIMIT LINE		
CLR	CLEAR	PA	PUBLIC ADDRESS
CMU	CONCRETE MASONRY UNIT	PAF	POWER-ACTUATED FASTENER
COL	COLLUMN	POU	POOL DEHUMIDIFICATION UNIT
CONC	CONCRETE	PL	PLATE / PROPERTY LINE
CONT	CONTINUOUS	PLAM	PLASTIC LAMINATE
CT	CERAMIC TILE	PLF	POUNDS PER LINEAR FOOT
CUH	CABINET UNIT HEATER	PP	POWER PANEL
		PSF	POUNDS PER SQUARE FOOT
D	DIAMETER	PSI	POUNDS PER SQUARE INCH
DBL	DOUBLE	PT	PRESSURE-TREATED
DF	DRINKING FOUNTAIN	PVC	POLYVINYL CHLORIDE
DL	DEAD LOAD	PVMT	PAVEMENT
DR	DISPLAY RAIL		
DTL	DETAIL	R	RISER / RADIUS
DW	DISHWASHER	RB	RESILIENT BASE
DWG	DRAWING	RD	ROOF DRAIN
		REINF	REINFORCED
EA	EACH	REQ'D	REQUIRED
EF	EXHAUST FAN / EACH FACE	RT	RIGHT
EJ	EXPANSION JOINT	RO	ROUGH OPENING
EL	ELEVATION	ROW	RIGHT OF WAY
ELEC	ELECTRICAL	RR	RUB-RAIL
EOP	EDGE OF PAVEMENT	RTU	ROOF TOP UNIT (HVAC)
EPDM	ETHYLENE PROPYLENE DIENE MONOMER		
EQ	EQUAL	SACT	SUSPENDED ACOUSTIC TILE CEILING
EW	EACH WAY	SC	SOLID CORE
EWC	ELECTRIC WATER COOLER	SF	SQUARE FOOT / SUPPLY FAN
EXIST	EXISTING	SFRM	SPRAYED FIRE-RESISTIVE MATERIAL
EXP	EXPANSION	SHT	SHEET
EXT	EXTERIOR	SIM	SIMILAR
		SK	SANITARY NAPKIN (DISPENSER)
FB	FLAT BAR	SN	SPECIAL
FBO	FURNISHED BY OTHERS	SP	SPECIAL
FCO	FLOOR CLEA-OUT	SS	STAINLESS STEEL
FD	FLOOR DRAIN	STA	STATION
FE	FIRE EXTINGUISHER	STL	STEEL
FEC	FIRE EXTINGUISHER CABINET	STRUC	STRUCTURAL
FF	FINISH FLOOR / FAR FACE		
FFE	FINISH FLOOR ELEVATION	T	TREAD
FO	FRAMED OPENING	TB	TACKBOARD
FRP	FIBER REINFORCED PLASTIC	T&B	TOP AND BOTTOM
FS	FAR SIDE	TBM	TEMPORARY BENCHMARK
FTG	FOOTING	TCE	TOP CHORD EXTENSION
		TJ	TIE JOIST
GA	GAUGE	TO	TOP OF
GALV	GALVANIZED	TOC	TOP OF CONCRETE
GB	GRAB BAR	TOF	TOP OF FOOTING
GC	GENERAL CONTRACTOR	TOM	TOP OF MASONRY
GDT	GYPSTUM DROP-IN TILE	TOP	TOP OF PIER
GV	GRAVITY VENT	TOS	TOP OF STEEL
GWB	GYPSTUM WALL BOARD	TOW	TOP OF WALL
		TP	TOILET PAPER (DISPENSER) / TEST PIT
H	HORIZONTAL	TS	TUBE STEEL
HC	HORIZONTAL HANDICAPPED / HOLLOW CORE	TYP	TYPICAL
HORIZ	HORIZONTAL		
HM	HOLLOW METAL	UH	UNIT HEATER
HRU	HEAT RECOVERY UNIT	UNO	UNLESS NOTED OTHERWISE
H&V	HEATING AND VENTILATING		
HVAC	HEATING, VENTILATING AND AIR CONDITIONING	V	VENT PIPE / VERTICAL
		VB	VAPOR BARRIER
I	INCLUDED ANGLE	VCT	VINYL COMPOSITION TILE
ID	INSIDE DIAMETER	VERT	VERTICAL
IF	INSIDE FACE	VP	VISION PANEL
IJ	ISOLATION JOINT	VTR	VENT THROUGH THE ROOF
IMP	IMPACT RESISTANT		
INS	INSULATED	W	WITH
INV	INVERT	WC	WATER CLOSET
		WD	WOOD
JS	JOINT SUBSTITUTE	WF	WIDE FLANGE
		WH	WATER HEATER
K	KIPS	W/O	WITH OUT
		WP	WORKING POINT
		WS	WEB STIFFENER
		WWF	WELDED WIRE FABRIC


SYMBOL LEGEND:

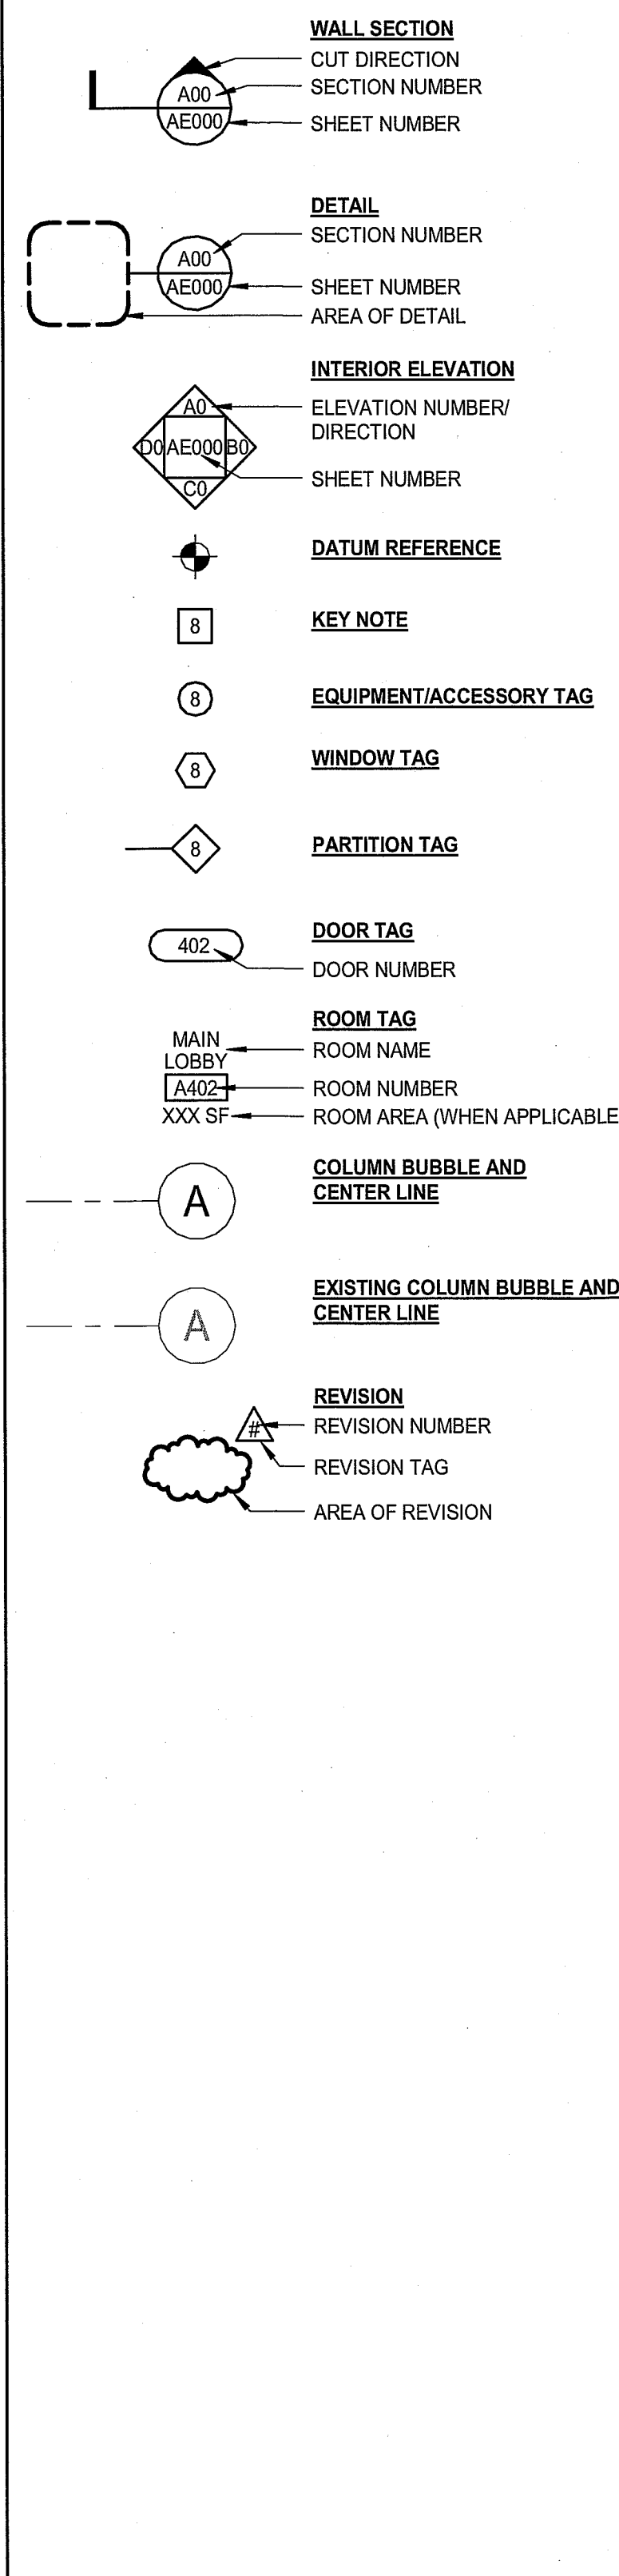


DRAWING LIST:

- GENERAL**
- G1001 COVER SHEET, LEGEND AND ABBREVIATIONS
 - G1002 CODE COMPLIANCE PLAN
 - G1003 LEVEL 4 PHASING PLAN
- ARCHITECTURAL**
- AD101 LEVEL 4 DEMOLITION PLAN
 - A-101 LEVEL 4 FACILITY PLAN PLAN
 - AE111 LEVEL 4 REFLECTED CEILING PLAN
 - AE201 INTERIOR ELEVATIONS
 - AE401 ENLARGED PLANS
 - AE501 DETAILS
 - AE502 DETAILS
 - AE601 DOOR INFORMATION
- INTERIORS**
- ID101 FLOOR FINISH PLAN AND ROOM FINISH SCHEDULE
- FIRE PROTECTION**
- FP001 LEVEL 4 FIRE PROTECTION LEGEND, ABBREVIATIONS AND SPECS
 - FP101 LEVEL 4 FIRE PROTECTION PLAN
- PLUMBING**
- PL001 PLUMBING LEGEND AND ABBREVIATIONS
 - PL002 PLUMBING SPECIFICATIONS AND SCHEDULES
 - PL101 LEVEL 4 PLUMBING PLAN
- MECHANICAL**
- M-001 MECHANICAL LEGEND AND ABBREVIATIONS
 - M-002 MECHANICAL SPECIFICATIONS
 - MD101 LEVEL 4 HVAC DEMOLITION PLAN
 - MH101 LEVEL 4 HVAC DUCTWORK PLAN
 - MP101 LEVEL 4 HVAC PIPING PLAN
 - M-501 MECHANICAL DETAILS
 - M-601 MECHANICAL SCHEDULES AND SEQUENCES
- ELECTRICAL**
- E-001 LEGEND AND GENERAL NOTES
 - E-002 SPECIFICATIONS
 - ED101 LEVEL 4 ELECTRICAL DEMOLITION PLAN
 - EP101 LEVEL 4 POWER PLAN
 - EL101 LEVEL 4 LIGHTING PLAN
 - EY101 LEVEL 4 SYSTEMS PLAN

LOCATION MAP:

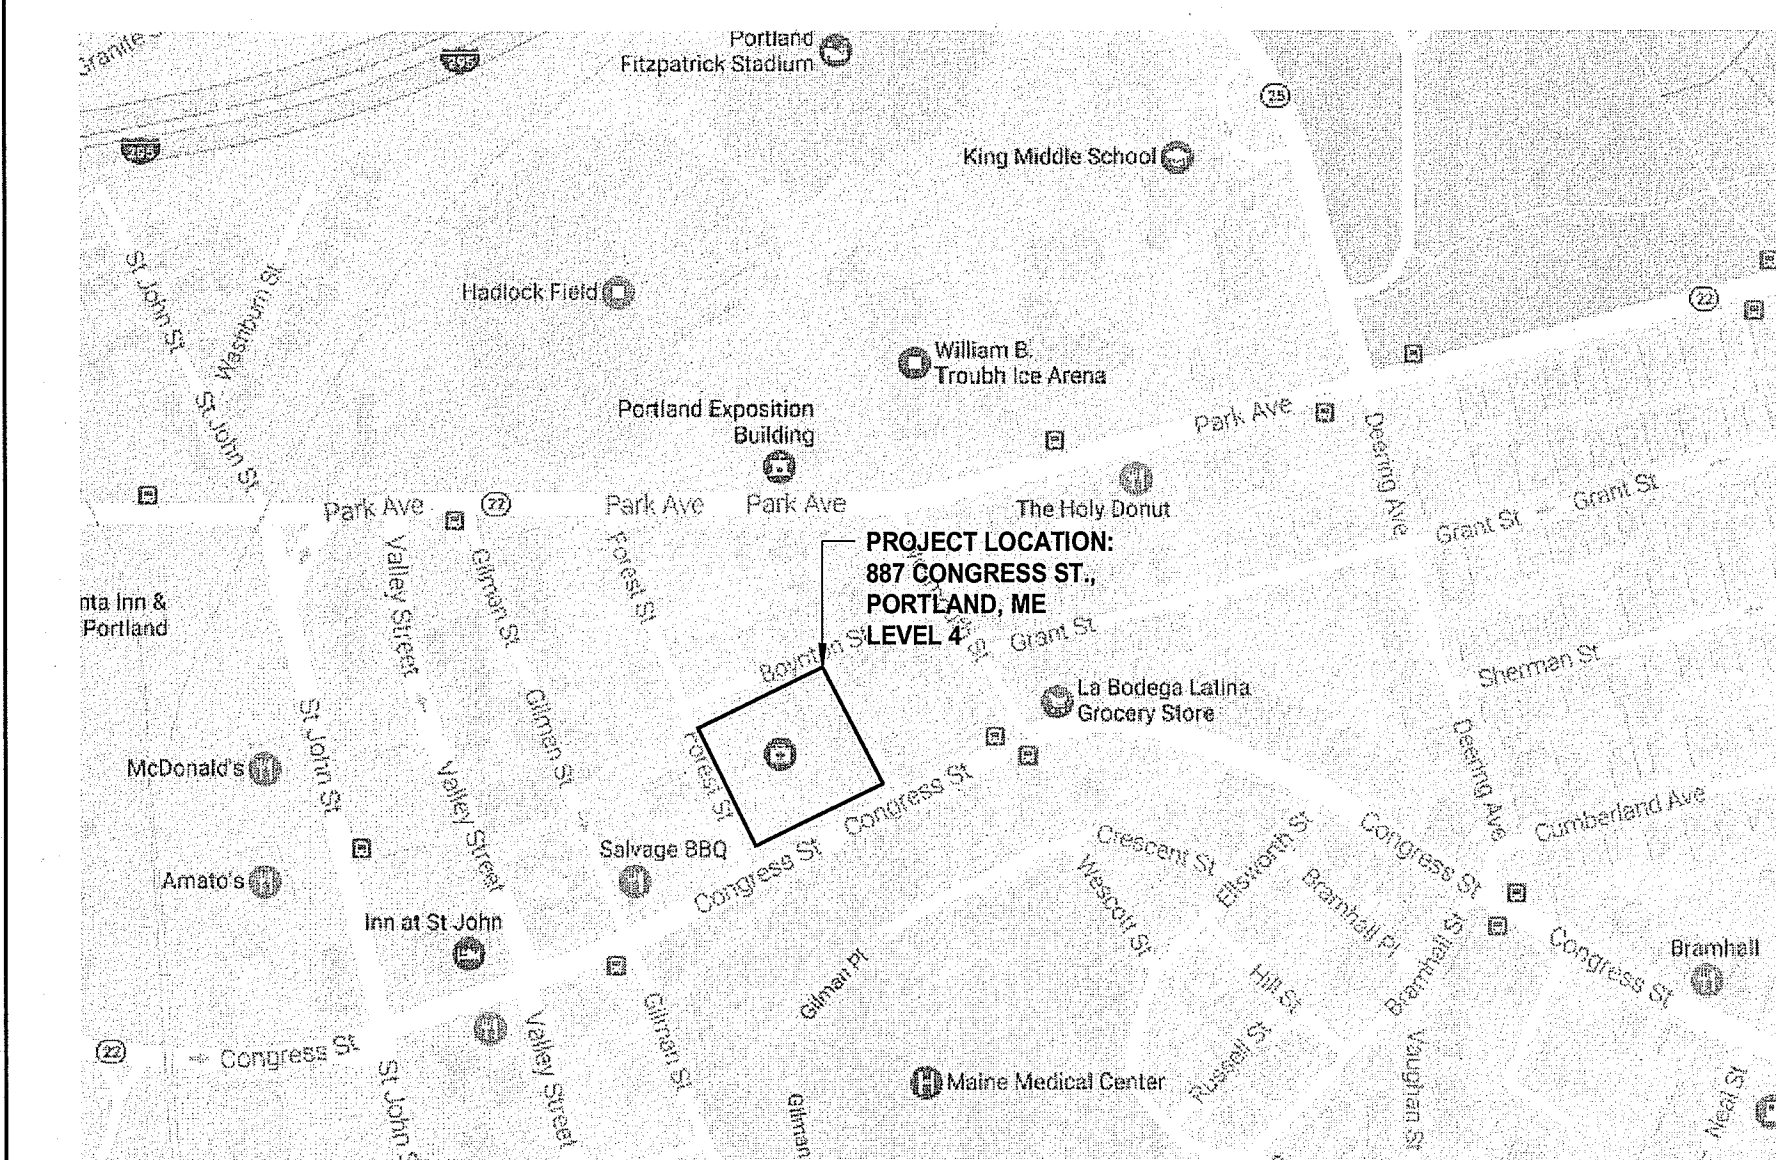

TYP. WALL TYPE

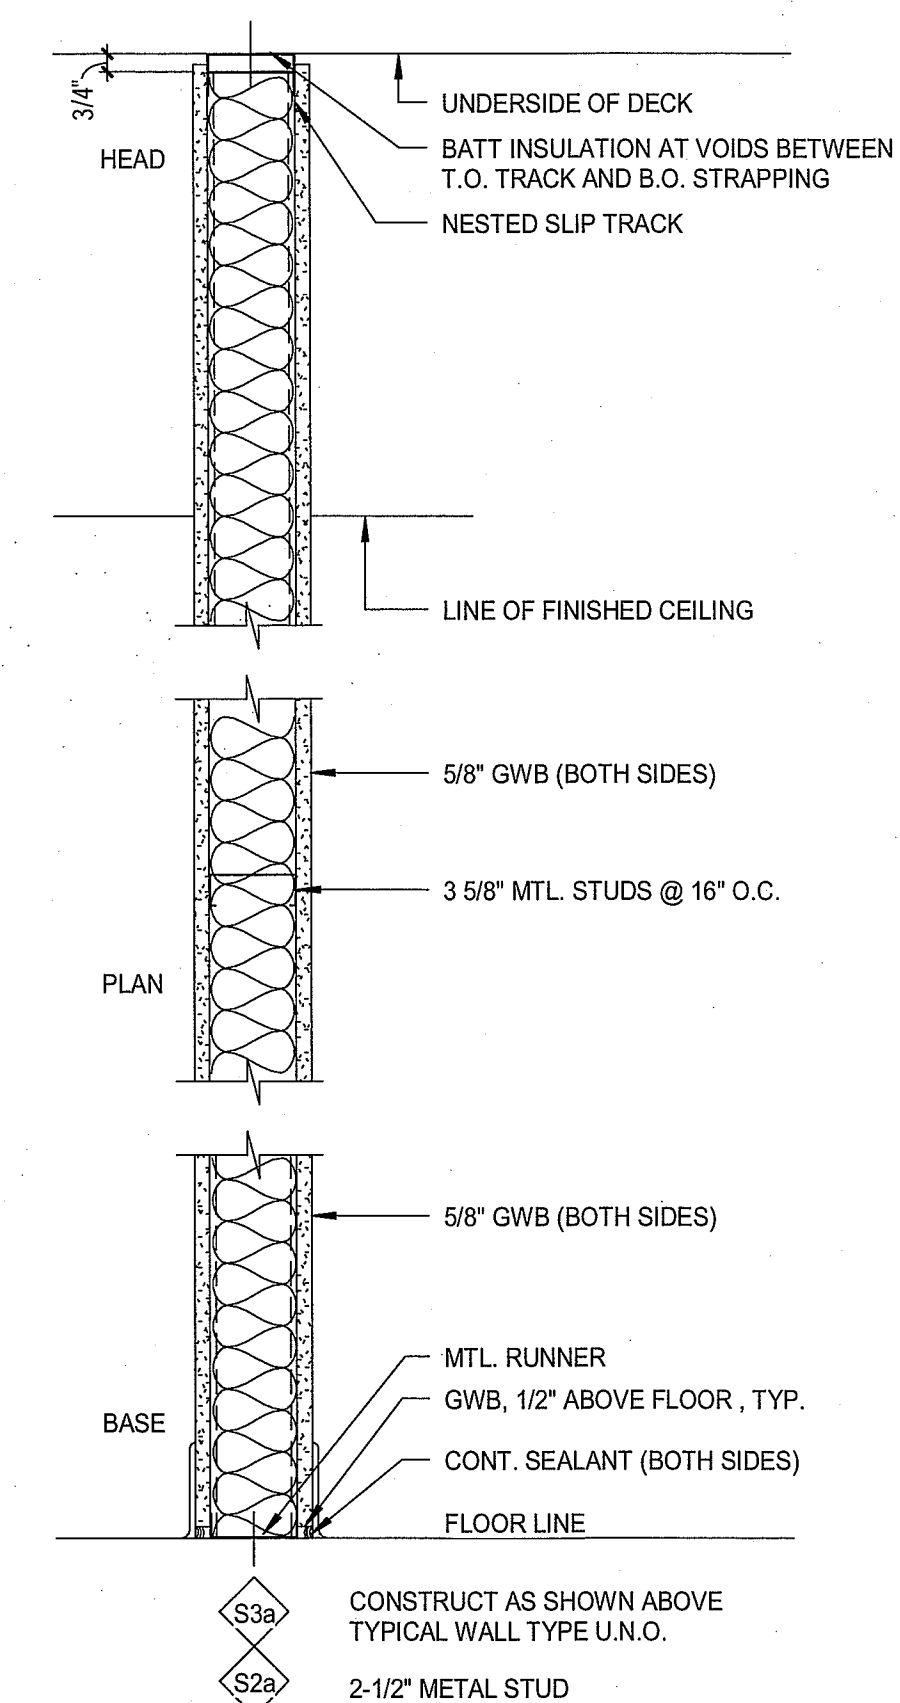

0	ISSUED FOR CONSTRUCTION	4-25-17
REV	DESCRIPTION	DATE
ISSUED FOR CONSTRUCTION 4-25-17		
CURRENT ISSUE STATUS:		
PROJECT NORTH:		
SMRT Architects and Engineers 144 Fore Street/P.O. Box 618 Portland, Maine 04104		
MAINE MEDICAL PARTNERS SURGICAL CARE RENOVATIONS		
PORTLAND, MAINE		
COVER SHEET, LEGEND AND ABBREVIATIONS		
SHEET TITLE:		
SCALE: AS NOTED		
PROJECT MANAGER: DJV	PROJECT NO:	17027
A/E OF RECORD: DJV		
JOB CAPTAIN: CAH		
DRAWN BY: CAH/UCH		
SMRT FILE: G1001-17027	SHEET No.	G1001