

NOTE:
 1. SEE M-001 FOR THE LEGEND AND ABBREVIATIONS.

KEYNOTES	
KEYNOTE NUMBER	KEYNOTE DESCRIPTION
1	1/4" LIQUID - UP TO ROOF 1/2" GAS - UP TO ROOF REFERENCE ARCHITECTURAL FOR FLASHING DETAIL.
2	PROVIDE HUMIDIFIER H-1 ABOVE CEILING ON STRUT RACK. INSTALL DISPERSION TUBES WITHIN DUCTWORK LOCATED ABOVE PROCEDURE 430. SHEET METAL CONTRACTOR SHALL PROVIDE DRAIN PAN PER DETAIL F1 / M-502. PLUMBING CONTRACTOR SHALL PICK UP DRAIN FROM HUMIDIFIER AND DUCT DRAIN PAN. SEE PL101 FOR MORE INFORMATION.
3	NEW TEMPERATURE SENSOR ON WALL. TEMPERATURE SENSOR SHALL COMMUNICATE TO AC-1 PER THE SEQUENCE OF OPERATIONS THROUGH THE EXISTING CONTROLS FRONT END BMS.

REV	DESCRIPTION	DATE
0	ISSUED FOR CONSTRUCTION	4-25-17

ISSUED FOR CONSTRUCTION
 4-25-17

CURRENT ISSUE STATUS:


PROJECT NORTH:
 SMRT Architects and Engineers
 144 Fore Street
 Portland, Maine 04104
 1.877.700.7678
 www.smrtinc.com

ARCHITECTURE | ENGINEERING | PLANNING | INTERIORS | ENERGY **SMRT**

**MAINE MEDICAL PARTNERS
 SURGICAL CARE RENOVATIONS**

PORTLAND, MAINE

**LEVEL 4
 HVAC PIPING PLAN**

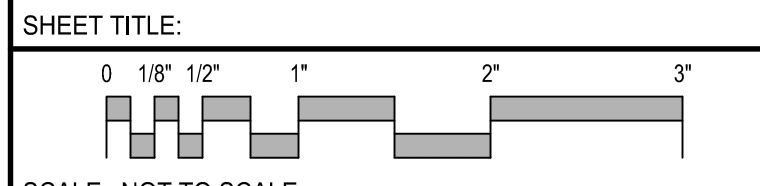

SCALE: NOT TO SCALE

PROJECT MANAGER: DJV PROJECT NO: 17027

A/E OF RECORD: RMW

JOB CAPTAIN: CAH

DRAWN BY: CWF

SMRT FILE: MP101-17027 SHEET No. **MP101**

LEVEL 4 - HVAC PIPING PLAN (A1)
 1/8" = 1' - 0"