


THE MAINE SURGICAL GROUP CONGRESS ST. MEDICAL BUILDING 4TH FLOOR RENOVATION PORTLAND, MAINE

DRAWING LIST

ARCHITECTURAL
A-100 COVER PAGE & LIFE SAFETY PLAN
A-101 FOURTH FLOOR DEMOLITION & FLOOR PLAN

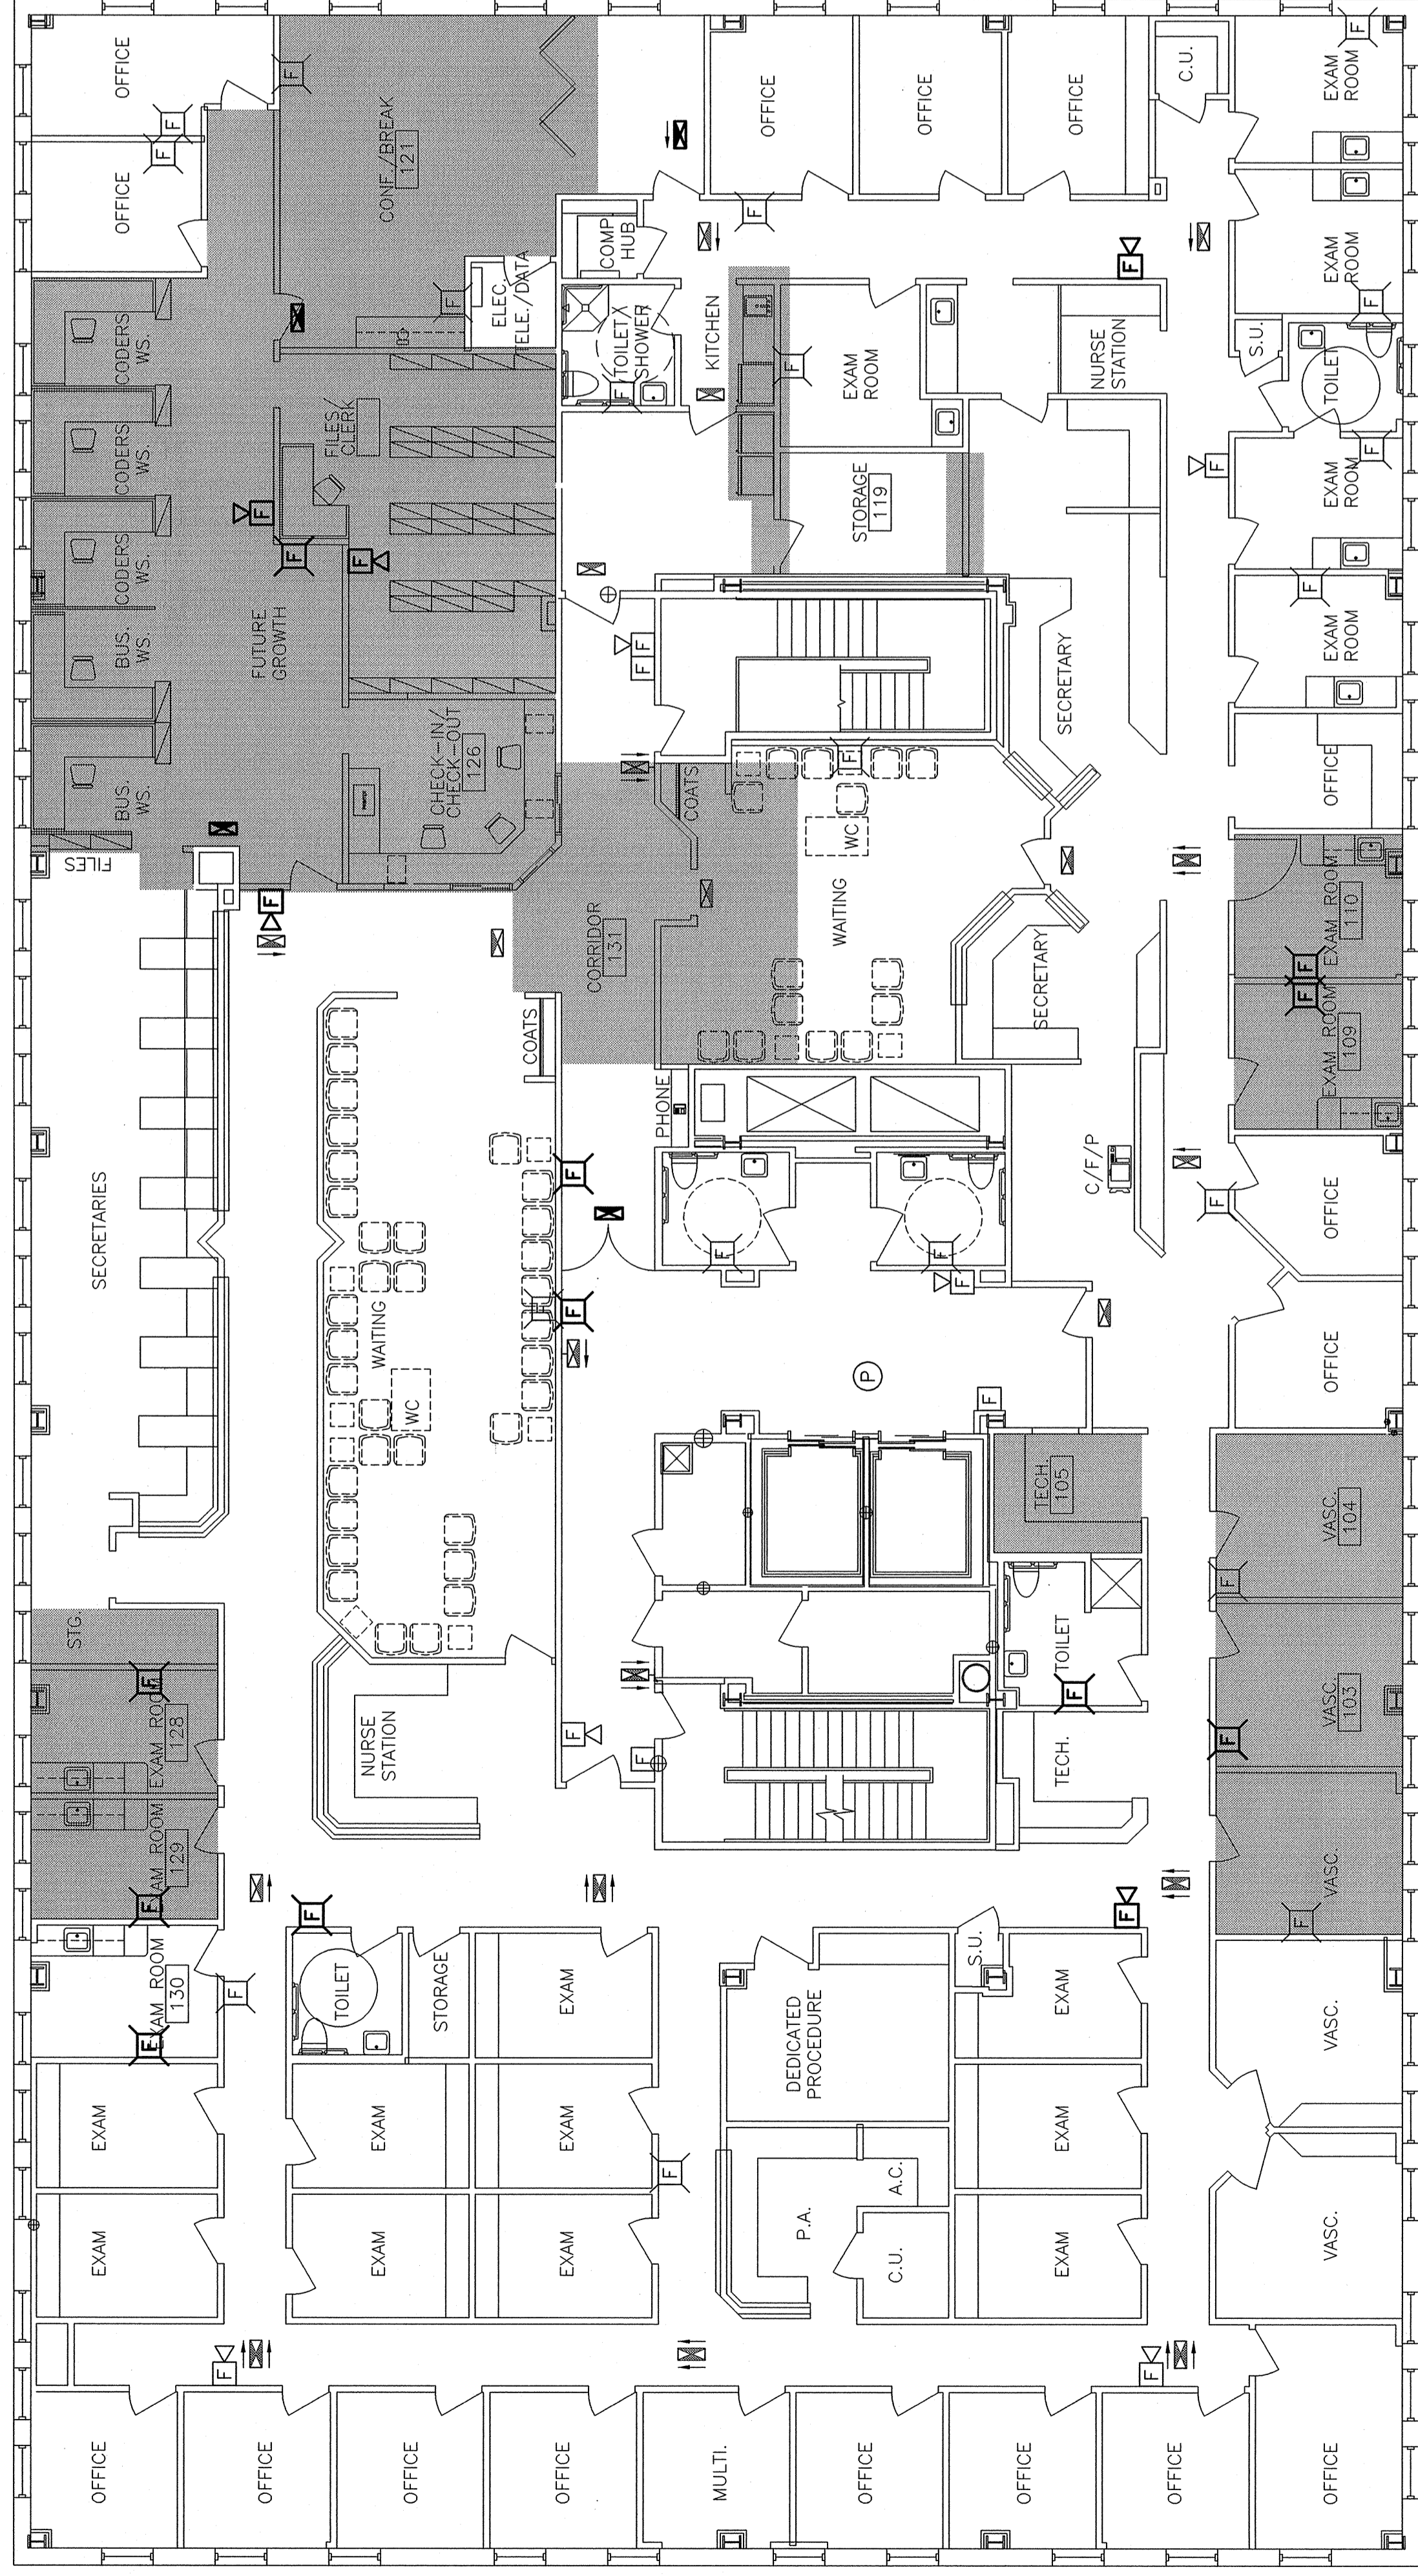

NOTE:

- BUILDING IS FULLY SPRINKLED.
- EGRESS LIGHTING SHALL BE PROVIDED IN ALL CONFERENCE ROOMS, FILE ROOMS, CORRIDORS AND PASSAGeways LEADING TO EXITS. A MINIMUM AVERAGE OF 1 FOOT-CANDLE IS TO BE PROVIDED. THE SOURCE OF ILLUMINATION NEEDS TO BE PROVIDED FOR A MINIMUM 90 MINUTES AND CAN BE EITHER OF THE FOLLOWING:
 - GENERATOR BACKED-UP LIGHT FIXTURES
 - BATTERY BALLAST LIGHT FIXTURES
 - INDIVIDUAL BATTERY UNIT WITH UNIT MONITOR OR REMOTE LAMPS.

LEGEND:

- 1 HOUR FIRE PROTECTION
- AREA OF WORK

SYMBOL LEGEND

- EXIT SIGN, BEILING MOUNTED, ARROW INDICATES EGRESS DIRECTION, SHADING INDICATES SIGN FACE. GREEN LED WITH BATTERY BACK-UP.
- EXIT SIGN, WALL MOUNTED, SHADING INDICATES SIGN FACE. GREEN LED WITH BATTERY BACK-UP.
- DUAL HEAD EMERGENCY LIGHT BATTERY PACK TD - TIME DELAY RESET
- FIRE ALARM AUDIBLE/VISIBLE NOTIFICATION APPLIANCE (GENERAL EVACUATION)
- FIRE ALARM VISIBLE ONLY NOTIFICATION APPLIANCE
- FIRE ALARM MANUAL PULL STATION.

GENERAL NOTES:


- FIELD VERIFY ALL DIMENSIONS AND LAYOUT PRIOR TO PROCEEDING WITH WORK. NOTIFY ARCHITECT IN WRITING OF ANY DISCREPANCIES OR INCONSISTENCIES. FAILURE TO REPORT ANY SUCH DISCREPANCIES OR INCONSISTENCIES TO THE ARCHITECT WILL NOT BE GROUNDS FOR ADDITIONAL COST OR CHANGE ORDERS.
- "PROVIDE" MEANS "FURNISH AND INSTALL".
- THE CONTRACTOR SHALL BE RESPONSIBLE FOR PROVIDING ALL MATERIALS (UNLESS NOTED OTHERWISE), AND WORKMANSHIP IN ACCORDANCE WITH THE REQUIREMENTS OF THE CITY AND LOCAL BUILDING CODES AND THEIR REQUIREMENTS.
- THE CONTRACTOR AND ALL TRADES SHALL NOTE REQUIREMENTS OF GENERAL NOTES ON ALL SHEETS.

SYMBOL LEGEND

- BUILDING SECTION
- WALL SECTION
- DETAIL
- EXTERIOR ELEVATION
- INTERIOR ELEVATION
- LEVEL LINE
- CIRCLE NOTE
- WINDOW TAG
- PARTITION TAG
- DOOR TAG
- ROOM NAME ROOM NUMBER
- MAIN LOBBY (400)
- COLUMN BUBBLE AND CENTER LINE
- BACKER ROD AND SEALANT

ISSUED FOR CONSTRUCTION
1-4-06

CURRENT ISSUE STATUS:

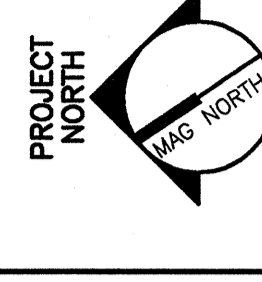

ARCHITECTURE ENGINEERING PLANNING
144 Fore Street P.O. Box 618
Portland, Maine 04104
Tel. (207) 772-9446
Fax. (207) 772-1070

887 CONGRESS ST.
THE MAINE SURGICAL GROUP
4TH FLOOR RENOVATION
PORTLAND, ME

COVER PAGE &
LIFE SAFETY PLAN

SHEET TITLE: 1/8"=1'-0" DATE: 1-4-06
PROJECT MANAGER: CDP GRAPHIC SCALE: 1"

JOB CAP/DRAWN: ART

DATE OF RECORD: CDP

SMART CAD FILE: AE100-06110-0

PROJECT No. 06110-01

SHEET No. AE100

1/8"=1'-0"

A1 LIFE SAFETY PLAN

1/8"=1'-0"