



**EQUIPMENT LIST:**

- CD-1 O.H. DOOR - 1ST FLOOR
- CP-1 DOMESTIC CIRC. PUMP
- CON-1 ELEC. CONVECTION HEATER
- CON-2 ELEC. CONVECTION HEATER
- EF-3 EXHAUST FAN - 3
- EH-1 ELEC. UHIT HEATER
- HP-1 HEAT PUMP
- SPP-1 SUMP PUMP PANEL
- WHTR-1 ELEC WATER HEATER

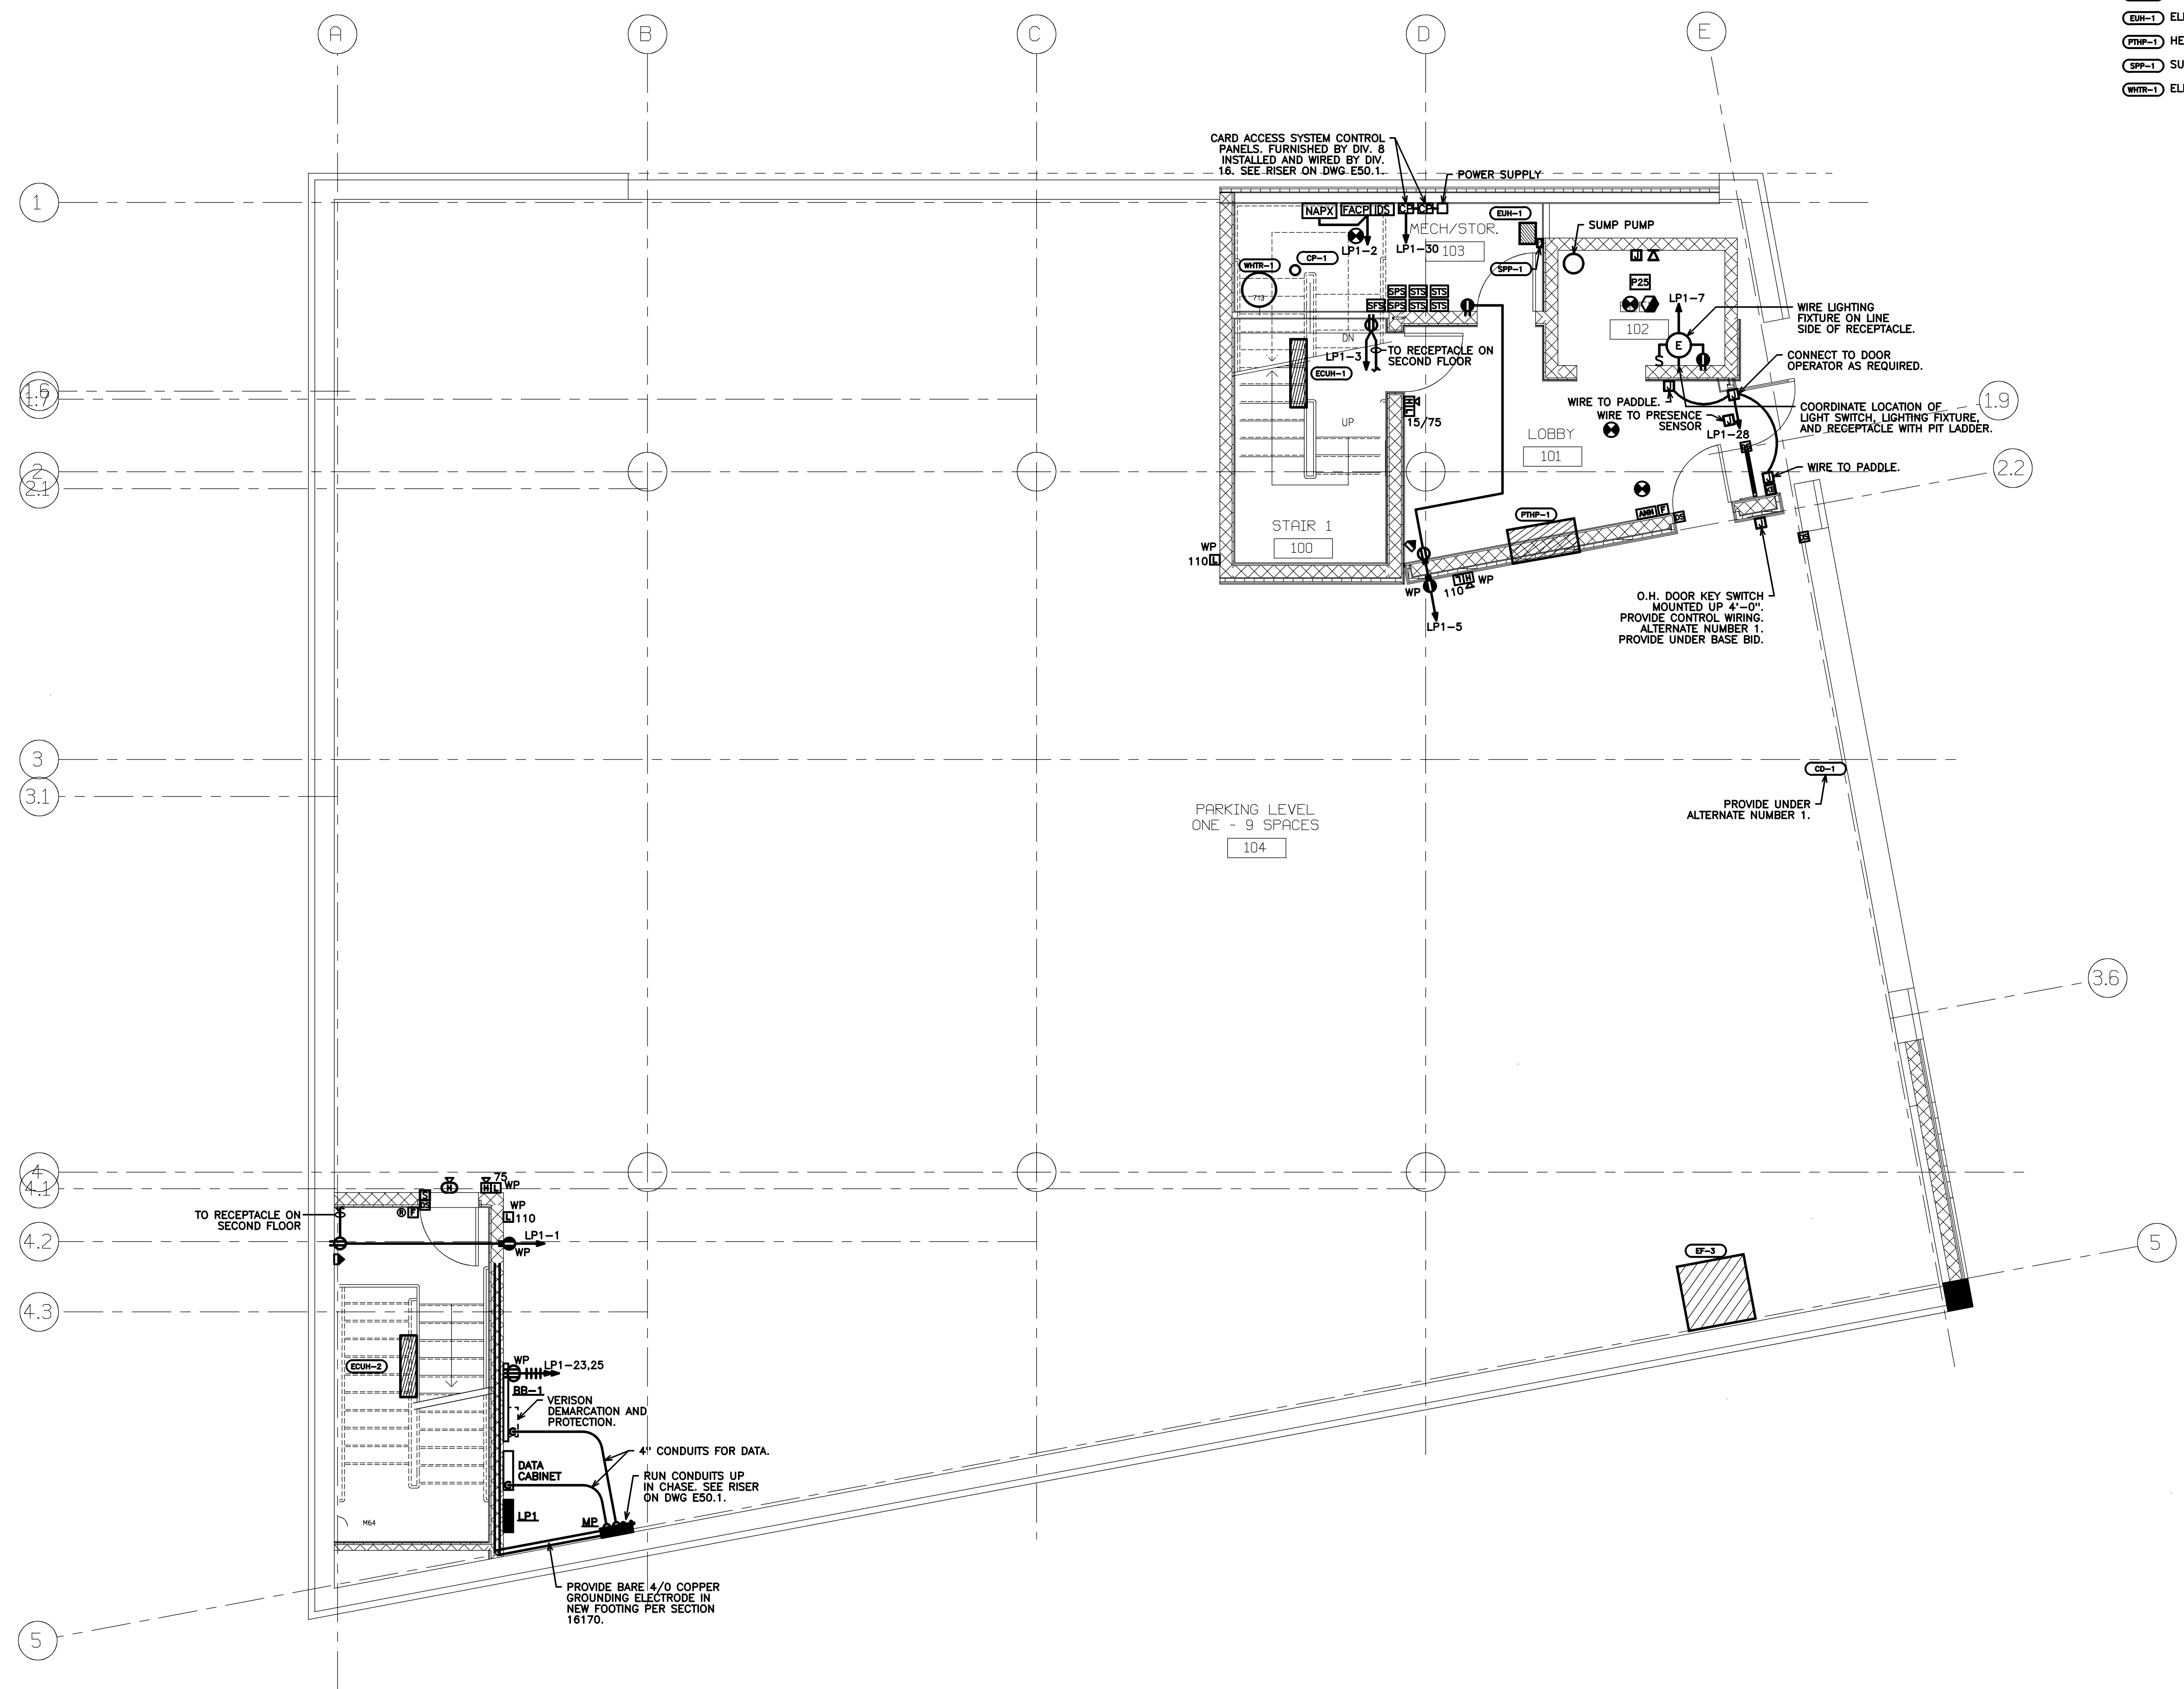

Project Title  
**MAINE HEART SURGICAL ASSOC. NEW OFFICE BLDG.**  
 PORTLAND, ME

HA Project No. **04180**

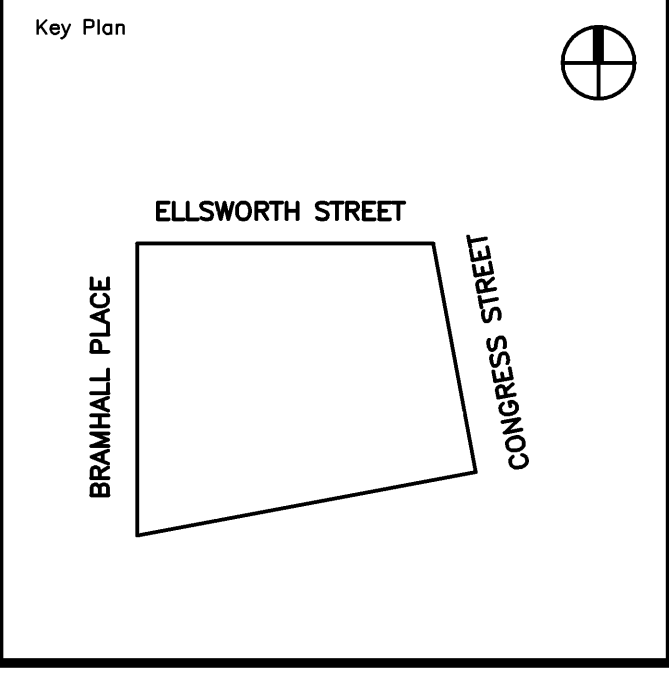

**KEY NOTES:**  
 P25...  
 IN ELEVATOR PIT LOCATE FIXTURE RECEPTACLE, AND SWITCH AS REQUIRED. LOCATE JUNCTION BOX AND TELEPHONE OUTLET HALF WAY UP ELEVATOR SHUTT. FROM EACH RUN 3/4\"/>

Mark	Date	Description
-	04-28-05	ISSUED FOR BID
-	04-11-05	100% REVIEW
-	01-10-05	DD REVIEW

Drawing Status

Drawing Title  
**FIRST FLOOR PLAN - POWER**

PA / PE: **PRM** Drawn By: **JMB/KRM**

Drawing Number

**E20.1**

**FIRST FLOOR PLAN - POWER**  
 1/4" = 1'-0" REF: NA

**E1**