



EQUIPMENT LIST:

- CD-2 O.H. DOOR - 2ND FLOOR
- CU-2 SPLIT AC UNIT (OUTDOOR UNIT)
- DF-1 DUCT FURNACE
- DF-2 EXHAUST FAN - 2
- EM-1 ELEC. UNIT HEATER
- FP-2 SPLIT AC UNIT (INDOOR UNIT)
- HP-2 HEAT PUMP
- HP-3 HEAT PUMP

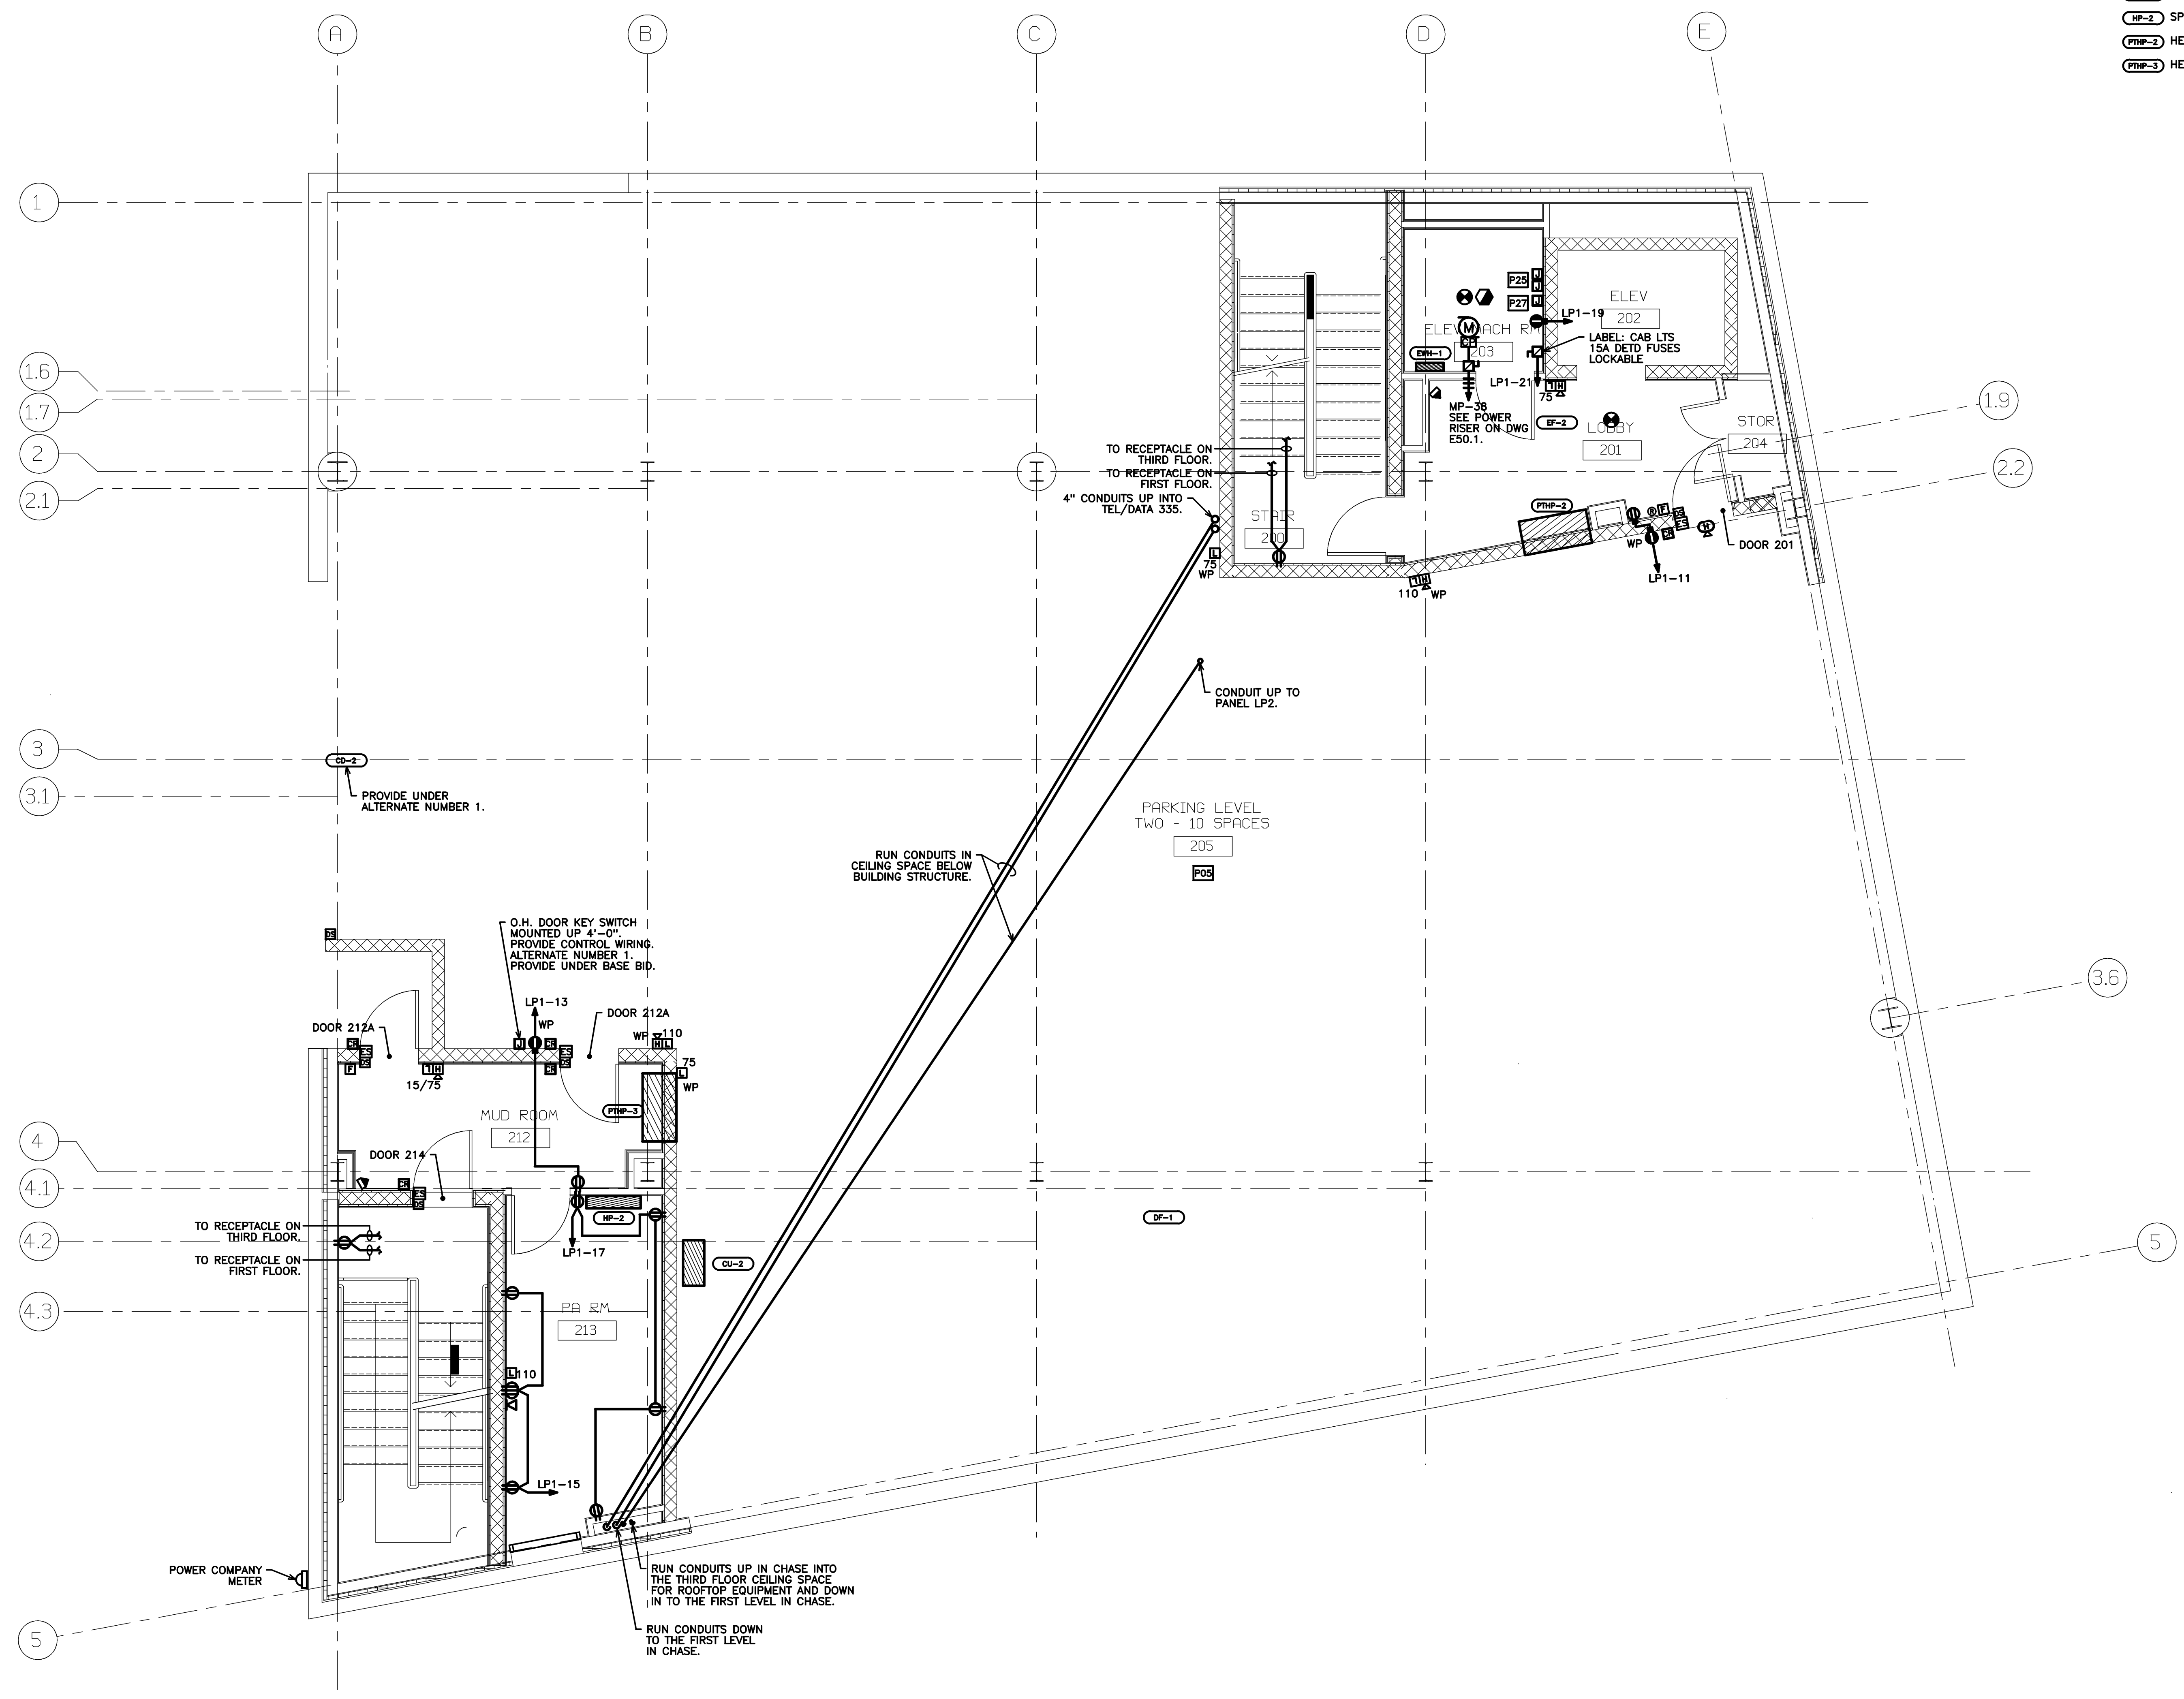

Project Title
MAINE HEART SURGICAL ASSOC. NEW OFFICE BLDG.
 PORTLAND, ME

HA Project No. **04180**

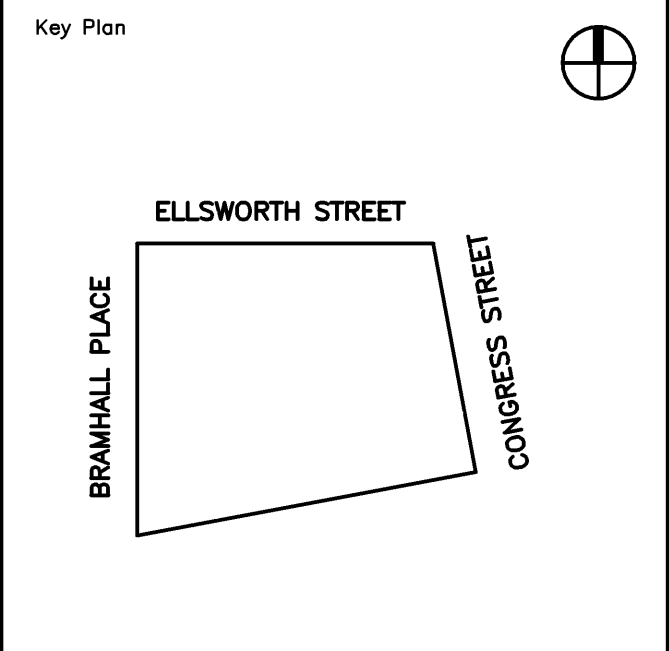

KEY NOTES:

- POS.: CEILING SPACE ABOVE THE SECOND FLOOR PARKING LEVEL IS USED AS AN AIR FLENUM.
- P25: IN ELEVATOR PIT LOCATE FIXTURE, RECEPTACLE, AND SWITCH AS REQUIRED. LOCATE JUNCTION BOX AND TELEPHONE OUTLET HALF WAY UP ELEVATOR SHAFT. FROM EACH RUN 3/4" C BACK TO ELEVATOR MACHINE ROOM.
- P27: FROM JUNCTION BOX RUN 3/4" C CONDUIT TO FIRE ALARM CONTROL PANEL. FOR ELEVATOR CAPTURE FEATURE. LABEL JUNCTION BOX * ELEVATOR CAPTURE * AT BOTH ENDS.

Mark	Date	Description
-	04-28-05	ISSUED FOR BID
-	04-11-05	100% REVIEW
-	01-10-05	DD REVIEW

Issue Dates

Drawing Status

Drawing Title
SECOND FLOOR PLAN - POWER

PA / PE: **PRM** Drawn By: **JMB/KRM**

Drawing Number
E20.2