



EQUIPMENT LIST:

- AC-1 SPLIT AC UNIT (INDOOR UNIT)
- CP-1 DOMESTIC CIRC. PUMP
- CP-2 MECHANICAL CONTROL PANEL
- CP-3 MECHANICAL CONTROL PANEL
- CU-1 SPLIT AC UNIT (OUTDOOR UNIT)
- EF-1 EXHAUST FAN - 1
- RTU-1 ROOF TOP UNIT - 1
- RTU-2 ROOF TOP UNIT - 2
- RTU-3 ROOF TOP UNIT - 3
- VW-17 VAV

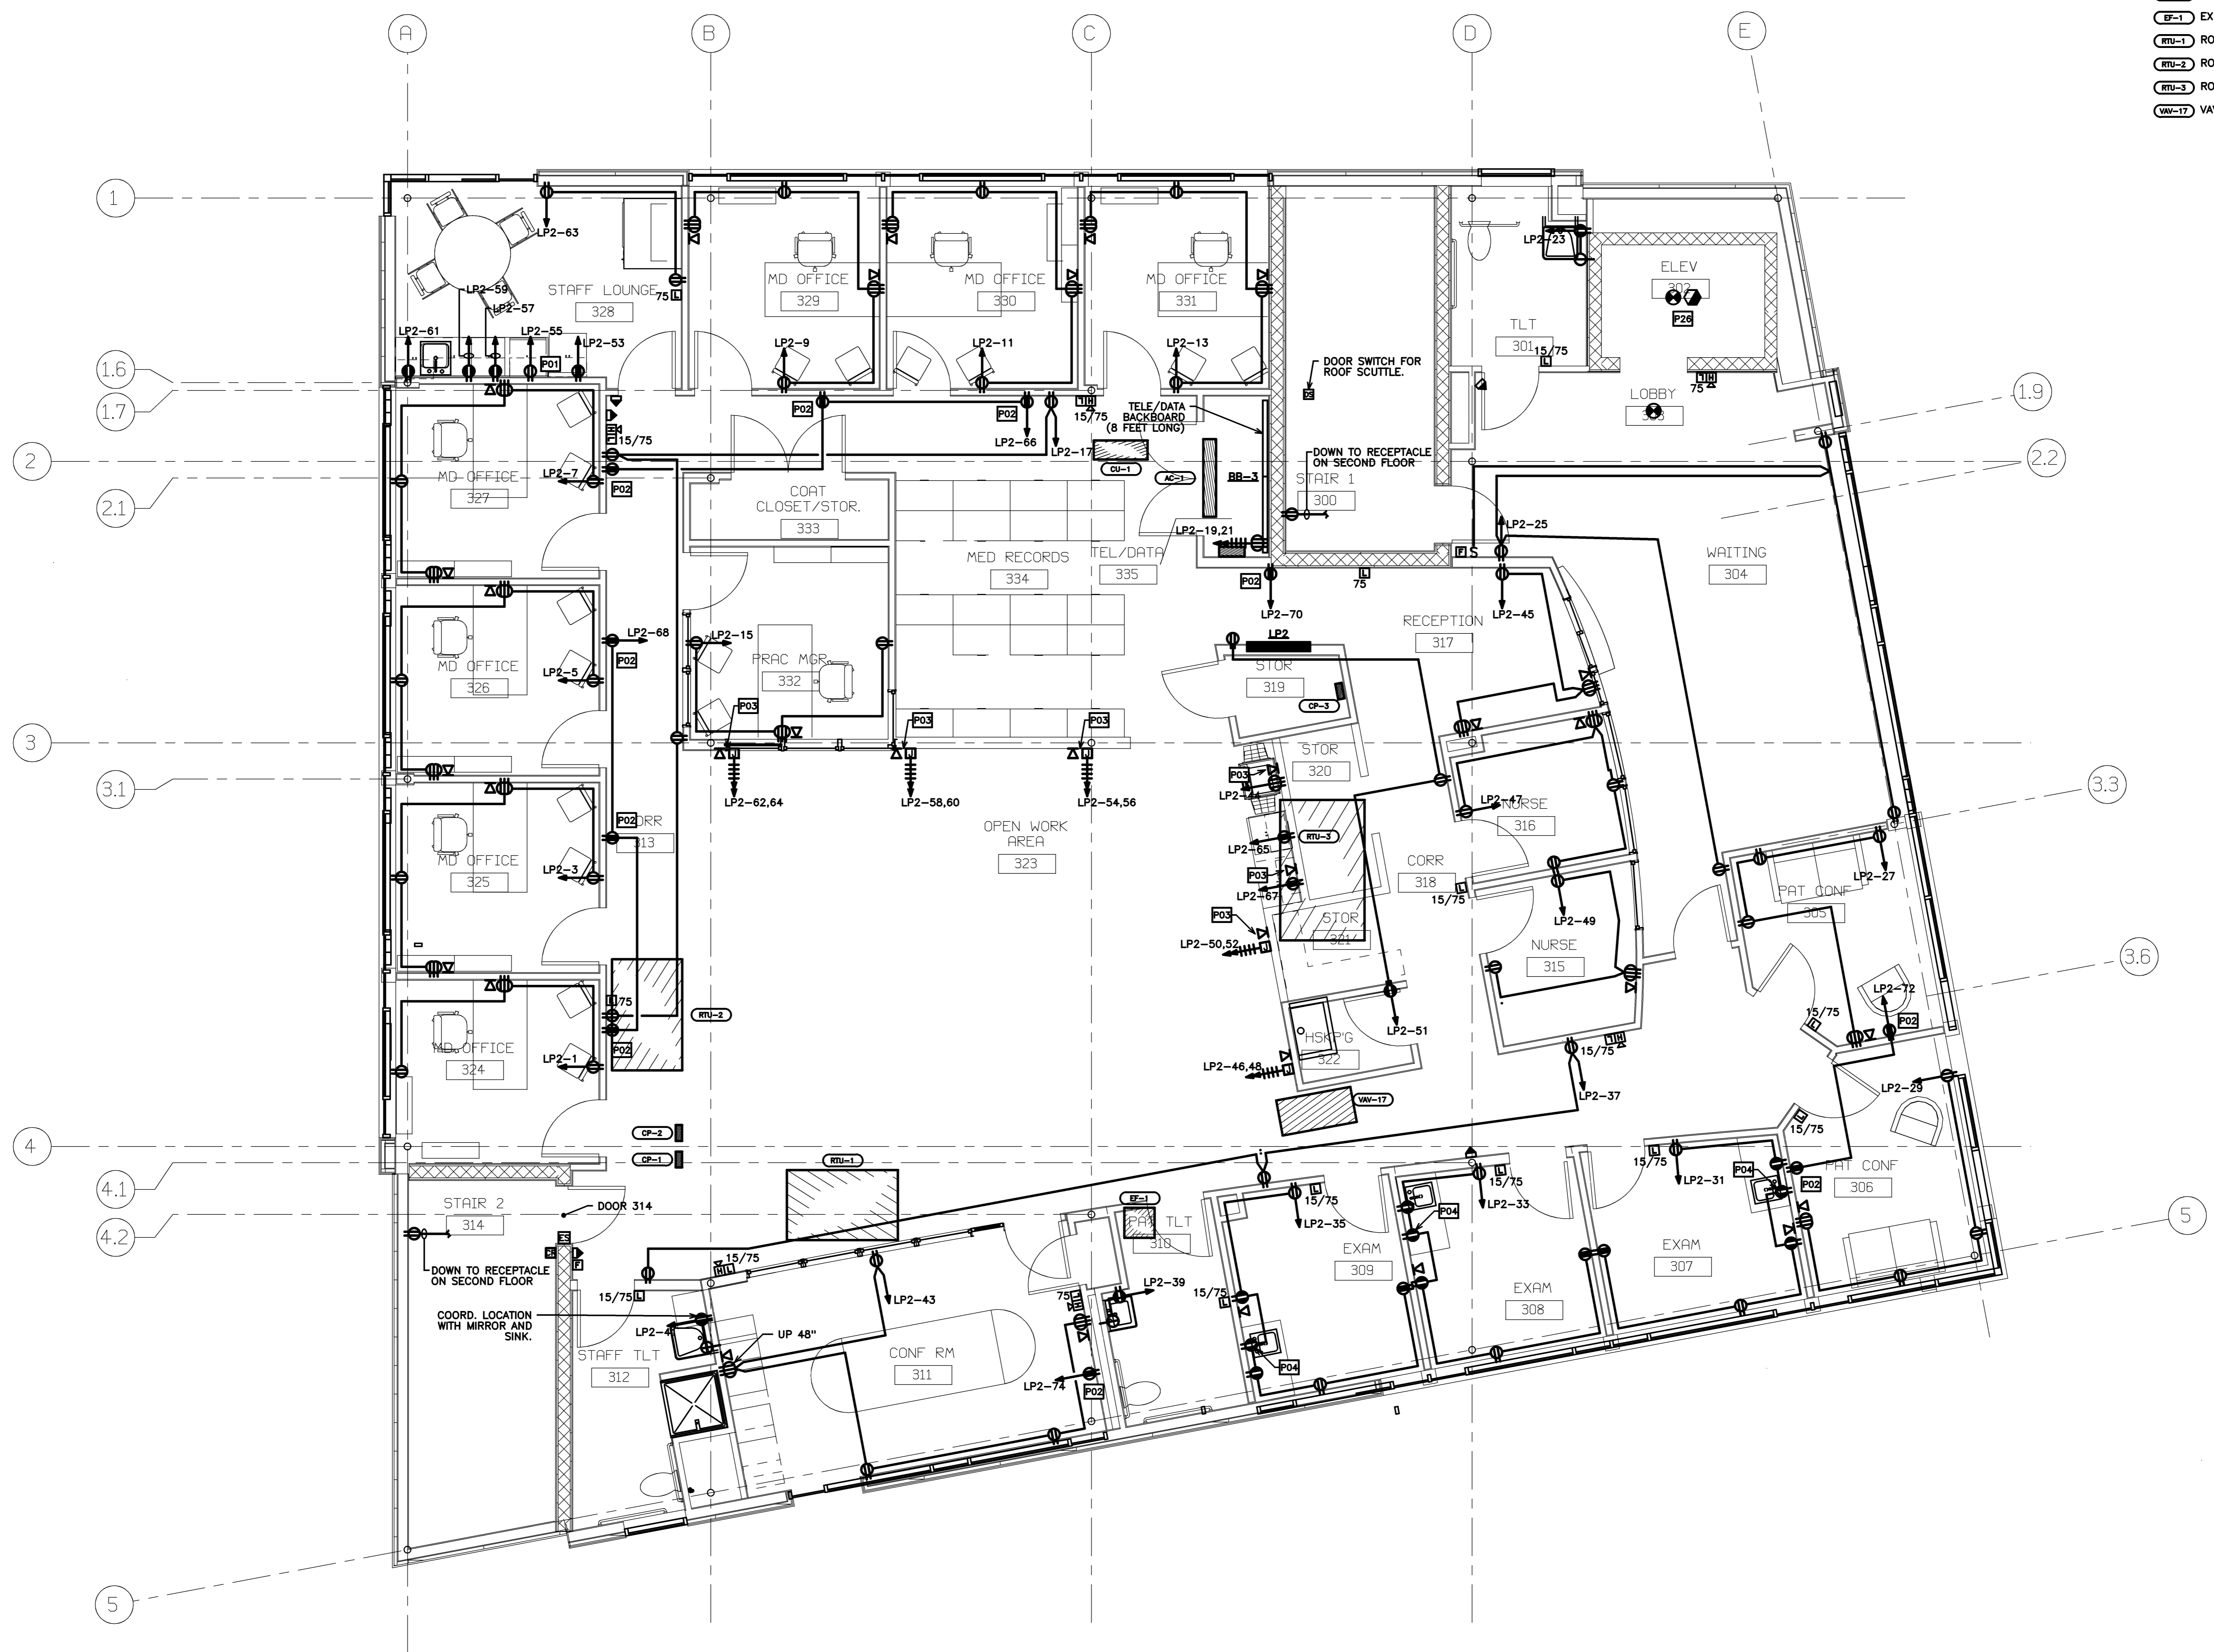

Project Title
MAINE HEART SURGICAL ASSOC. NEW OFFICE BLDG.
 PORTLAND, ME

HA Project No. **04180**

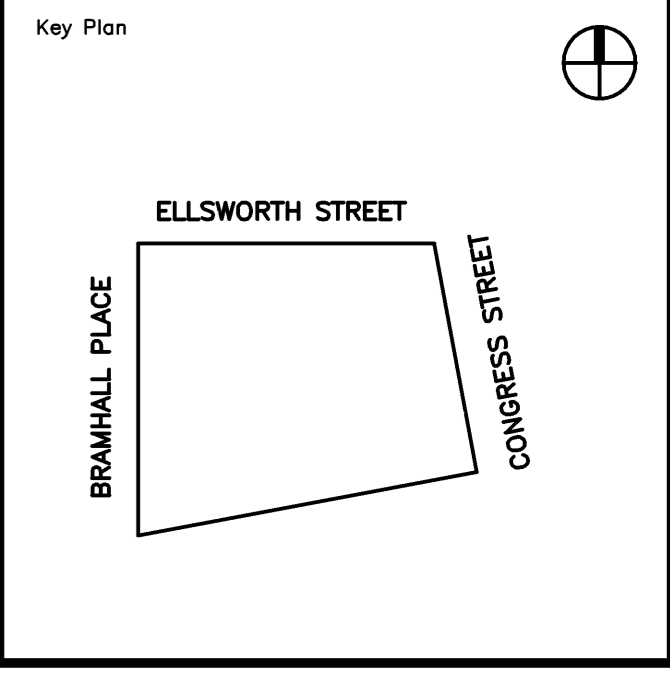

KEY NOTES:

- P01... RECEPTACLE TO BE MOUNTED UNDER COUNTER FOR DISHWASHER. COORDINATE EXACT LOCATION WITH VENDOR. PROVIDE CORD AND PLUG.
- P02... RECEPTACLE MOUNTED UP 4'-6" AFF. COORDINATE LOCATION WITH OWNERS VIEW BOXES.
- P03... RUN CONDUITS BELOW IN SECOND FLOOR CEILING SPACE TO TEL/DATA 335 AND RUN POWER CONDUITS BELOW IN SECOND FLOOR CEILING SPACE (PLENUM SPACE) TO PANEL LP2.
- P04... RECEPTACLE FOR ELECTRONIC POWERED SENSOR FAUCET. MOUNT UNDER COUNTER. COORDINATE EXACT LOCATION WITH PLUMBING AND CABINET INSTALLER.
- P26... PROVIDE HEAT AND SMOKE DETECTORS AT TOP OF ELEV SHAFT ONLY IF THERE IS A SPRINKLER HEAD.

Mark	Date	Description
-	04-28-05	ISSUED FOR BID
-	04-11-05	100% REVIEW
-	01-10-05	DD REVIEW

Drawing Status

Drawing Title
THIRD FLOOR PLAN - POWER

PA / PE: **FRM** Drawn By: **JMB/KRM**
 Drawing Number

THIRD FLOOR PLAN - POWER
 1/4" = 1'-0" REF: NA **E1**

E20.3