



EQUIPMENT LIST:

- CD-1 O.H. DOOR - 1ST FLOOR
- CP-1 DOMESTIC CIRC. PUMP
- ECOH-1 ELEC. CONVECTION HEATER
- ECOH-2 ELEC. CONVECTION HEATER
- EF-3 EXHAUST FAN - 3
- EH-1 ELEC. UHIT HEATER
- HP-1 HEAT PUMP
- SP-1 SUMP PUMP PANEL
- WHTR-1 ELEC WATER HEATER

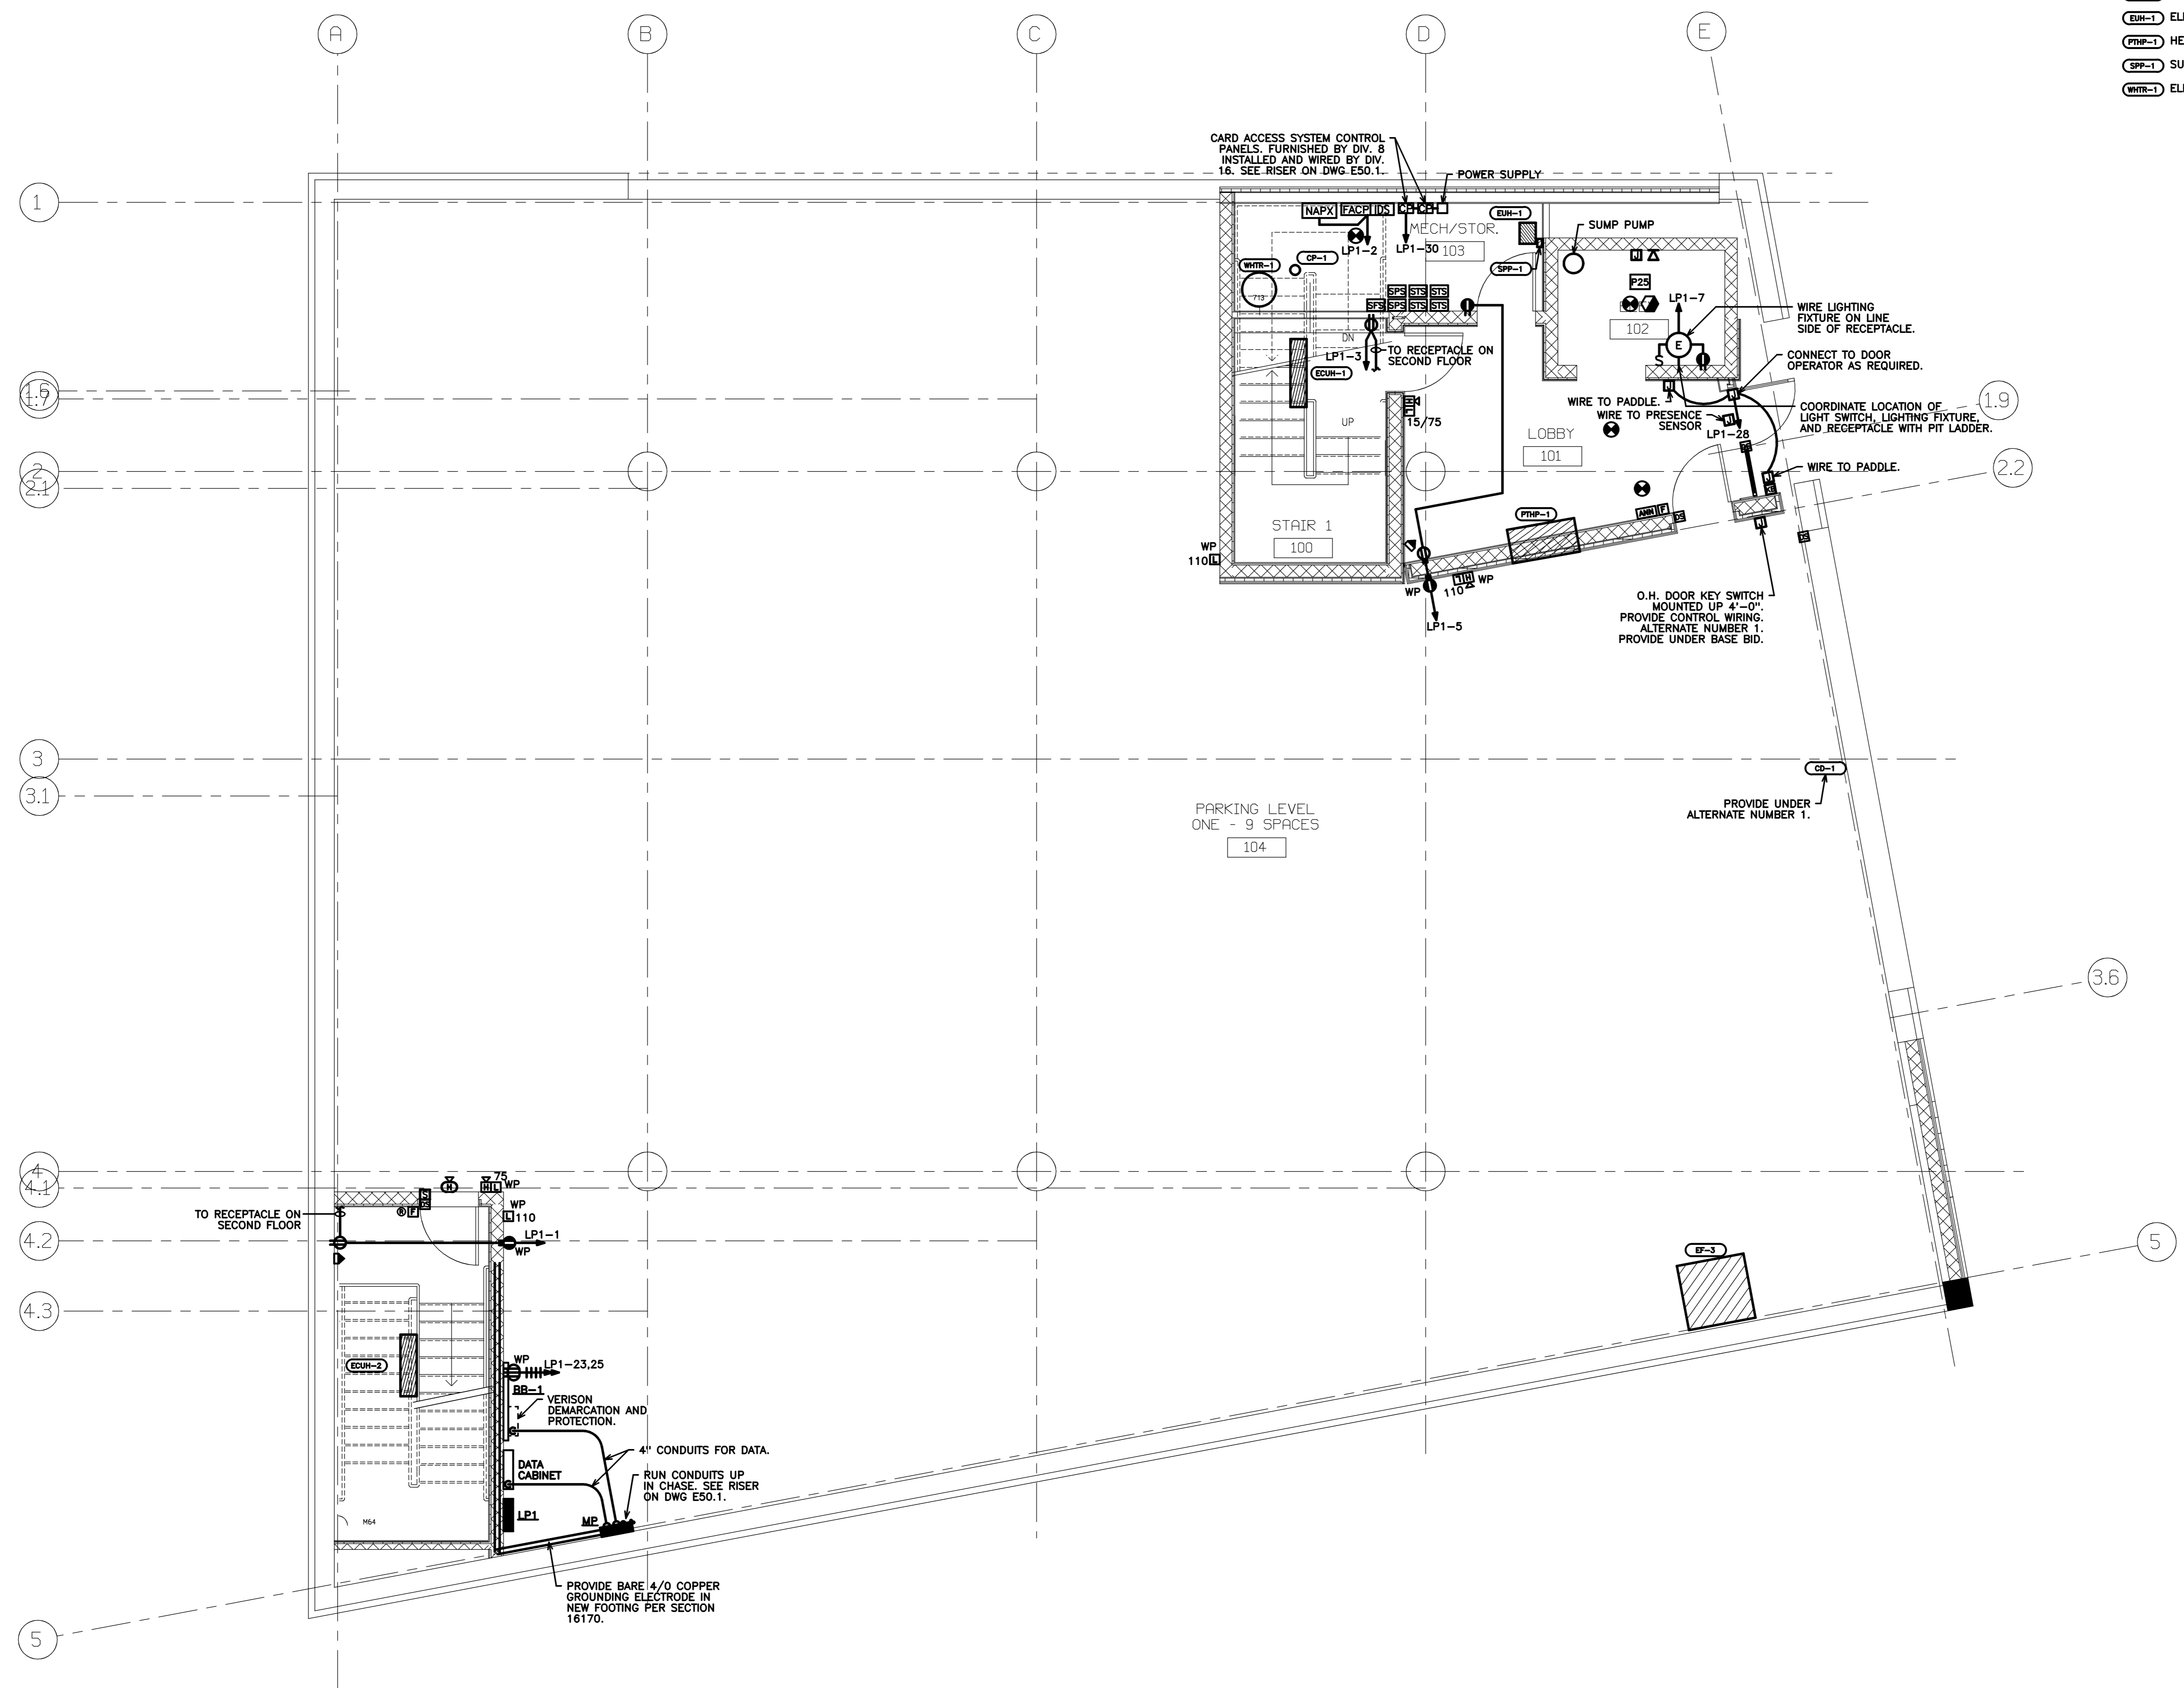

Project Title
MAINE HEART SURGICAL ASSOC. NEW OFFICE BLDG.
 PORTLAND, ME

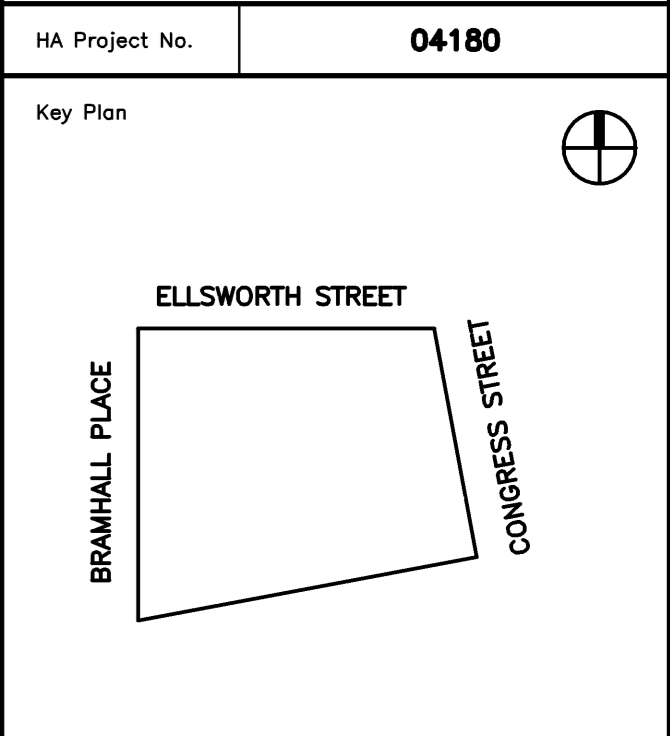

KEY NOTES:

P25... IN ELEVATOR PIT LOCATE FIXTURE RECEPTACLE, AND SWITCH AS REQUIRED. LOCATE JUNCTION BOX AND TELEPHONE OUTLET HALF WAY UP ELEVATOR SHAFT. FROM EACH RUN 3/4" BACK TO ELEVATOR MACHINE ROOM.

Mark	Date	Description
-	04-28-05	ISSUED FOR BID
-	04-11-05	100% REVIEW
-	01-10-05	DD REVIEW

Drawing Status

Drawing Title
FIRST FLOOR PLAN - POWER

PA / PE: **PRM** Drawn By: **JMB/KRM**

Drawing Number
E20.1