
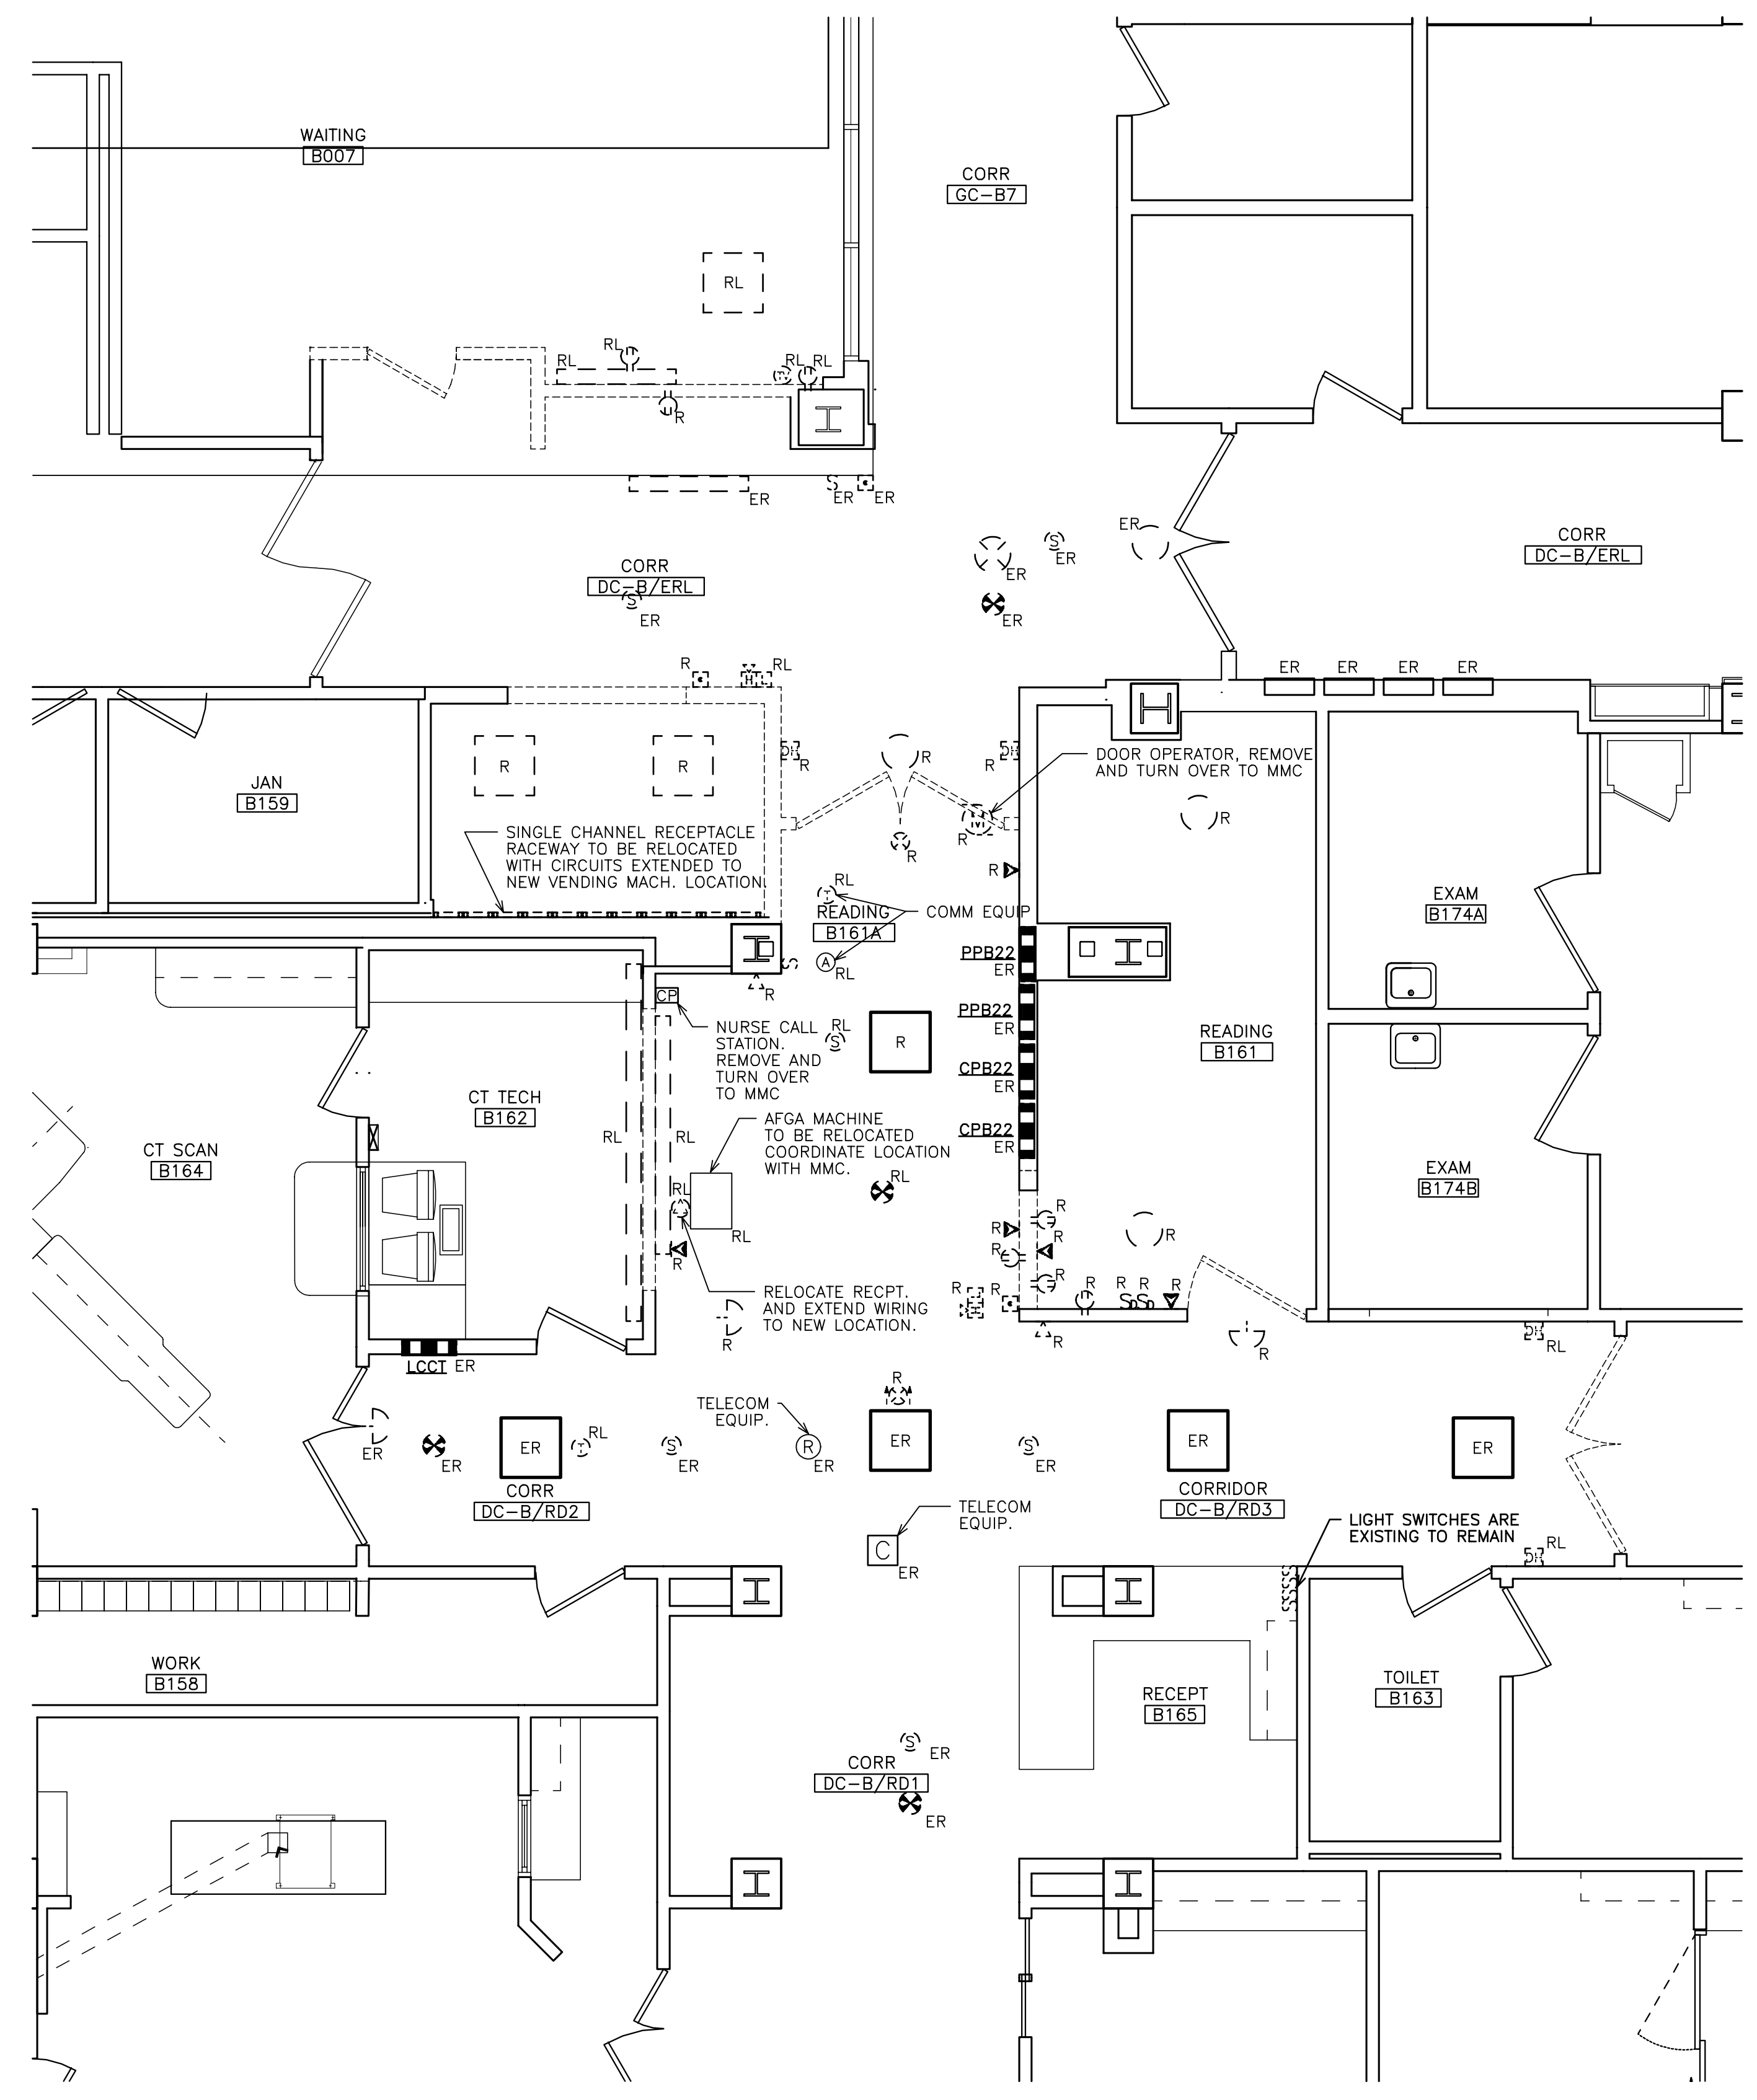


Project Title
**MAINE MEDICAL CENTER
 ED READING
 RENOVATION**
 PORTLAND, MAINE

HA Project No. **00112**

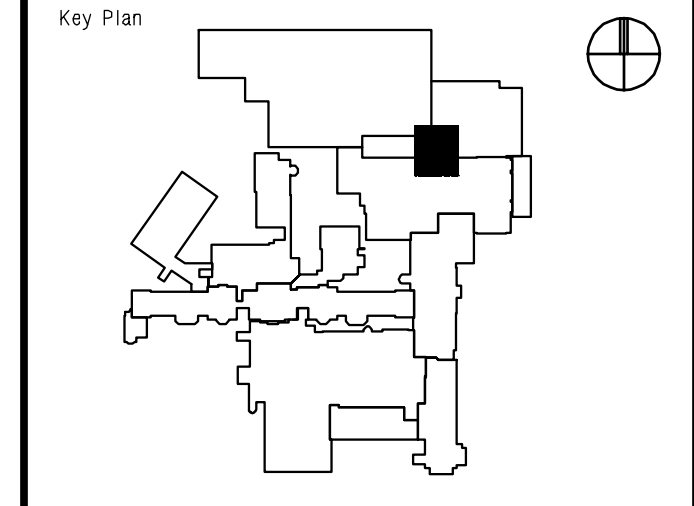

Mark	Date	Description
-	07-22-02	ISSUED FOR PRICING
-	06-07-02	FINAL REVIEW
-	05-14-02	PROGRESS REVIEW

Issue Dates

Drawing Status

Drawing Title
**FLOOR PLAN
 ELECTRICAL DEMOLITION**

PA / PE: **PRM** Drawn By: **PRA**

Drawing Number
E05.1