
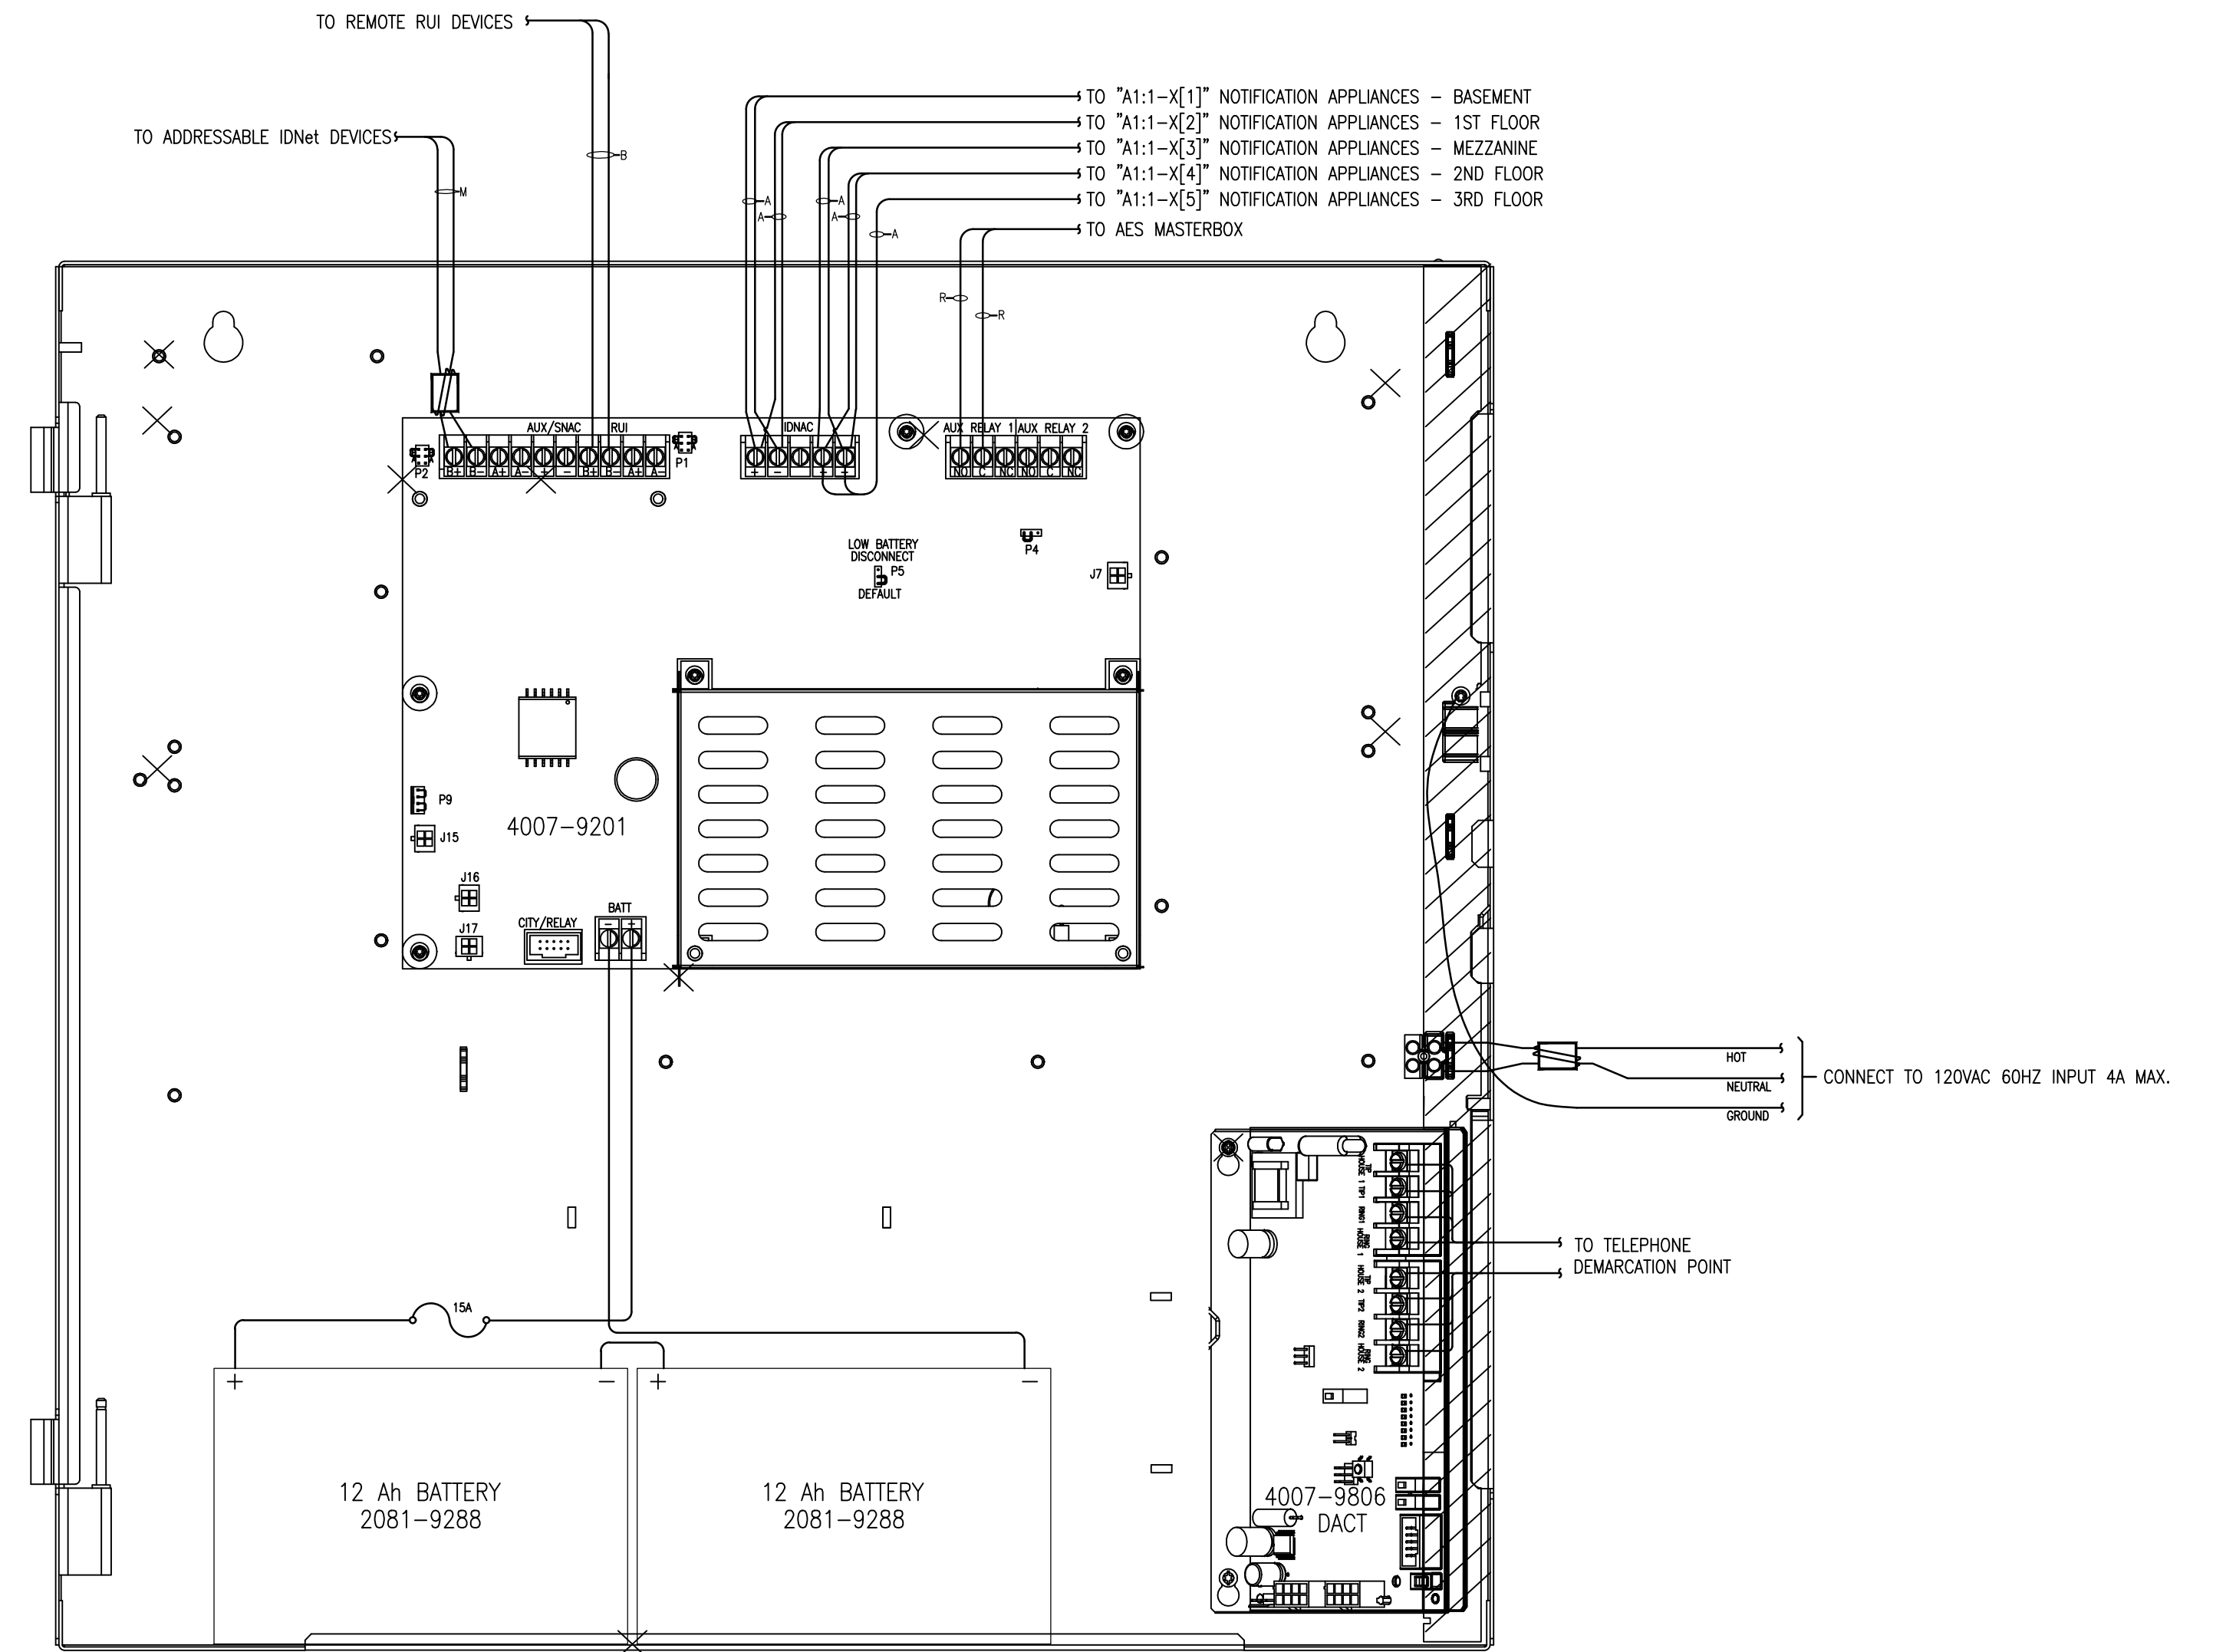
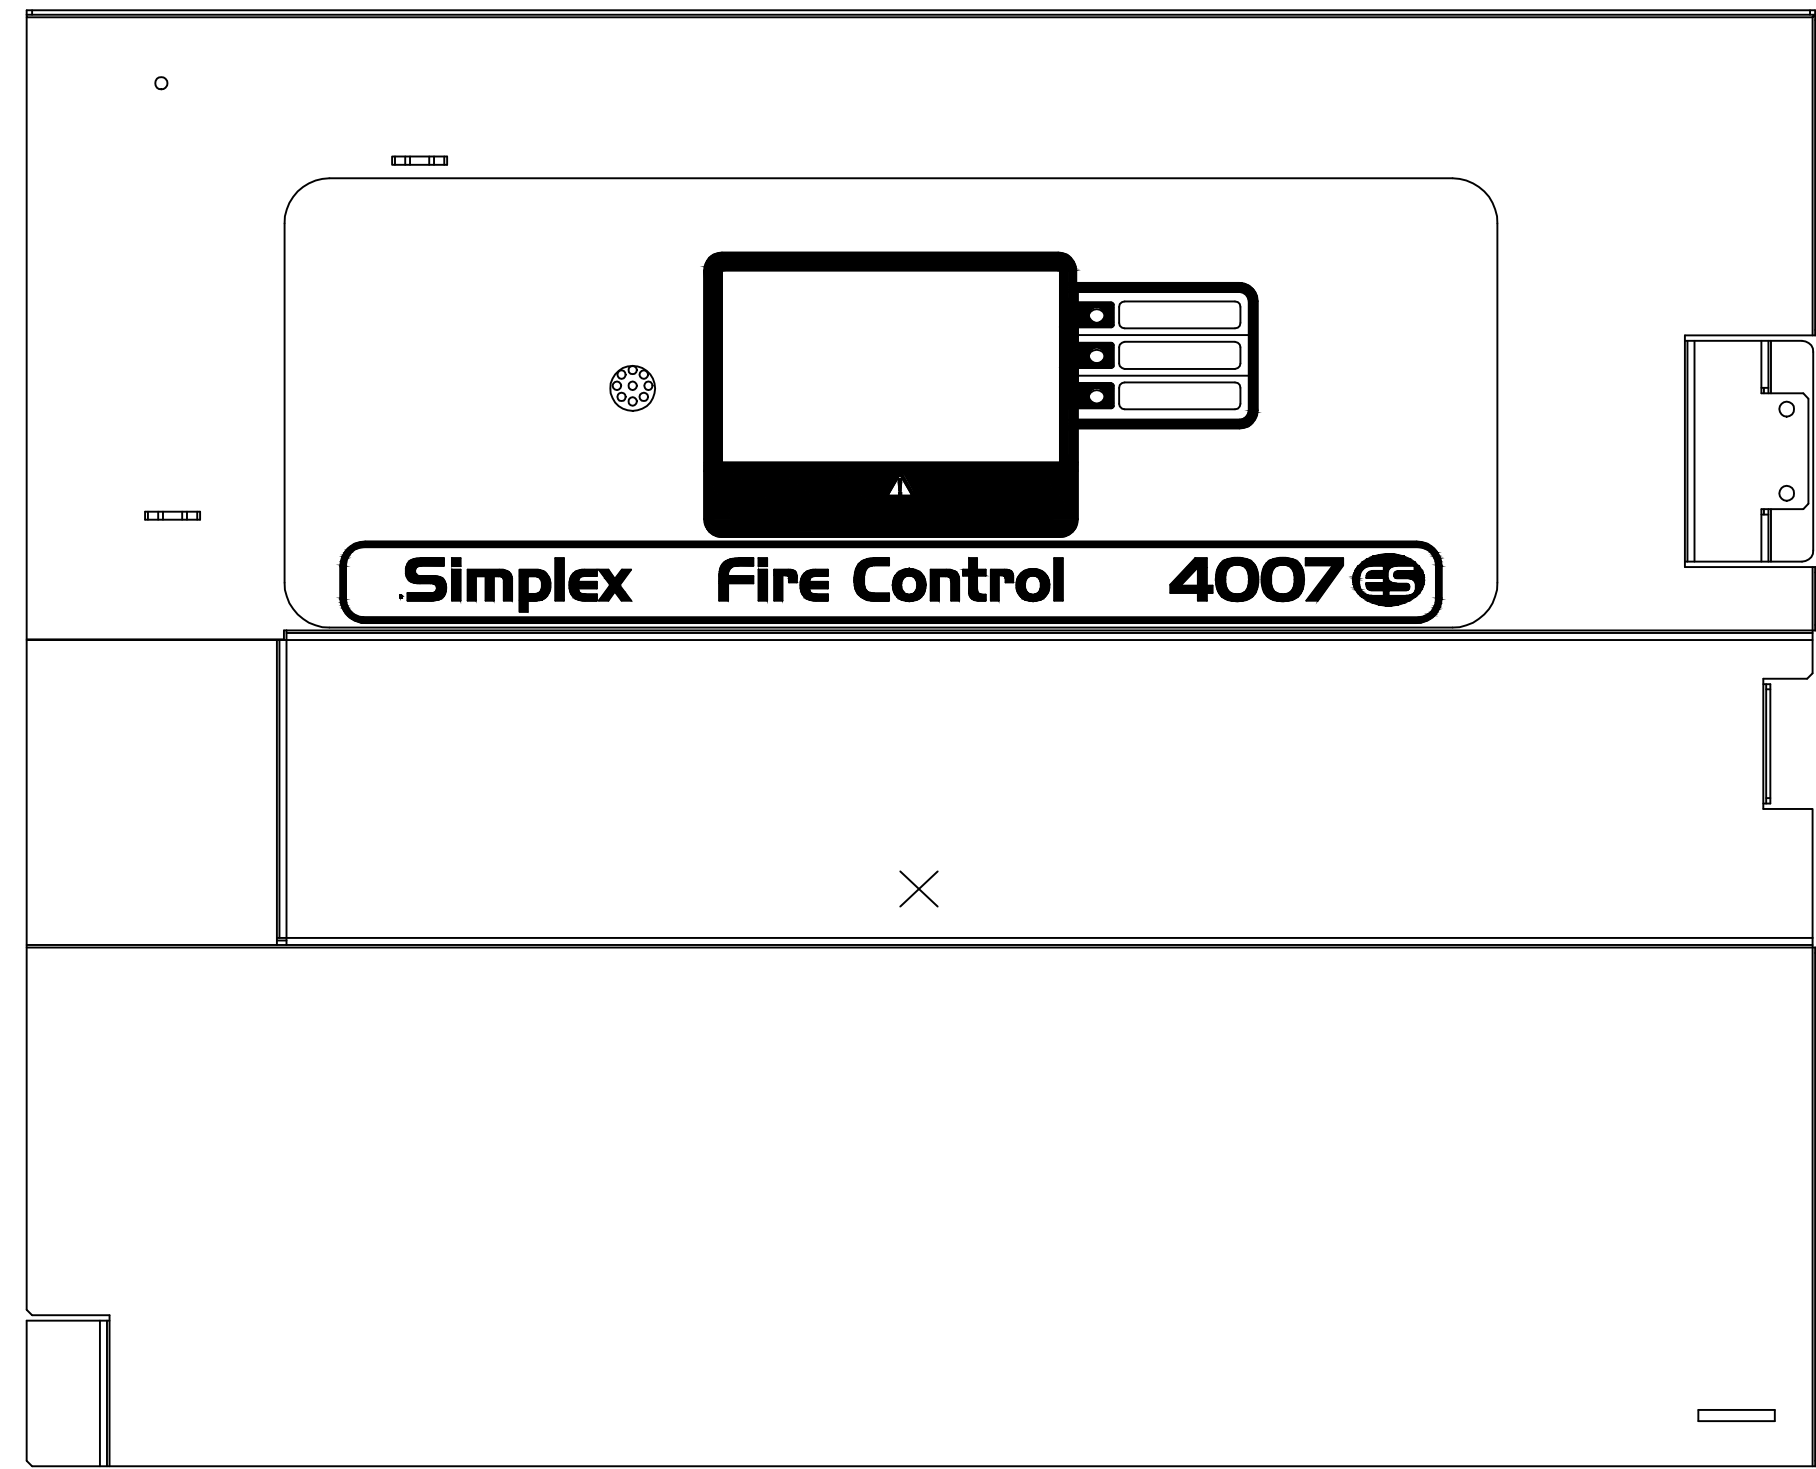


FILE PATH: P:\2016\4784-Cabletron\SS\Draws\FA-501.dwg

LAST SAVED BY: MDESZIATA

LAST PRINTED: 7/1/2016 4:17:31 PM

30" x 42" - Arch E1 Size

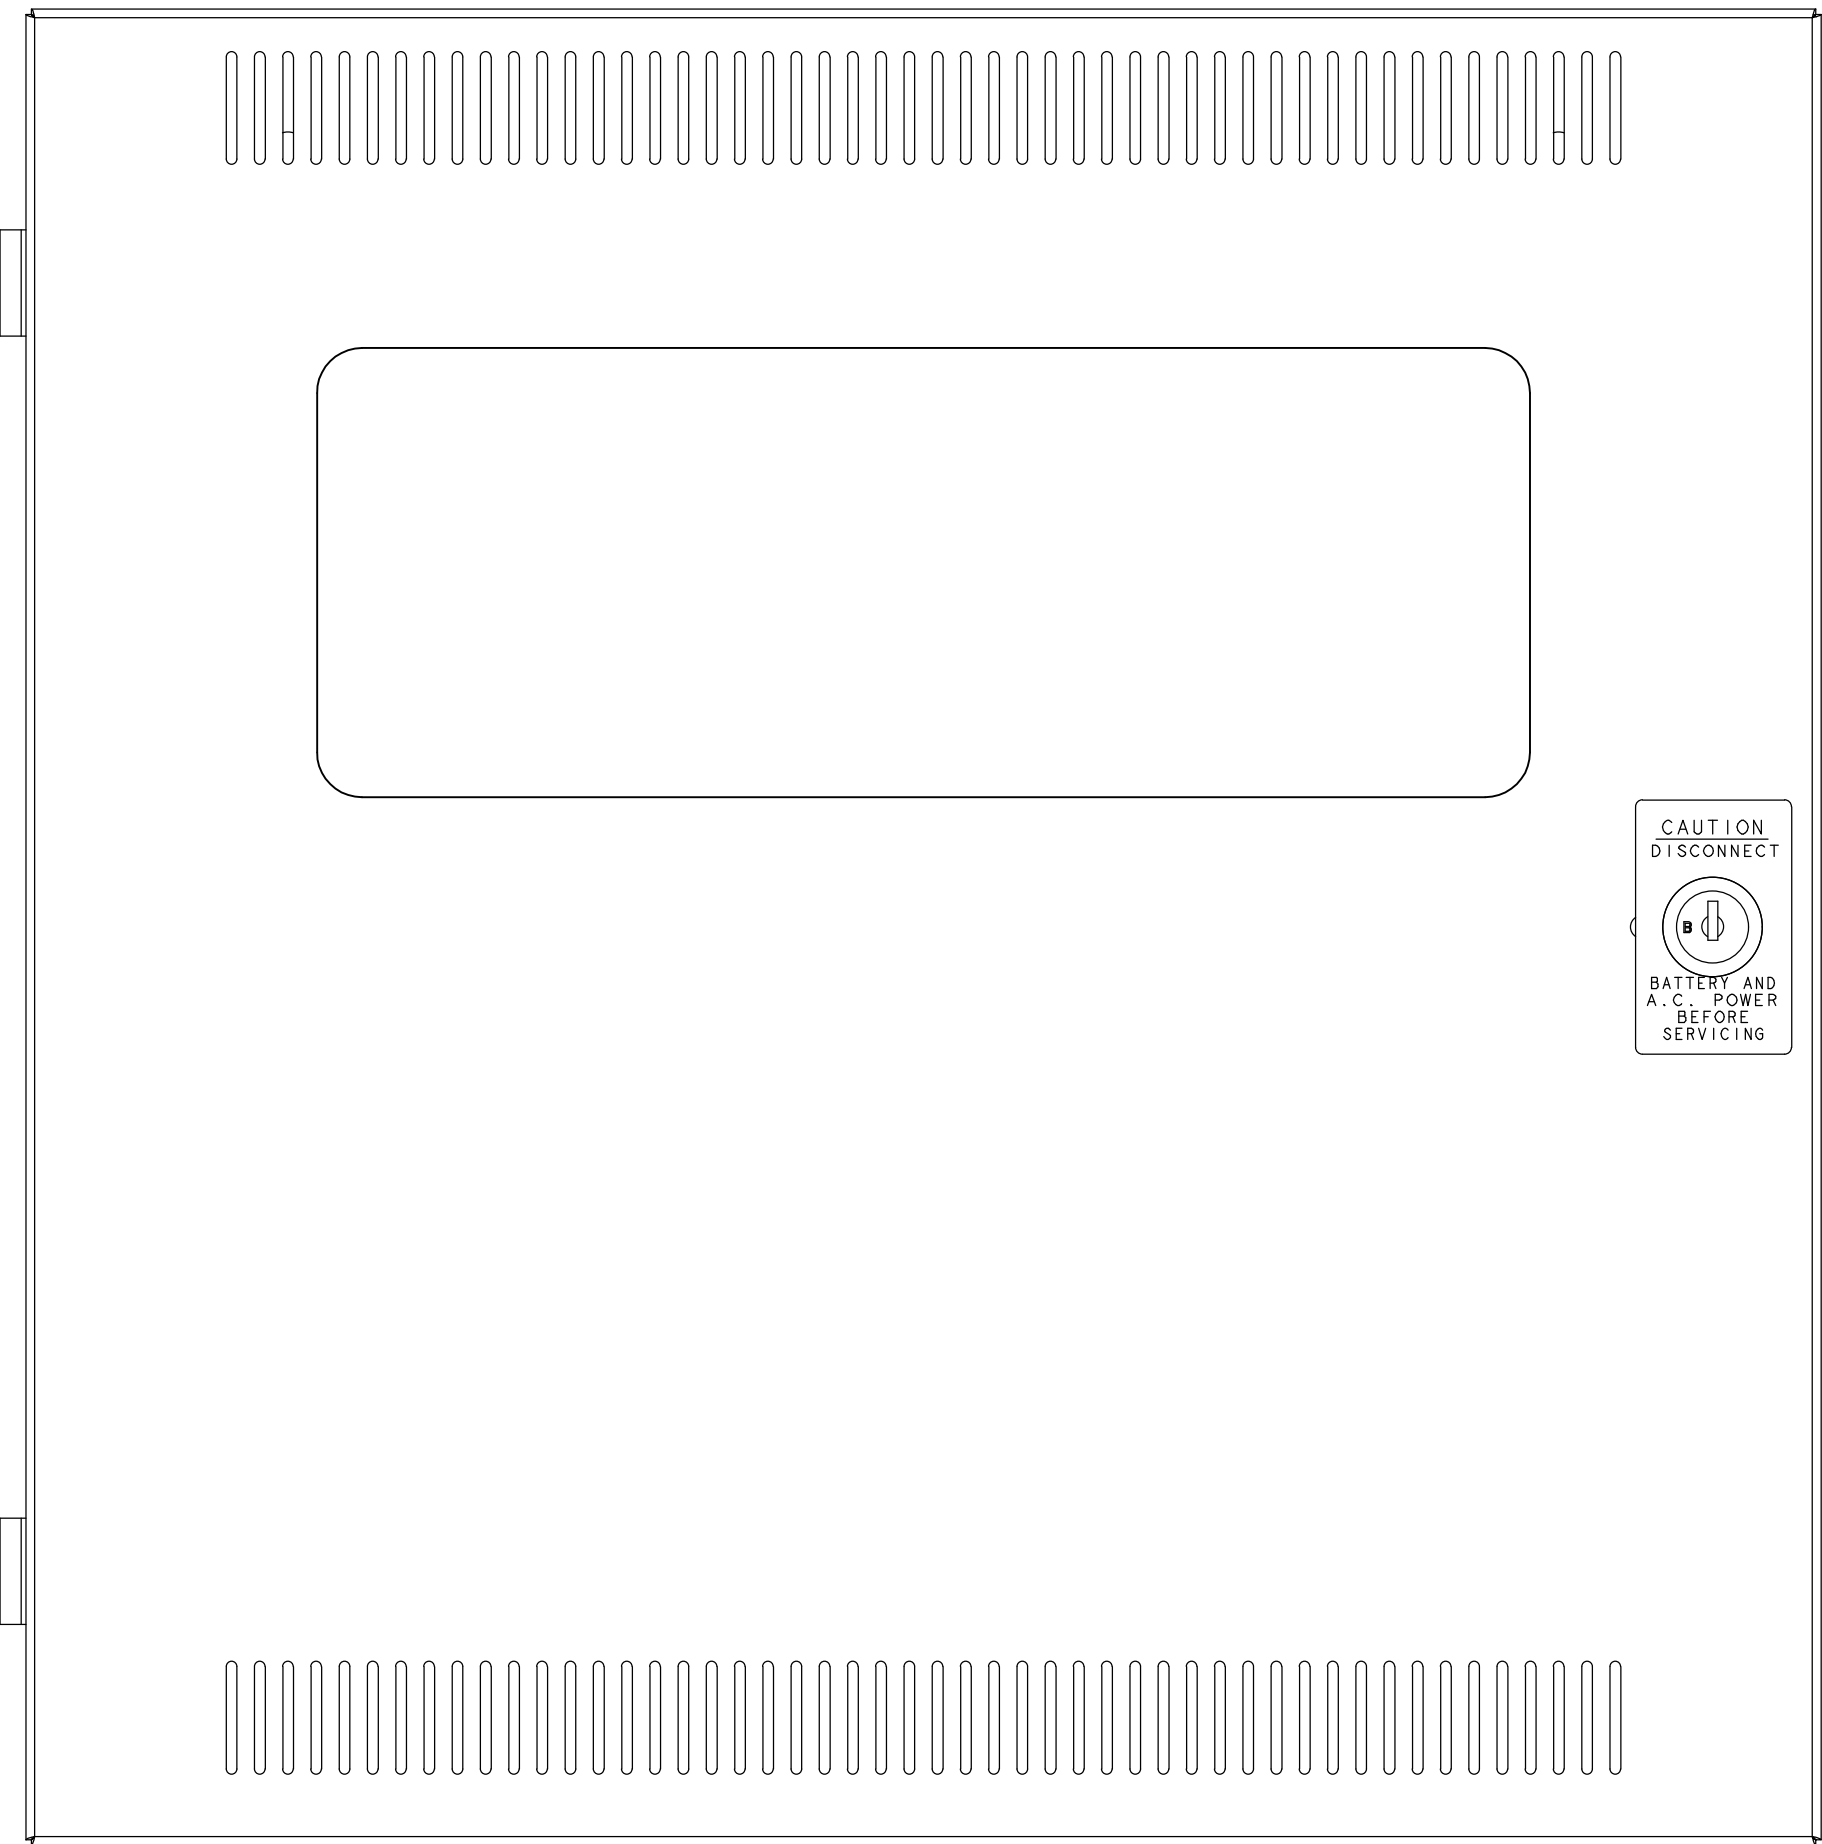

KEEP BATTERY WIRING TERMINALS TO THE FRONT OF THE BOX.
IF THE DACT SPACE OR THE CITY/RELAY OPTION CARD IS USED,
RUN 734-306 HARNESS WIRING ON THE BACK OF THE BOX TO
MAINTAIN SEPARATION FROM BATTERY WIRING.

ISSUE LOG	MARK	DATE	CHK	DESCRIPTION

DRAWN BY: M.DESIATA
CHECKED BY: S.KALAFARSKI
ISSUE DATE: 7/1/16
JOB #: 147-992934001
PROJECT #: 147-992934001
SIMPLEXGRINNELL © 2016
SYSTEM: FIRE ALARM SYSTEM
SHEET: PANEL DETAIL
FA-501

IMPORTANT NOTICE TO USER: By receiving or using this drawing you are deemed to have accepted the information contained herein. The user agrees to the following terms and conditions: The electronic information in this drawing may be subject to frequent or occasional alteration. Any user, maker, copy or modification or alteration of the information contained herein shall be the sole risk of the user. This information may not be used or transferred to any third party. User or other projects or addresses to this project shall be prepared or used for completion of this project by any third party. SimplexGrinnell disclaims all liability for the use or reuse of altered files by the user or any third party and our use will be user's sole risk. User shall be the liable user permitted by law, electric, company, and that SimplexGrinnell.