



**FOURTH FLOOR MECHANICAL PLAN**  
SCALE - 1/8" = 1'-0"

**NOTES**  
 1. HUS/R BRANCHES SHALL BE 3/4" UNLESS OTHERWISE NOTED.  
 2. EXHAUST FAN DUCTS SHALL BE 6" UNLESS OTHERWISE NOTED.

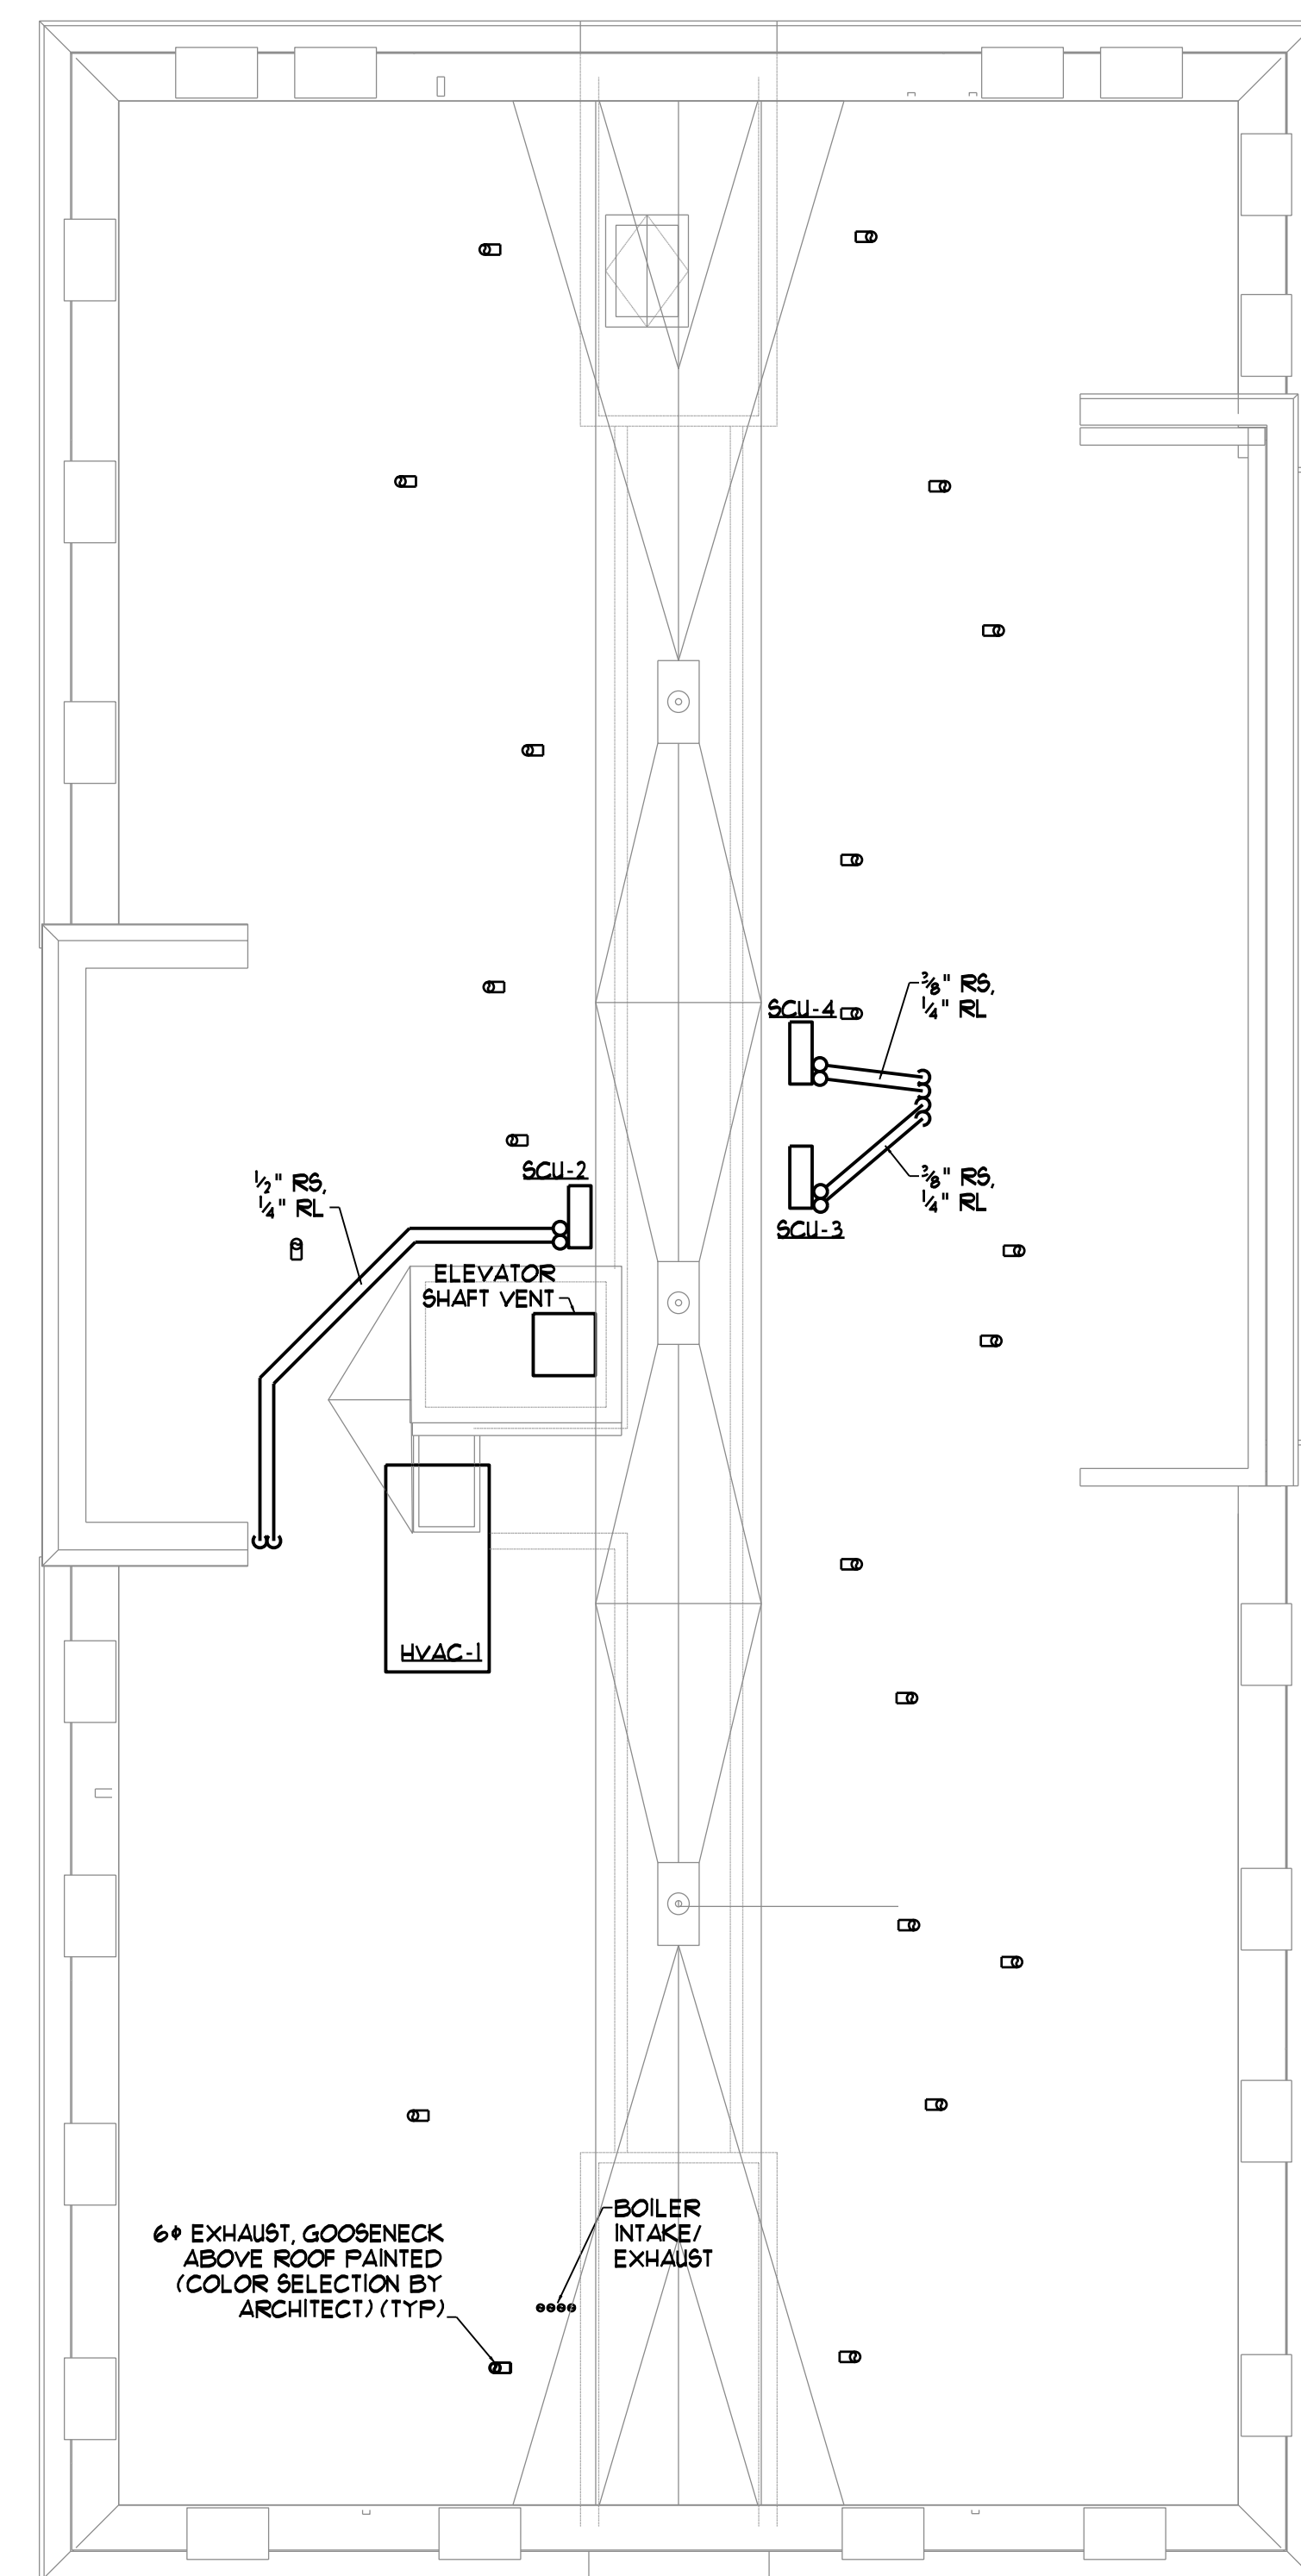

**ROOF MECHANICAL PLAN**  
SCALE - 1/8" = 1'-0"

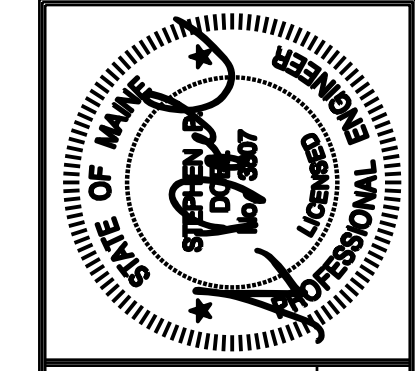

Prepared For:  
**AVESTA BUTLER  
 PAYSON PL.**  
 307 CUMBERLAND AVE  
 PORTLAND, ME. 04101

Consulting Engineer:  
  
**BENNETT  
 ENGINEERING**  
 MECHANICAL, ELECTRICAL  
 0071889475

Architect:  
  
**ARCHETYPE  
 architects**  
 48 Union Wharf Portland, Maine 04101  
 (207) 772-6022 Fax (207) 772-4056

Project:  
**CARLETON STREET  
 SENIOR HOUSING**  
 17 CARLETON ST.  
 PORTLAND, MAINE

Revisions:


Date: 08/08/2016  
 Scale: As Noted  
**FOURTH FLOOR AND ROOF  
 MECHANICAL PLANS**

**M1.03**