




Carleton St Senior Housing
17 Carleton St.
Portland, ME

Designer
SAJ
Date
5/5/2015
Scale
Not to Scale
Drawing No.
E0
Summary

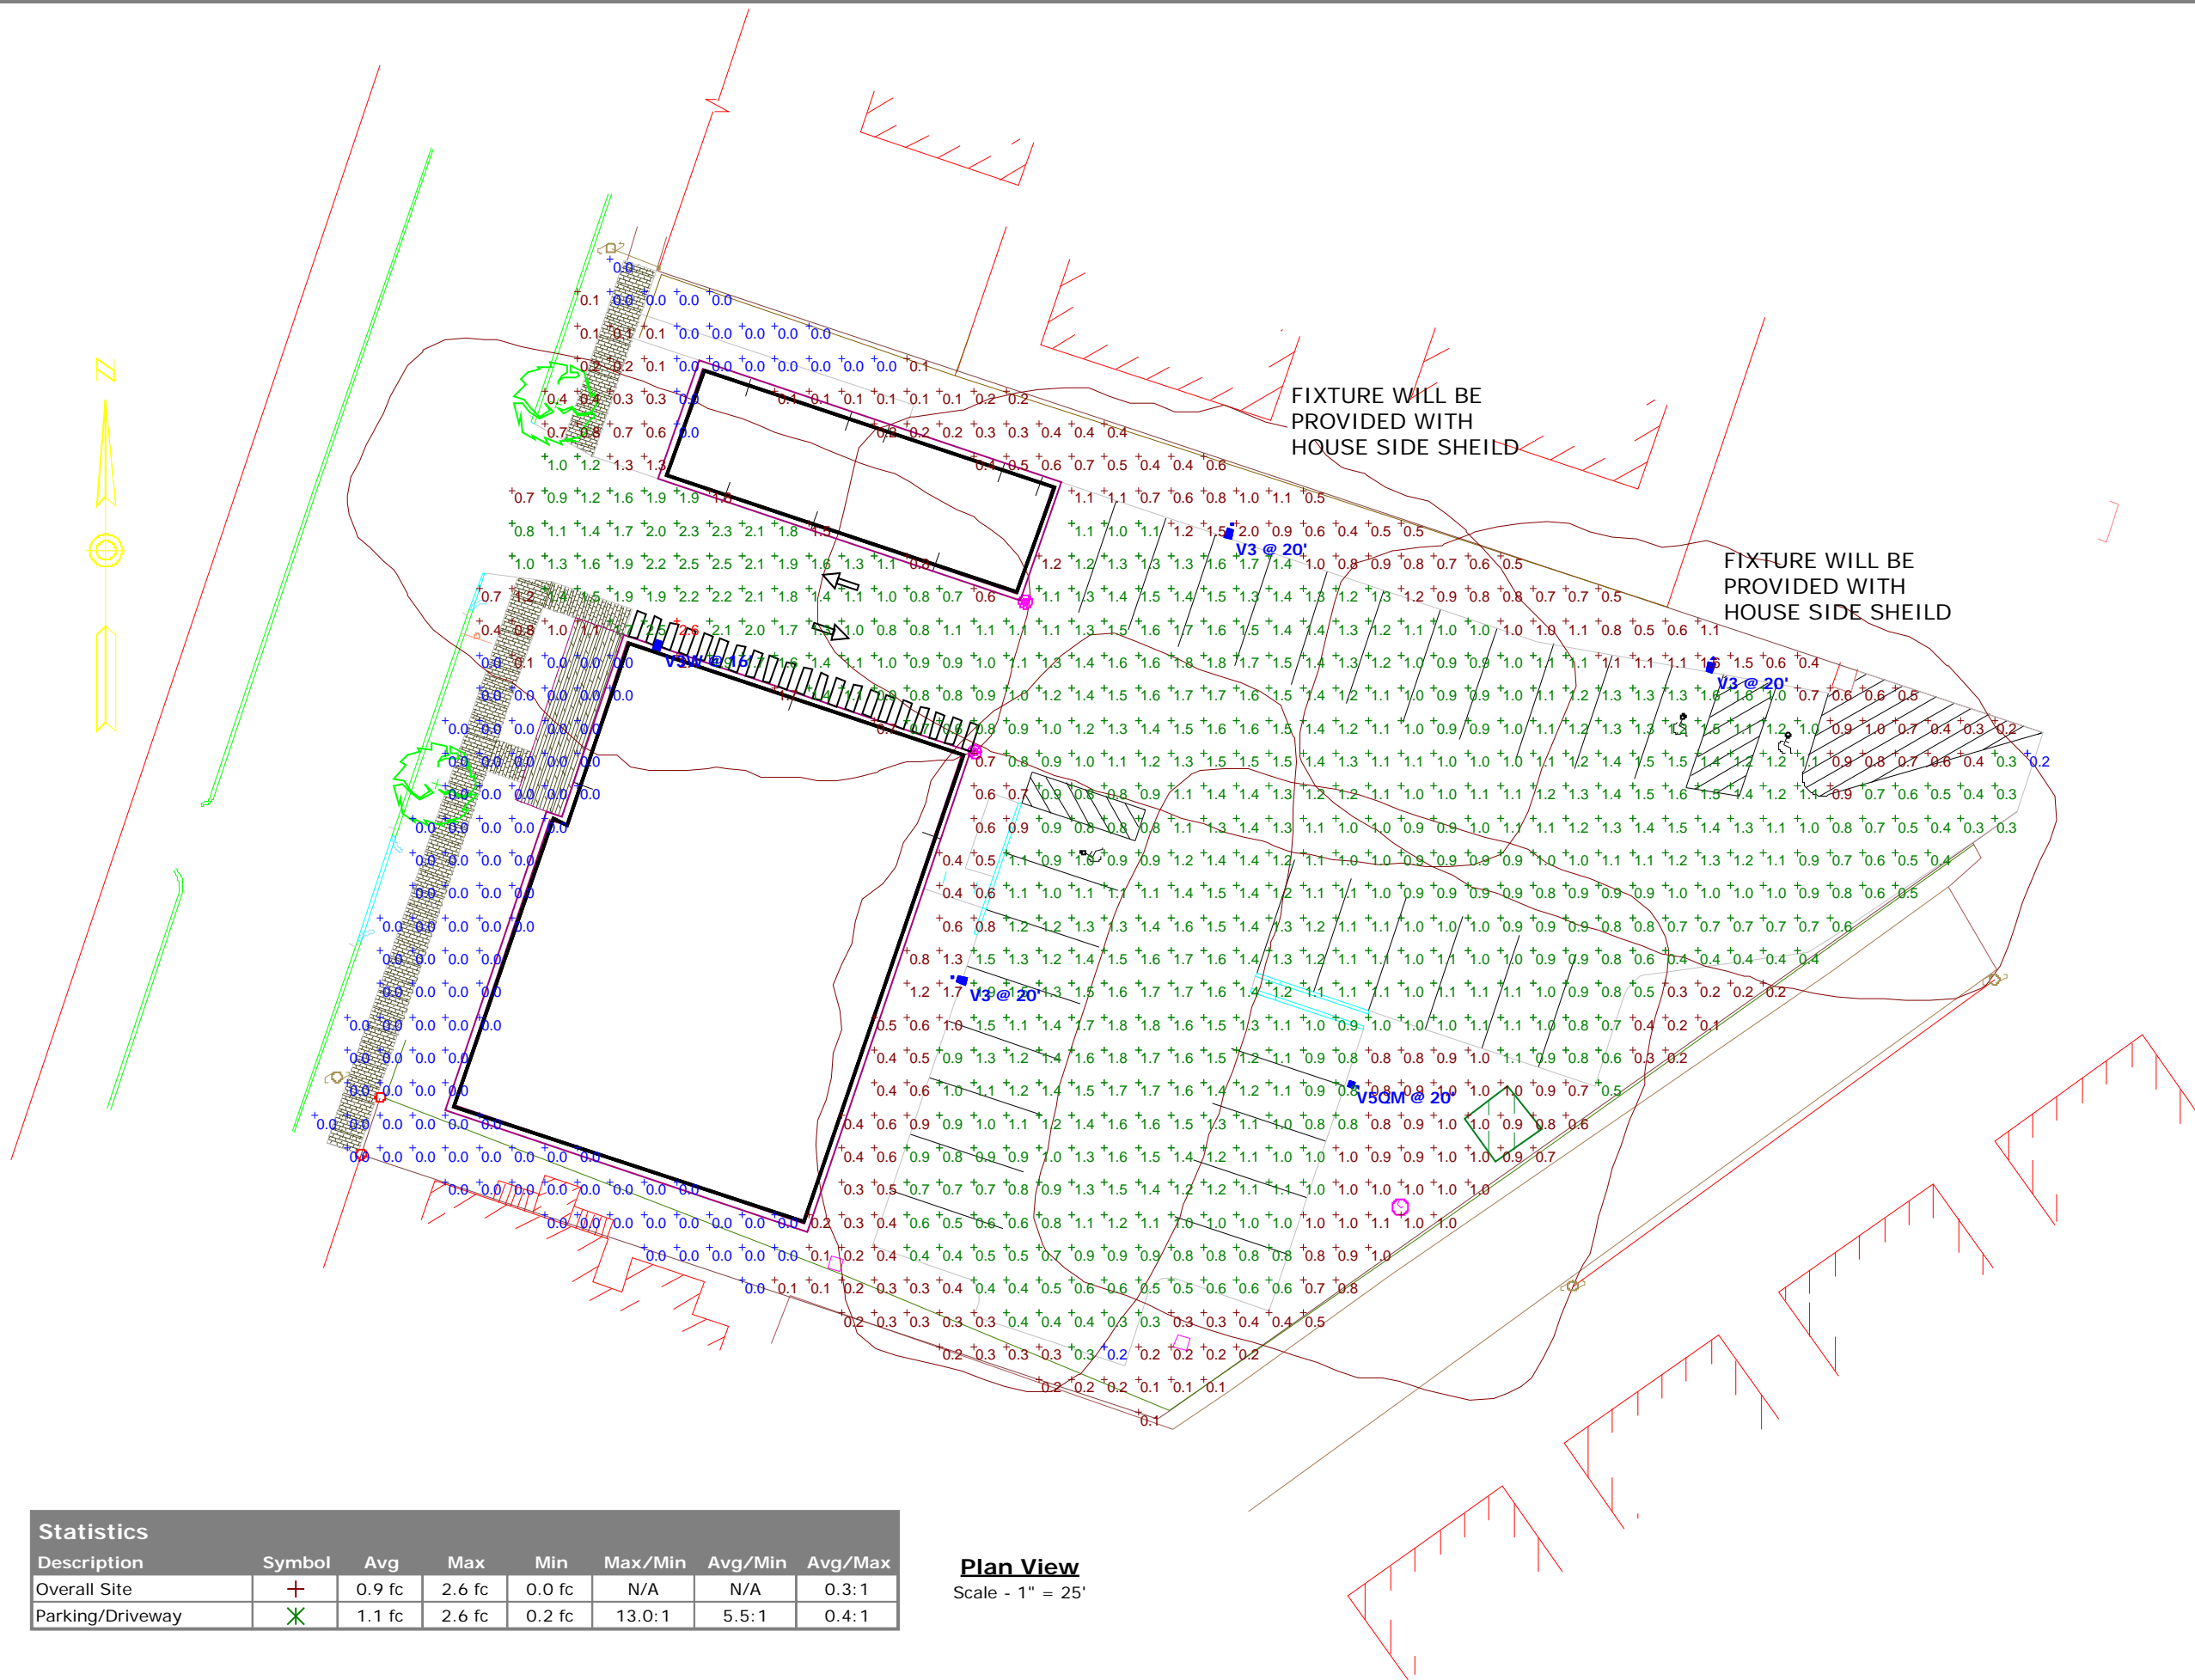

| Statistics | | | | | | | |
|------------------|--------|--------|--------|--------|---------|---------|---------|
| Description | Symbol | Avg | Max | Min | Max/Min | Avg/Min | Avg/Max |
| Overall Site | + | 0.9 fc | 2.6 fc | 0.0 fc | N/A | N/A | 0.3:1 |
| Parking/Driveway | X | 1.1 fc | 2.6 fc | 0.2 fc | 13.0:1 | 5.5:1 | 0.4:1 |

Plan View
Scale - 1" = 25'



Luminaire Schedule

| Symbol | Label | Quantity | Manufacturer | Catalog Number | Description | Lamp | Number Lamps | Filename | Lumens Per Lamp | Light Loss Factor | Wattage |
|--------|-------|----------|-----------------|----------------|-------------|----------------|--------------|-----------------------|-----------------|-------------------|---------|
| | V3 | 3 | BEACON PRODUCTS | 22NB-50-T3-5K | | 22 NICHIA LEDS | 1 | VP-S-22NB-50-T3.ies | 4710 | 1 | 50 |
| | V5QM | 1 | BEACON PRODUCTS | 22NB-500-T5SM | | 22 NICHIA LEDS | 1 | VP-S-22NB-50-T5QM.ies | 4923 | 1 | 50 |
| | V3W | 1 | BEACON PRODUCTS | 22NB-50-T3-5K | | 22 NICHIA LEDS | 1 | VP-S-22NB-50-T3.ies | 4710 | 1 | 50 |

Carleton St Senior Housing
 17 Carleton St.
 Portland, ME

Designer
 SAJ
Date
 5/5/2015
Scale
 Not to Scale
Drawing No.
 E0
Summary