

project name

Butler Payson  
pine st.  
state st.  
portland, me

avesta housing

goduti/thomas architects

44 oak st.

portland, maine 04101

ph. 207-775-3184

fax 207-774-0486

revisions

revisions

date  
March 26, 2015

sheet title












butler  
boiler room plans  
mechanical plan

scale  
1/8" = 1'-0"

drawn by  
R.E.M.

project number  
butpay

BM6

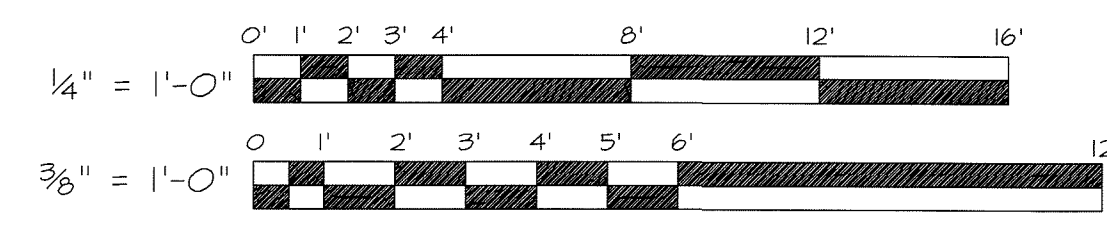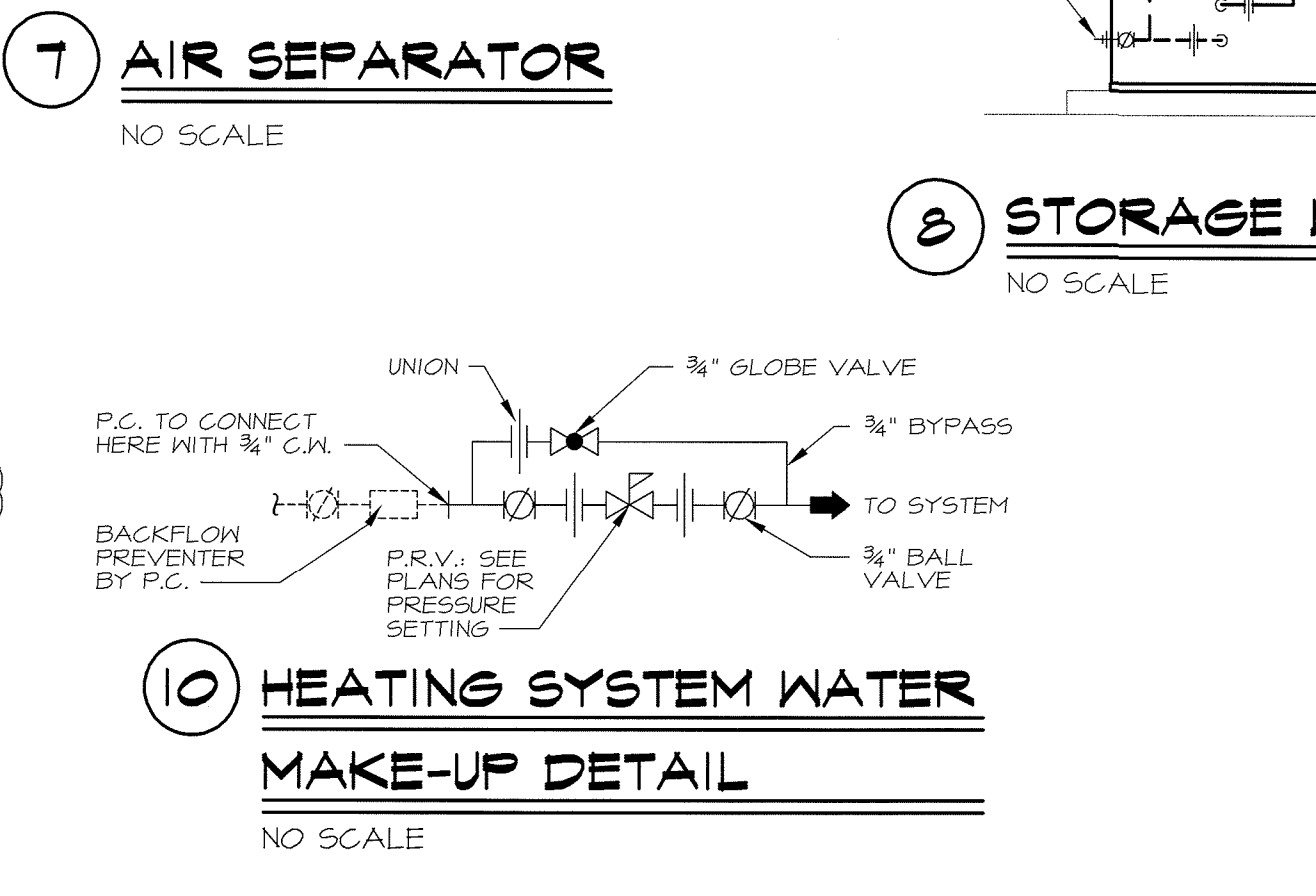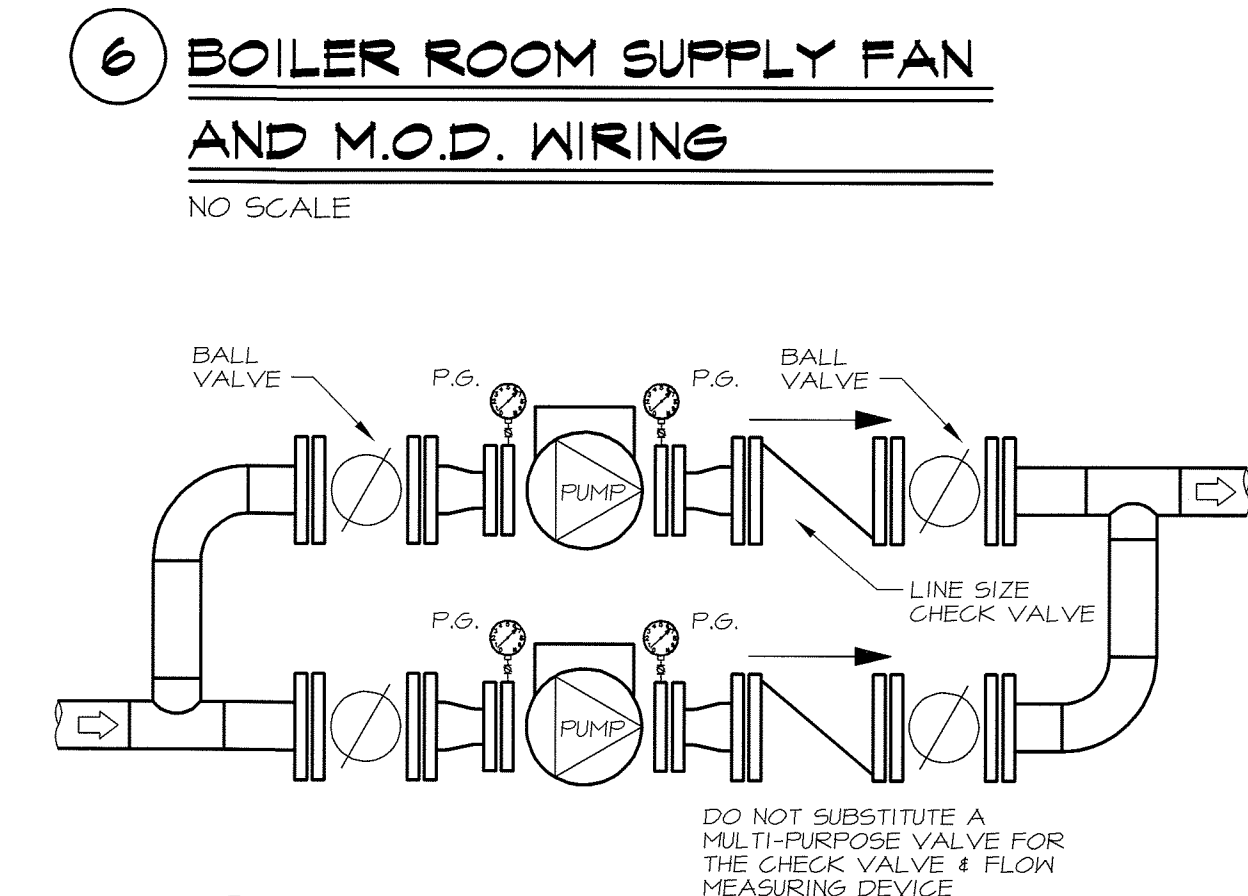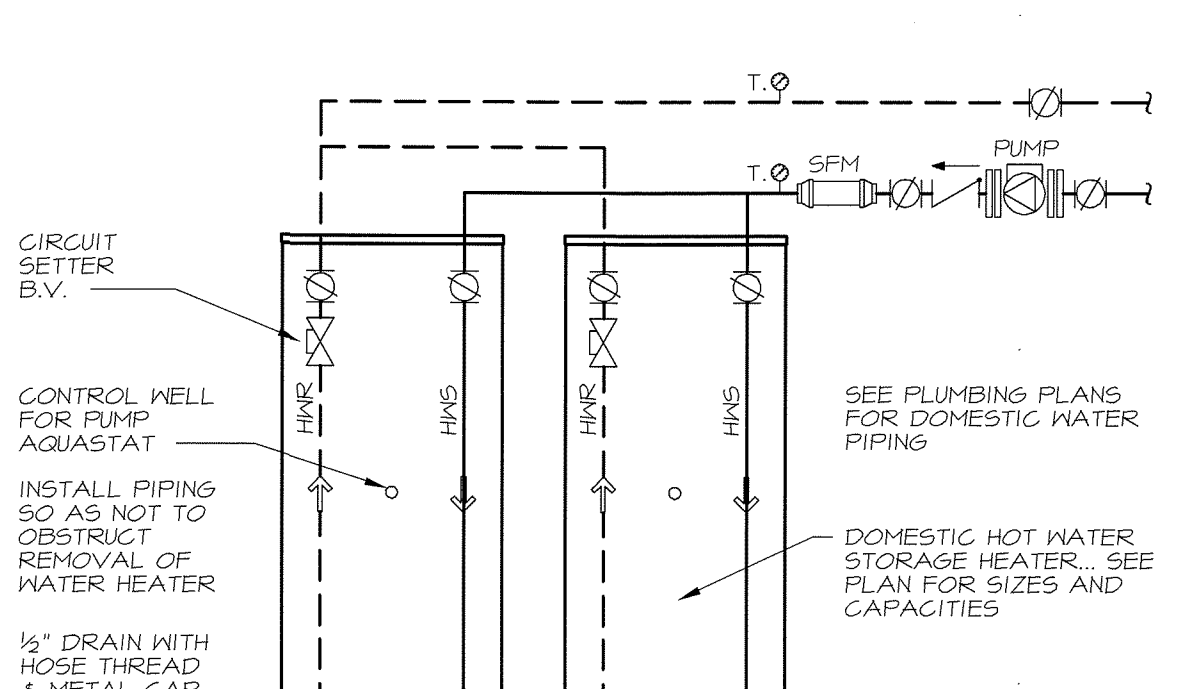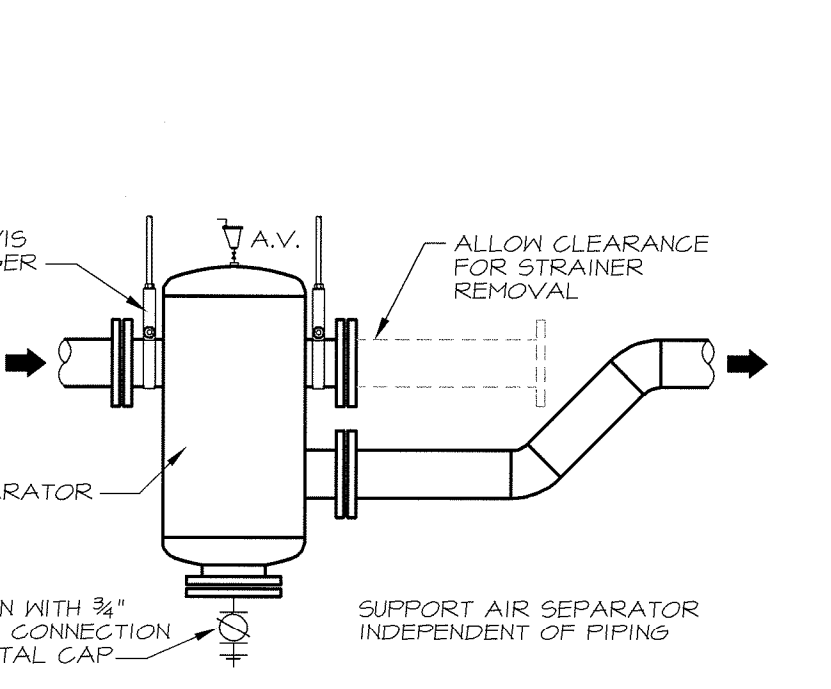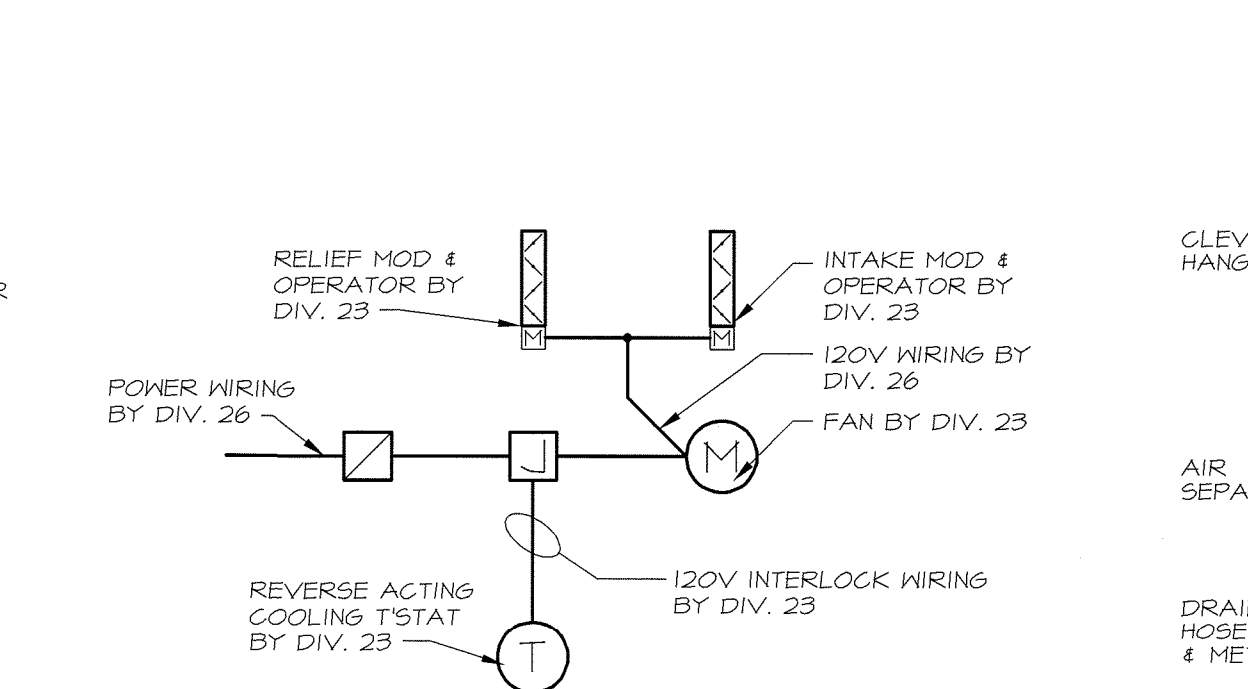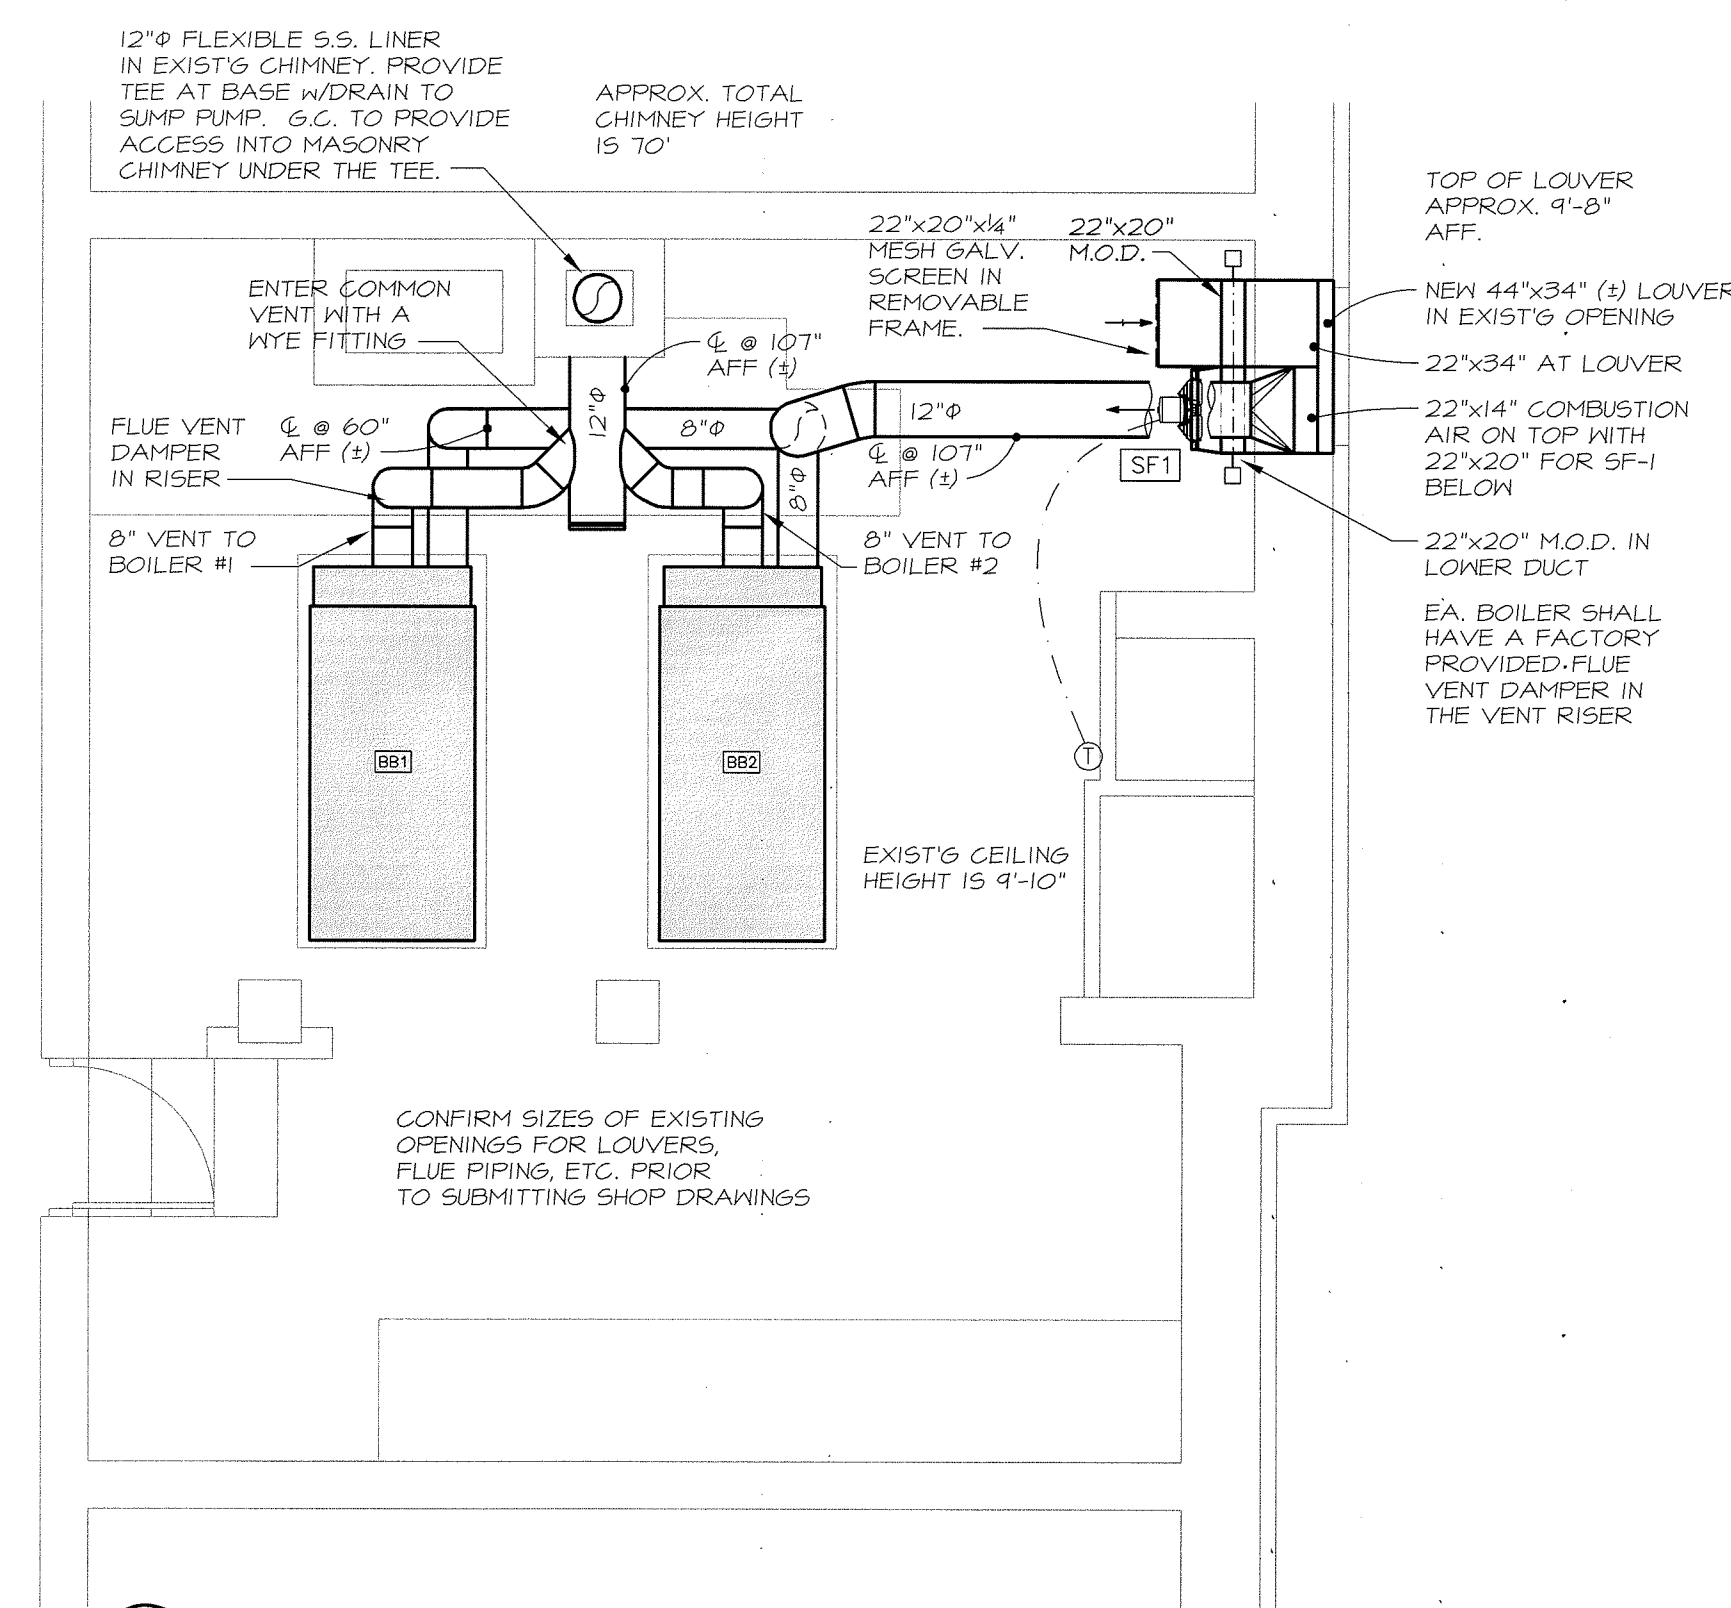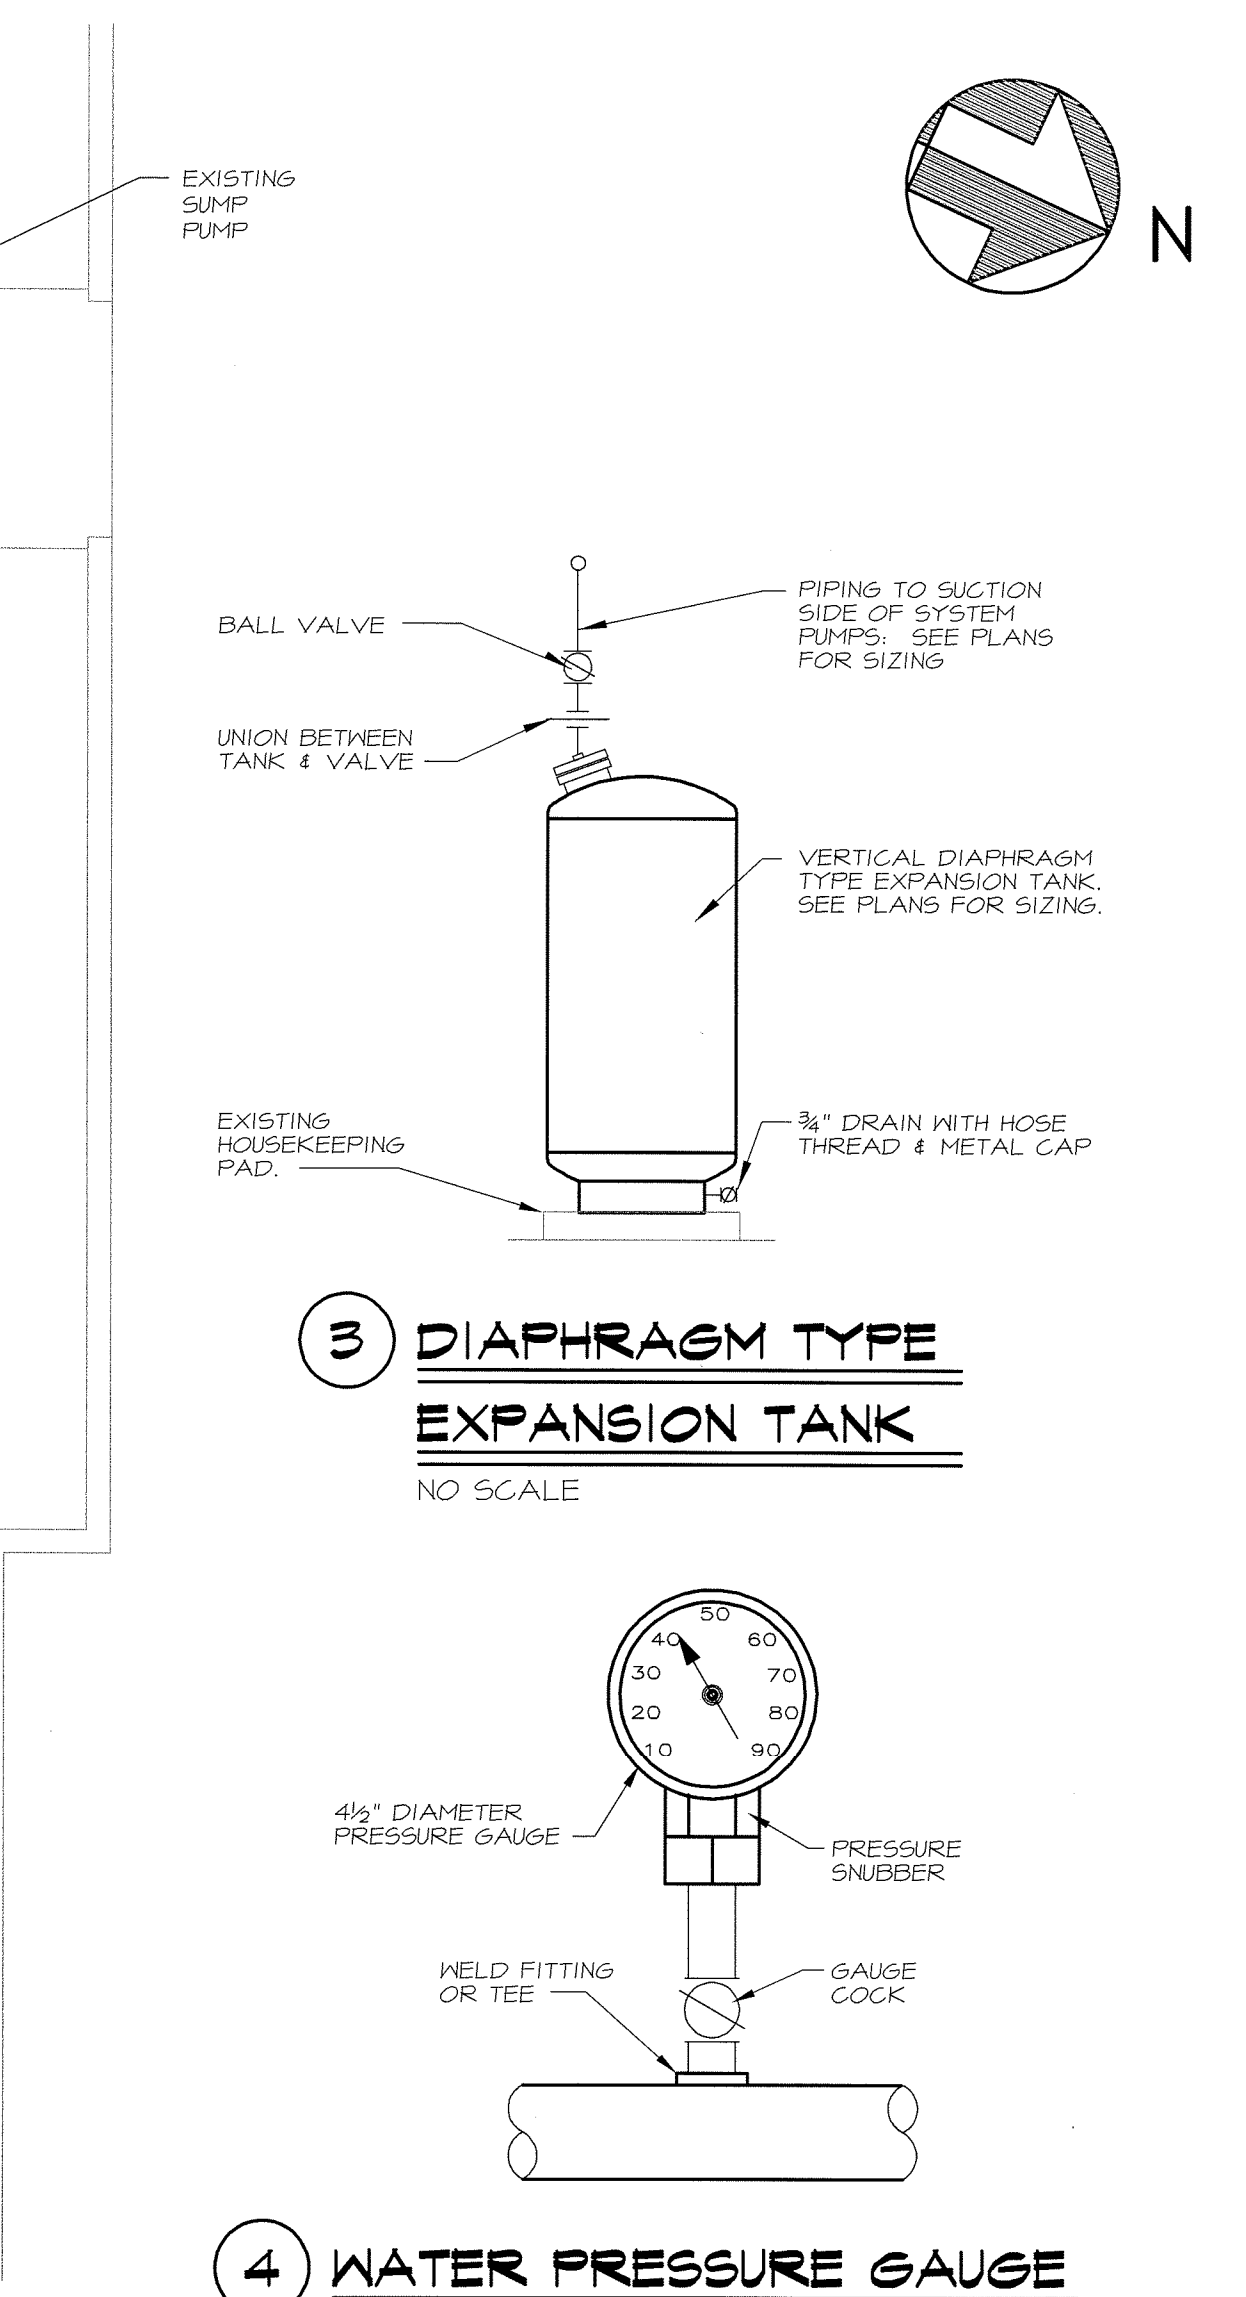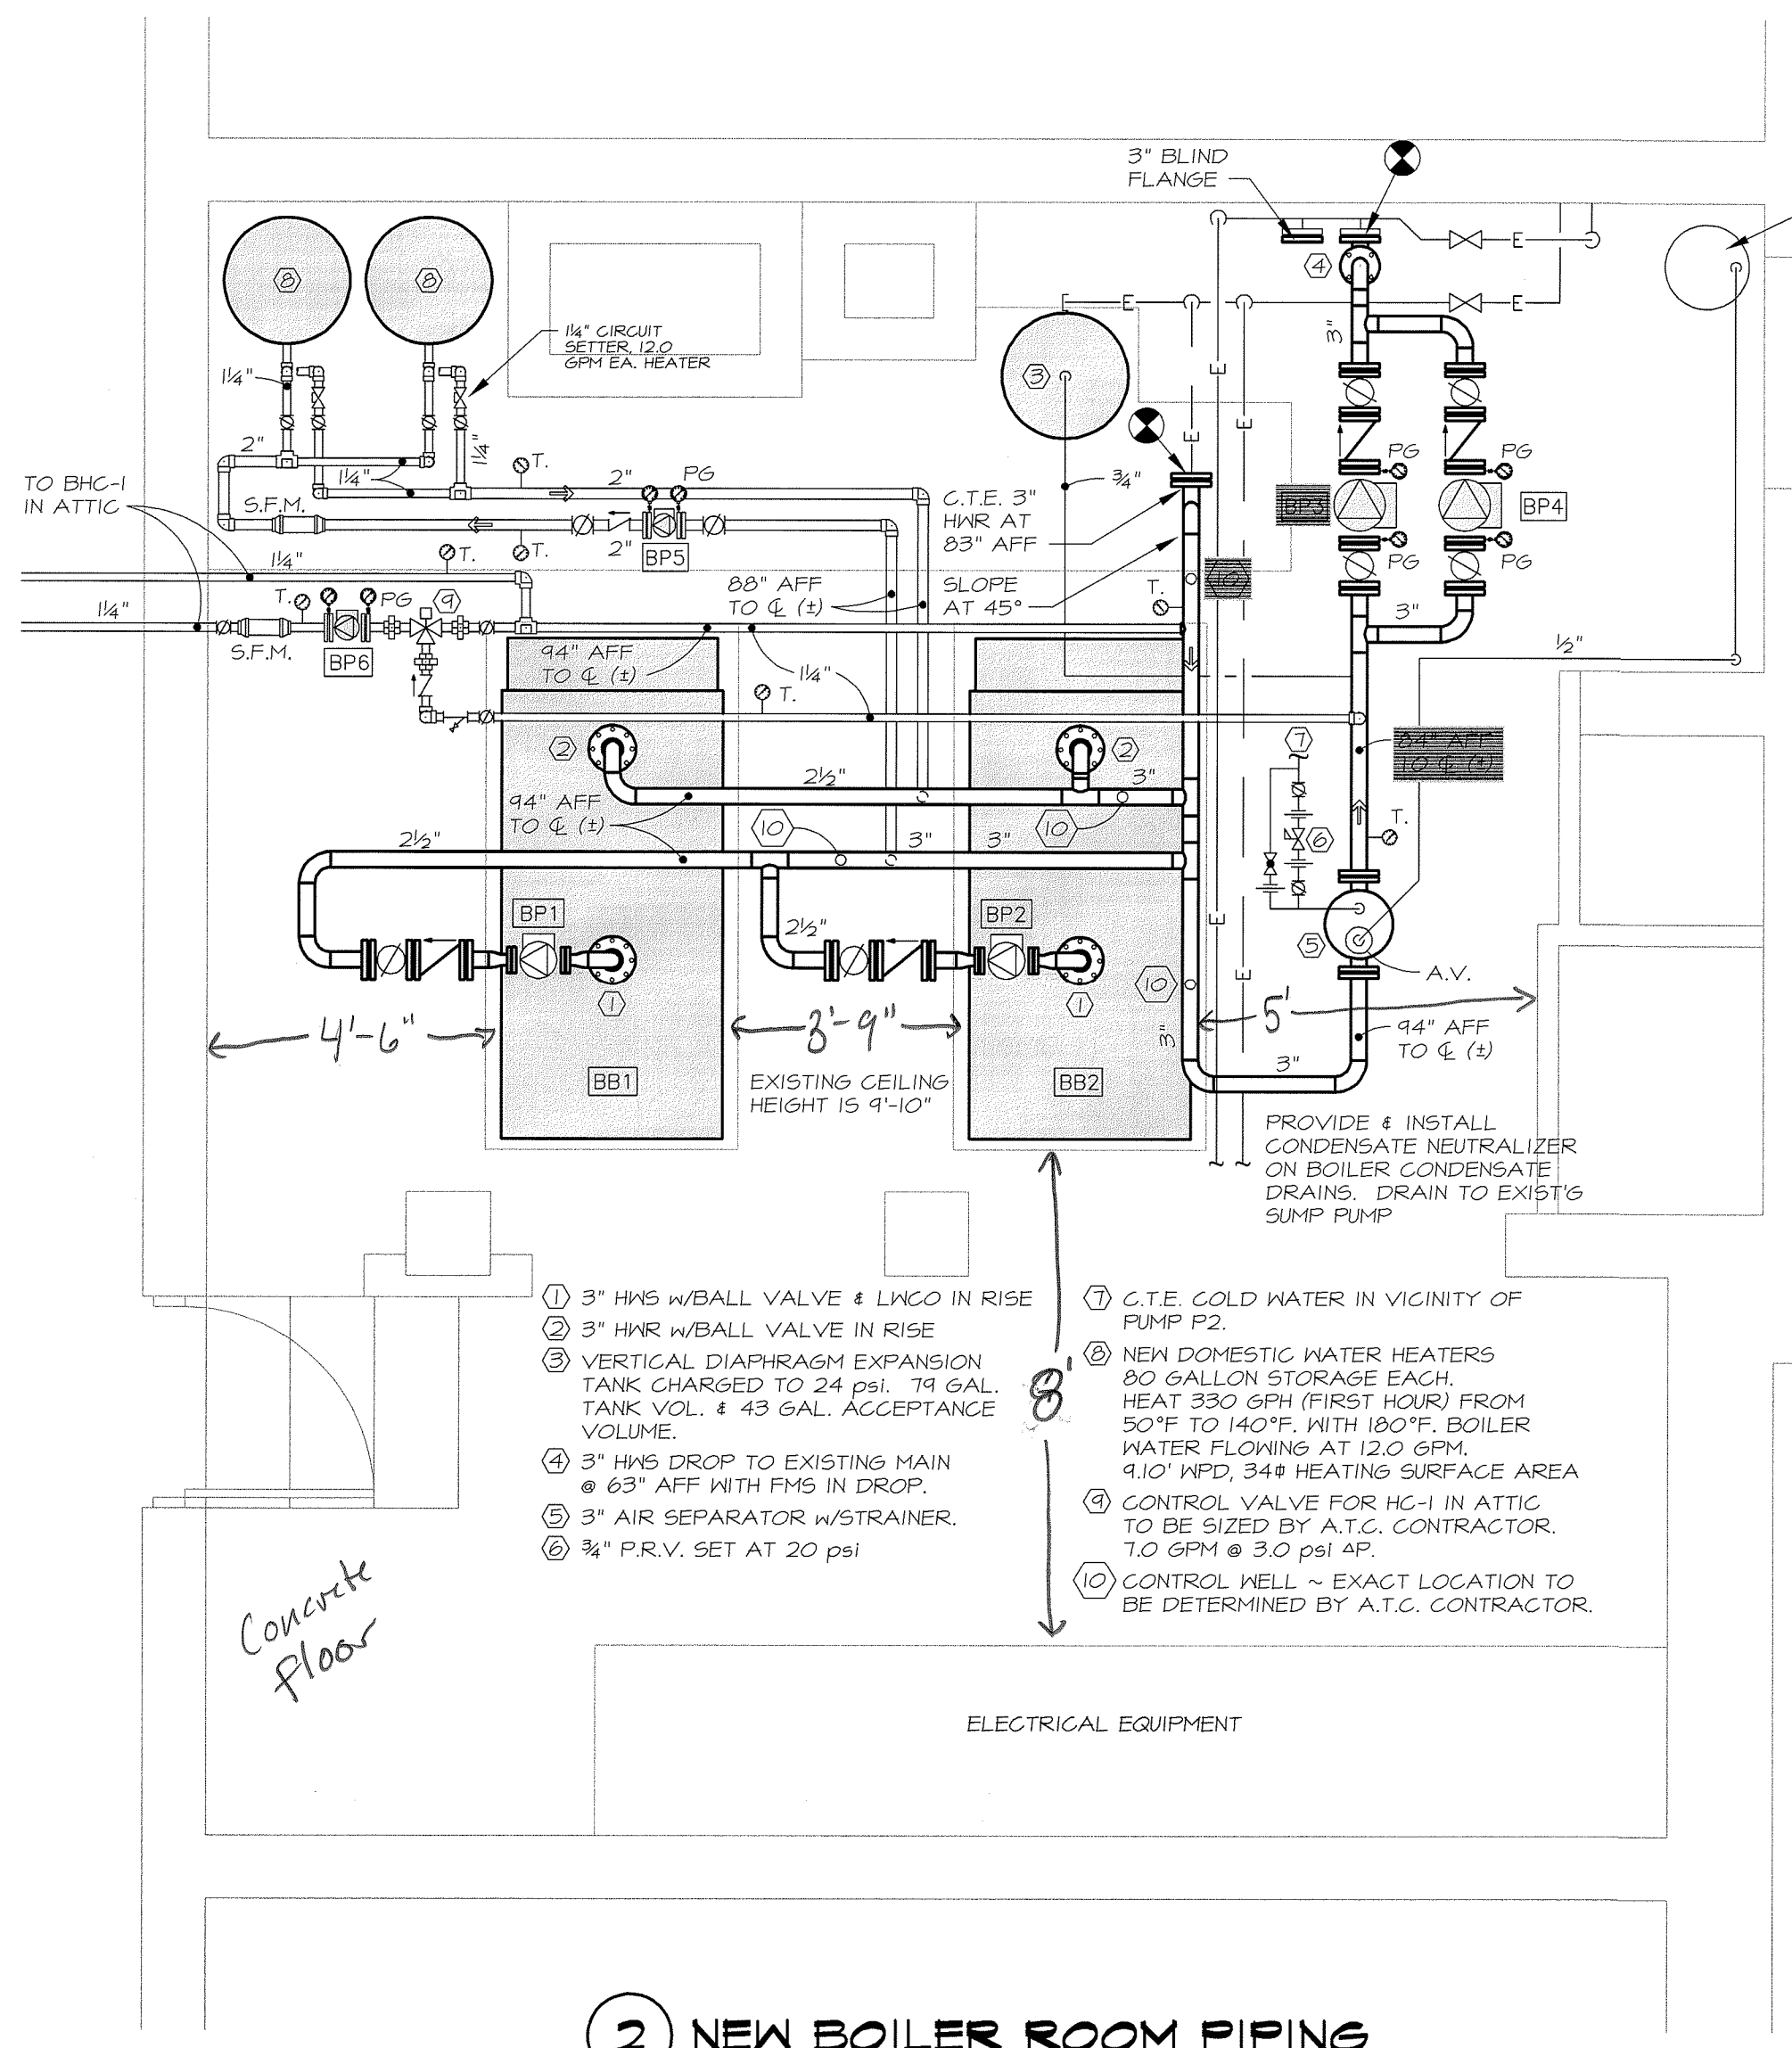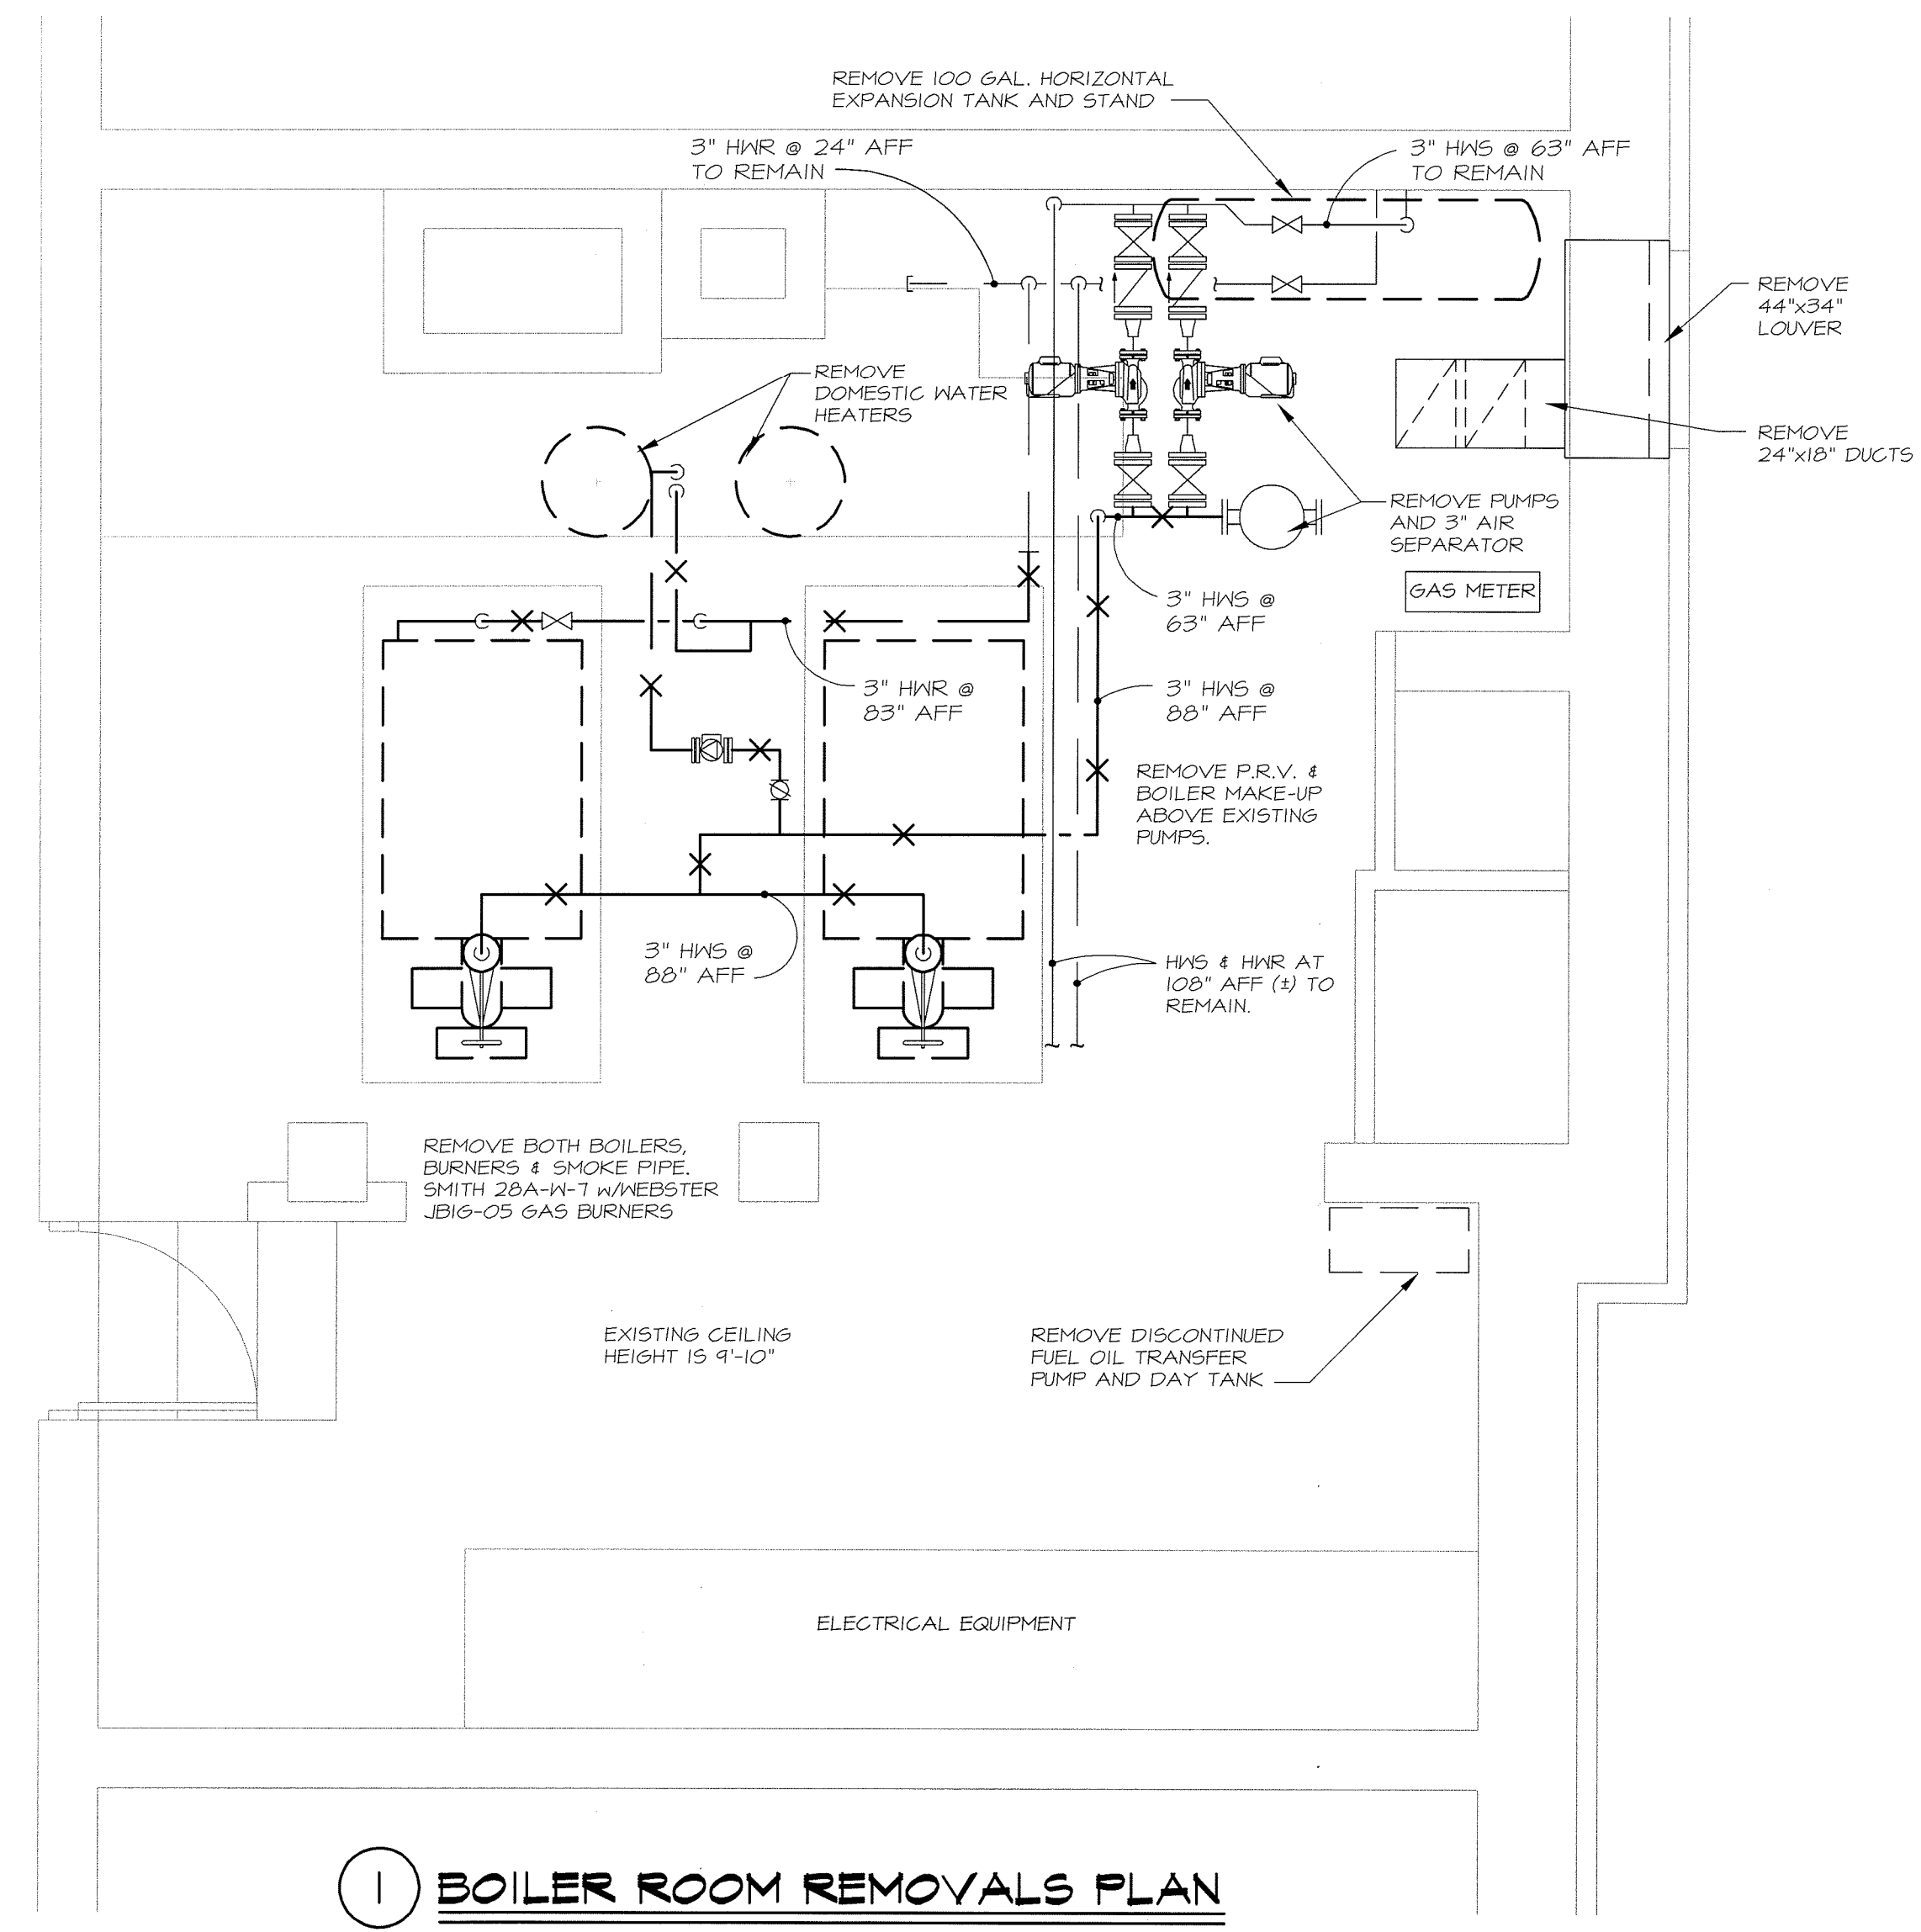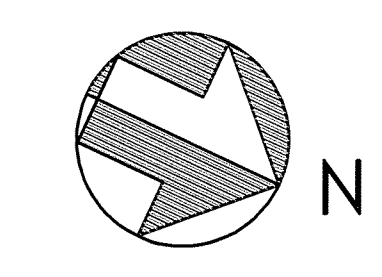

MECHANICAL SYSTEMS ENGINEERS  
ROYAL RIVER CENTER, UNIT 108  
10 FOREST FALLS DRIVE, YARMOUTH, MAINE 04096  
(207) 846-1441  
FACEBOOK: MECHANICAL SYSTEMS ENGINEERS  
© COPYRIGHT 2015



March 18, 2015 - 7:55 am  
\\MSFFS\shared\Projects\1433 Butler School Drawings\1433 BM6-BM7.dwg