

project name

Butler Payson
pine st.
state st.
portland, me

avesta housing


goduti/thomas architects

44 oak st.

portland, maine 04101


ph. 207-775-3184

fax 207-774-0486

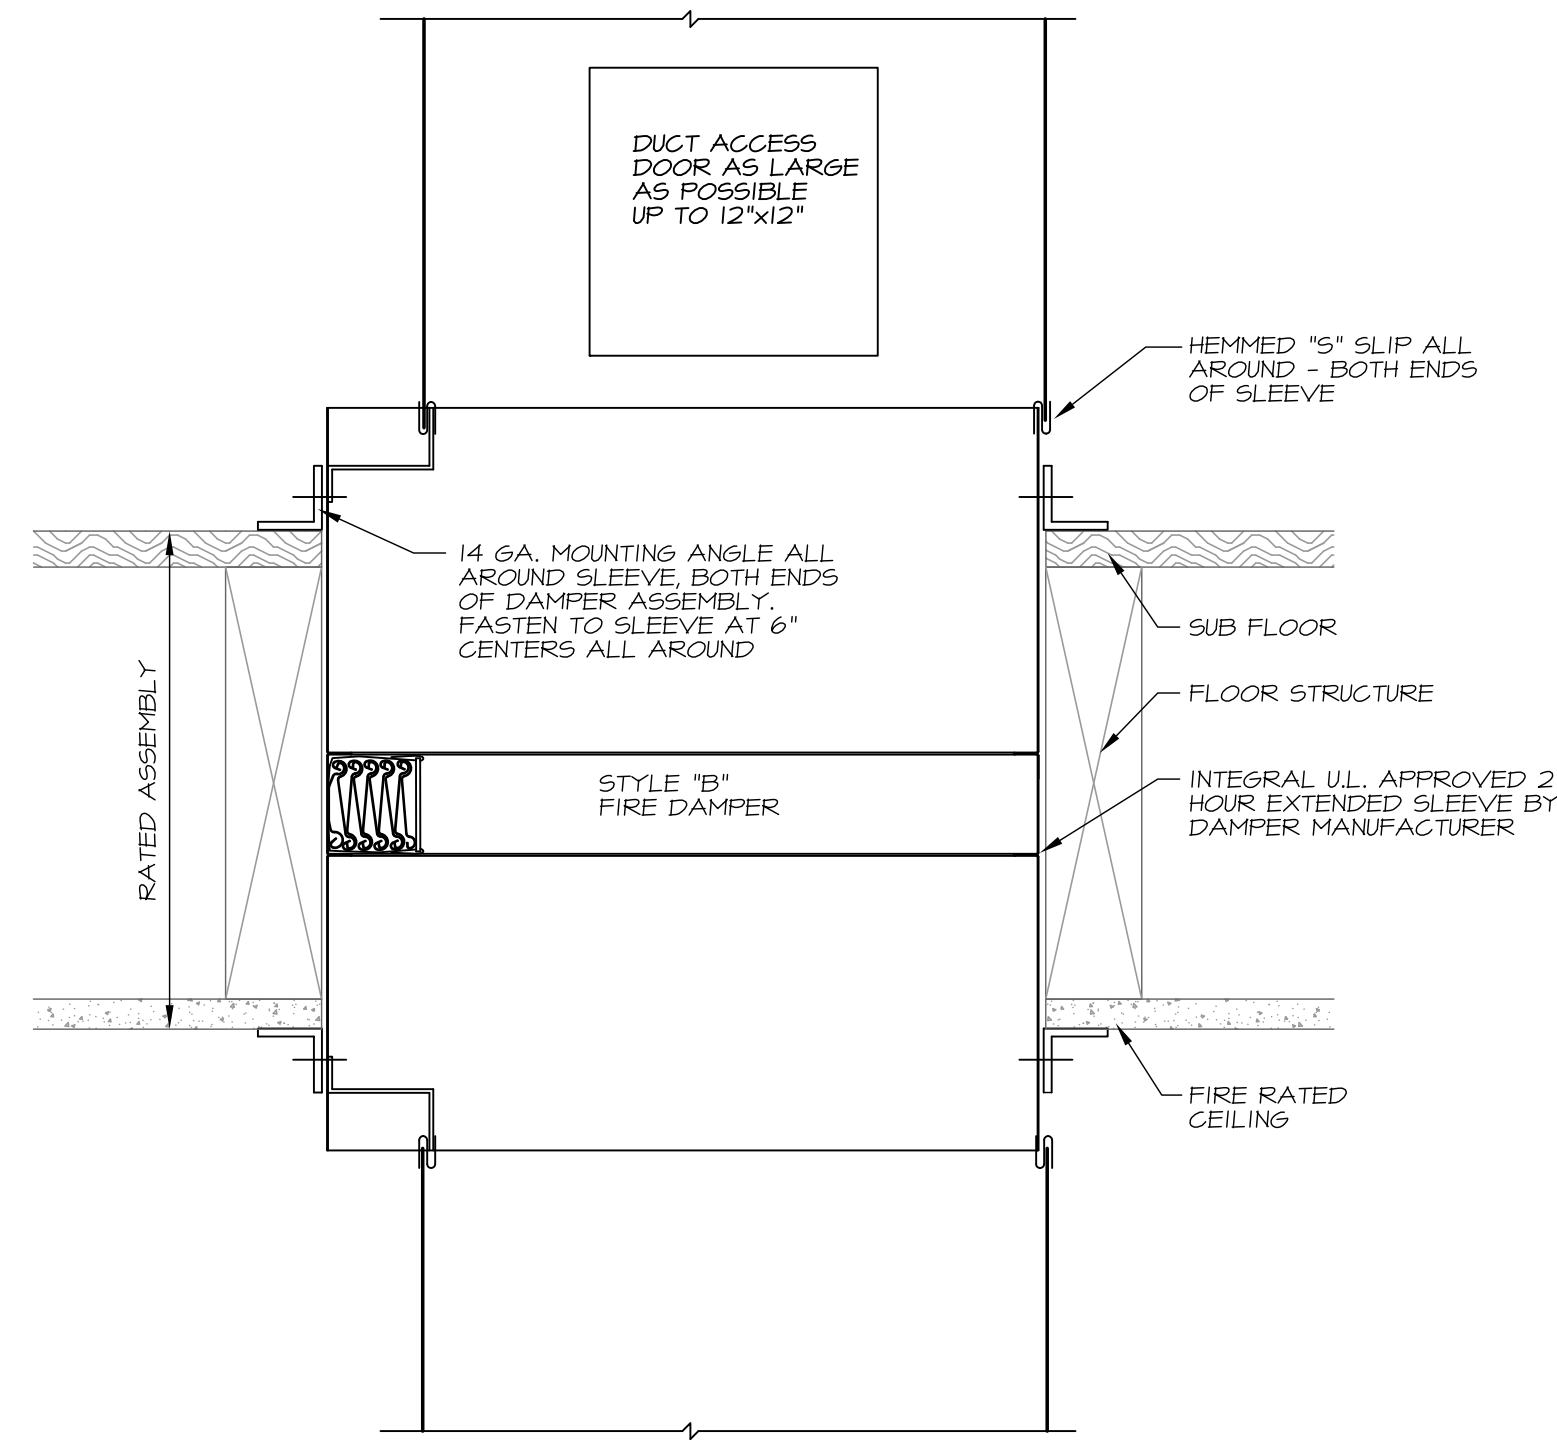

SEE PLANS FOR DUCT AND DAMPER SIZING


1 FLOOR FIRE DAMPER STYLE "B"
NO SCALE

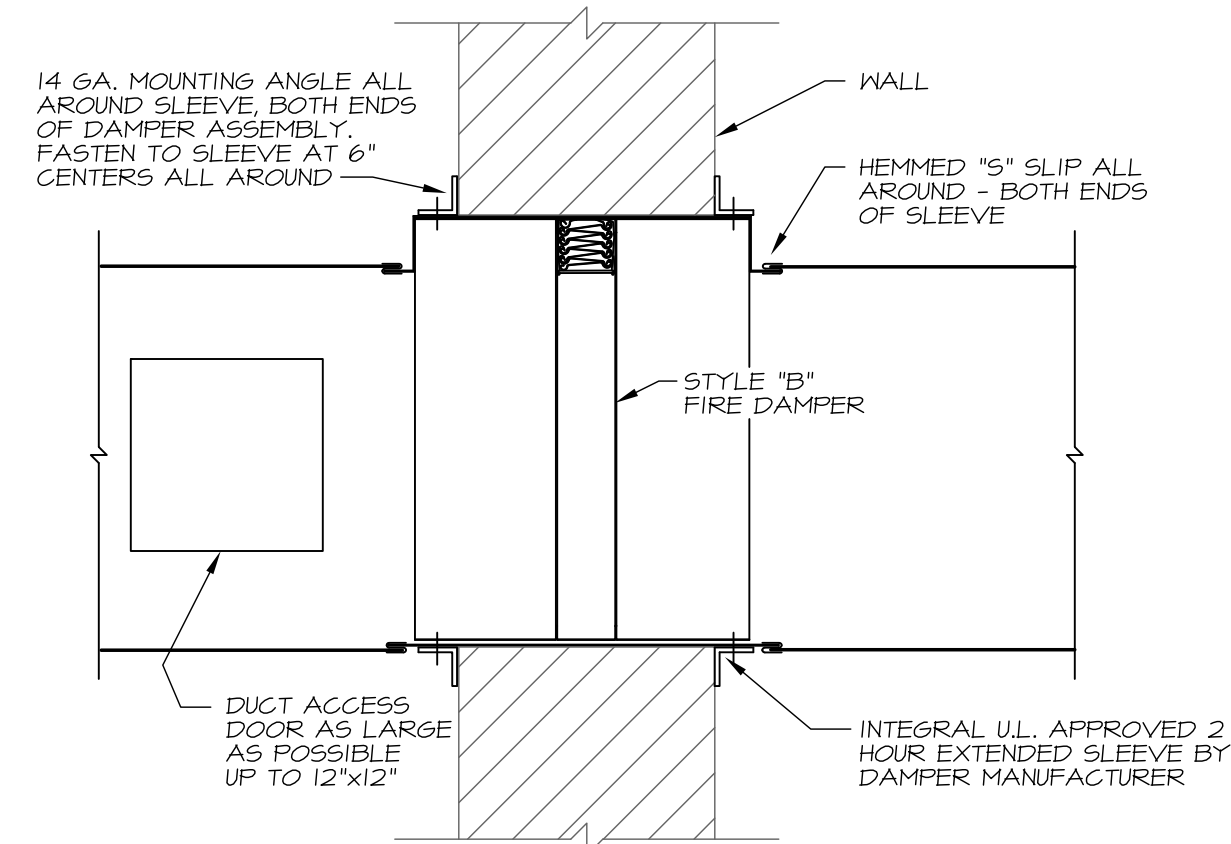


SEE PLANS FOR DUCT AND DAMPER SIZING

2 WALL FIRE DAMPER STYLE "B"
NO SCALE

REPLACE EXISTING SELF-CONTAINED C.V.'s IN FINNED TUBE COVERS w/NEW LOW VOLTAGE VALVES. PROVIDE NEW TWO POSITION REMOTE DIGITAL T'STATS WHERE SHOWN. EXACT LOCATIONS OF VALVES IN APARTMENTS IS ESTIMATED. FINNED TUBE IS SIMILAR TO STERLING "SENIOR" BASEBOARD.

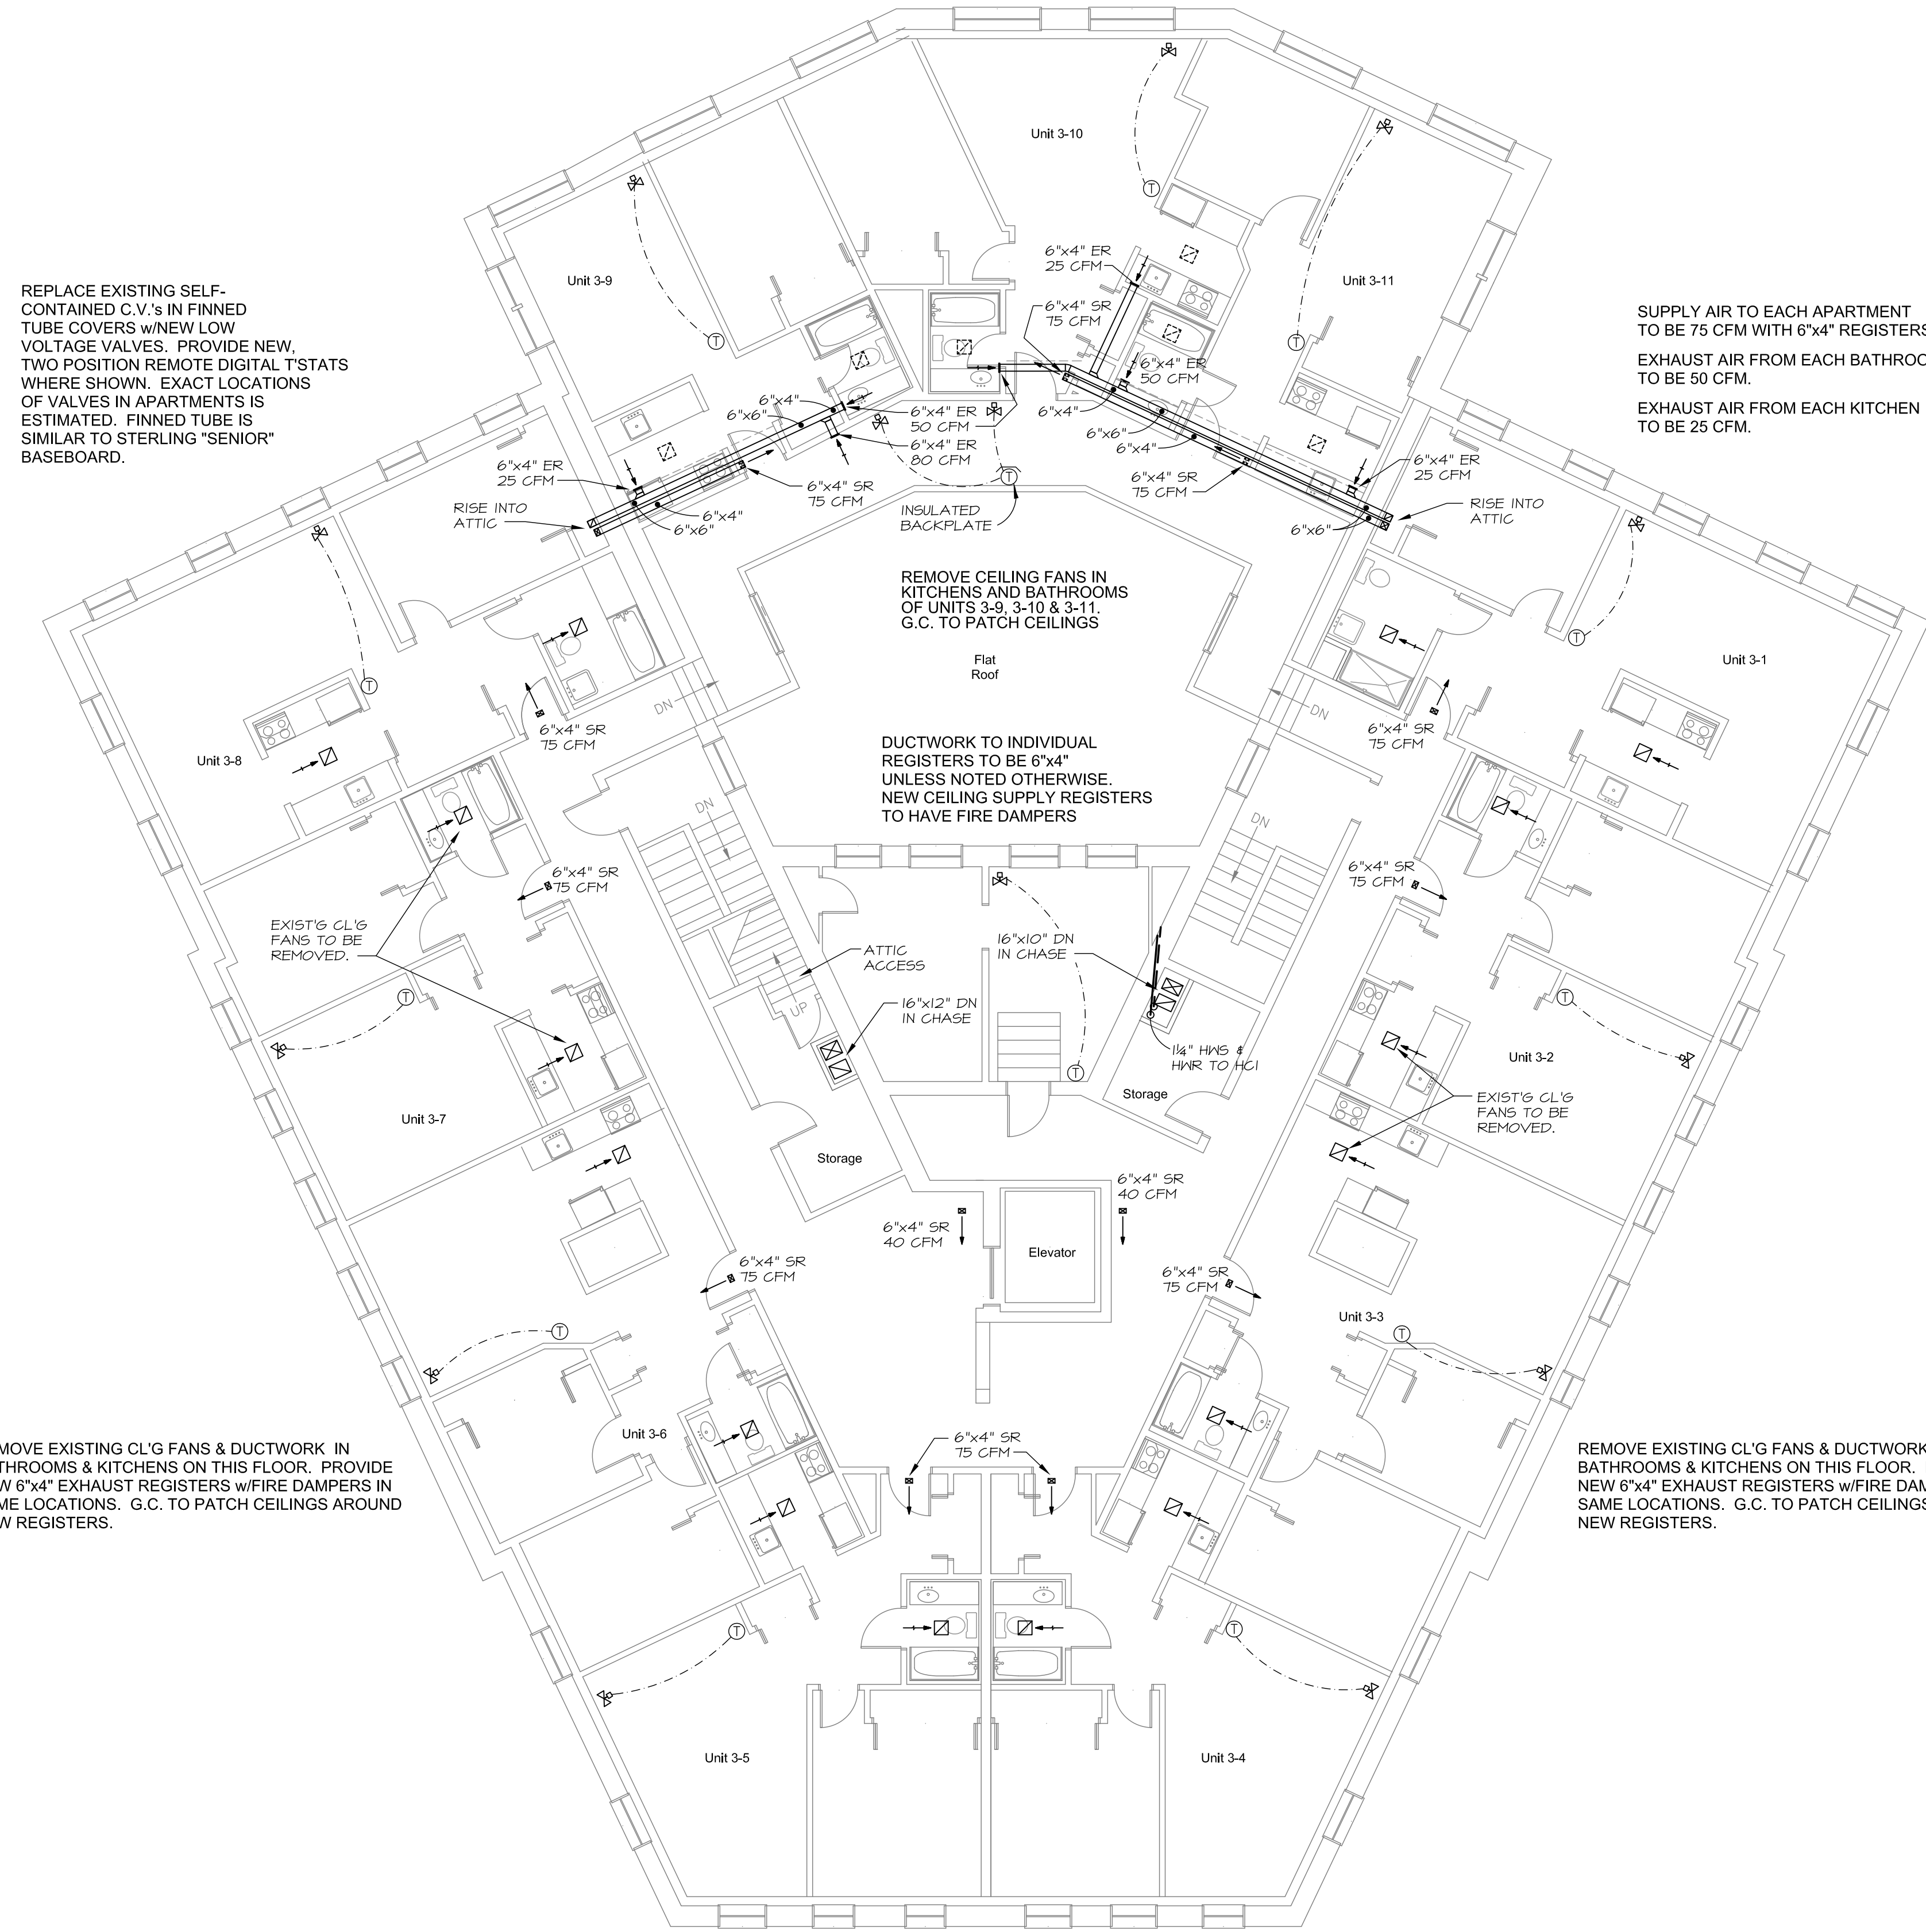

3 LEVEL 3 MECHANICAL PLAN
SCALE: 1/8" = 1'-0"

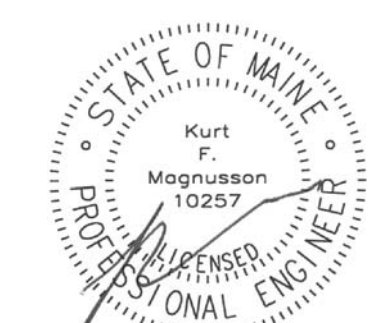

MECHANICAL SYSTEMS ENGINEERS
ROYAL RIVER CENTER, UNIT 108
10 FOREST FALLS DRIVE, YARMOUTH, MAINE 04096
(207) 846-1441
FACEBOOK: MECHANICAL SYSTEMS ENGINEERS
© COPYRIGHT 2015



PERMIT SET

revisions

date
January 17, 2015

sheet title

butler
level 3
mechanical plan

scale

1/8" = 1'-0"

drawn by

R.E.M.

project number

butpay

BM4