

project name

Butler Payson
pine st.
state st.
portland, me

avesta housing


goduti/thomas architects

44 oak st.

portland, maine 04101

ph. 207-775-3184

fax 207-774-0486

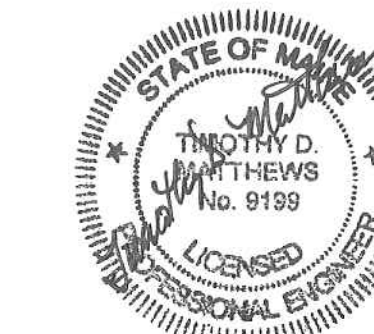

SWIFTCURRENT
Engineering Services
10 Forest Falls Dr. Unit 4b
Yarmouth, ME 04096
Tel: (207) 847-9280

ISSUED FOR PERMIT

revisions

date

Feb. 6, 2015

sheet title

ELECTRICAL FLOOR PLAN -
THIRD FLOOR


scale: as shown

drawn by:JMD checked by:TDM

project number

NOTES:

1. SEE E0.0 FOR LEGEND, ABBREVIATIONS AND GENERAL NOTES.
2. REPLACE EXISTING CORRIDOR LIGHTS IN PLACE WITH NEW FIXTURES. REWIRE TO EXISTING CIRCUITS AND CONTROLS.

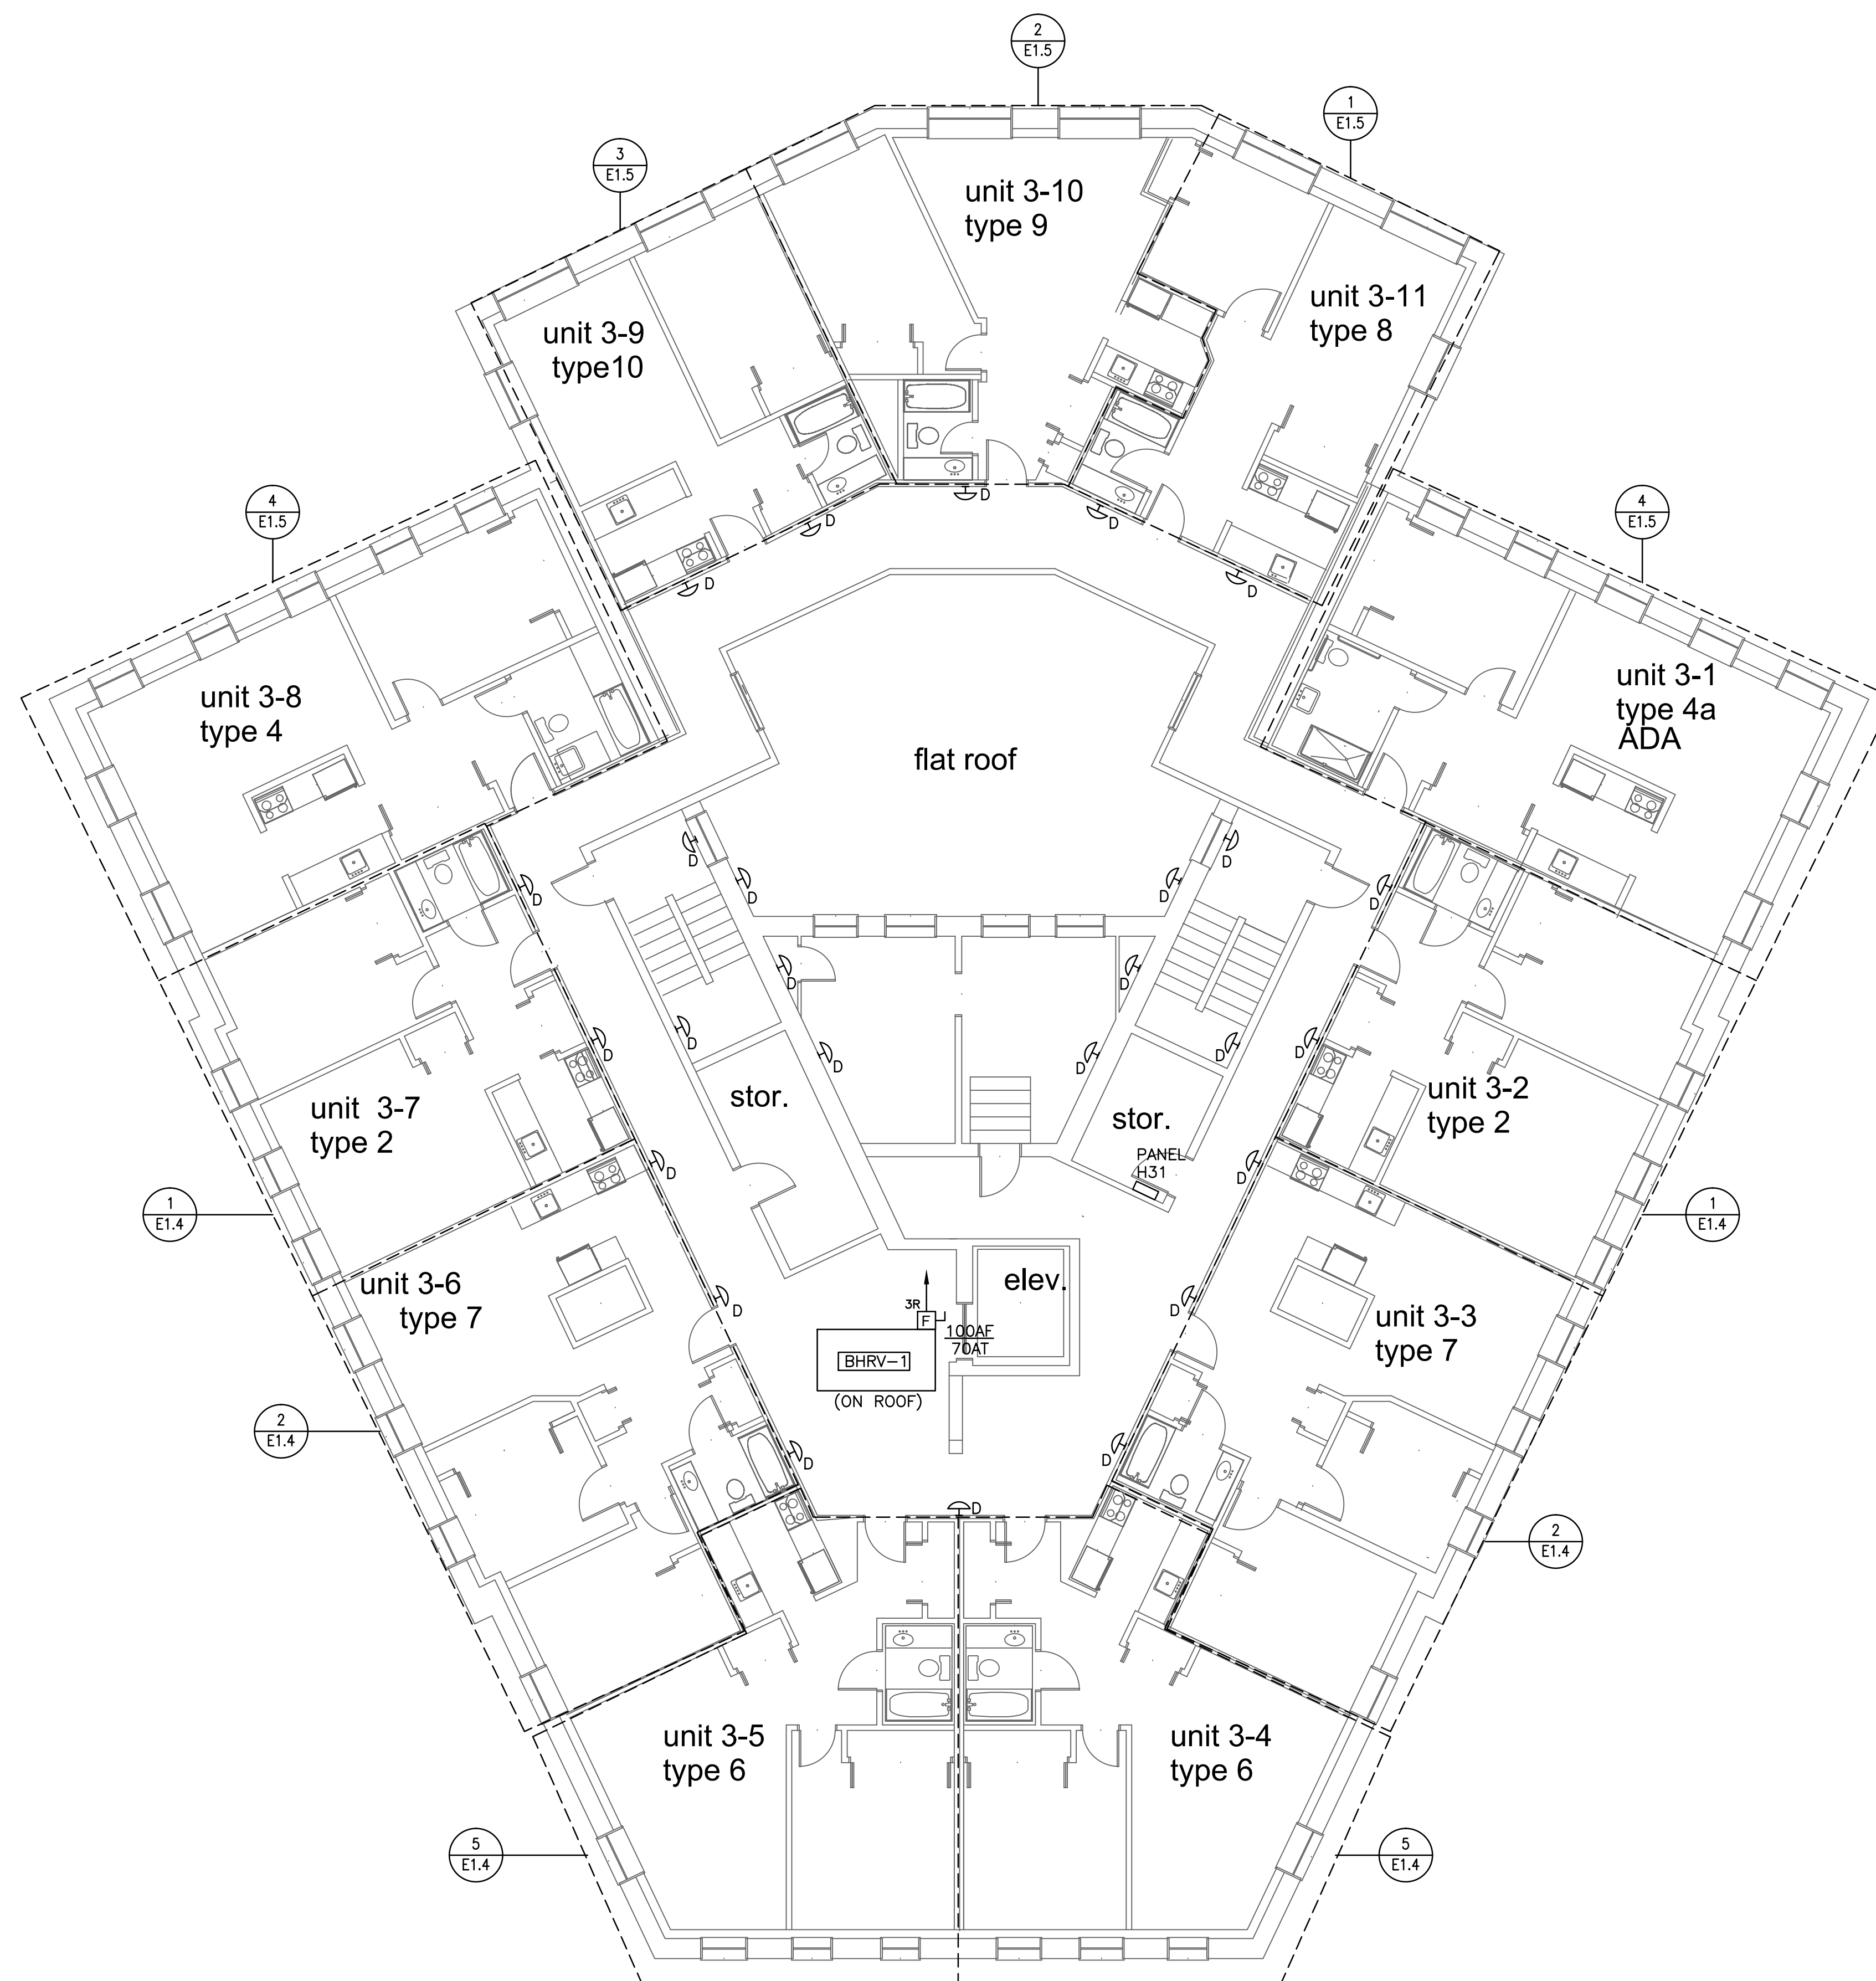

1 ELECTRICAL POWER & SYSTEMS PLAN - THIRD FLOOR
SCALE: 1/8"=1'

BE1.3