

project name

Butler Payson
pine st.
state st.
portland, me

NOTES:

- SEE E0.0 FOR LEGEND, ABBREVIATIONS AND GENERAL NOTES.
- THE ADD ALTERNATE IS TO REPLACE THE EXISTING WESTINGHOUSE/ARROW-HART MAIN PANEL AND REPLACE WITH NEW METER PANEL.

avesta housing


goduti/thomas architects

44 oak st.

portland, maine 04101

ph. 207-775-3184

fax 207-774-0486

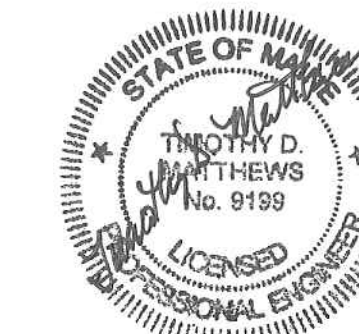

SWIFTCURRENT
Engineering Services
10 Forest Falls Dr. Unit 4b
Yarmouth, ME 04096
Tel: (207) 847-9280

ISSUED FOR PERMIT

revisions

date

Feb. 6, 2015


sheet title

EXISTING ELECTRICAL ONE-LINE DIAGRAMS

scale: as shown

drawn by:JMD checked by:TDM

project number

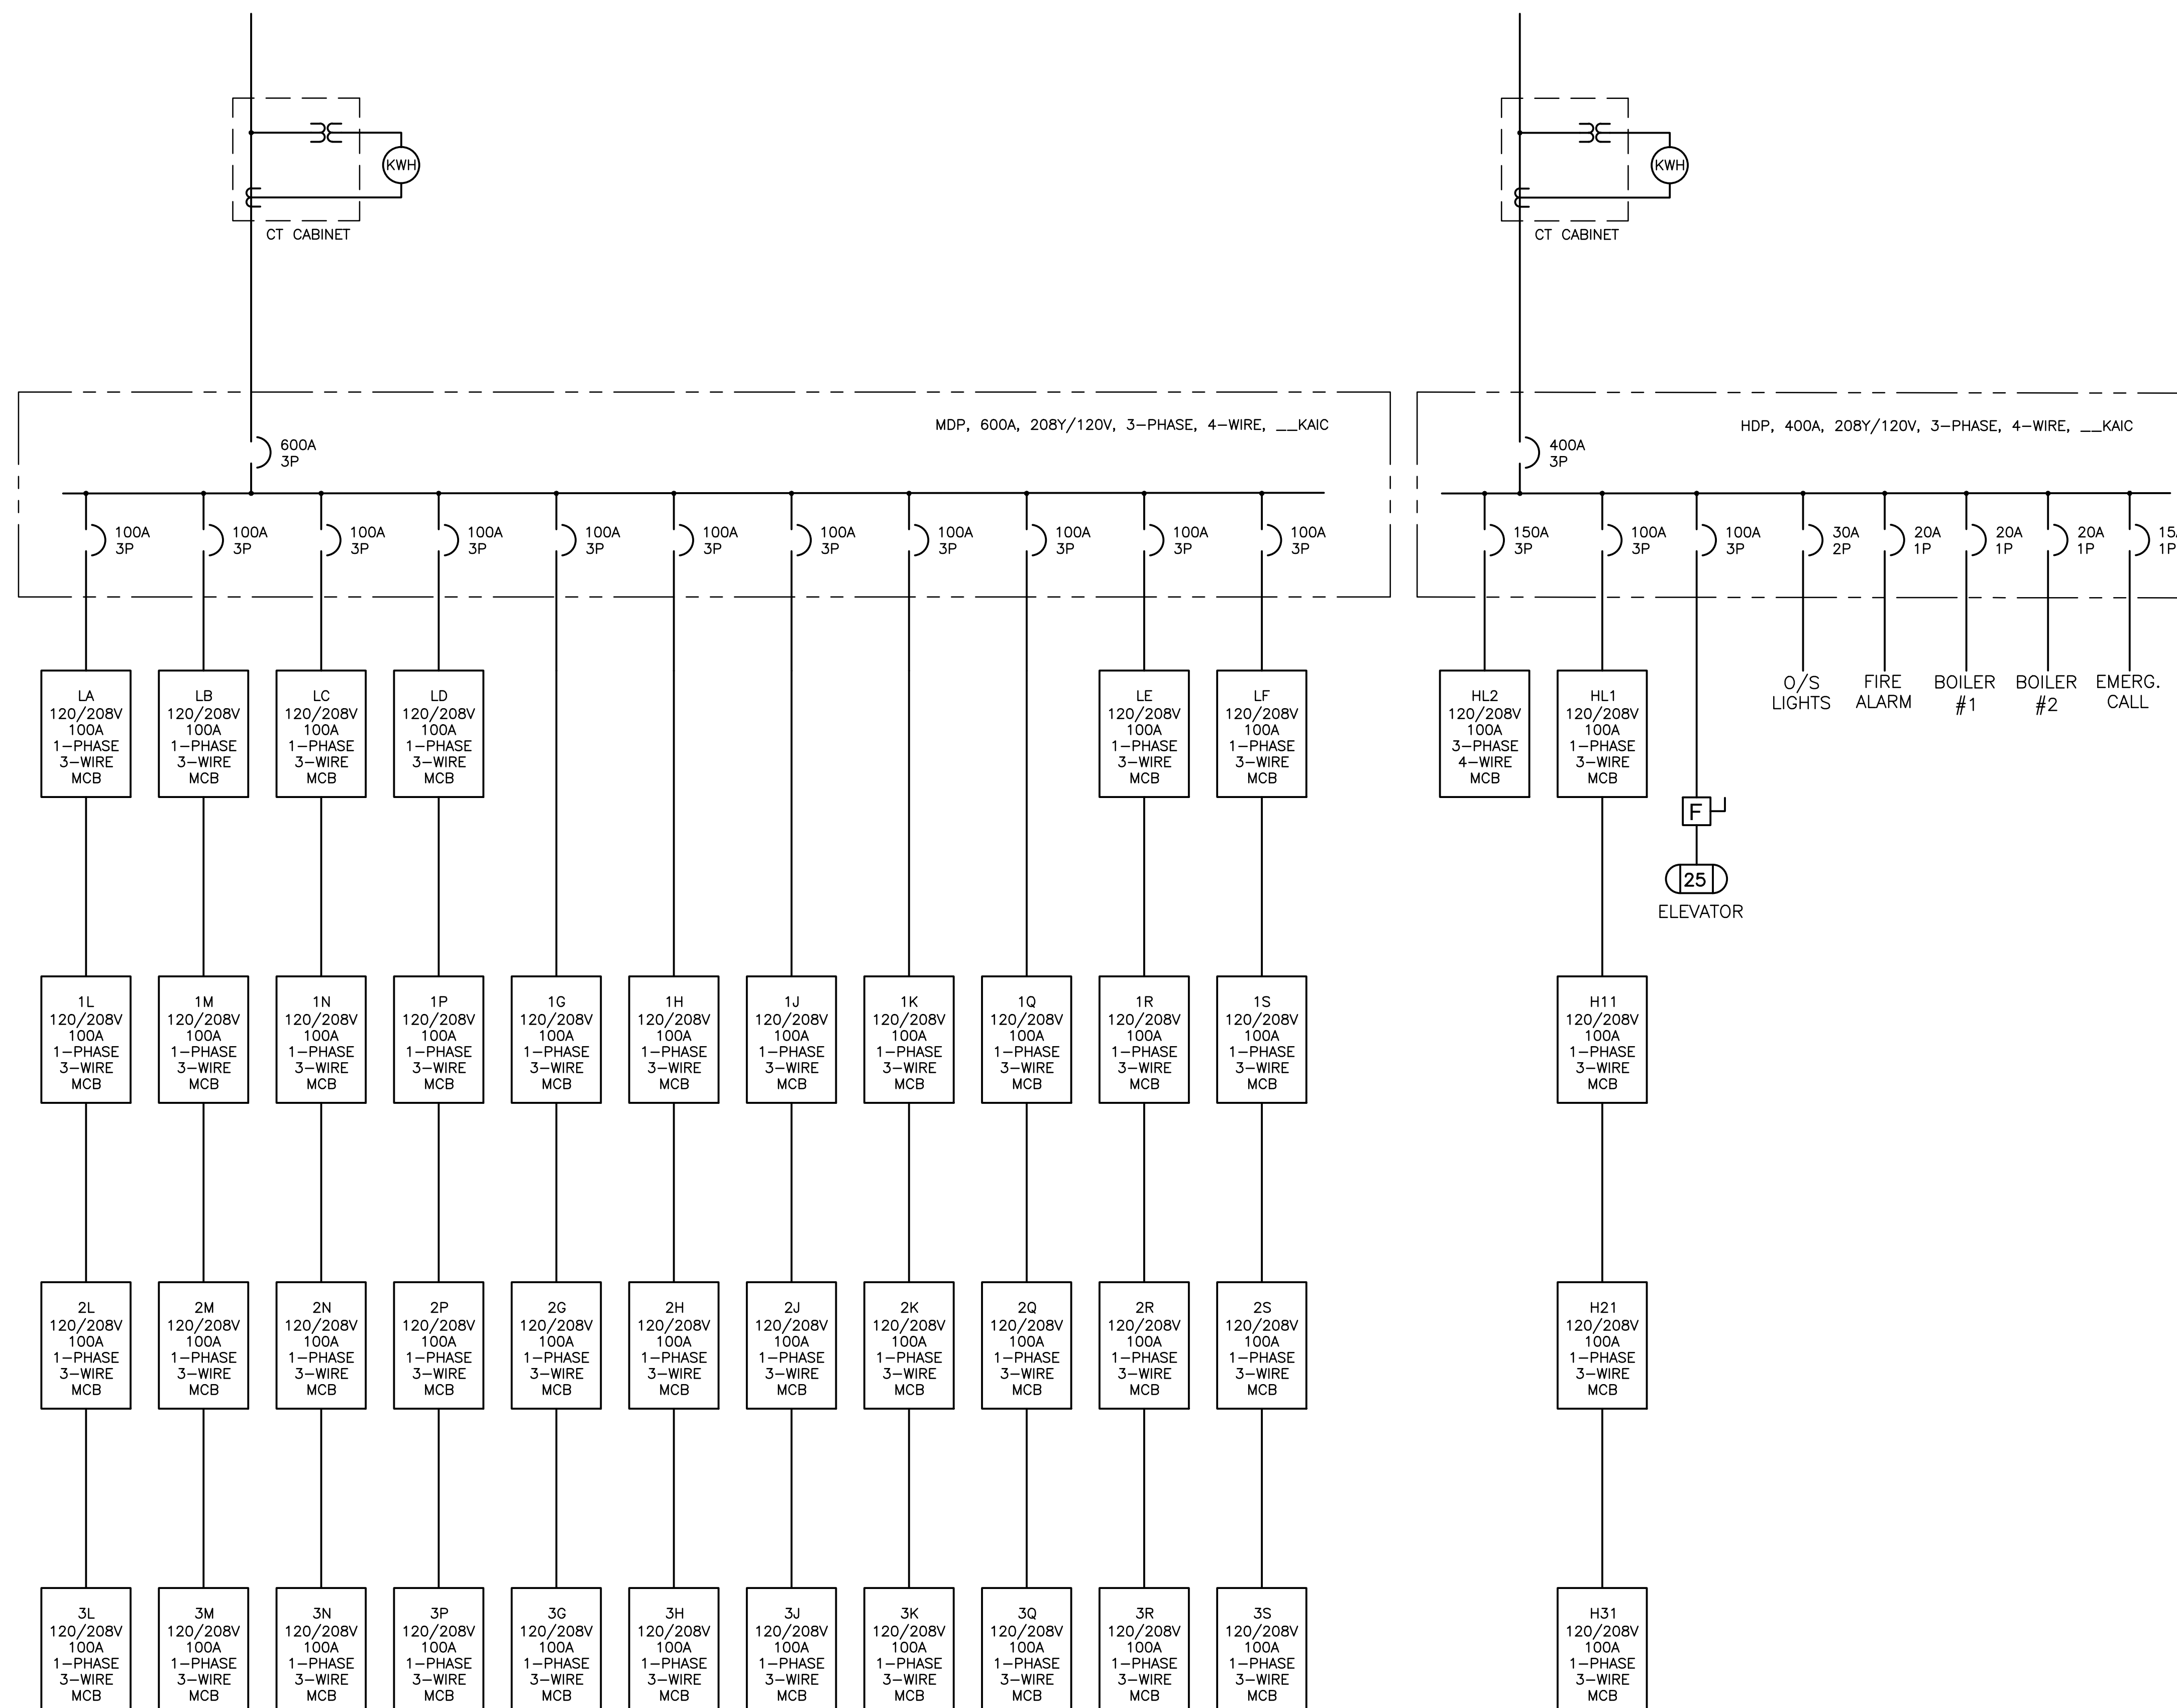

1 EXISTING ELECTRICAL ONE-LINE DIAGRAM
SCALE: NOT TO SCALE

BE1.7