

Project Title
**BRACKETT ST.
 RESIDENCE
 RENOVATIONS**
 PORTLAND, MAINE

HA Project No. **03171**

Key Plan 

KEY NOTES:

P01...
 TO TELEPHONE BACKBOARD IN BASEMENT.

P02...
 RECEPTACLE TO BE MOUNTED UNDER COUNTER
 FOR DISHWASHER. COORDINATE EXACT LOCATION
 WITH EQUIPMENT FURNISHED.

10-18-04 ISSUED FOR BID

Mark	Date	Description

Issue Dates

Drawing Status


Drawing Title

**ELECTRICAL
 FLOOR PLANS
 POWER AND SYSTEMS**

PA / PE: **PRM** Drawn By: **PRA/JMB**

Drawing Number

E20.1

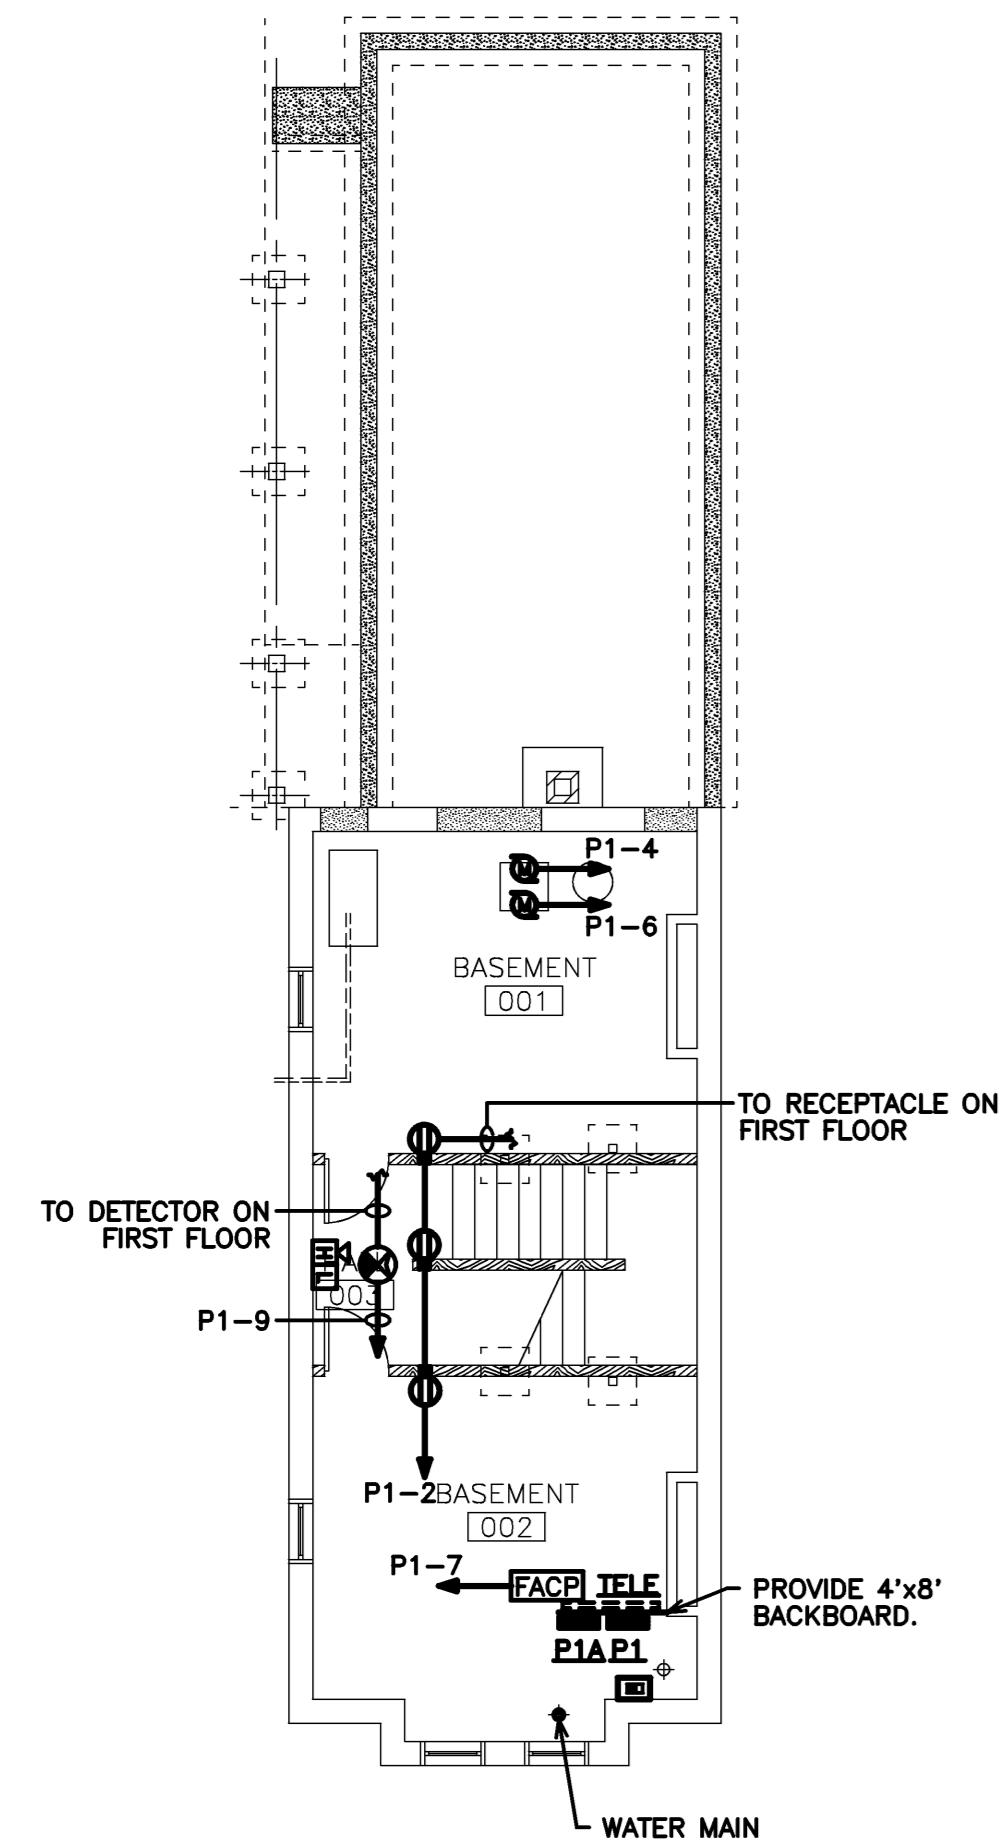

BASEMENT PLAN

1/8" = 1'-0"  REF: NA

A4

FIRST FLOOR PLAN

1/8" = 1'-0"  REF: NA

A3

SECOND FLOOR PLAN

1/8" = 1'-0"  REF: NA

A2

THIRD FLOOR PLAN

1/8" = 1'-0"  REF: NA

A1