

AXAM engineering, inc.  
CONSULTING ENGINEERS  
1000 State Street, Portland, Maine 04101  
Tel: (207) 761-0155 Fax: (207) 761-0155

Owner:  
MAINE WORKFORCE HOUSING, LLC  
One Longfellow Square, Portland, Maine 04101  
(207) 871-9811 Fax (207) 761-0155

Project:  
WALKER TERRACE  
Walker Street,  
Portland, Maine 04101


ARCHETYPE, P.A.  
ARCHITECTS  
48 Union Wharf Portland, Maine 04101  
(207) 772-6022 Fax (207) 772-4056

WALKER TERRACE  
ELECTRICAL  
UNIT TYPES "G" THRU "K" TYPICAL  
LIGHTING/POWER PLANS


Date: 7-12-05  
Scale: AS NOTED  
Drawn By: CLC  
Checked By: AWM  
Revisions:

E4


FOR  
SUBMISSION  
7-12-05

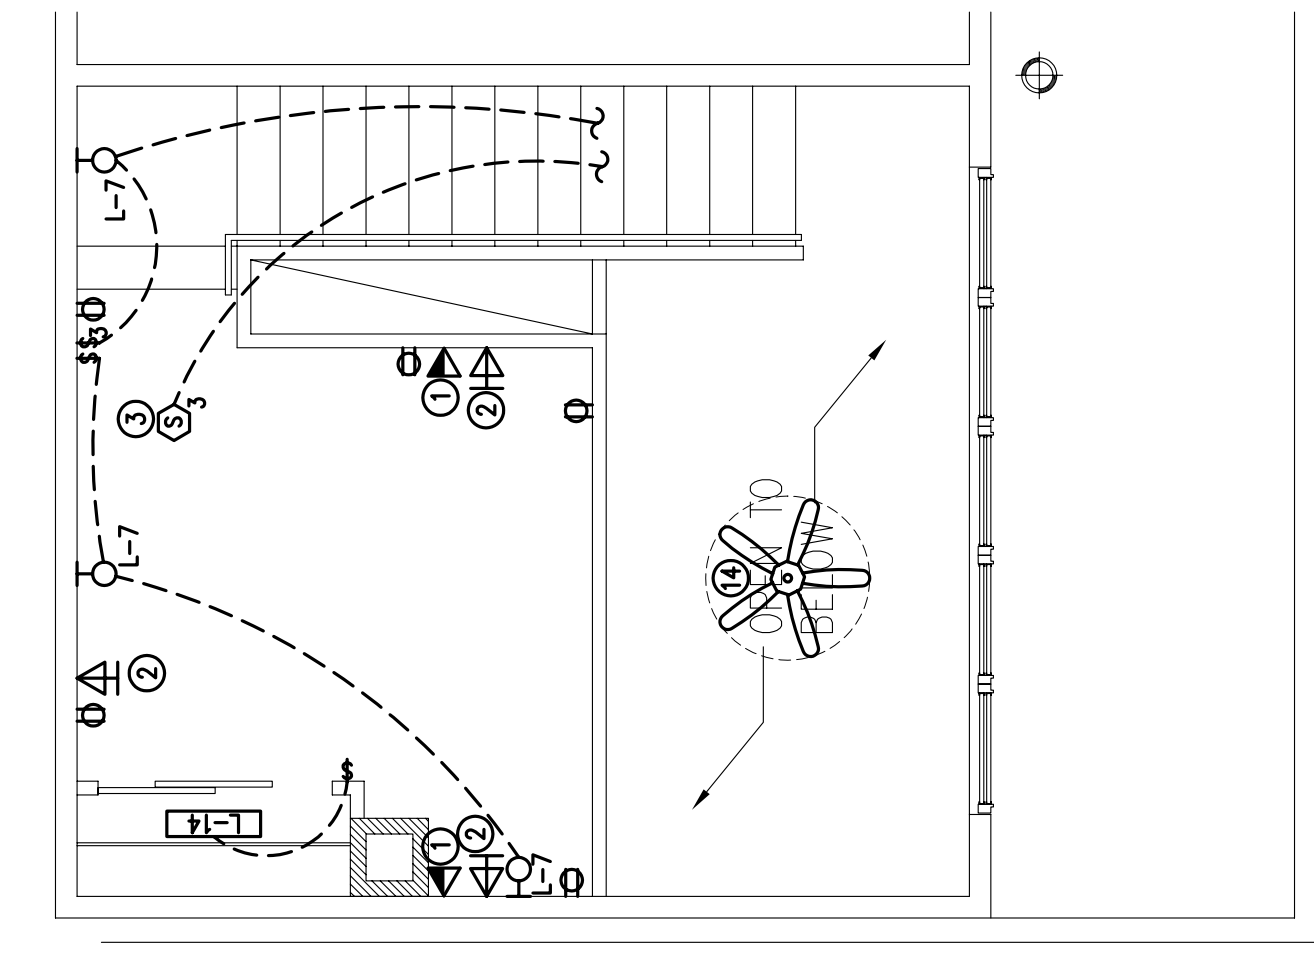


1 TYPICAL UNIT TYPE "I" - (UPPER FLOOR) ELECTRICAL PLAN  
SCALE: 1/4"=1'-0"

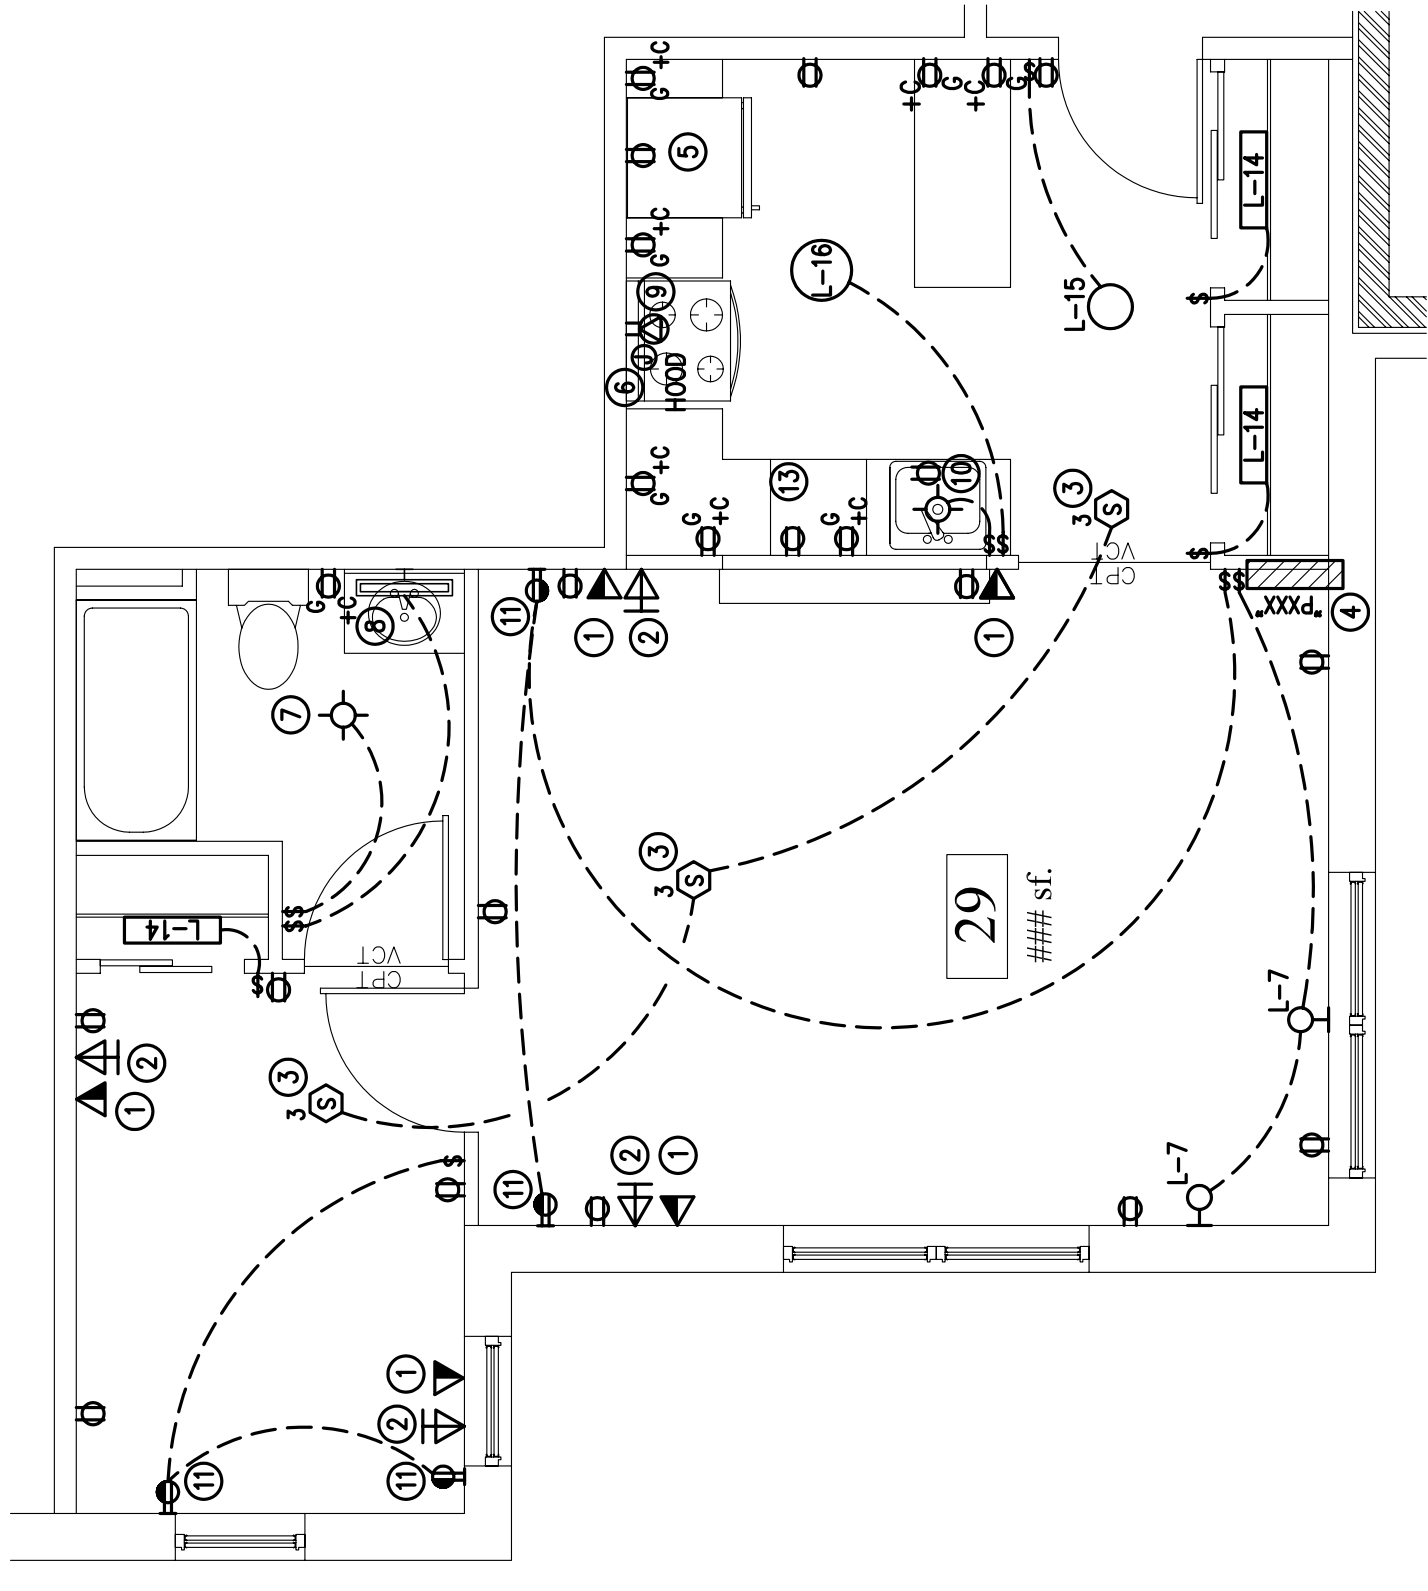


6 TYPICAL UNIT TYPE "G" - ELECTRICAL PLAN  
SCALE: 1/4"=1'-0"

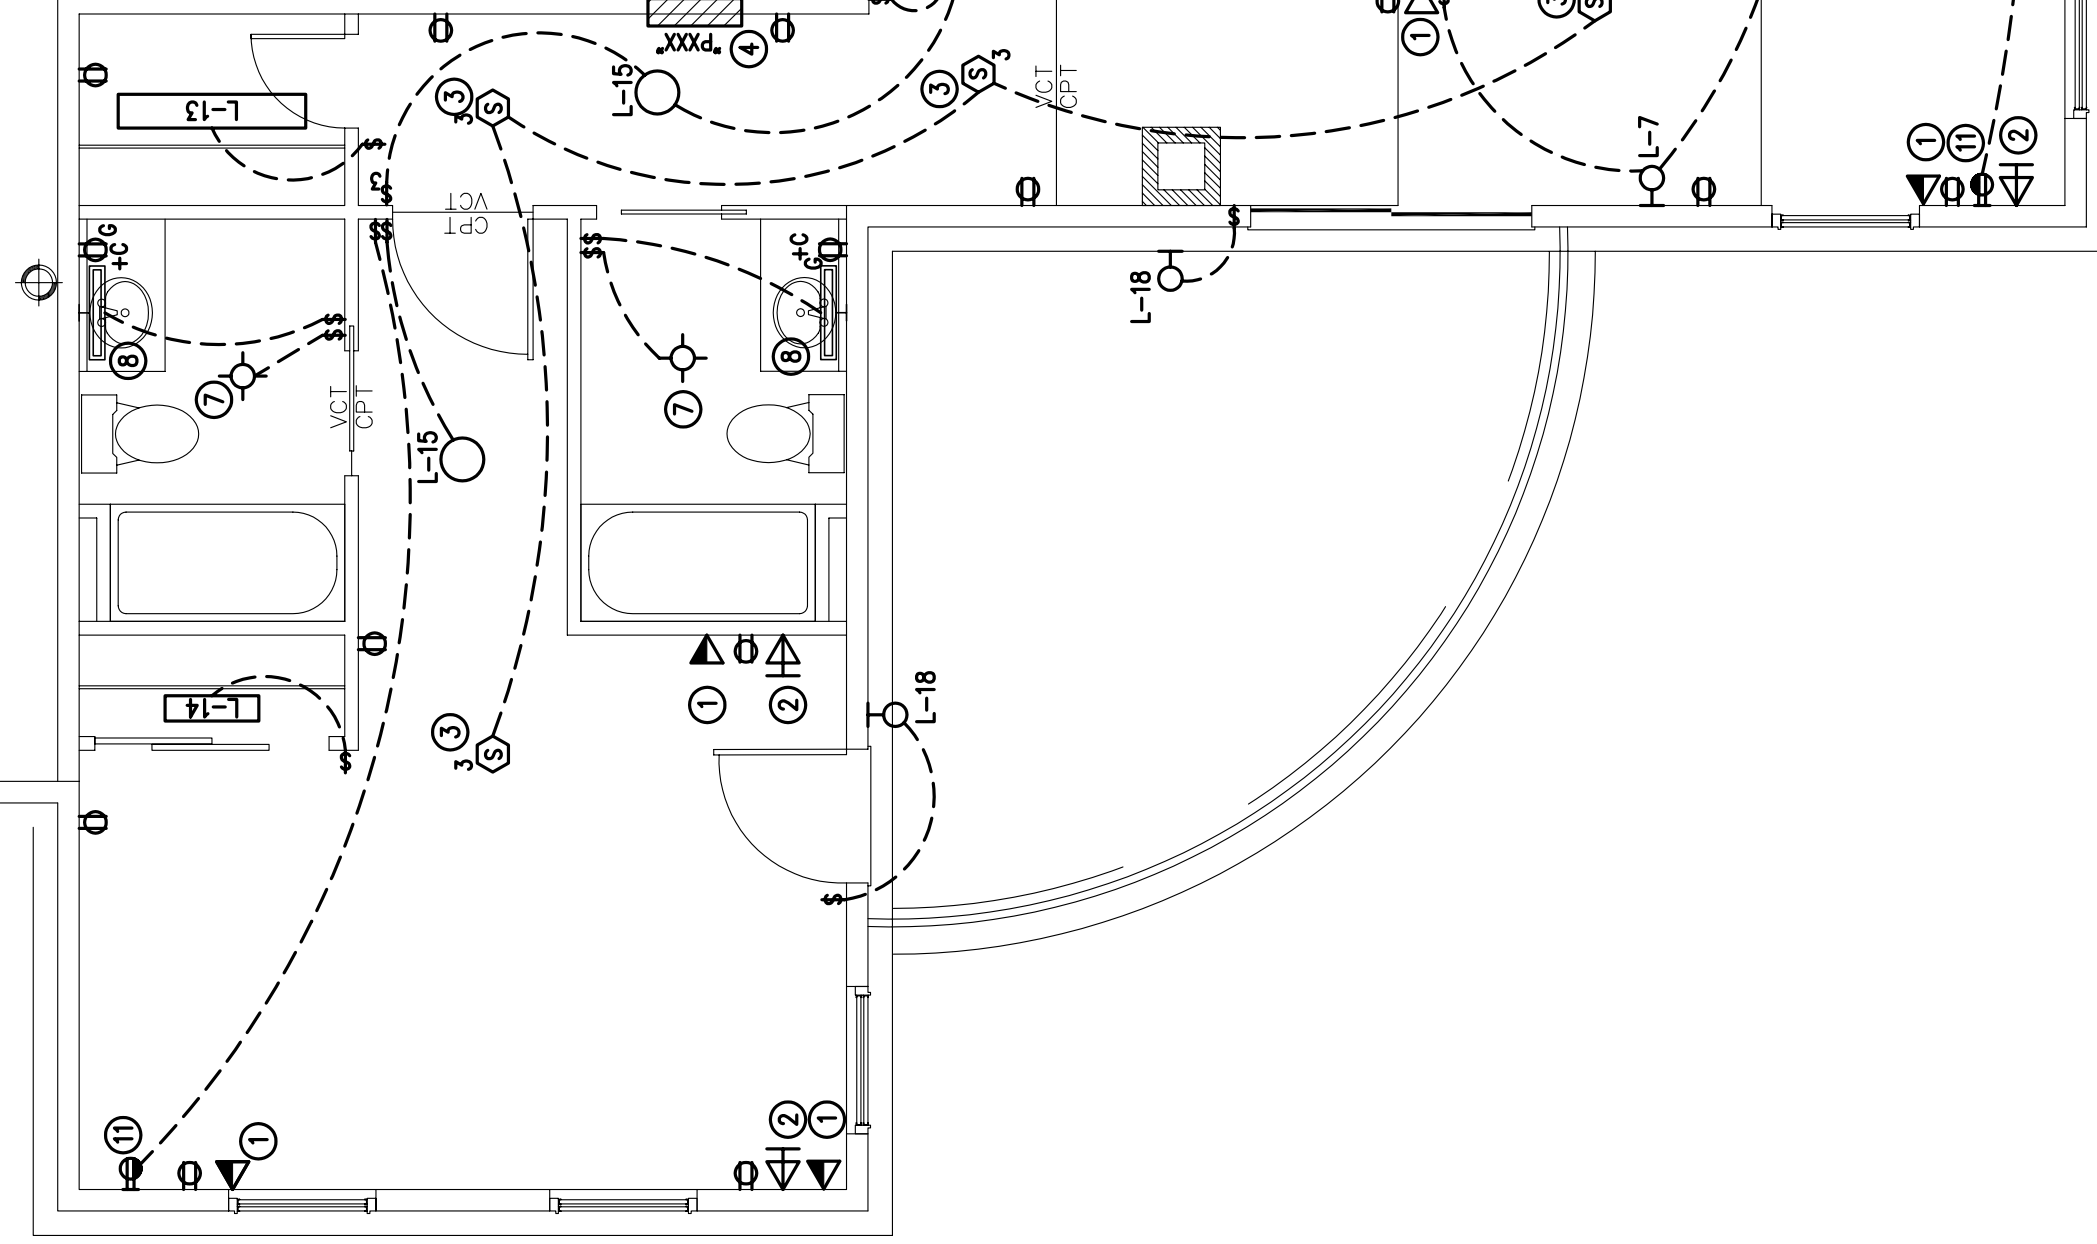


2 TYPICAL UNIT TYPE "J" - (LOWER FLOOR) ELECTRICAL PLAN  
SCALE: 1/4"=1'-0"

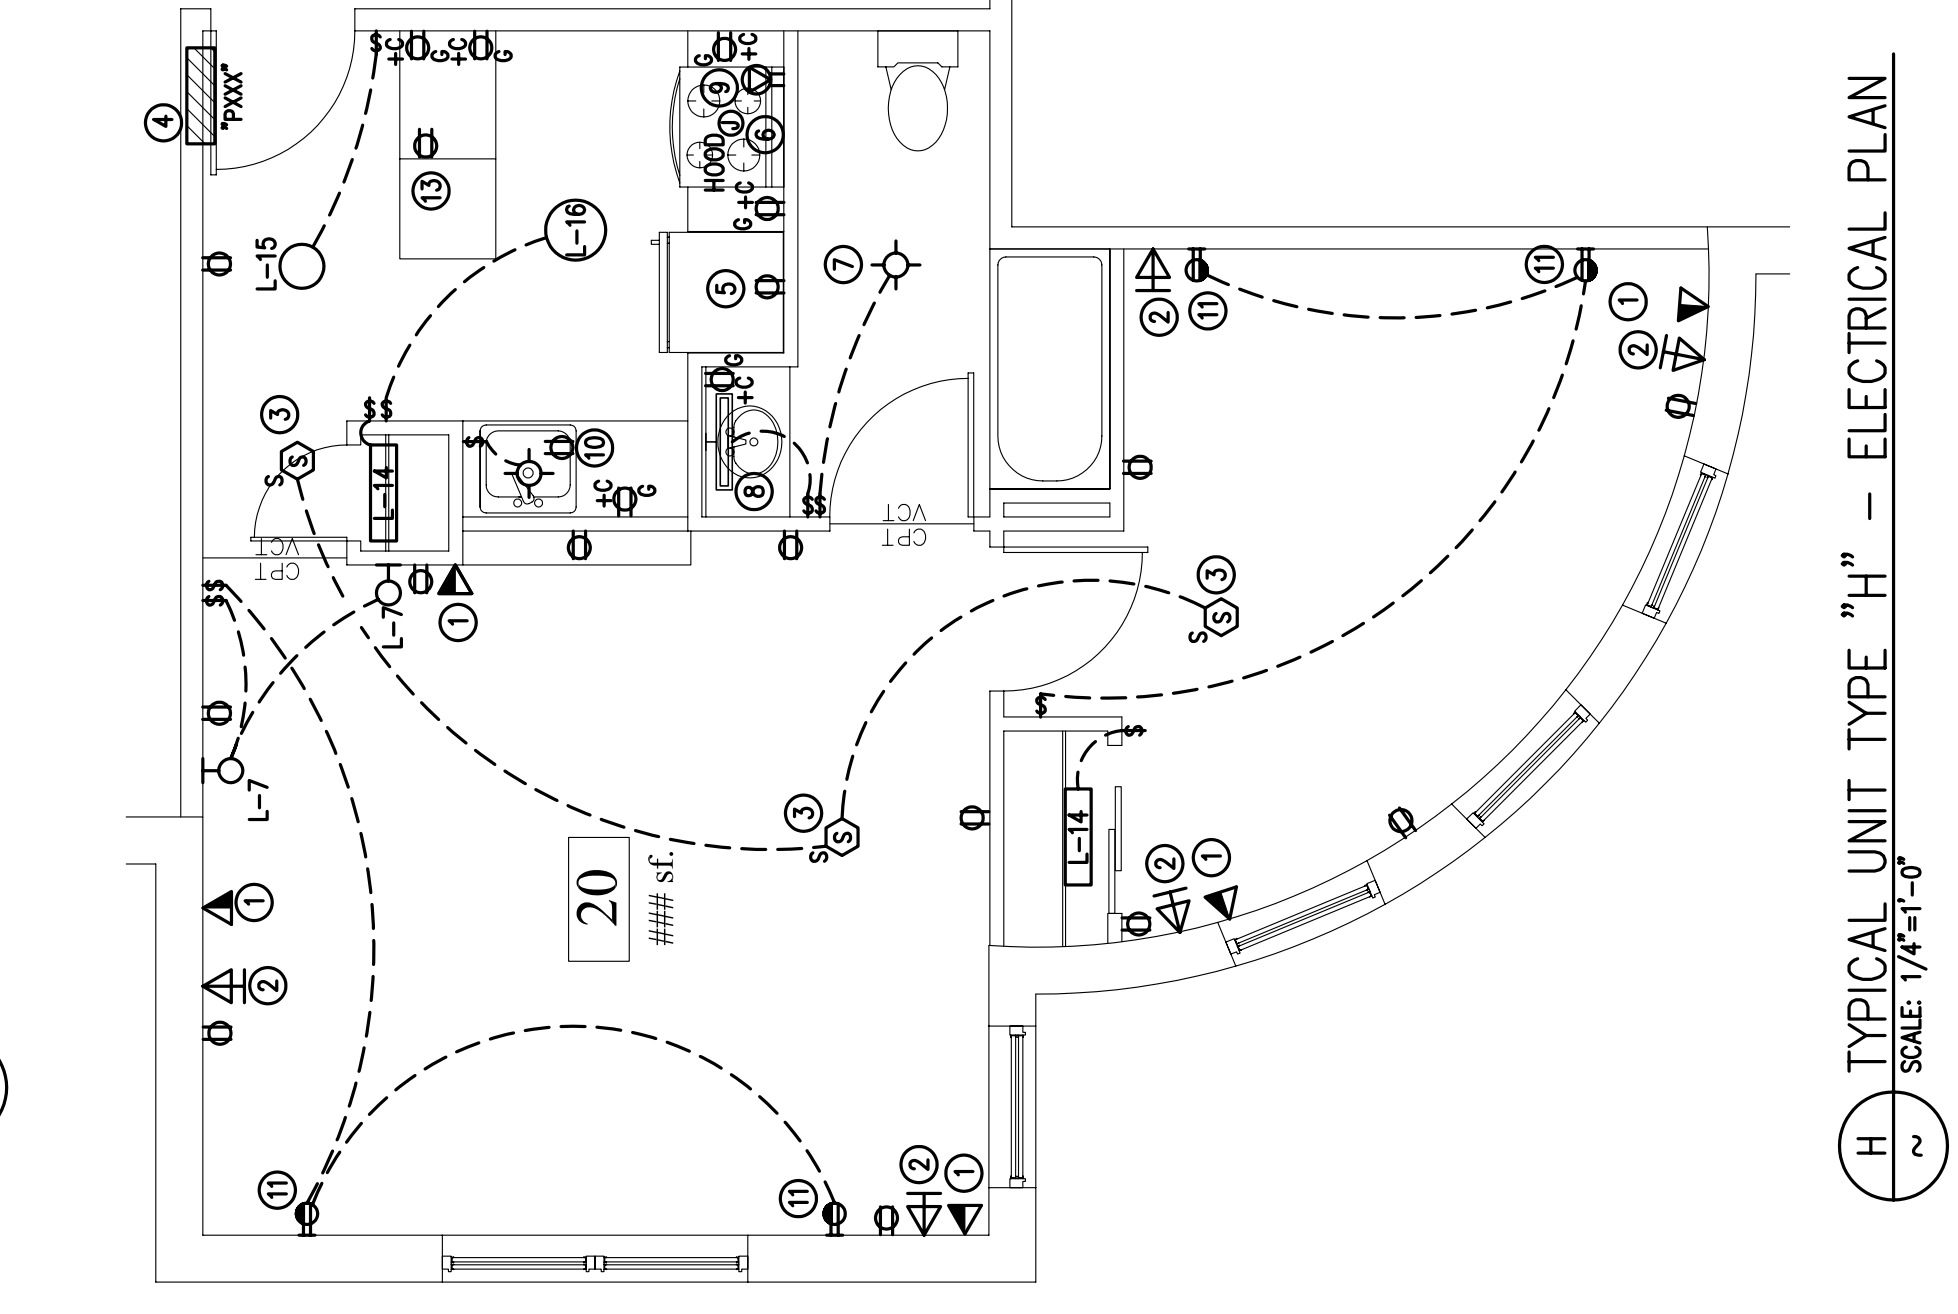


8 TYPICAL UNIT TYPE "H" - ELECTRICAL PLAN  
SCALE: 1/4"=1'-0"

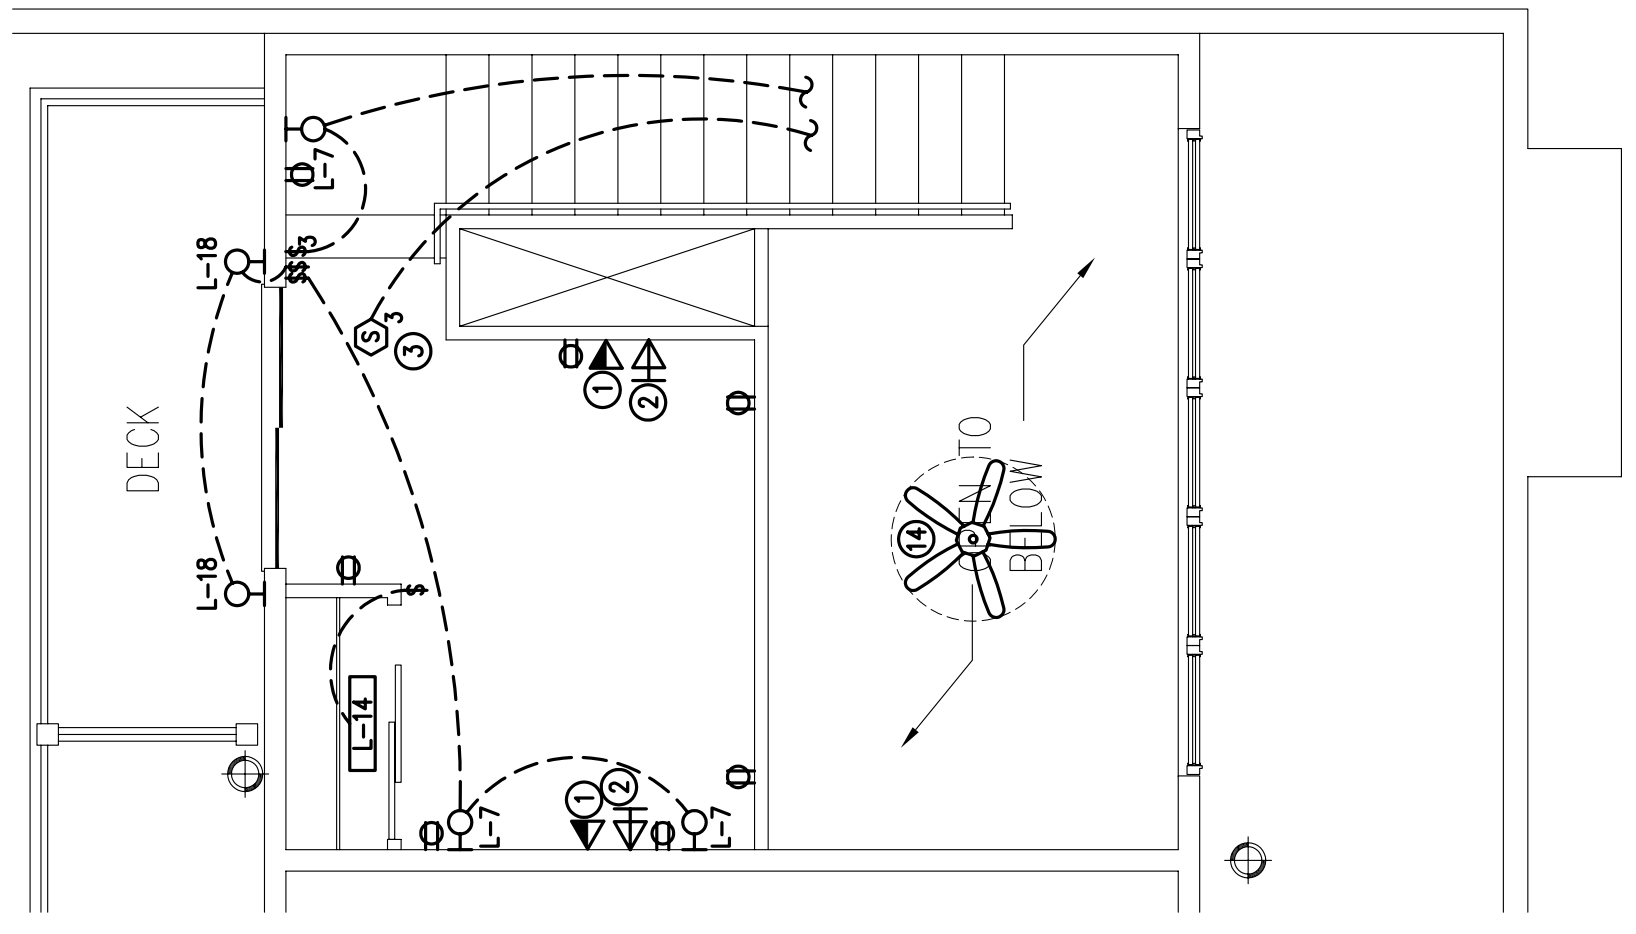

3 TYPICAL UNIT TYPE "K" - (UPPER FLOOR) ELECTRICAL PLAN  
SCALE: 1/4"=1'-0"

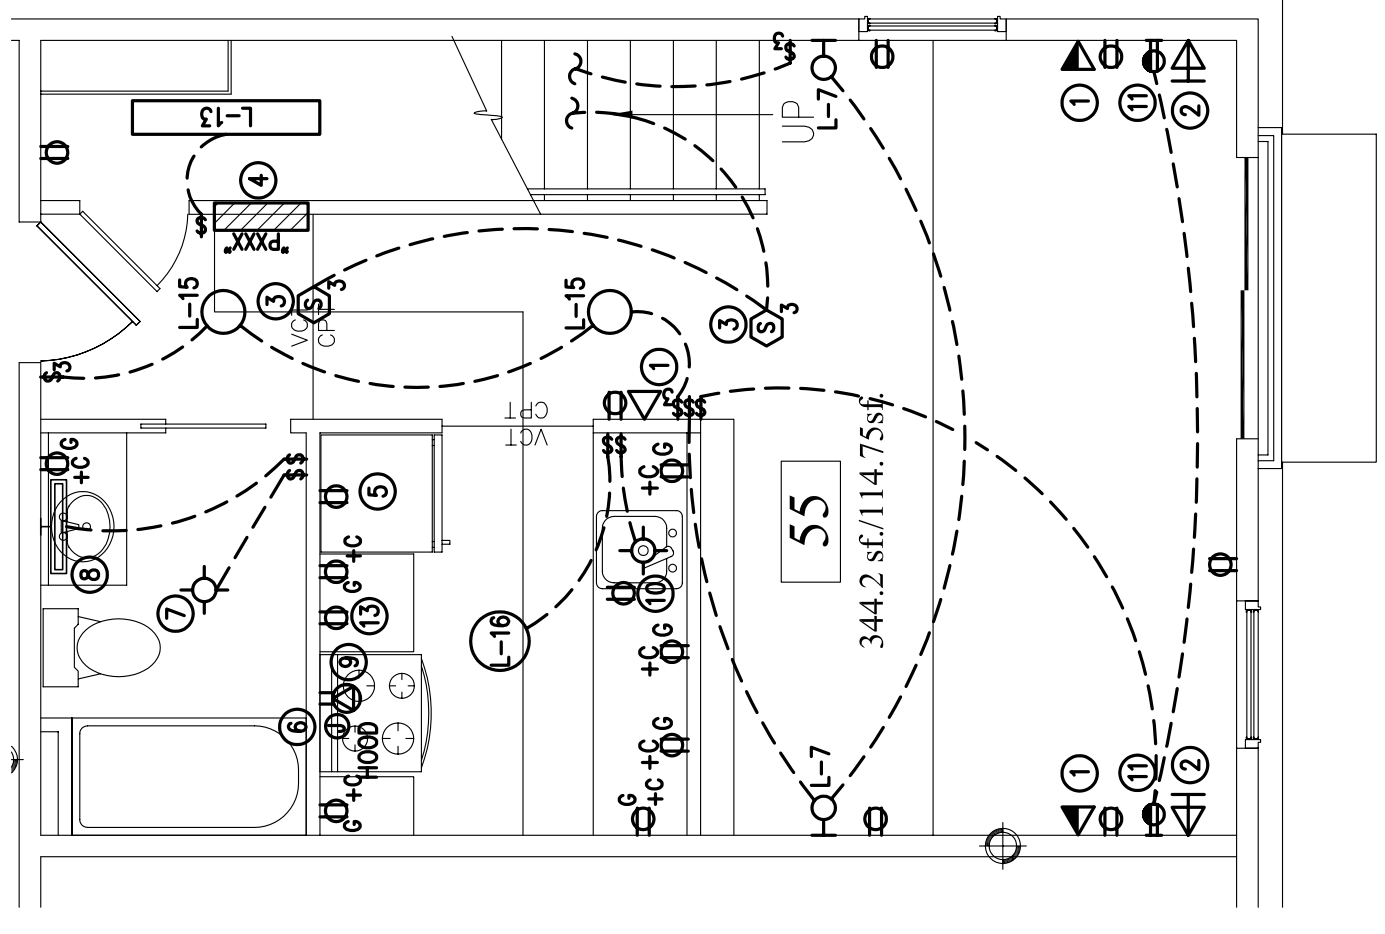

2 TYPICAL UNIT TYPE "J" - (LOWER FLOOR) ELECTRICAL PLAN  
SCALE: 1/4"=1'-0"

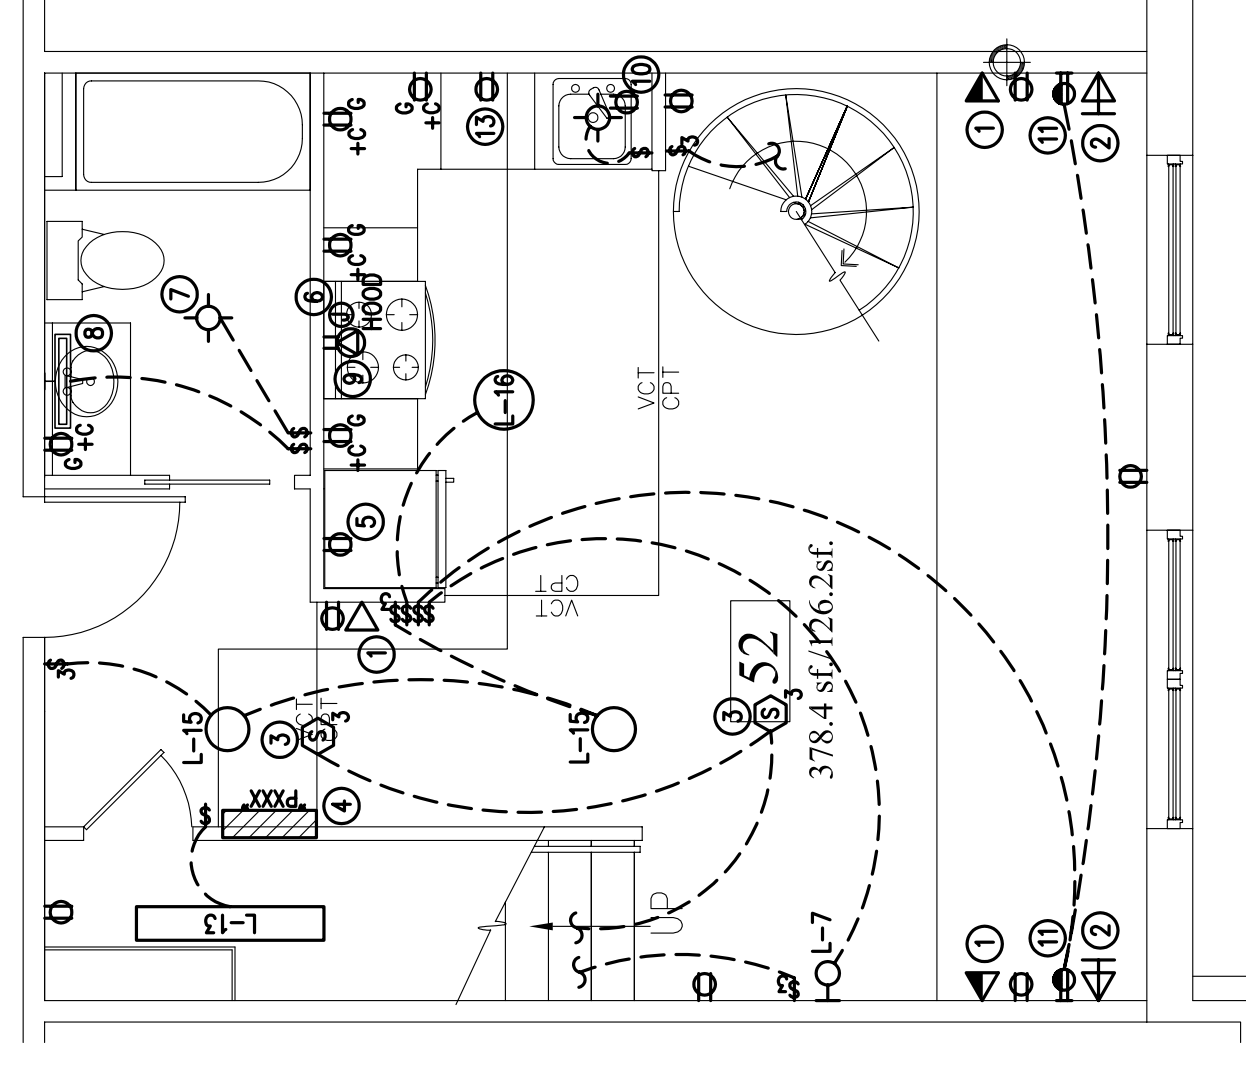

3 TYPICAL UNIT TYPE "K" - (LOWER FLOOR) ELECTRICAL PLAN  
SCALE: 1/4"=1'-0"

NOTE:  
FOR KEY NOTES LEGEND SEE DWG. E-3.