



WALKER TERRACE
ELECTRICAL - UNIT TYPE "L"
AND 2nd THRU 4th FLOOR
LIGHTING/POWER PLANS

Date:	7-12-05
Drawn By:	CLC
Checked By:	AWM
Scale:	AS NOTED
Revisions:	


ARCHETYPE, P.A.
ARCHITECTS
48 Union Wharf Portland, Maine 04101
(207) 772-6022 Fax (207) 772-4056

Project:
WALKER TERRACE
Walker Street,
Portland, Maine 04101

Owner:
MAINE WORKFORCE HOUSING, LLC
One Longfellow Square, Portland, Maine 04101
(207) 871-9811 Fax (207) 761-0155

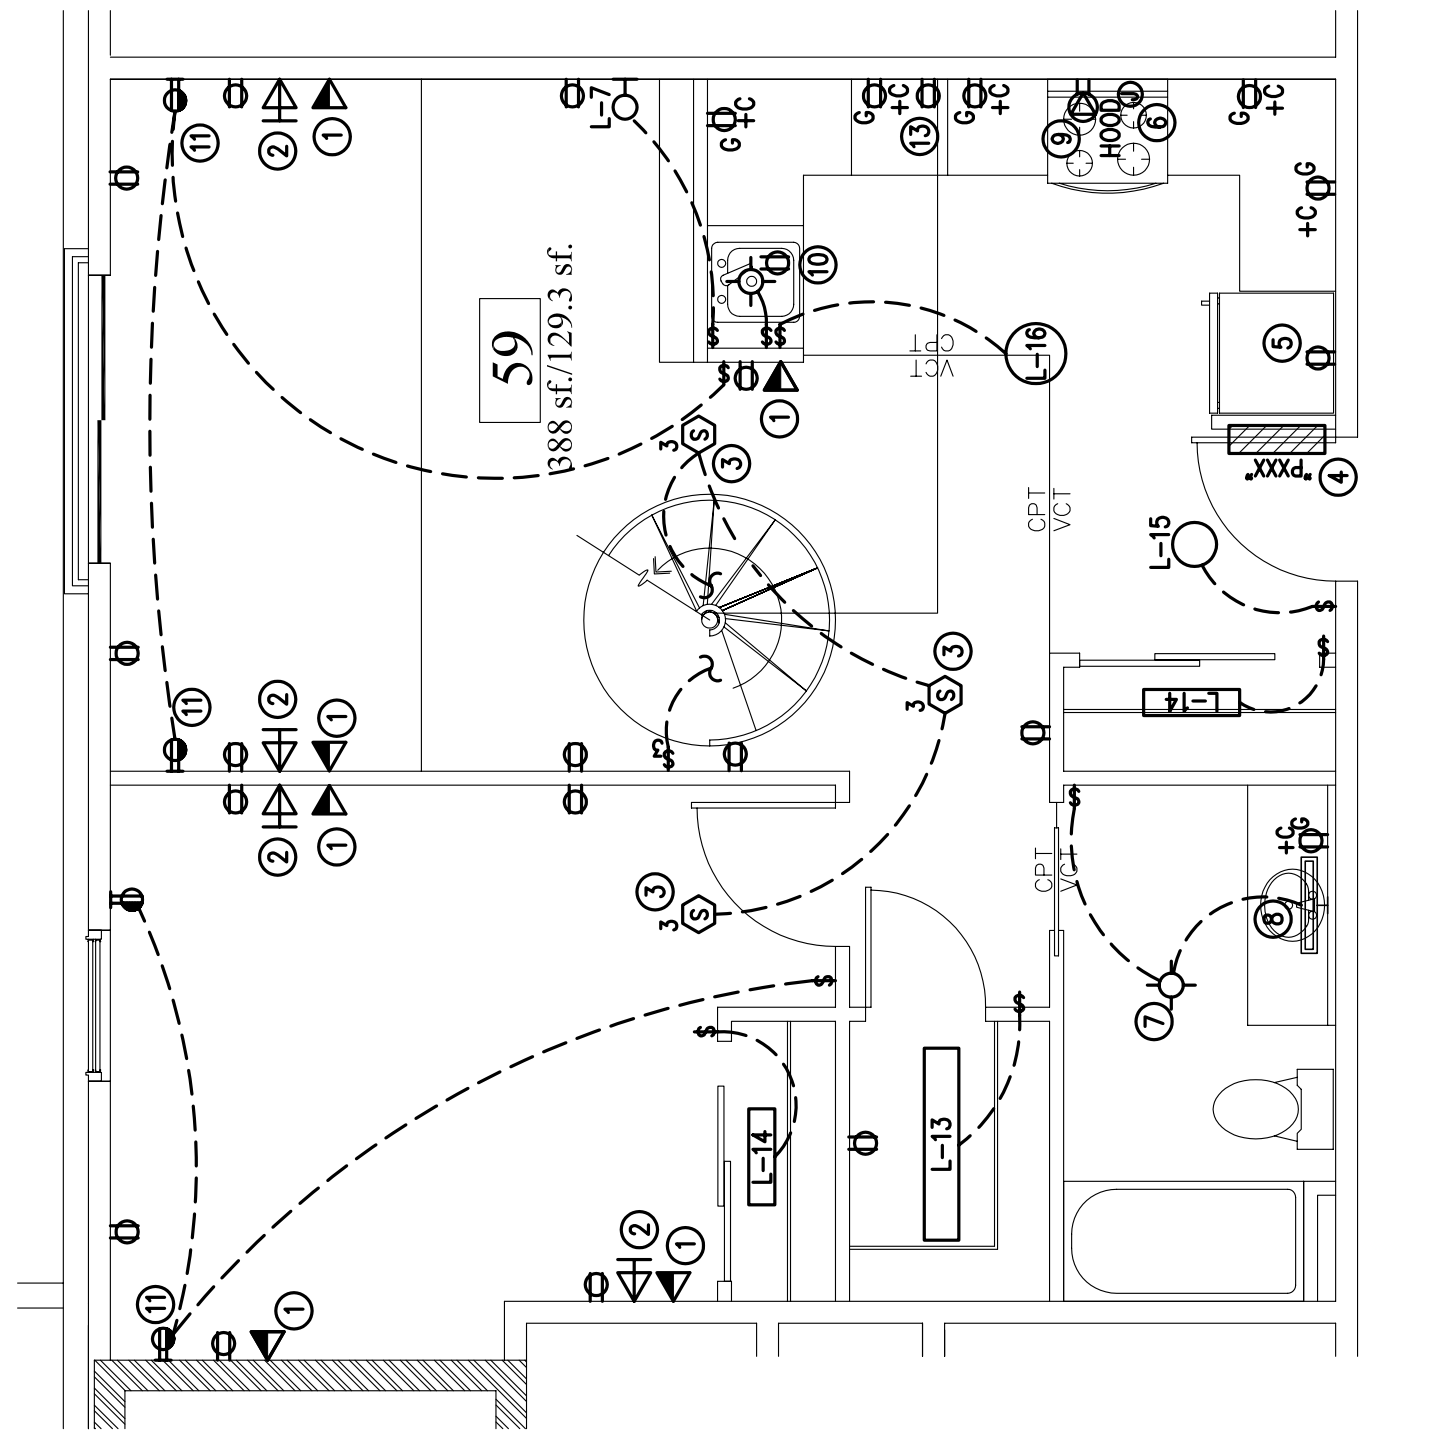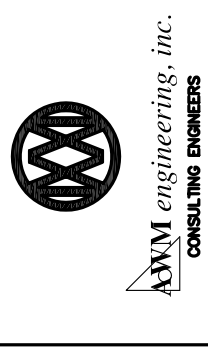


L TYPICAL UNIT TYPE "L" - (LOWER FLOOR) ELECTRICAL PLAN
SCALE: 1/4"=1'-0"

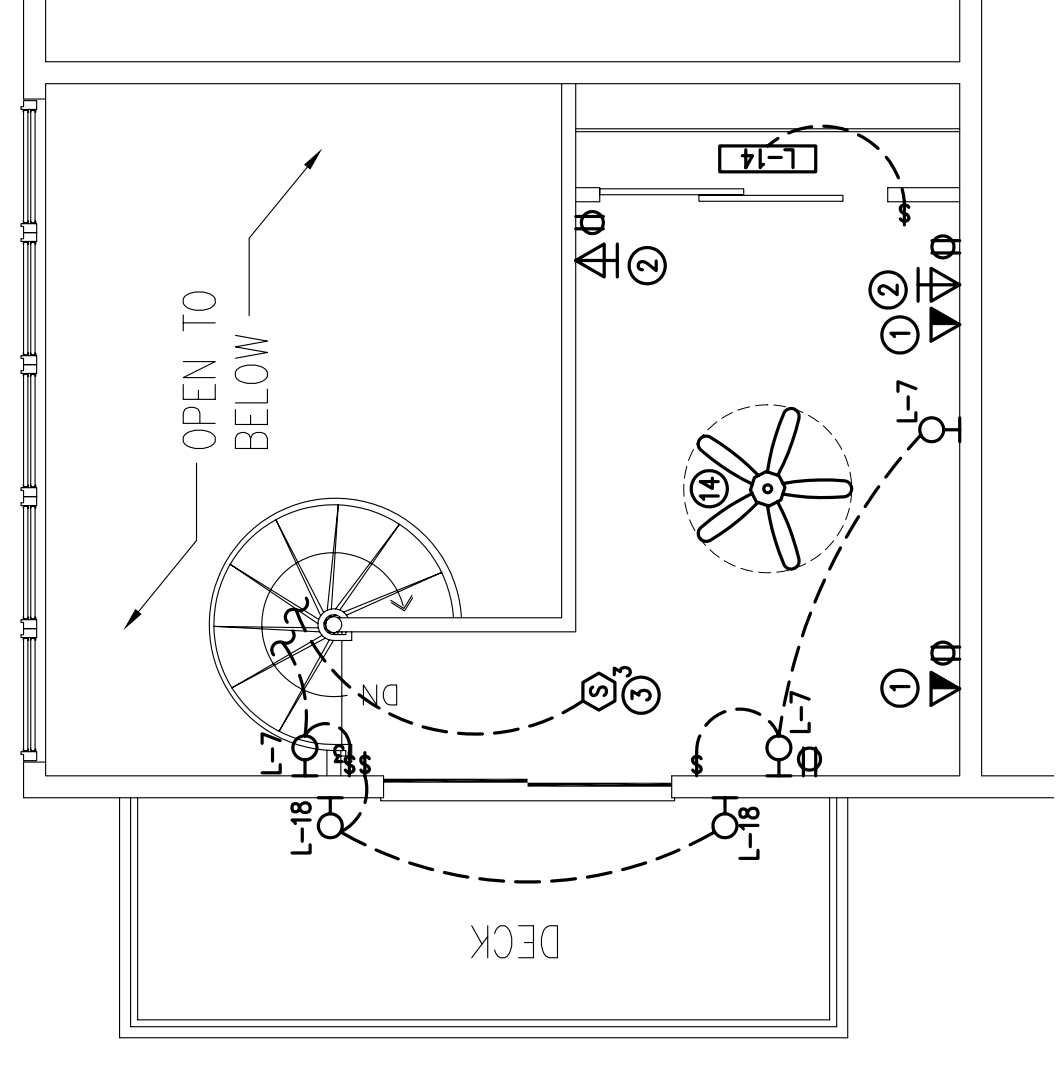

NOTE:
FOR KEY NOTES LEGEND SEE DWG. E-3.

L TYPICAL UNIT TYPE "L" - (UPPER FLOOR) ELECTRICAL PLAN
SCALE: 1/4"=1'-0"

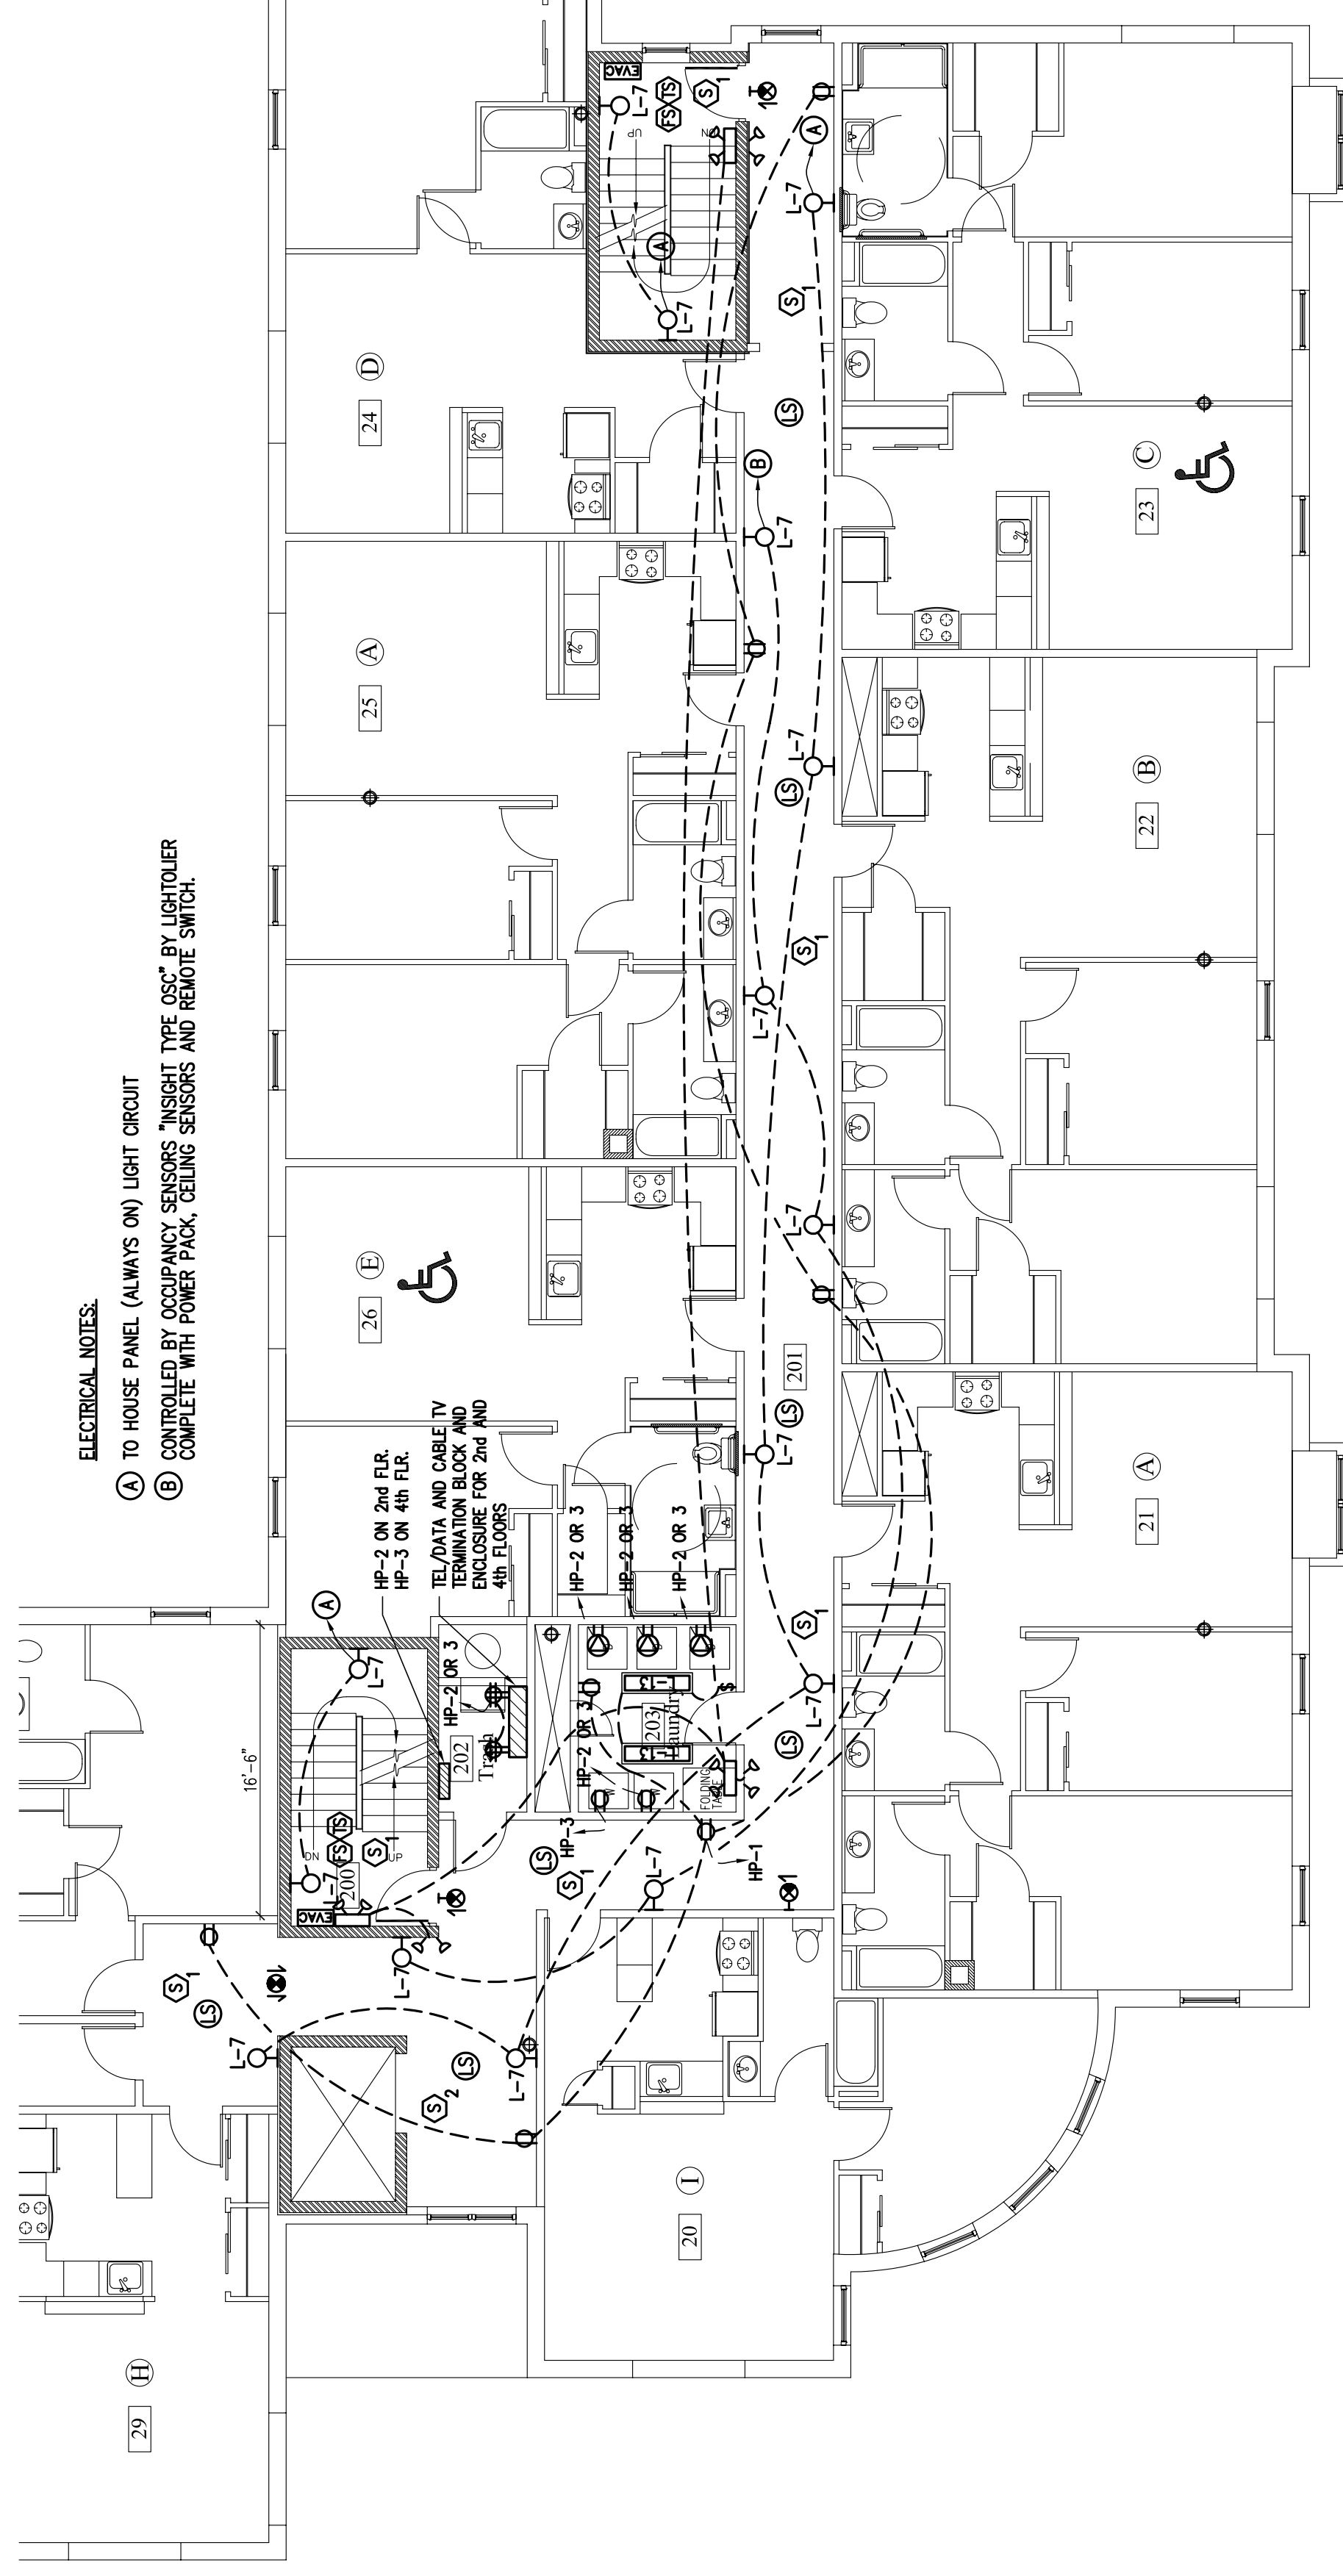

TYPICAL 2nd THRU 4th FLOOR COMMON LIGHTING/POWER PLAN
SCALE: 1/8"=1'-0"

ELECTRICAL NOTES:
 (A) TO HOUSE PANEL (ALWAYS ON) LIGHT CIRCUIT
 (B) CONTROLLED BY OCCUPANCY SENSORS "INSIGHT TYPE GSC" BY LIGHTTOOLER COMPLETE WITH POWER PACK, CEILING SENSORS AND REMOVE SWITCH.