



KEY NOTES LEGEND:
 (A) TO HOUSE PANEL (ALWAYS ON) LIGHT CIRCUIT
 CONTROLLED BY OCCUPANCY SENSORS. INSERT THE OSC BY LIGHTTOWER
 COMPLETE WITH POWER PACK, BEING SENSORS AND REMOTE SWITCH.

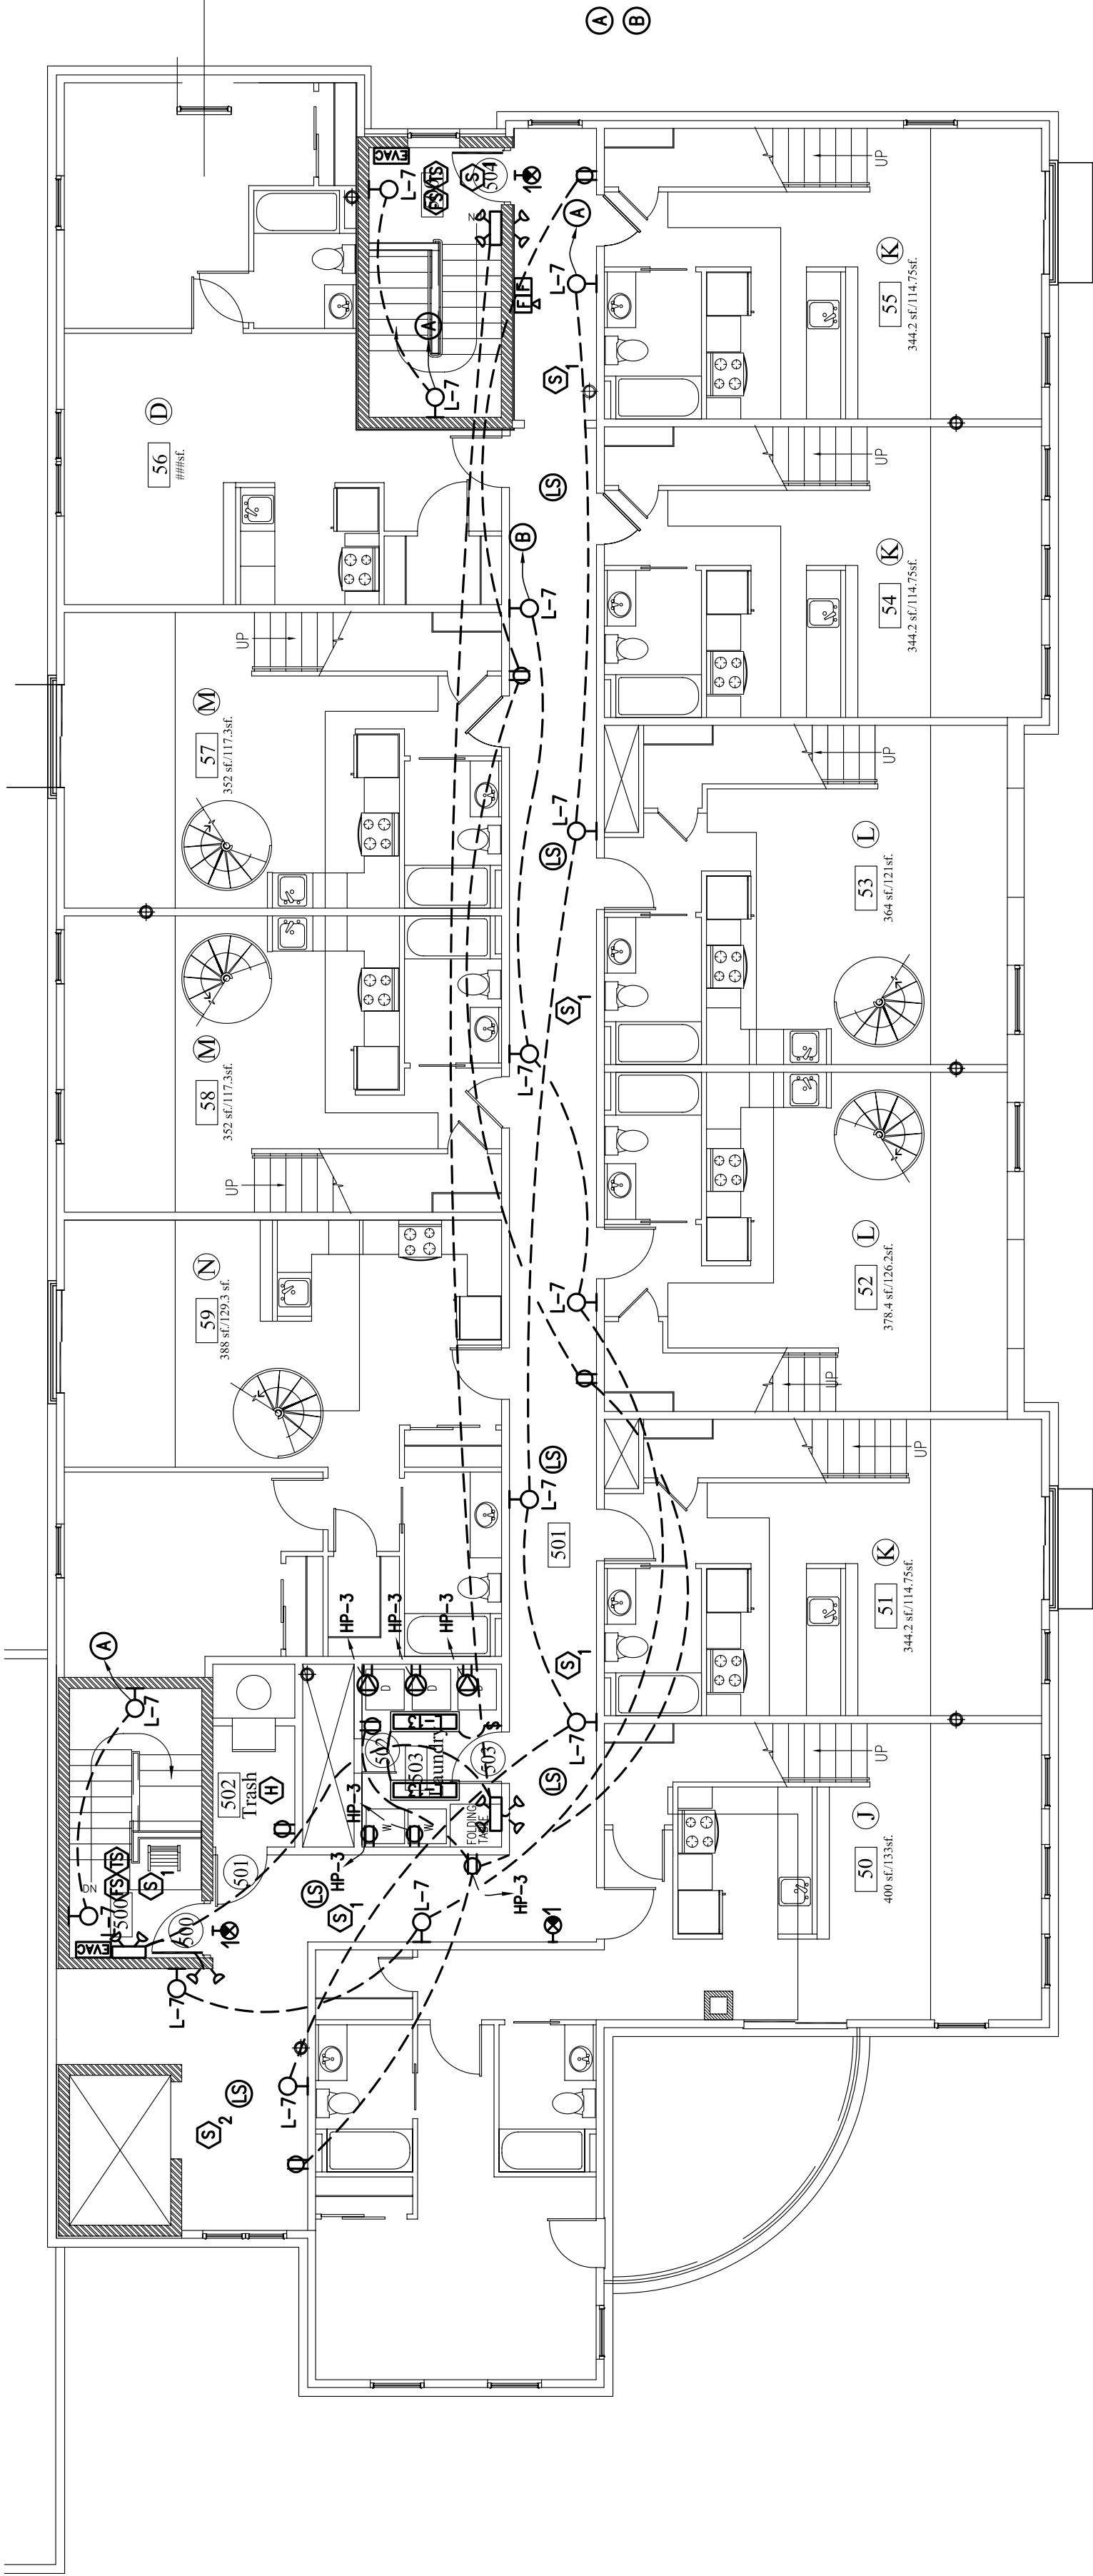

5th FLOOR COMMON LIGHTING/POWER PLAN
SCALE: 1/8"=1'-0"

ROOF LIGHTING/POWER PLAN
SCALE: 1/8"=1'-0"

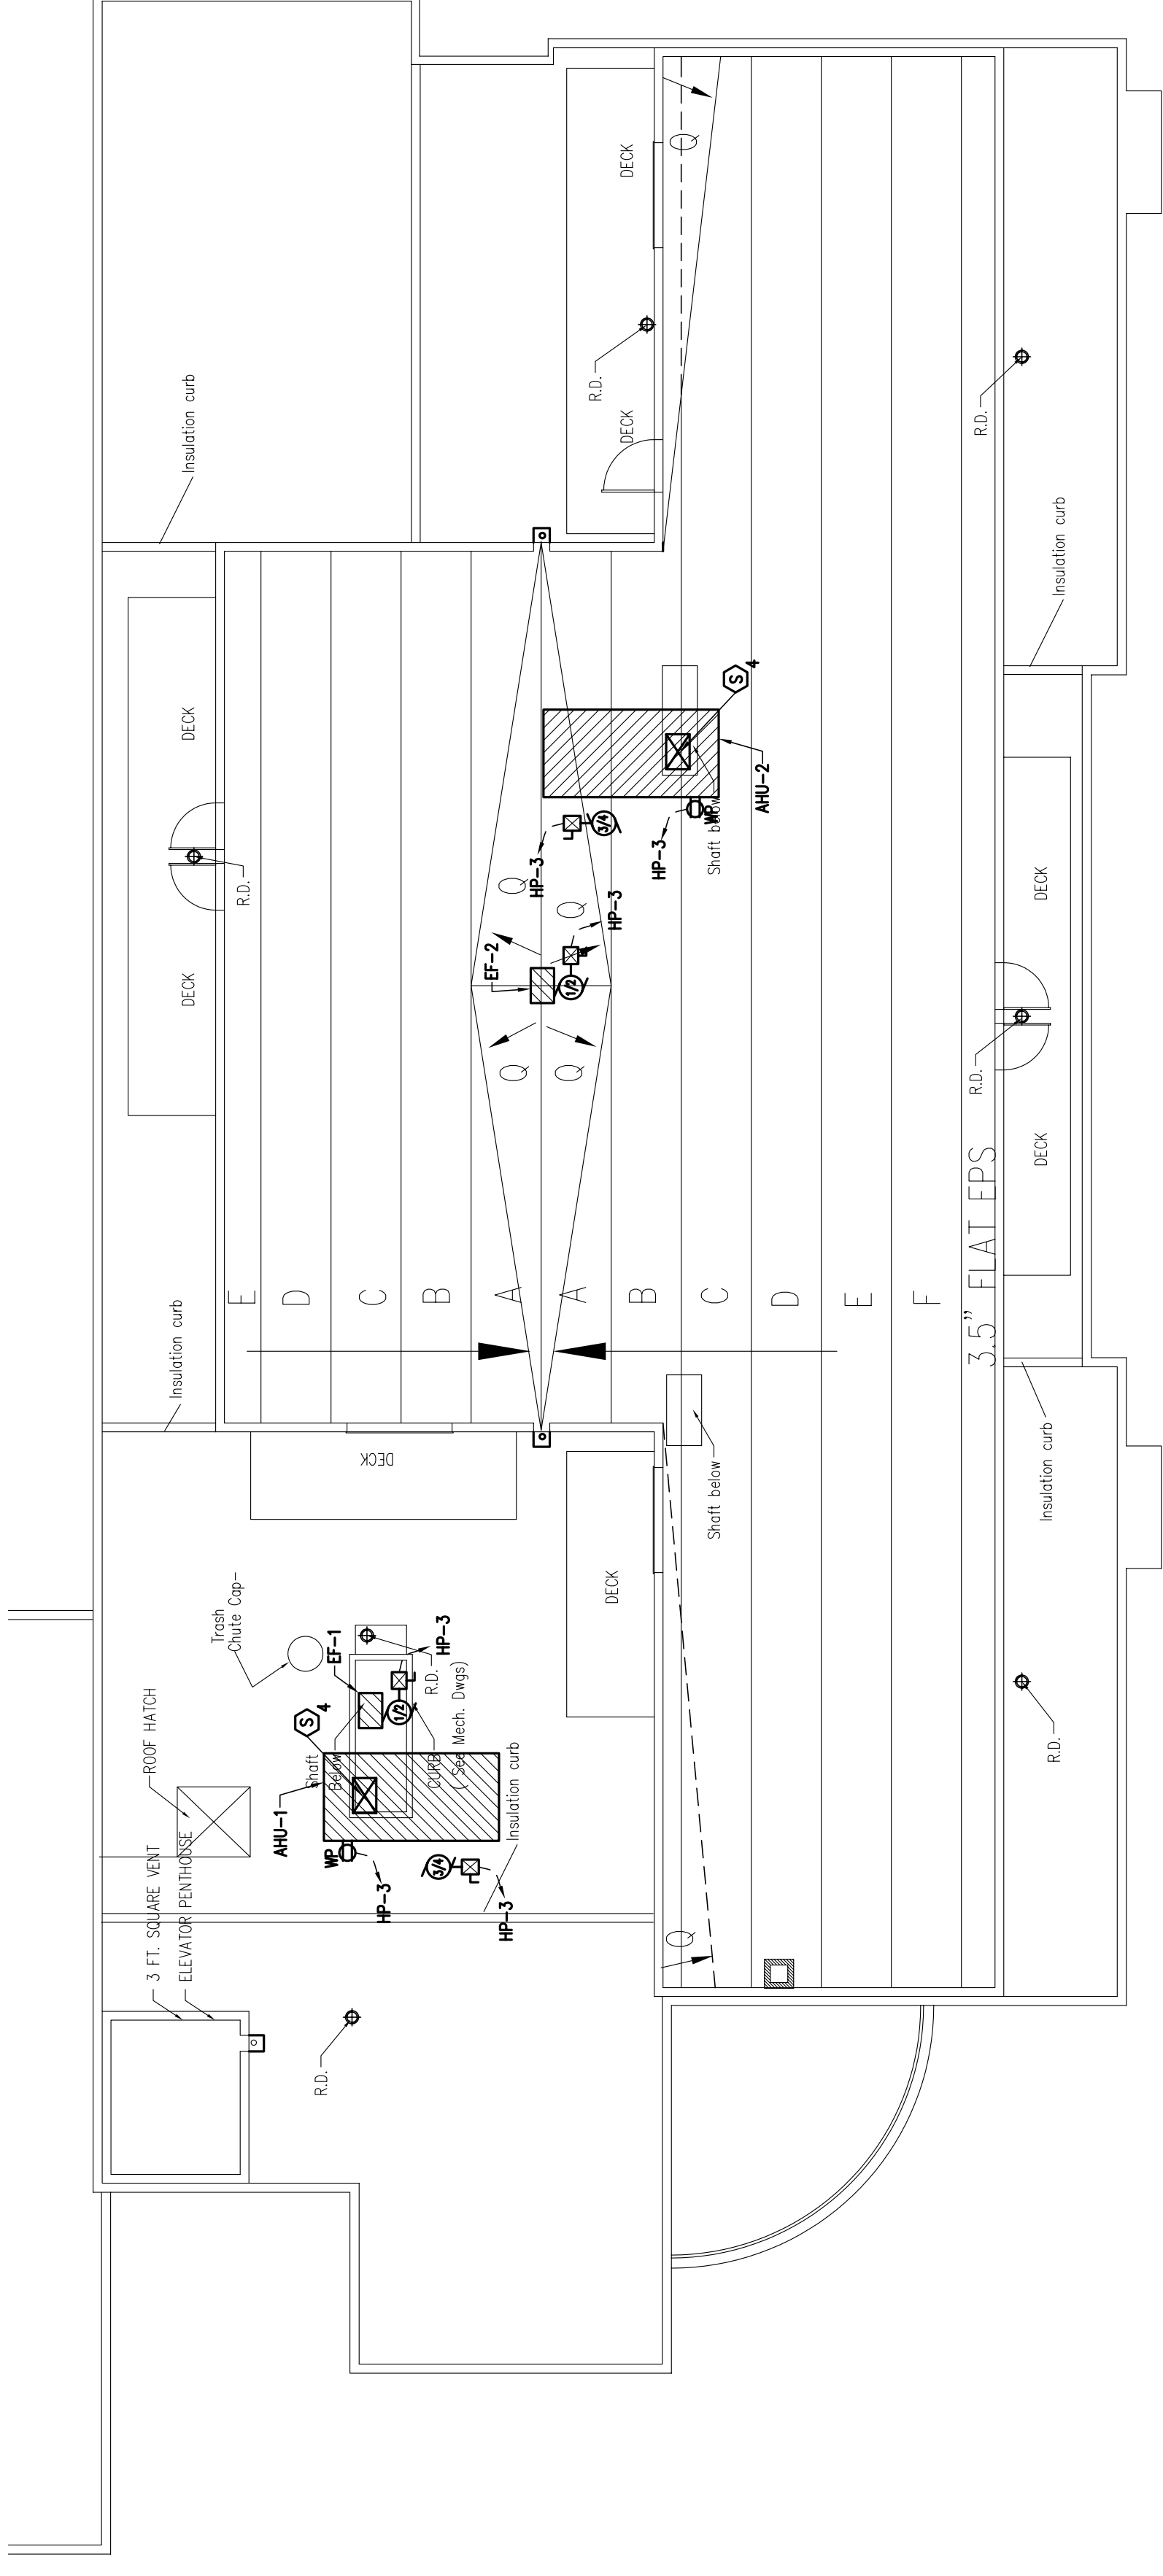

ROOF LIGHTING/POWER PLAN
SCALE: 1/8"=1'-0"