

FOR  
SUBMISSION  
7-12-05


## WALKER TERRACE FIRE PROTECTION PLAN GROUND FLOOR

Date: 7-12-05  
Scale: AS NOTED  
Checked By: CLC  
Drawn By: AWM

ARCHETYPE, P.A.  
ARCHITECTS  
48 Union Wharf Portland, Maine 04101  
(207) 772-6022 Fax (207) 772-4056


Project:  
WALKER TERRACE  
Walker Street,  
Portland, Maine 04101

Owner:  
MAINE WORKFORCE HOUSING, LLC  
One Longfellow Square, Portland, Maine 04101  
(207) 871-9811 Fax (207) 761-0155

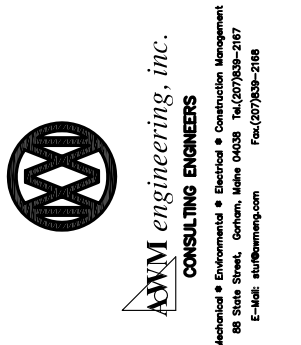

FIRE PUMP SCHEDULE						
TAG#	TYPE	LOCATION	SERVES	GPM HD. FT.	MOTOR HP	MANUFACTURER - MODEL
FP-1	VERTICAL IN-LINE FIRE SERVICE PUMP	FIRE PUMP ROOM	COMBINED WET STANDPIPE & SPRINKLER SYSTEM	750	208	ARMSTRONG DARLING "THERPAK ULTRA PLUS" PACKAGE SERIES FASTA, MODEL 6XALB-F, INCL'S BUCKET PUMP & CONTROLLERS, 6" SUCTION & 4" DISCHARGE
					208	
					75	
					3600	
					3	

GROUND FLOOR FIRE PROTECTION PLAN

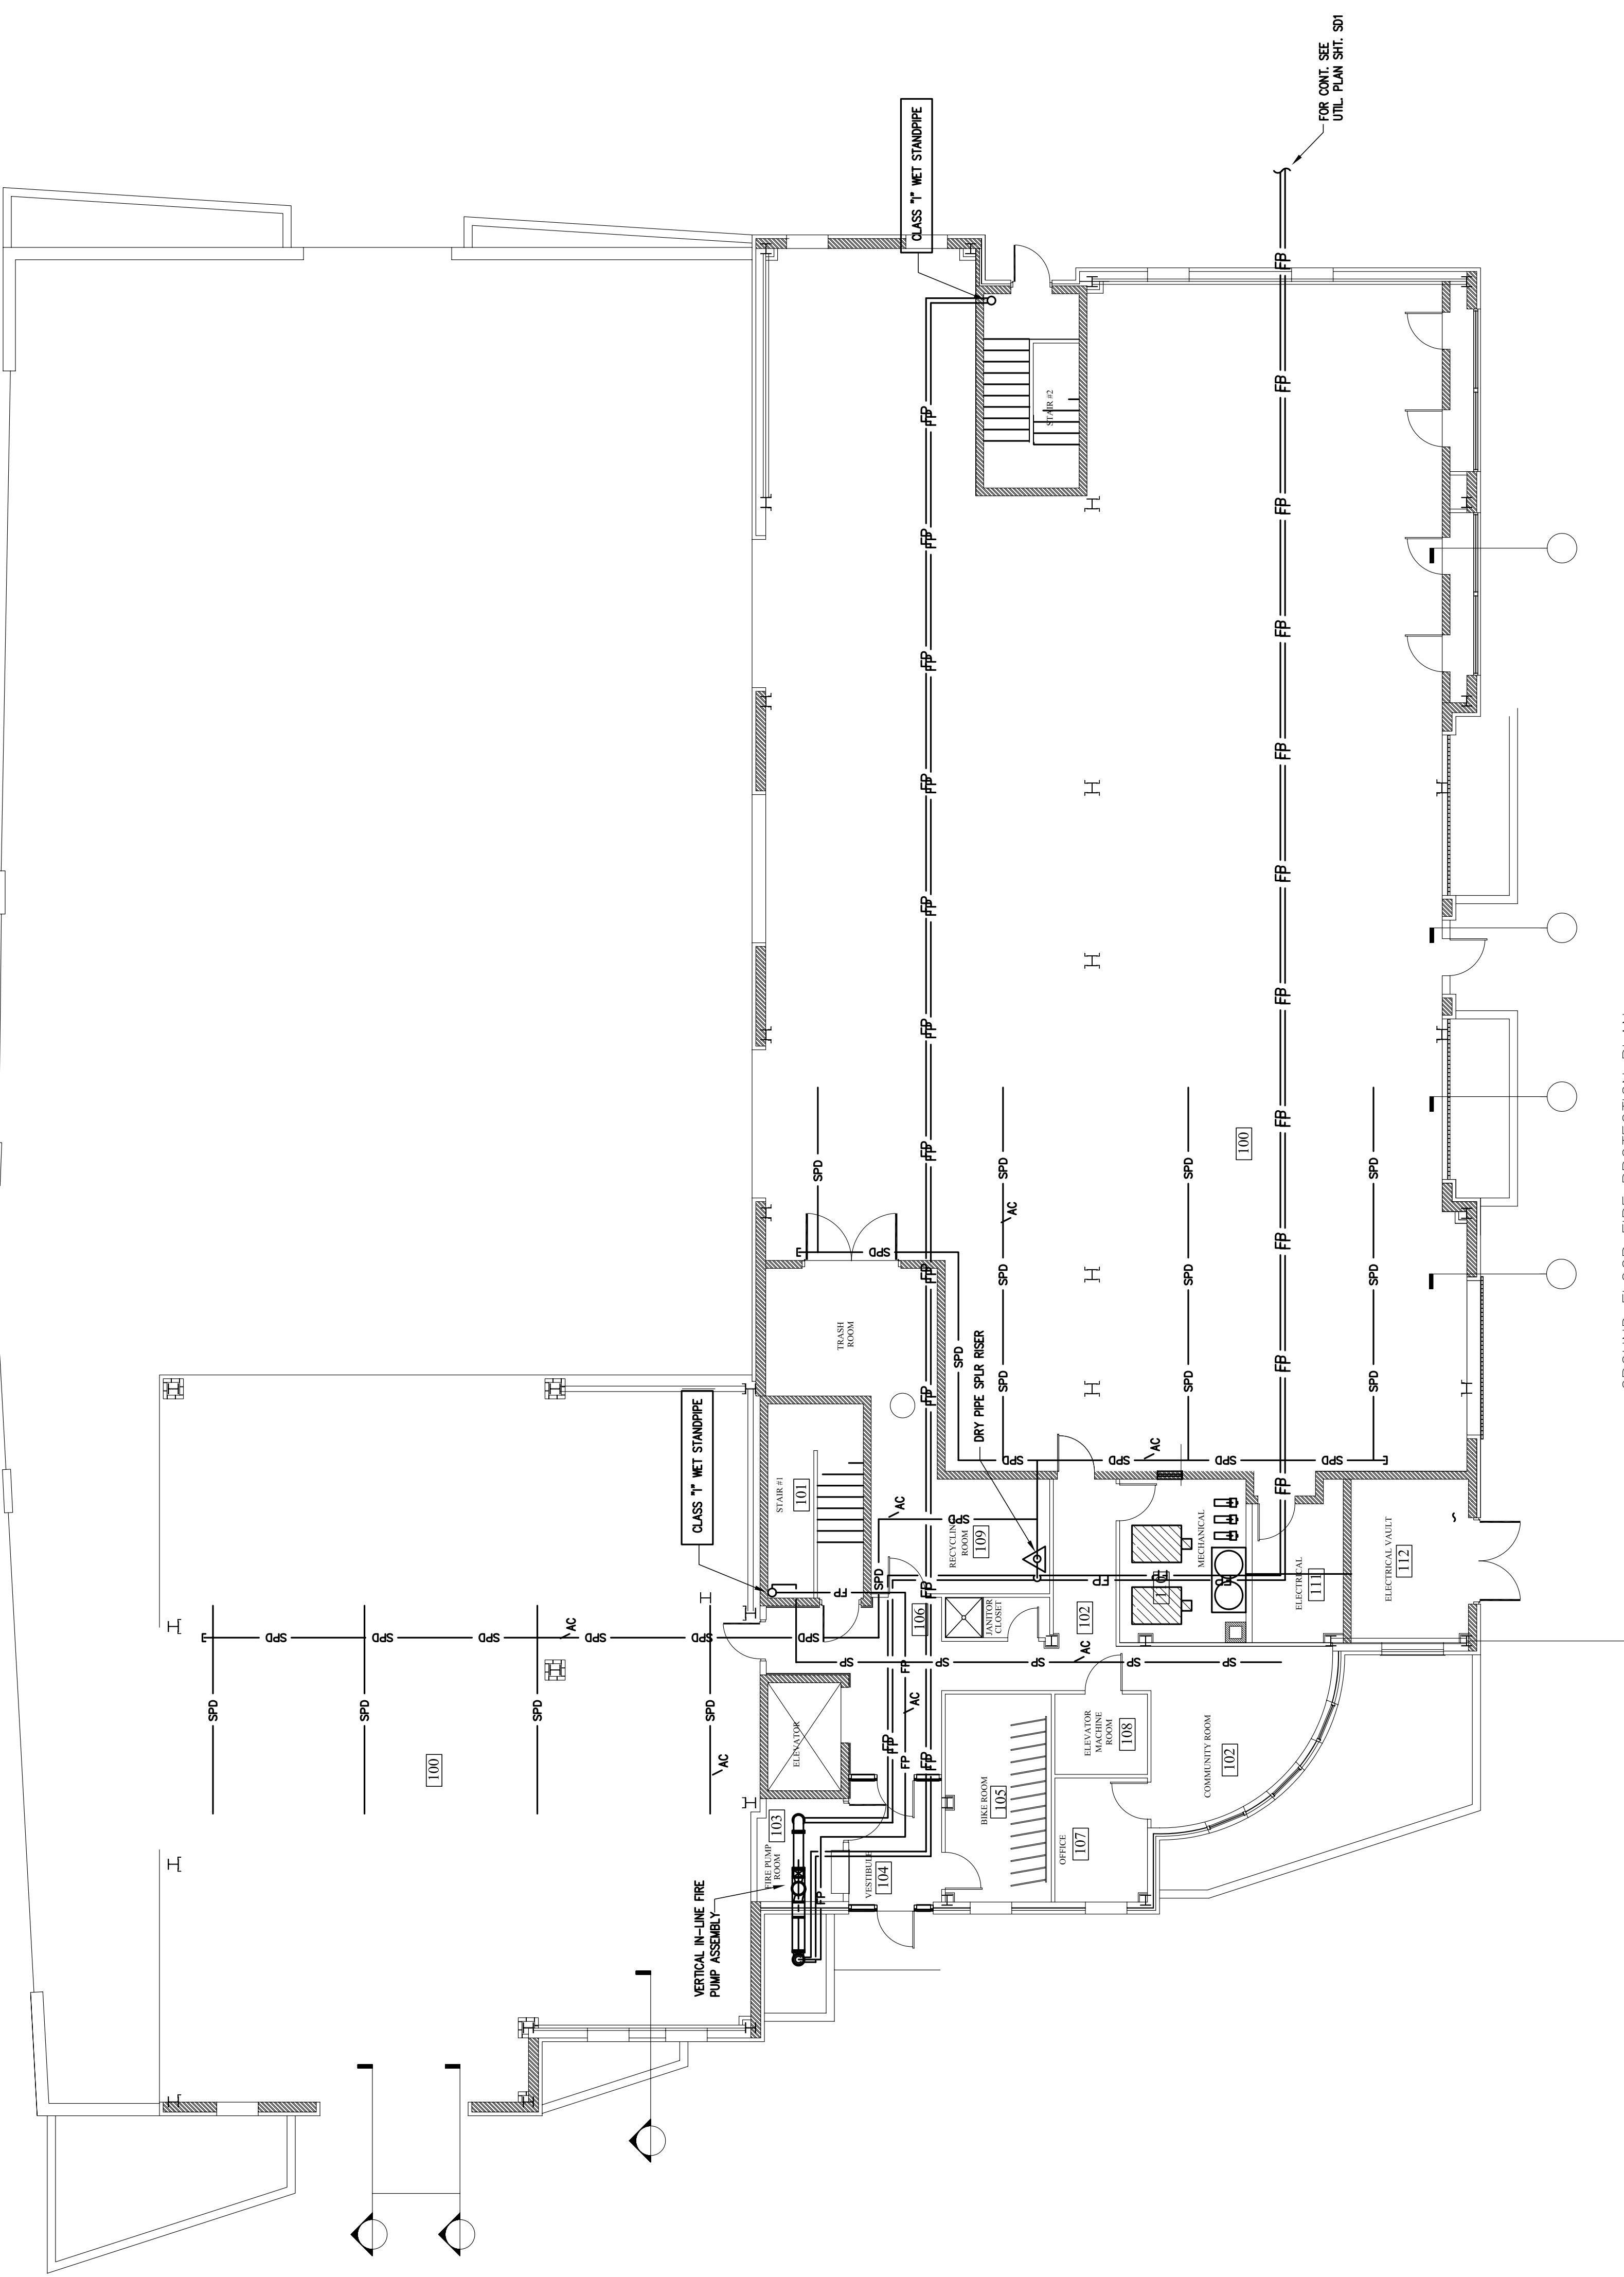

- LEGEND**
- SPD — NET PIPE SPRINKLER PIPING ABOVE GROUND
  - SPD — DRY PIPE SPRINKLER PIPING ABOVE GROUND
  - FP — FIRE LINE PIPING ABOVE GROUND
  - FP — FIRE LINE (AND FIRE SERVICE) PIPING BELOW GROUND

