

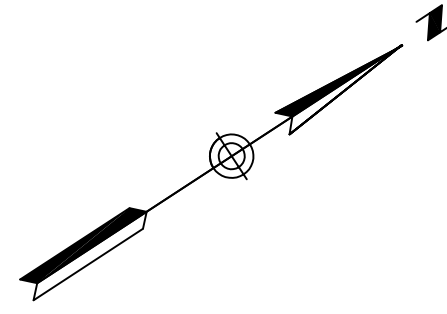


Date:	7-12-05
Scale:	AS NOTED
Checked By:	AWM
Drawn By:	CLC
Revisions:	

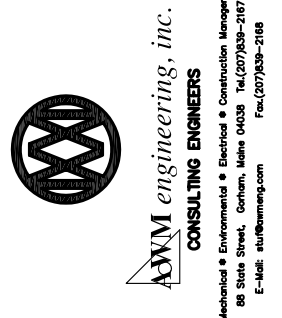

1 THIRD FLOOR PLAN
SCALE : 1/8" = 1'-0"

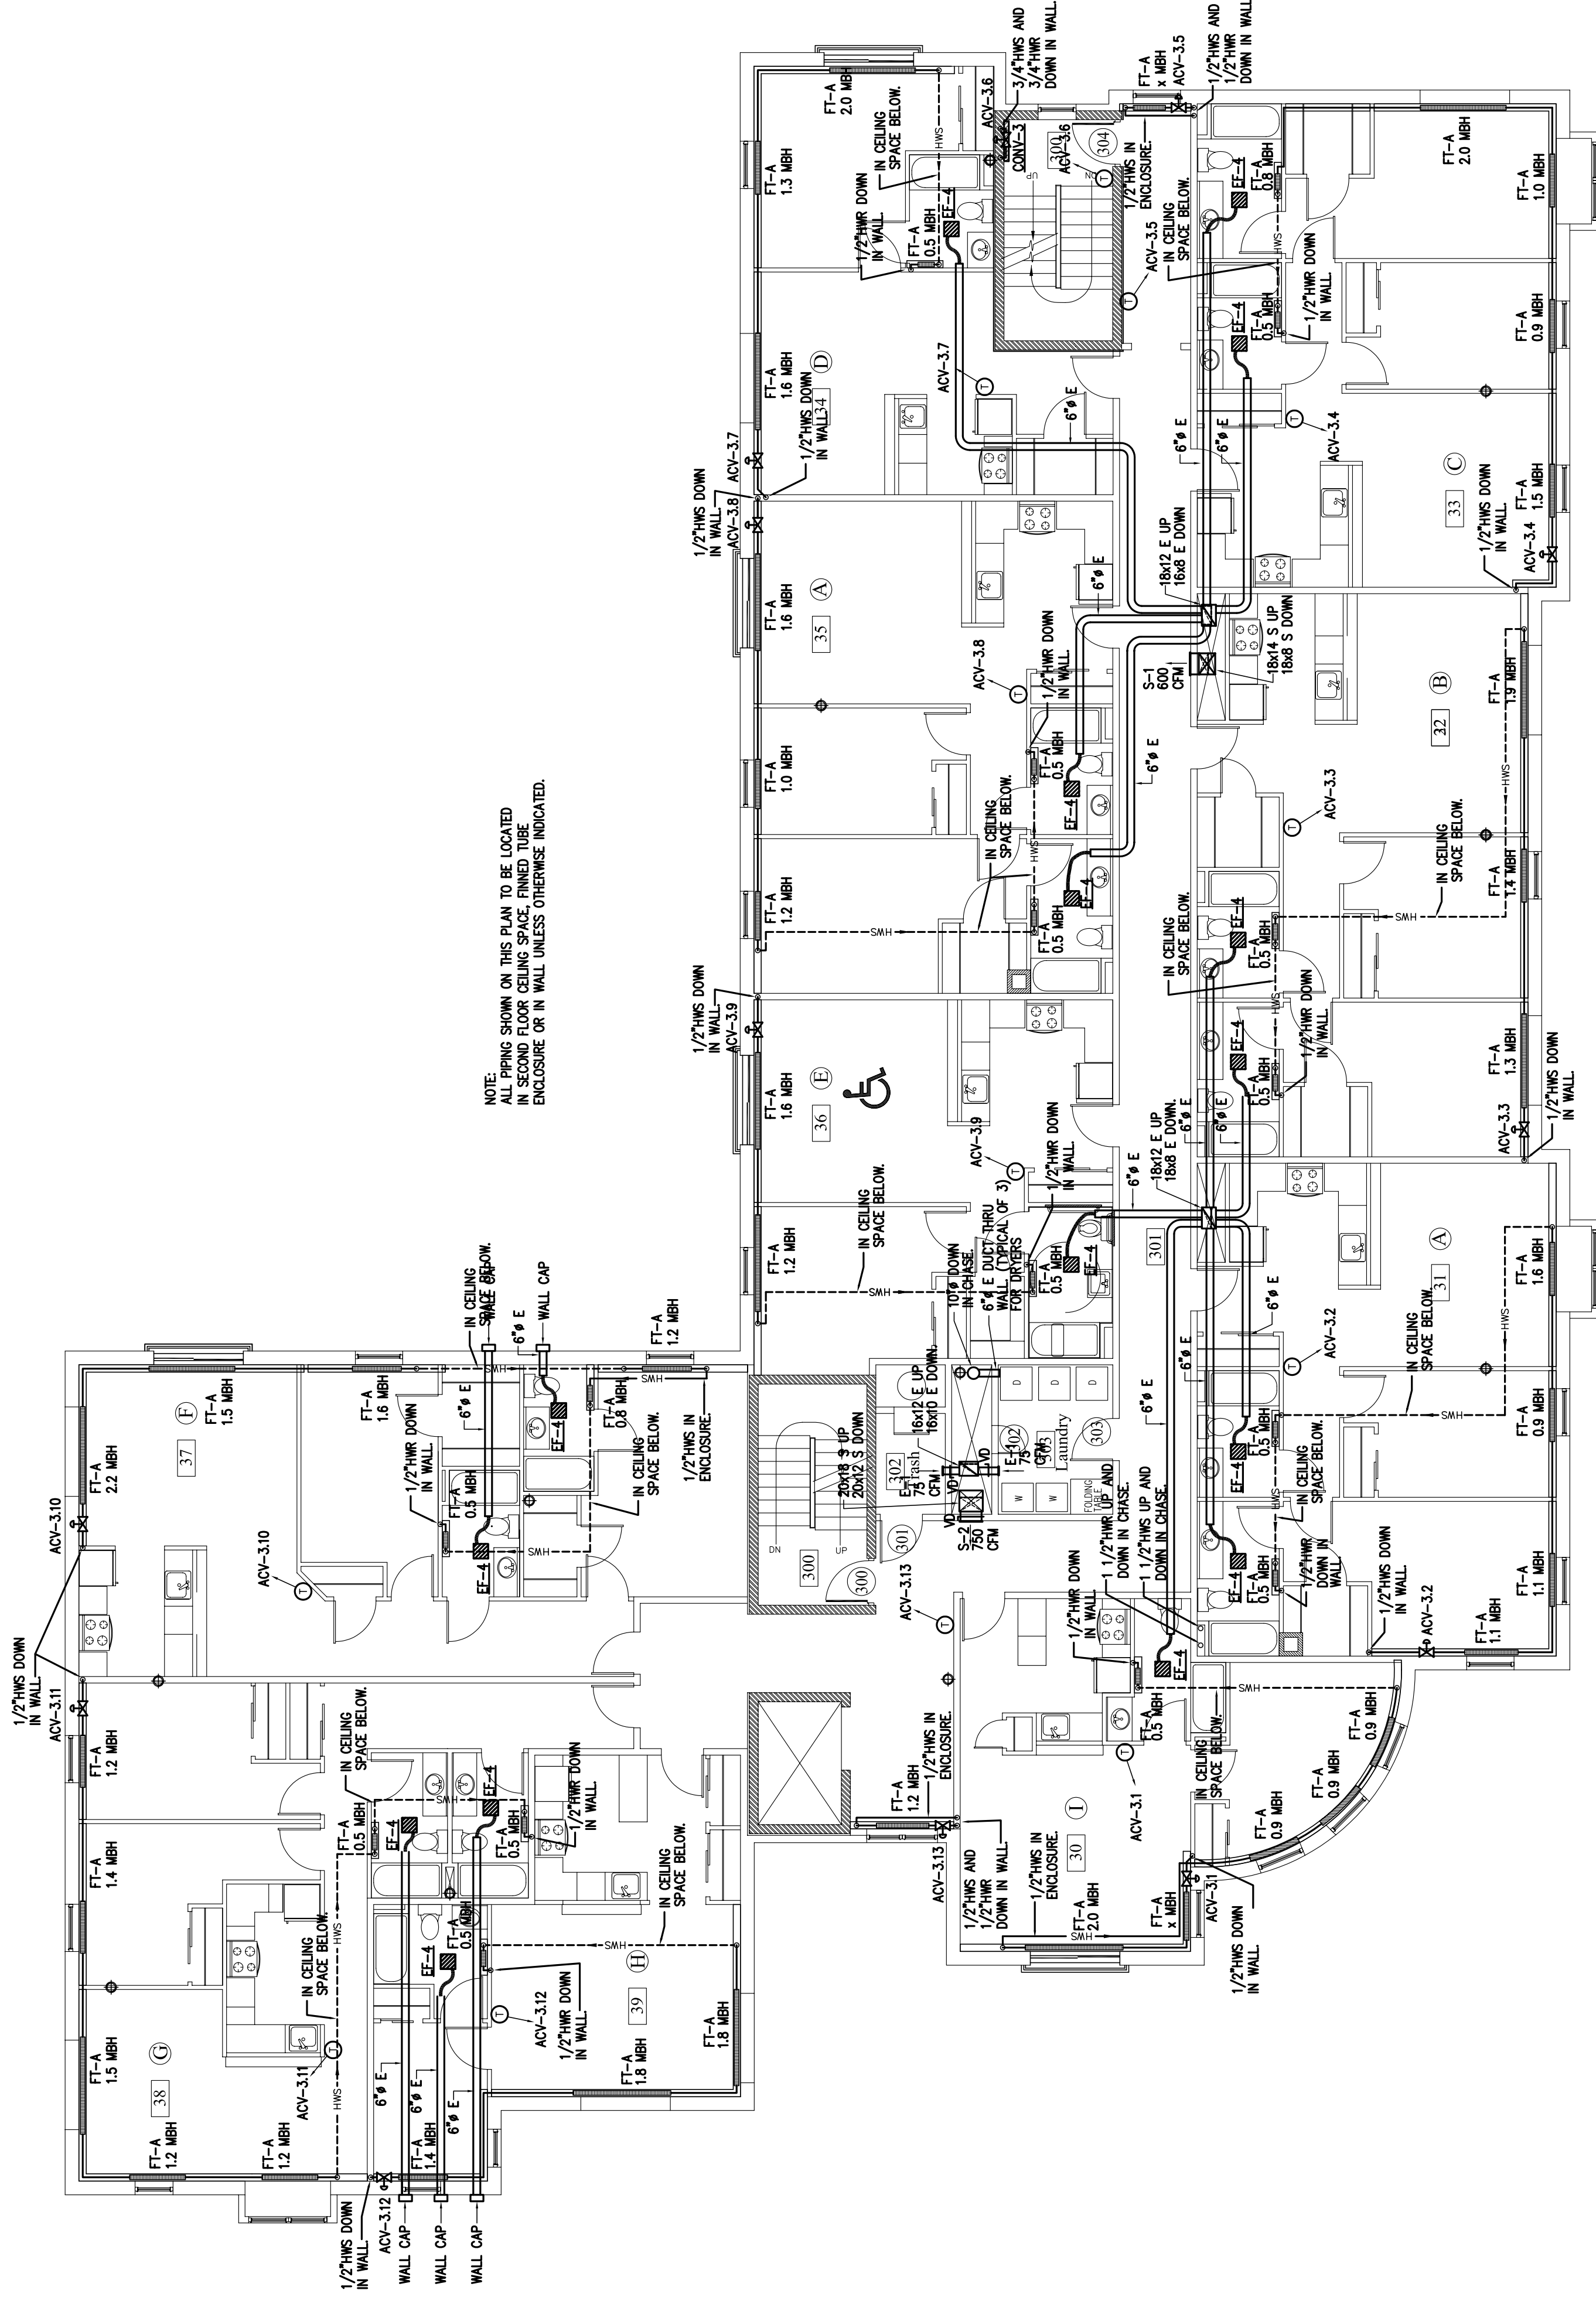

NOTE:
FANS SHOWN ON THIS PLAN TO BE LOCATED
IN SECOND FLOOR CEILING SPACE FINISH TUBE
ENCLOSURE OR IN WALL UNLESS OTHERWISE INDICATED.

LOCATION MAP
N.T.S.

