

MAINE WORKFORCE HOUSING, LLC  
 One Longfellow Square, Portland, Maine 04101  
 (207) 871-9811 Fax (207) 761-0155


Project: WALKER TERRACE  
 Walker Street,  
 Portland, Maine 04101

ARCHETYPE, P.A. ARCHITECTS  
 48 Union Wharf Portland, Maine 04101  
 (207) 772-6022 Fax (207) 772-4056


Scale: AS NOTED  
 Date: 7-12-05  
 Drawn By: SJM  
 Revisions: Checked By: AWB

WALKER TERRACE  
 PLUMBING  
 DETAILS & RISER  
 DIAGRAMS


P11

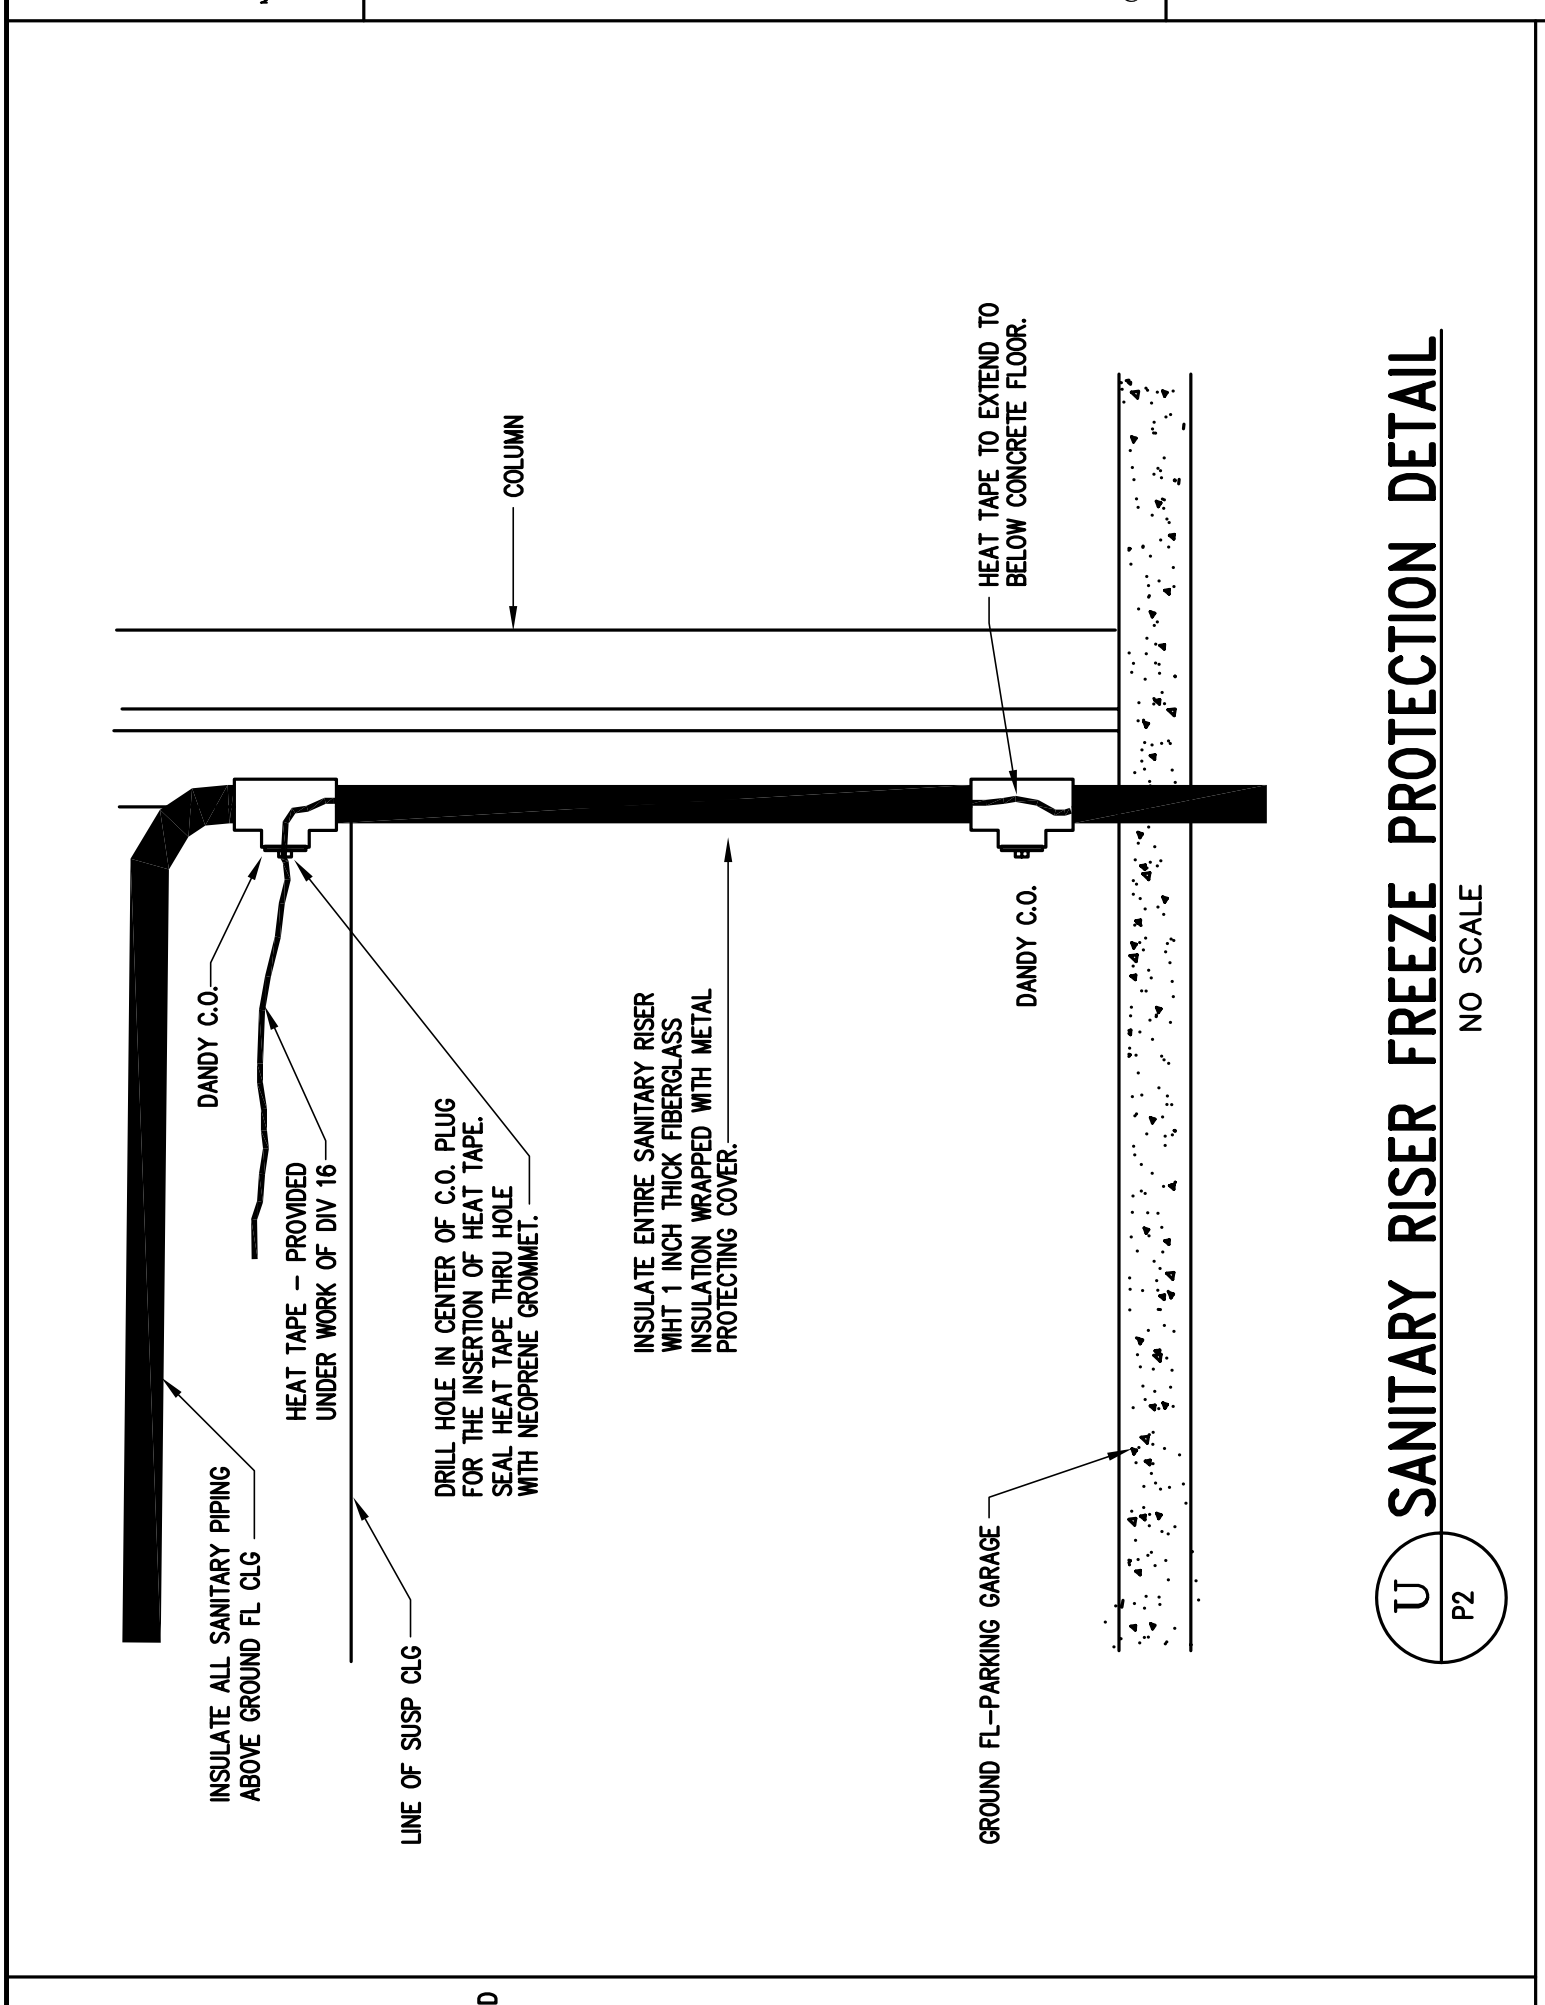


U P2 SANITARY RISER FREEZE PROTECTION DETAIL  
 NO SCALE

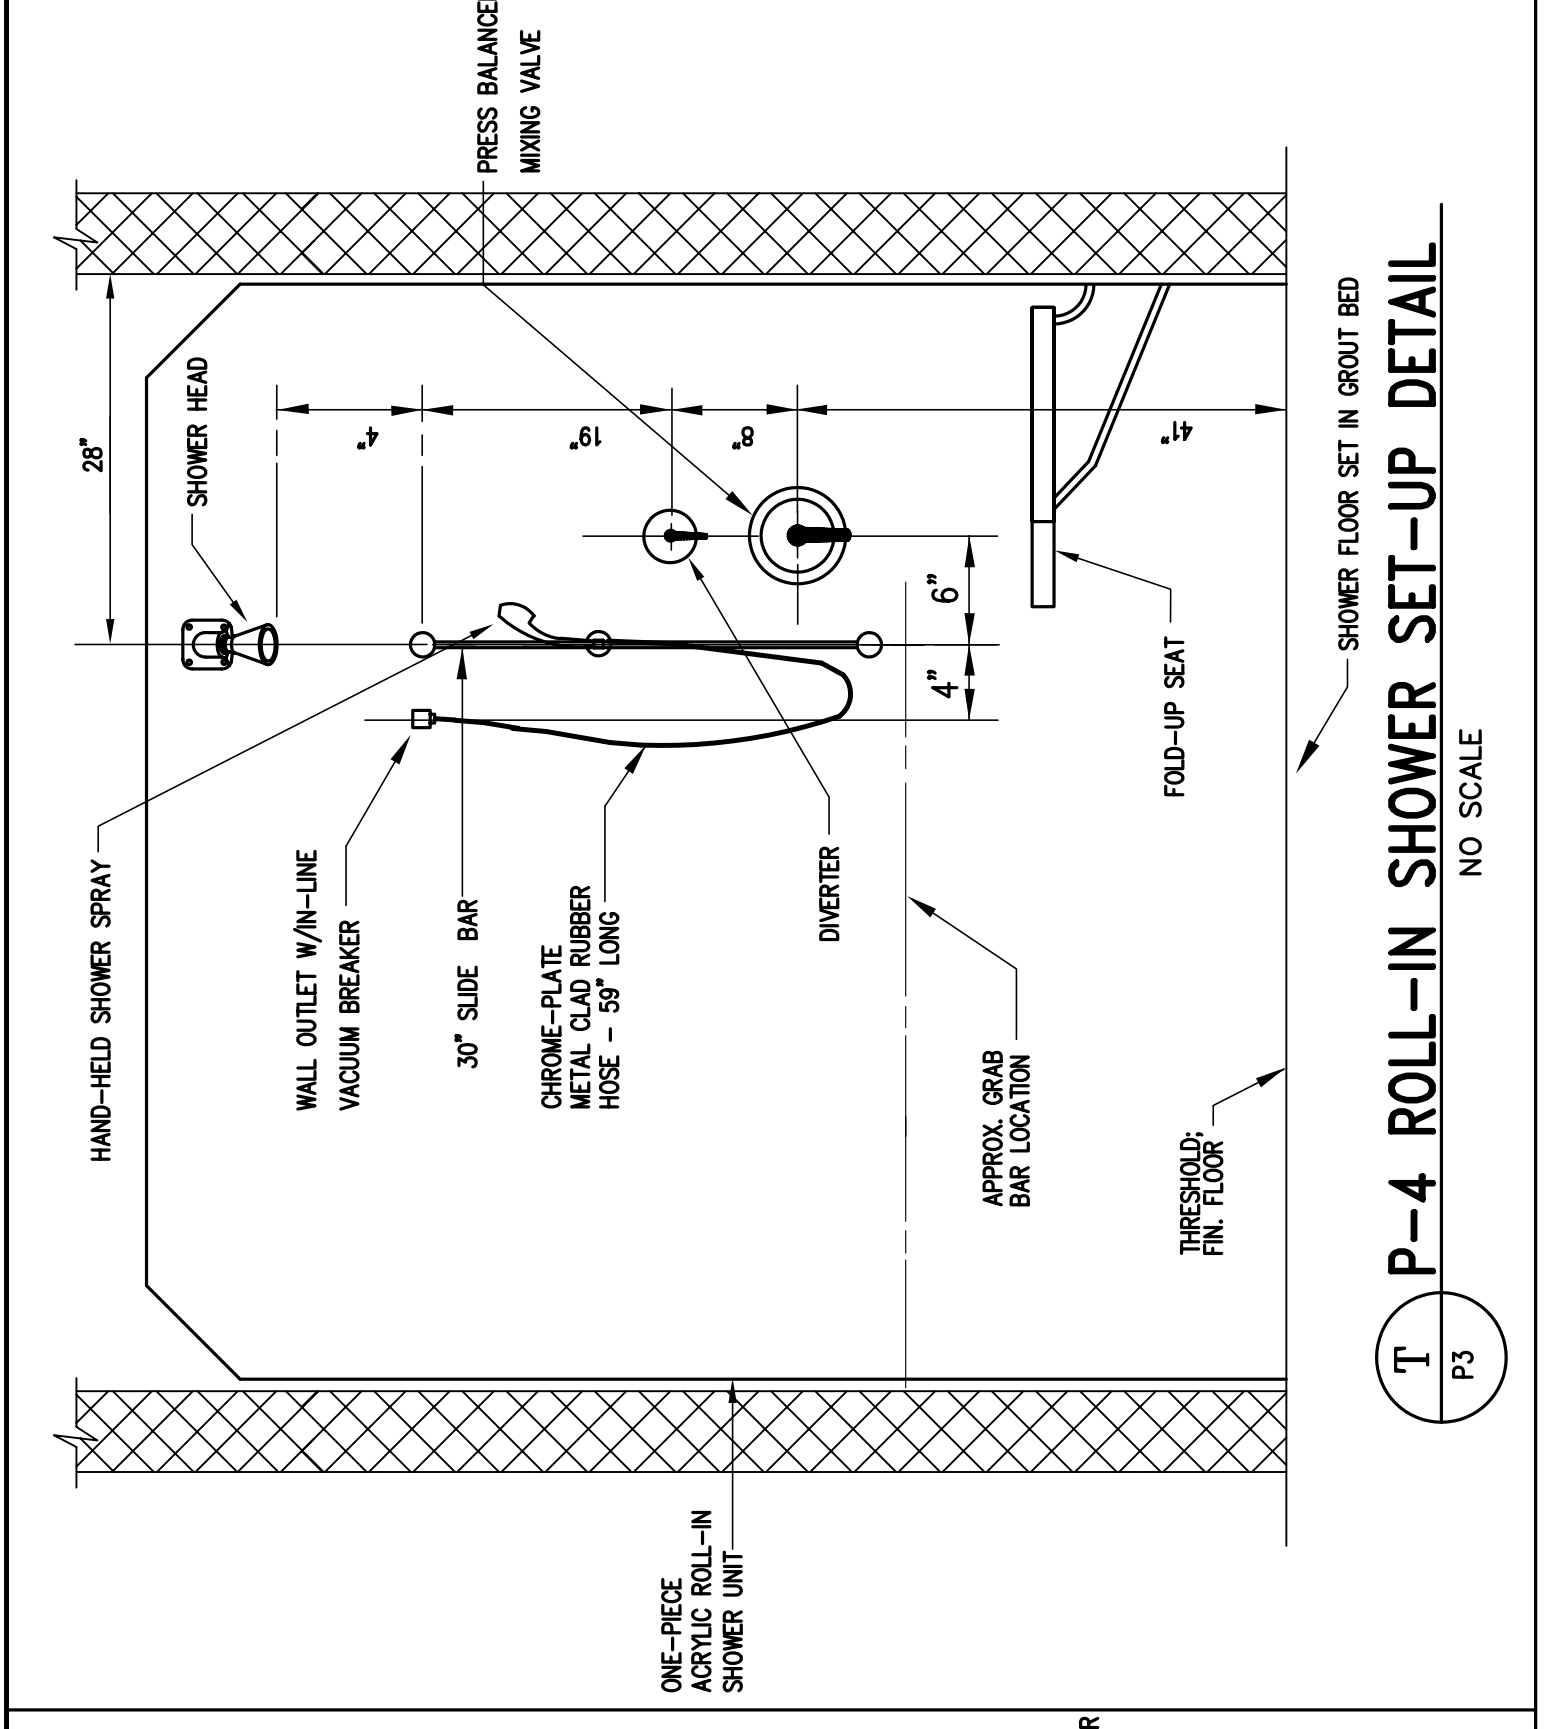

T P3 P-4 ROLL-IN SHOWER SET-UP DETAIL  
 NO SCALE

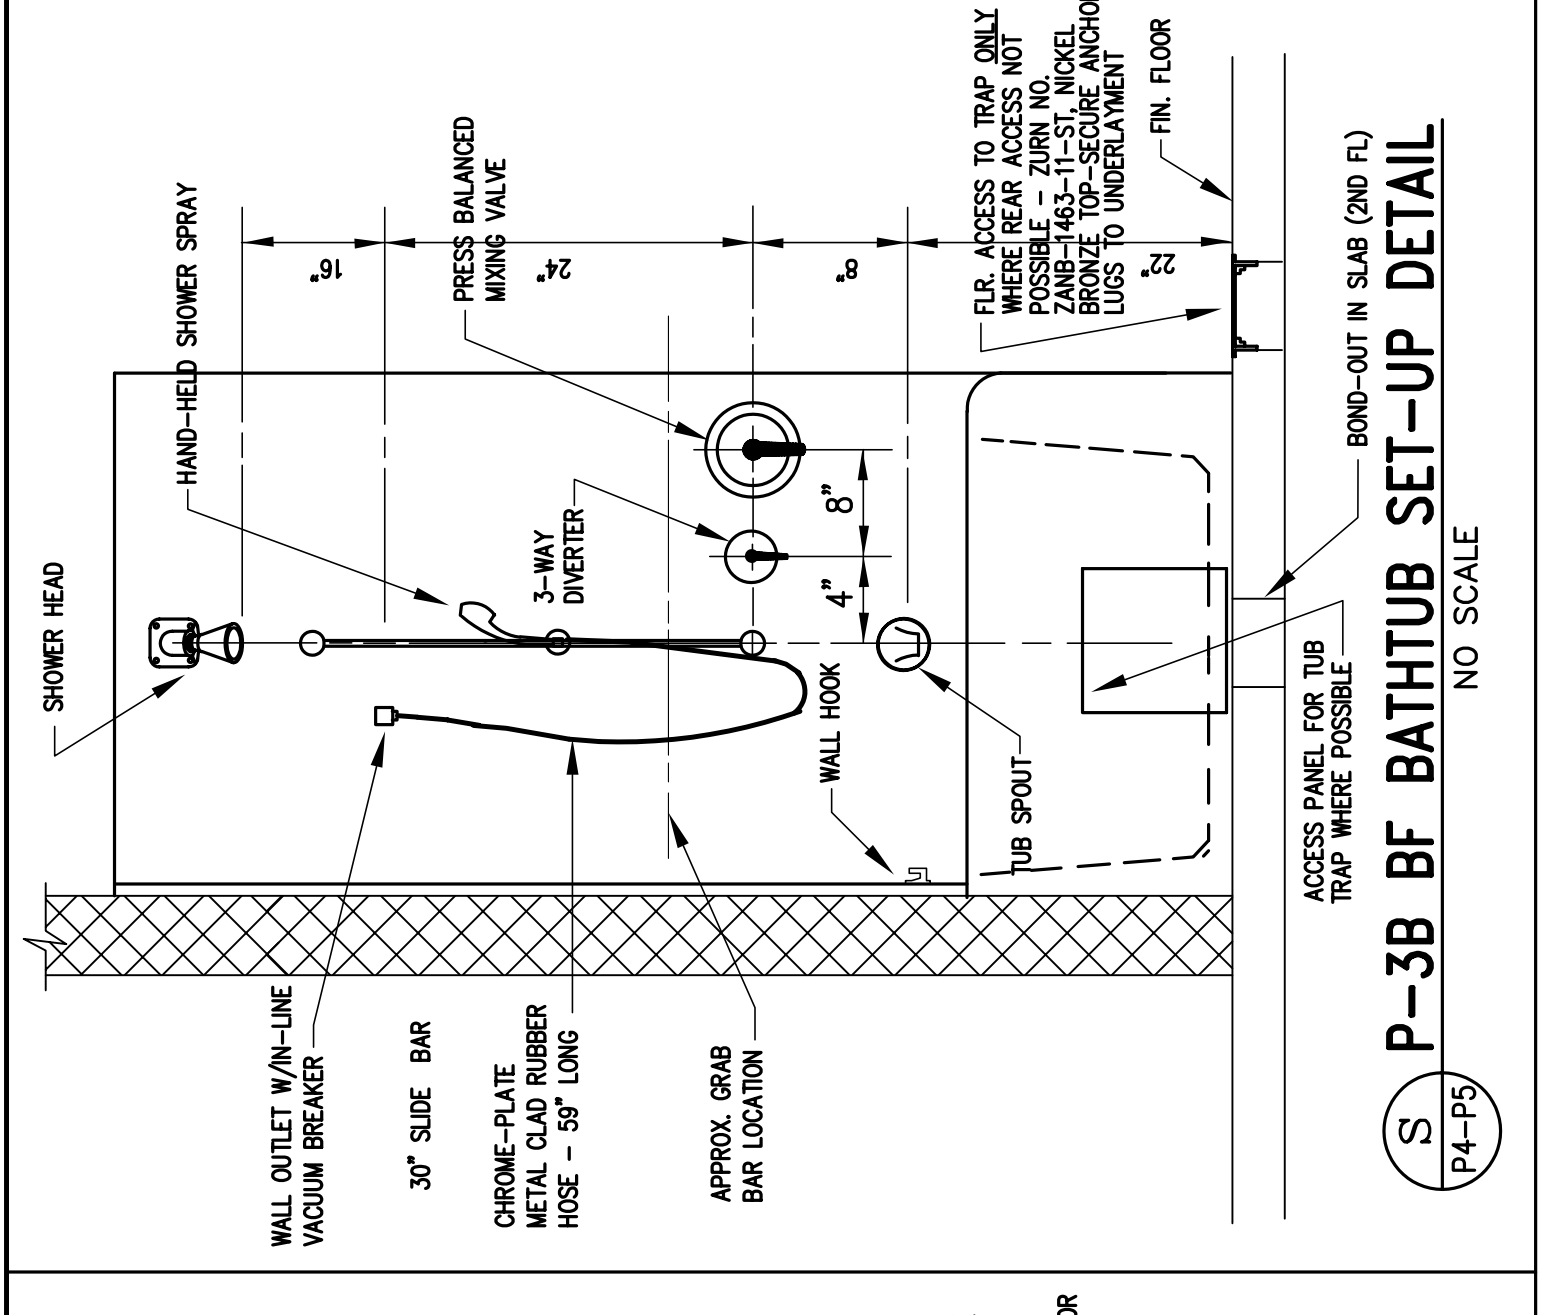


S P4-P5 P-3B BF BATHTUB SET-UP DETAIL  
 NO SCALE

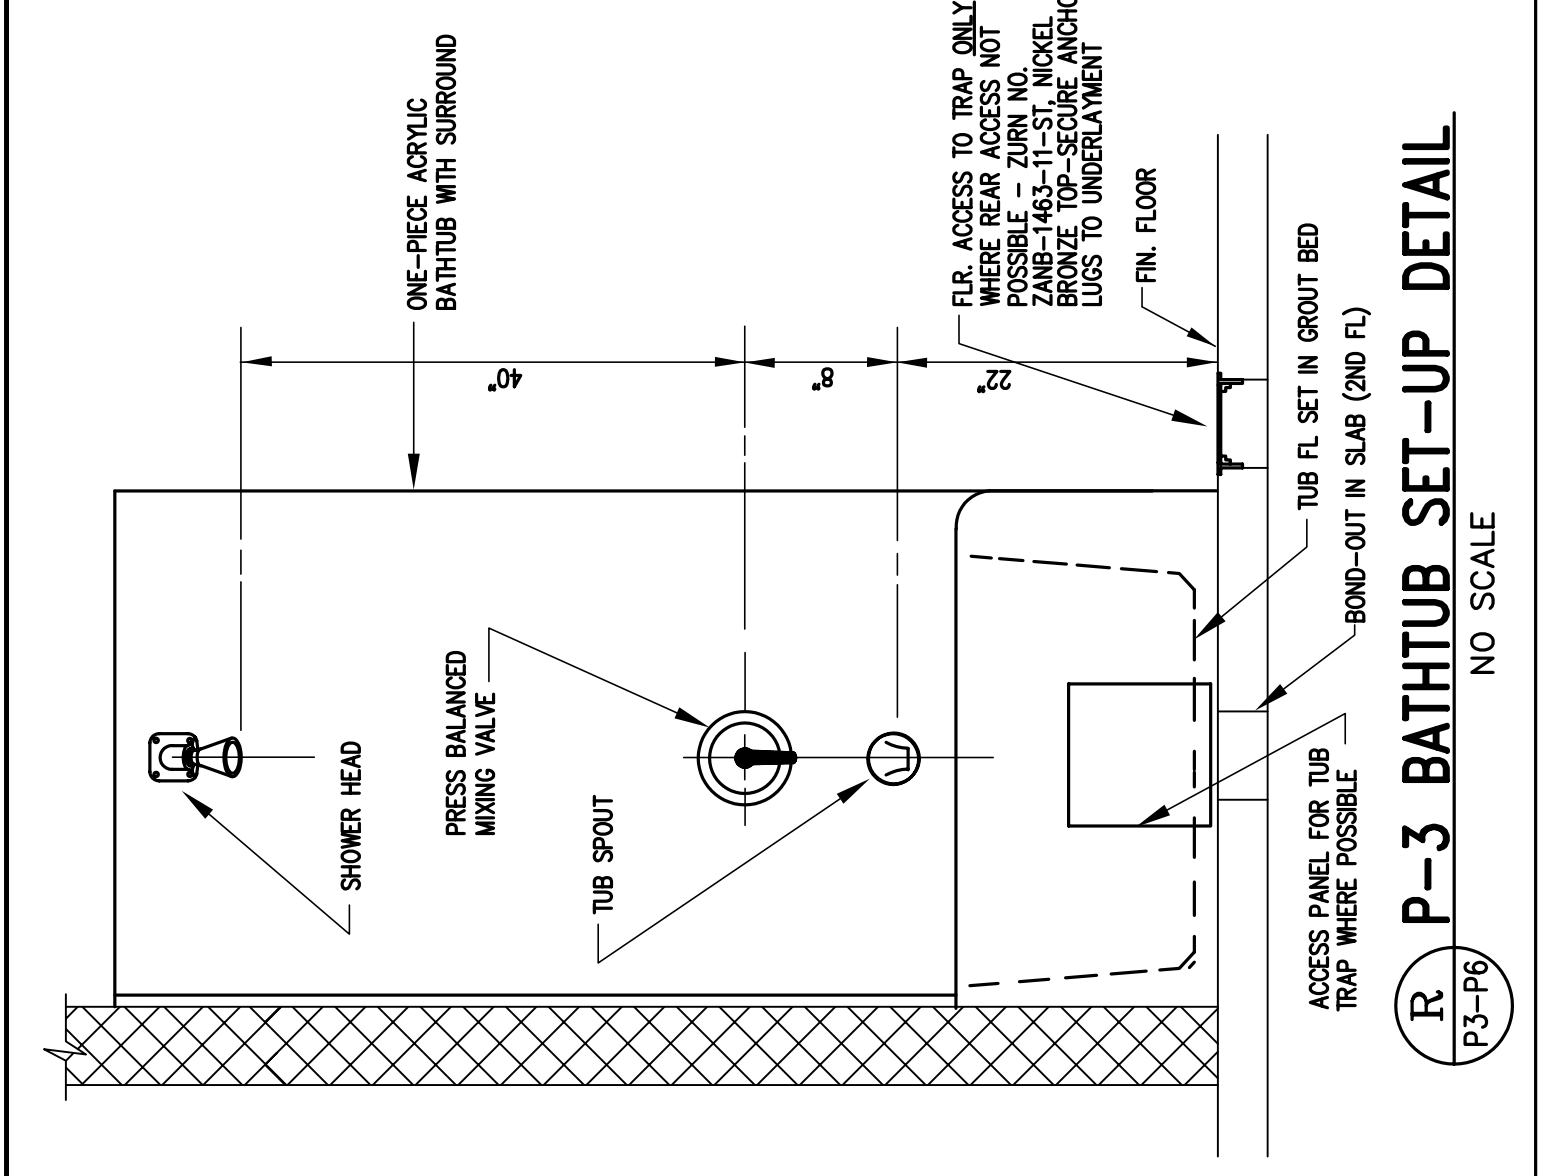

R P3-P6 P-3 BATHTUB SET-UP DETAIL  
 NO SCALE

**RISER FIXTURE LEGEND**

	WATER CLOSET, P-1, P-1B		KITCHEN SINK, P-5, P-5B, P-5C
	WALL LAVATORY, P-2B		MOP RECEPTOR, P-6
	COUNTER LAVATORY, P-2		CLOTHES WASHER, P-8
	TUB/SHOWER UNIT, P-3, P-3B		SANITARY RISER NUMBER 1
	ROLL IN SHOWER, P-4		

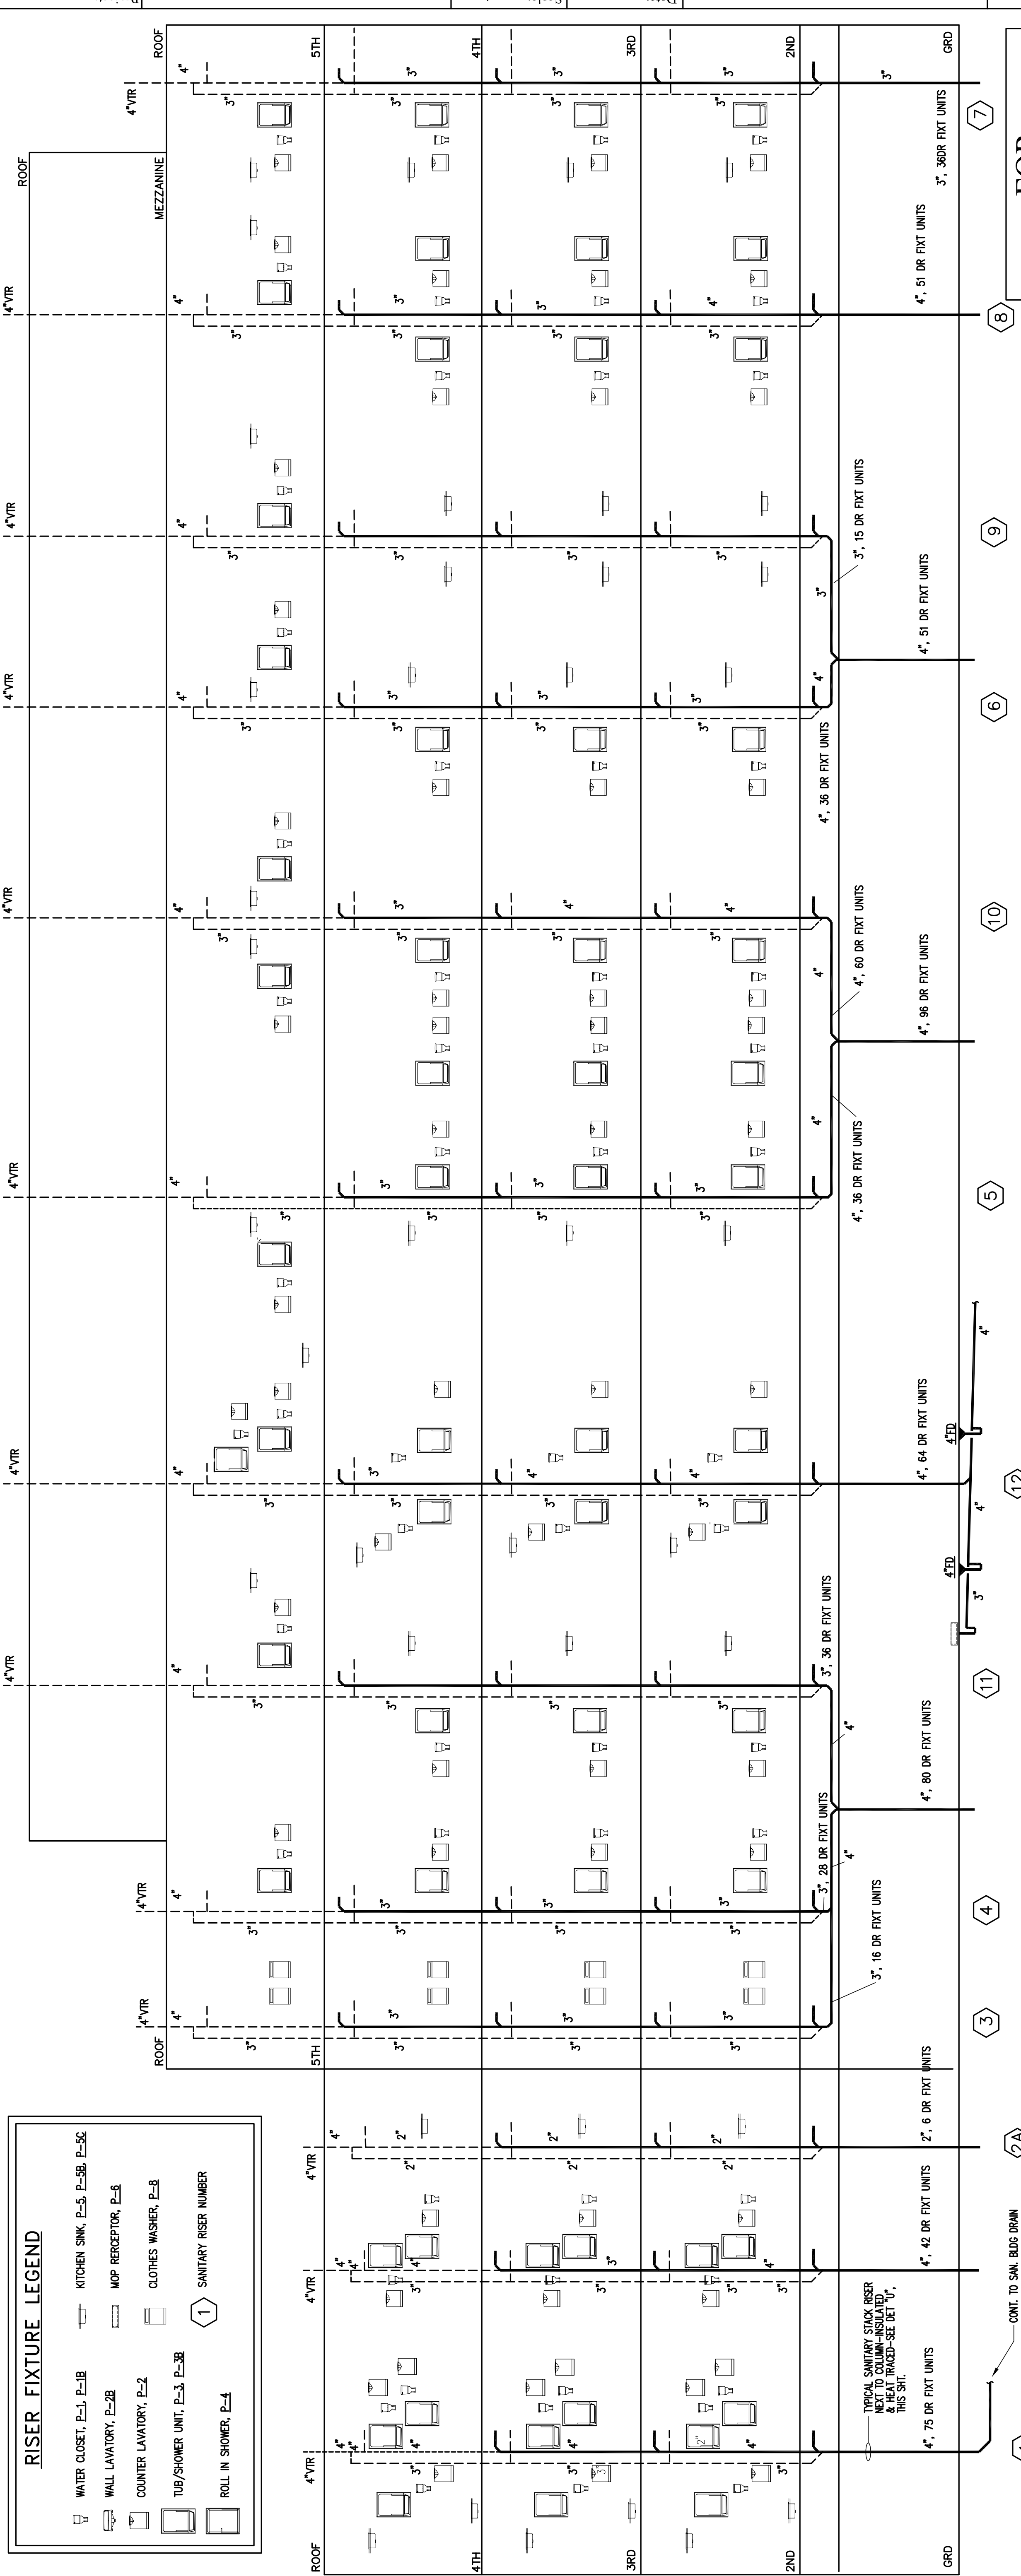

FOR SUBMISSION  
 7-12-05

SCHEMATIC SANITARY RISER DIAGRAMS  
 SCALE: 1/8"=1'-0"