

WALKER TERRACE
PLUMBING
SECOND FLOOR
PLAN



Date:	7-12-05
Revisions:	Drawn By: CLC
	Checked By: AWM
Scale:	AS NOTED

ARCHETYPE, P.A.
ARCHITECTS

48 Union Wharf Portland, Maine 04101
(207) 772-6022 Fax (207) 772-4056


Project:
WALKER TERRACE
Walker Street,
Portland, Maine 04101

Owner:
MAINE WORKFORCE HOUSING, LLC
One Longfellow Square, Portland, Maine 04101
(207) 871-9811 Fax (207) 761-0155

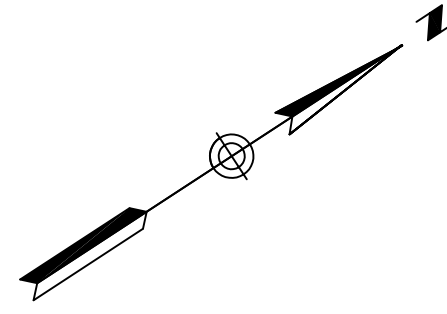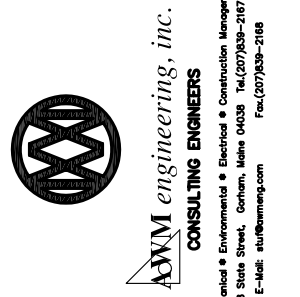

1 SECOND FLOOR PLAN
SCALE : 1/8" = 1'-0"

SECOND FLOOR PLUMBING PLAN
SCALE: 1/8" = 1'-0"

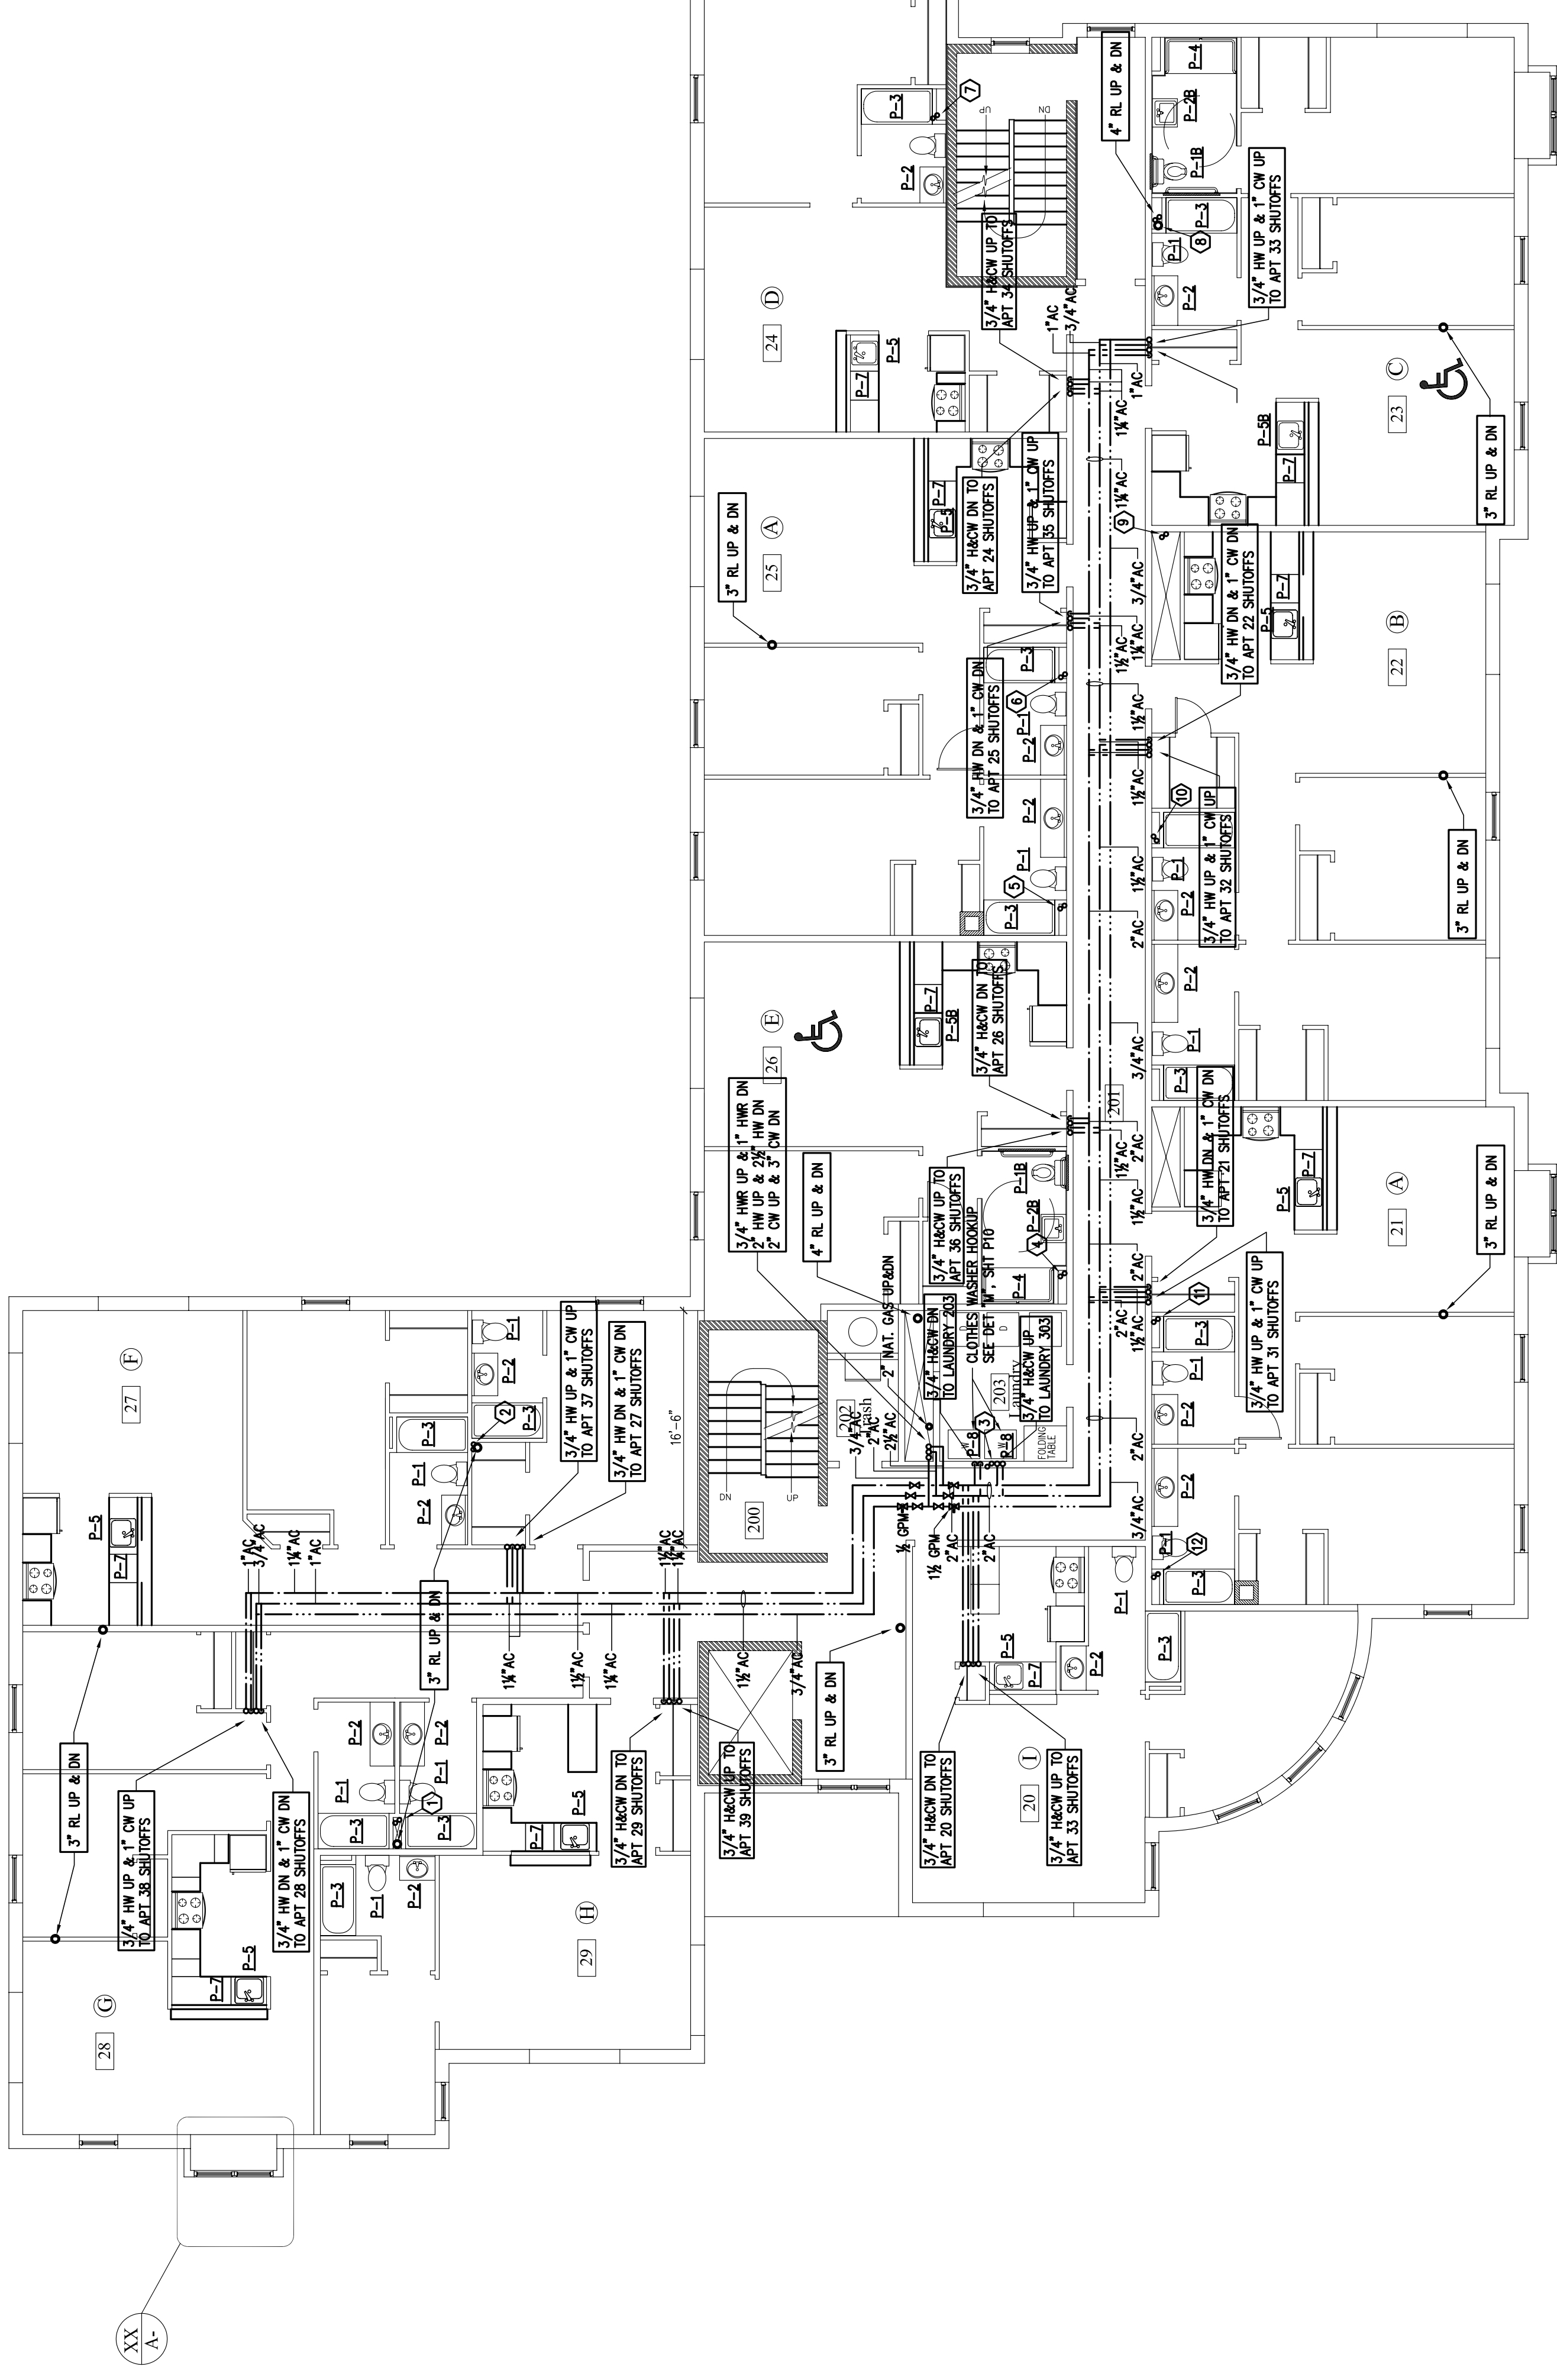

LOCATION MAP
N.T.S.

