




WALKER TERRACE  
PLUMBING  
FIFTH FLOOR  
PLAN

Date:	7-12-05
Scale:	AS NOTED
Revisions:	Drawn By: CLC Checked By: AWM

ARCHETYPE, P.A.  
ARCHITECTS  
48 Union Wharf Portland, Maine 04101  
(207) 772-6022 Fax (207) 772-4056

Project:  
WALKER TERRACE  
Walker Street,  
Portland, Maine 04101

Owner:  
MAINE WORKFORCE HOUSING, LLC  
One Longfellow Square, Portland, Maine 04101  
(207) 871-9811 Fax (207) 761-0155

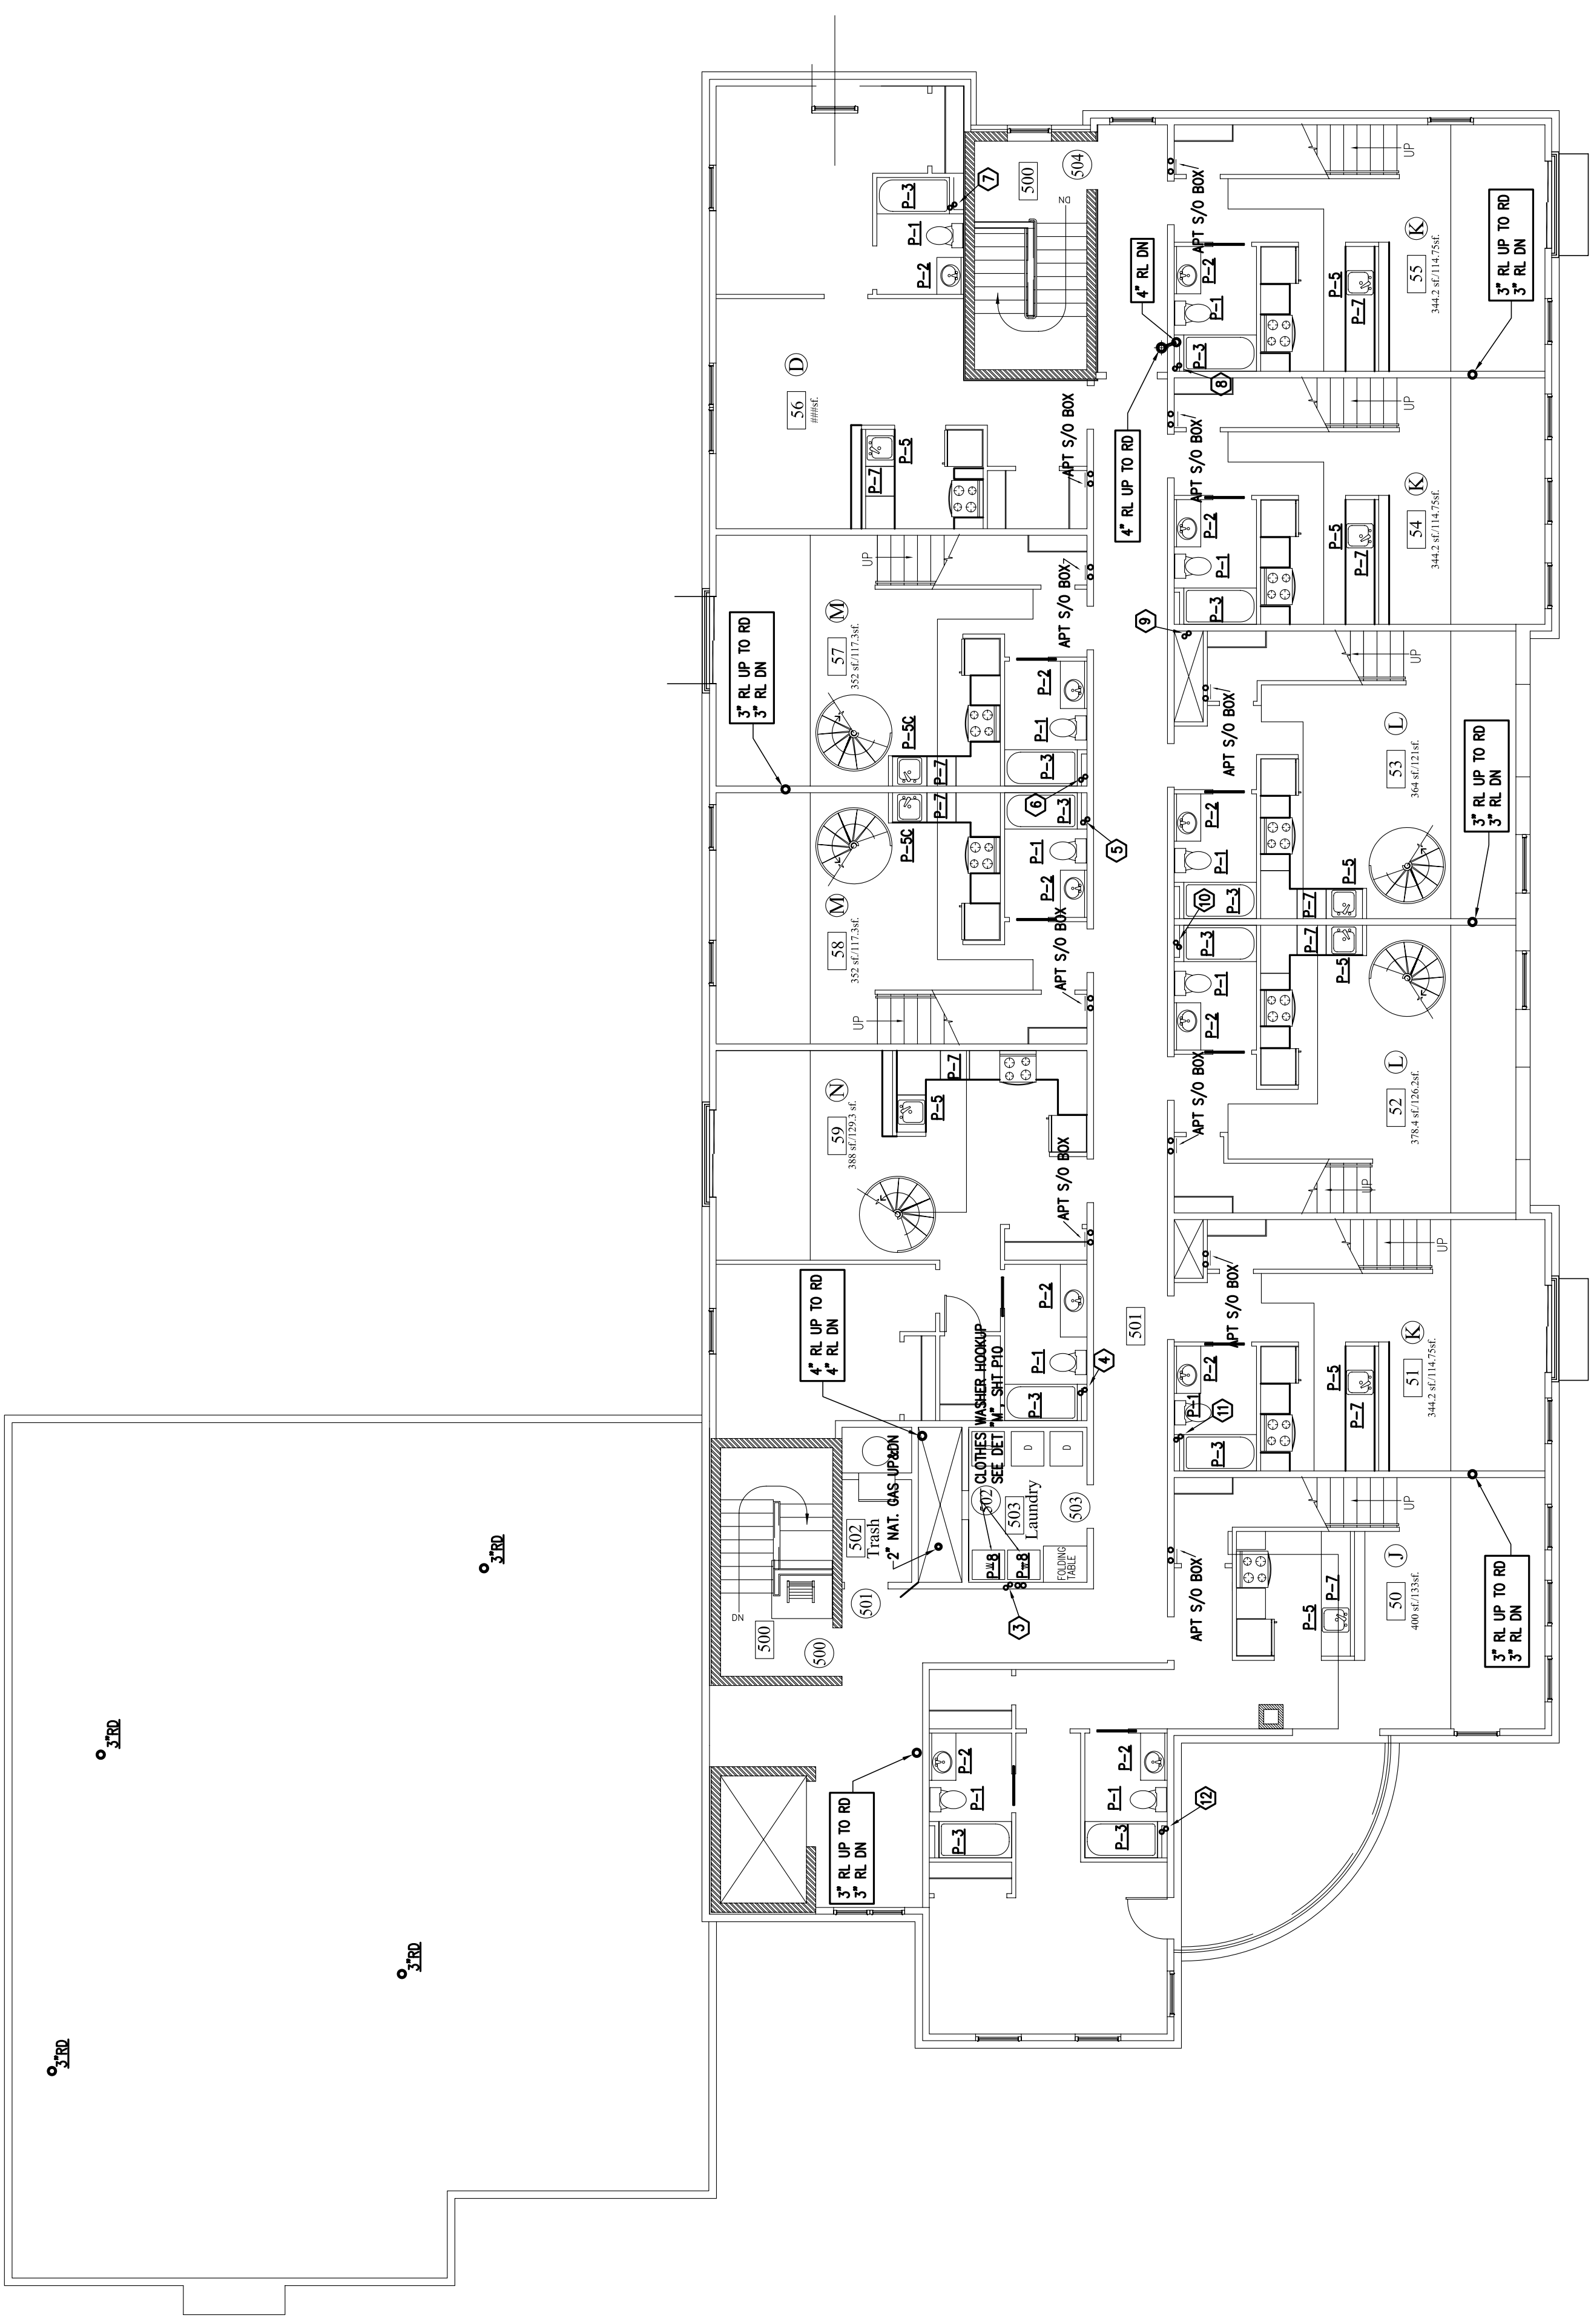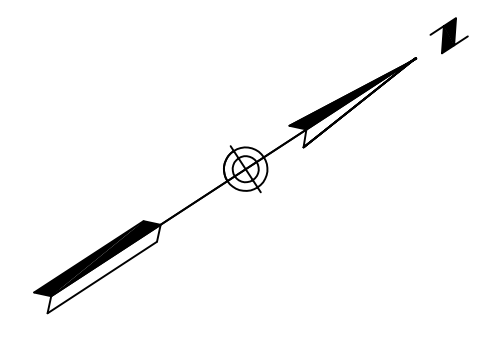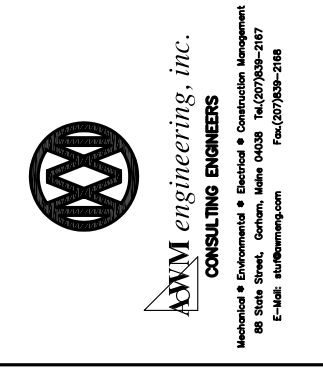

FIFTH FLOOR PLUMBING PLAN  
SCALE: 1/8" = 1'-0"

