

P7

FOR
SUBMISSION
7-12-05




WALKER TERRACE
PLUMBING
MEZZANINE FLOOR
PLAN

Date:	7-12-05
Drawn By:	CLC
Checked By:	AWM
Revisions:	
Scale:	AS NOTED

ARCHETYPE, P.A.
ARCHITECTS
48 Union Wharf Portland, Maine 04101
(207) 772-6022 Fax (207) 772-4056

Project:
WALKER TERRACE
Walker Street,
Portland, Maine 04101

Owner:
MAINE WORKFORCE HOUSING, LLC
One Longfellow Square, Portland, Maine 04101
(207) 871-9811 Fax (207) 761-0155

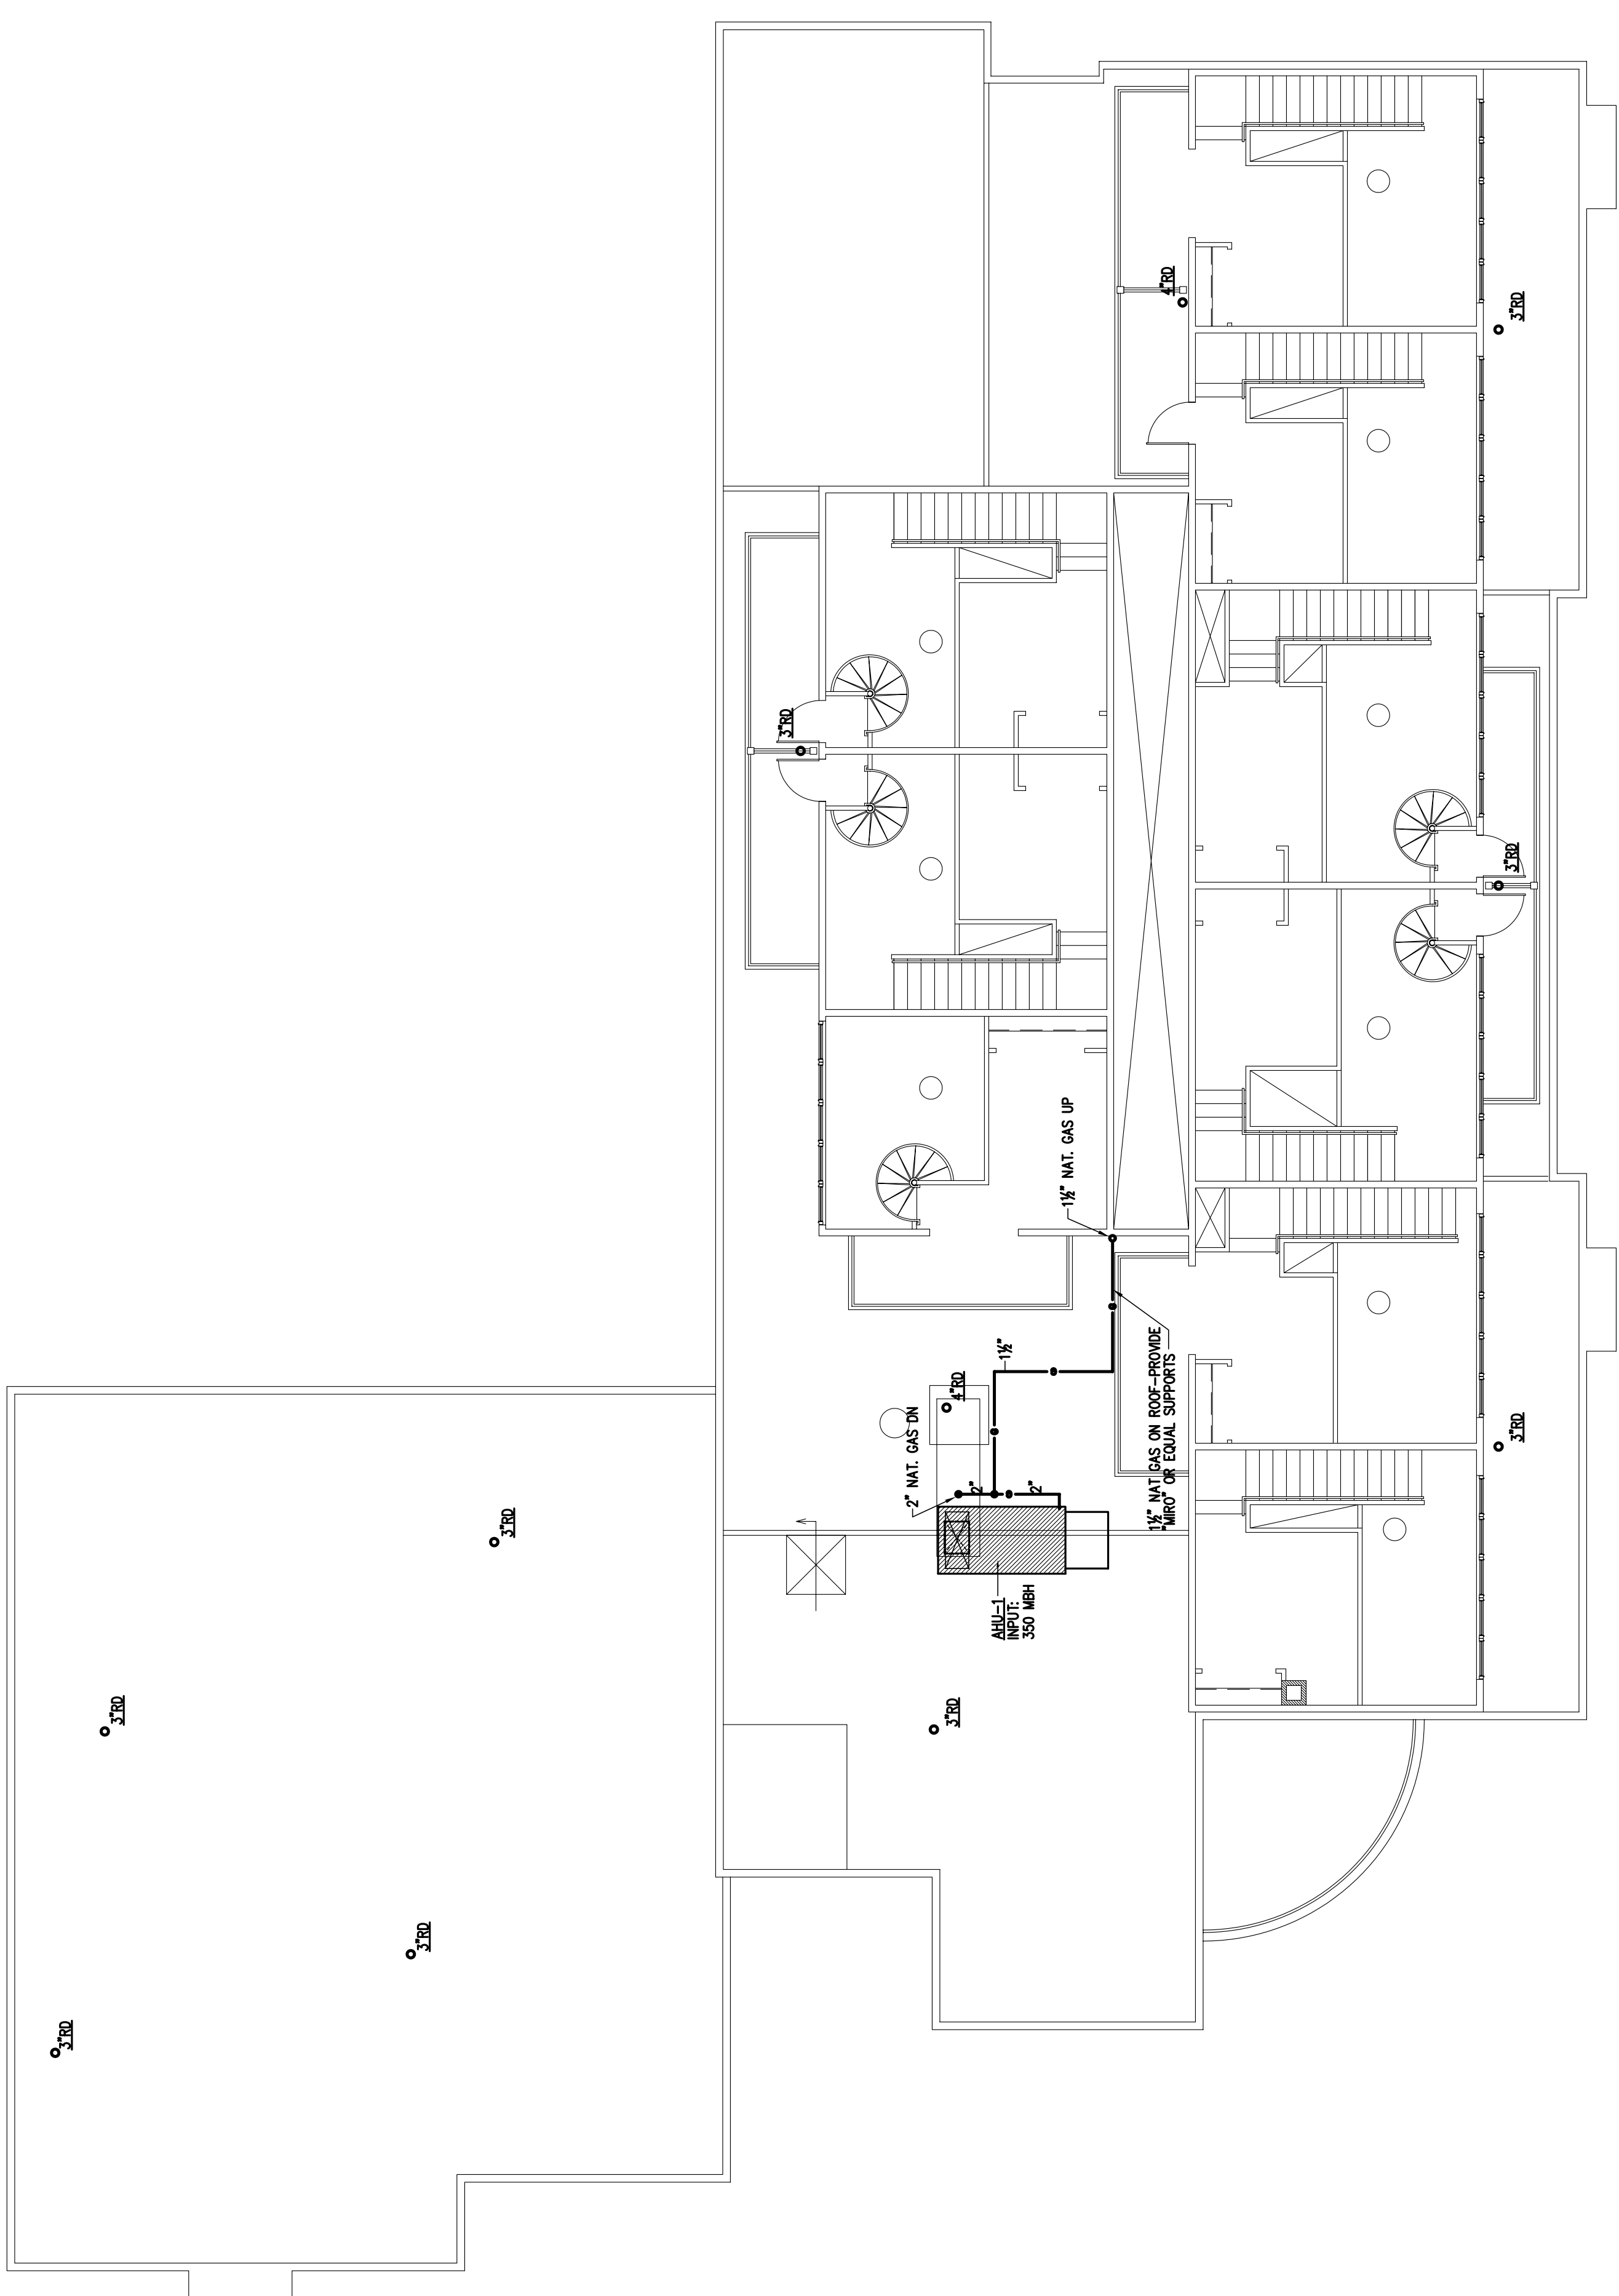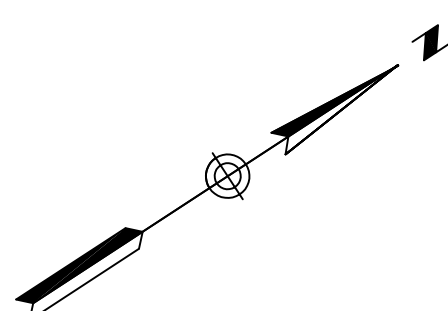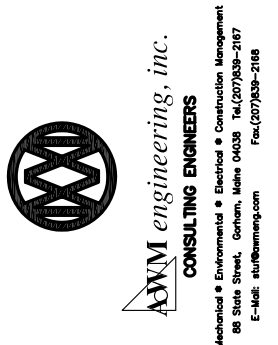

MEZZANINE LEVEL PLUMBING PLAN
SCALE: 1/8" = 1'-0"

