

P8

FOR
SUBMISSION
7-12-05

WALKER TERRACE

PLUMBING

ROOF

PALN

Date: 7-12-05

Scale: AS NOTED

Checked By: CLC

Drawn By: CLC

Revisions:

AS NOTED

Checked By: AWM

ARCHETYPE, P.A.
ARCHITECTS

48 Union Wharf Portland, Maine 04101
(207) 772-6022 Fax (207) 772-4056

Project: WALKER TERRACE



Walker Street,
Portland, Maine 04101

Owner: MAINE WORKFORCE HOUSING, LLC

One Longfellow Square, Portland, Maine 04101
(207) 871-9811 Fax (207) 761-0155



AXM engineering, inc.
CONSULTING ENGINEERS
MECHANICAL, ELECTRICAL, PLUMBING
100 State Street, Portland, Maine 04101
Tel: (207) 871-9811 Fax: (207) 761-0155
www.axm-engineering.com

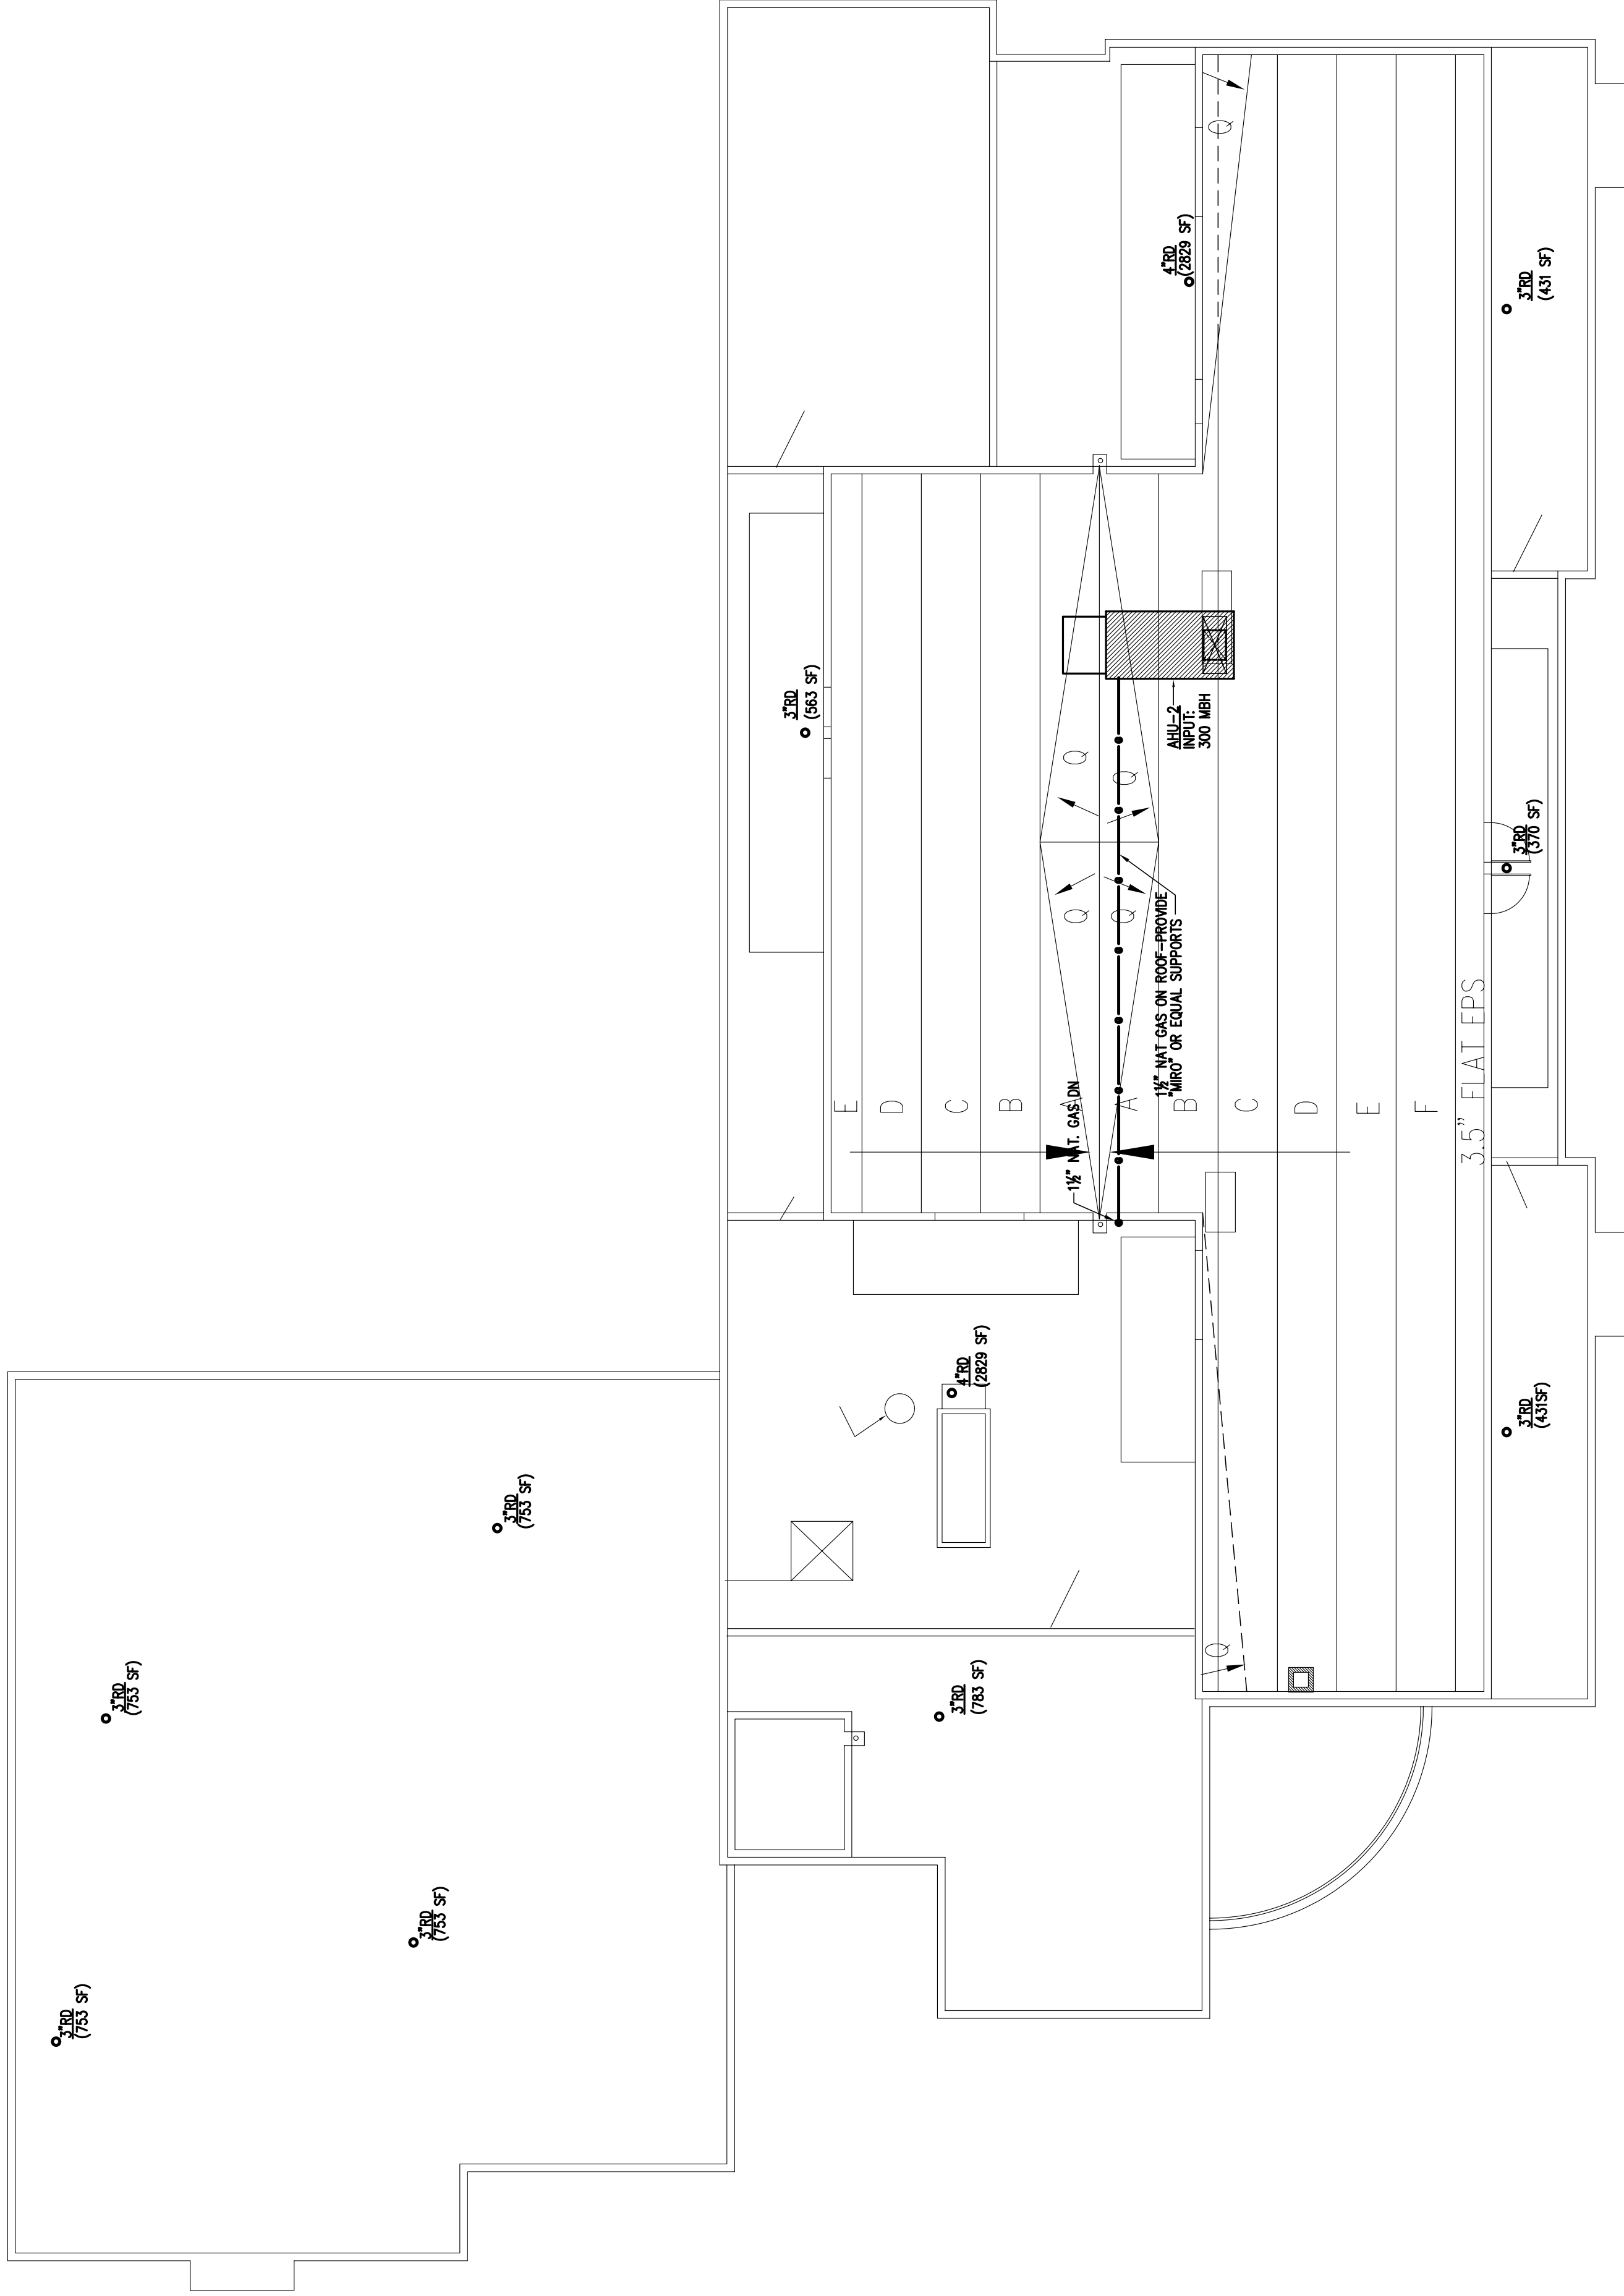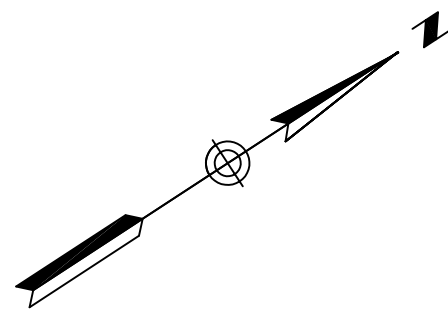

ROOF LEVEL PLUMBING PLAN
SCALE: 1/8" = 1'-0"

LOCATION MAP
N.T.S.

