

Rev #	Date	Description

FUELING PIPING AND TANK PLAN
 7-11 #32531
 704 CONGRESS STREET
 PORTLAND, ME 04102
 7-EL EVEN, INC.
 1722 ROUTH STREET, DALLAS, TEXAS 75221



CORE STATES GROUP
 ONE ARTS PLAZA
 7-EL EVEN, INC.

Checked By: CPS
 Drawn By: WLL
 Date: 04/07/15
 Scale: AS NOTED
 Job#: SEP-15380144






SHEET: G1
 FUELING - USA

GENERAL NOTES

- ALL CONSTRUCTION SHALL BE IN ACCORDANCE WITH THE LATEST EDITIONS OF THE INTERNATIONAL CODE BOOKS.
- THE CONTRACTOR SHALL MAINTAIN FULLY ACCESSIBLE TO ALL AT ALL TIMES THROUGHOUT THE PROJECT. ANY DIFFERENCES BETWEEN THE CONTRACT AND THE PERMITS SHALL BE RESOLVED BY THE CONTRACTOR PRIOR TO COMMENCEMENT OF CONSTRUCTION.
- PERMITS AND CONTRACTS SHALL BE THE RESPONSIBILITY OF THE CONTRACTOR. THE CONTRACTOR SHALL BE RESPONSIBLE FOR THE INTEGRITY OF THE INSTALLATION. THE CONTRACTOR SHALL BE RESPONSIBLE FOR OBTAINING ALL NECESSARY PERMITS AND CONTRACTS PRIOR TO COMMENCEMENT OF CONSTRUCTION.
- AT THE COMPLETION OF THE INSTALLATION, THE CONTRACTOR SHALL BE RESPONSIBLE FOR OBTAINING ALL NECESSARY PERMITS AND CONTRACTS PRIOR TO COMMENCEMENT OF CONSTRUCTION.
- PERMITS AND CONTRACTS SHALL BE THE RESPONSIBILITY OF THE CONTRACTOR. THE CONTRACTOR SHALL BE RESPONSIBLE FOR THE INTEGRITY OF THE INSTALLATION. THE CONTRACTOR SHALL BE RESPONSIBLE FOR OBTAINING ALL NECESSARY PERMITS AND CONTRACTS PRIOR TO COMMENCEMENT OF CONSTRUCTION.

KEY NOTES

- REPLACE SLAB AT FUELING CANOPY.
- GLAZED FABRIC MATERIAL TO EXTEND 12" PAST EACH SIDE OF PIPING TRENCH AND TANK COVER.
- CONTRACTOR SHALL BE RESPONSIBLE FOR OBTAINING ALL NECESSARY PERMITS AND CONTRACTS PRIOR TO COMMENCEMENT OF CONSTRUCTION.
- PERMITS AND CONTRACTS SHALL BE THE RESPONSIBILITY OF THE CONTRACTOR. THE CONTRACTOR SHALL BE RESPONSIBLE FOR THE INTEGRITY OF THE INSTALLATION. THE CONTRACTOR SHALL BE RESPONSIBLE FOR OBTAINING ALL NECESSARY PERMITS AND CONTRACTS PRIOR TO COMMENCEMENT OF CONSTRUCTION.

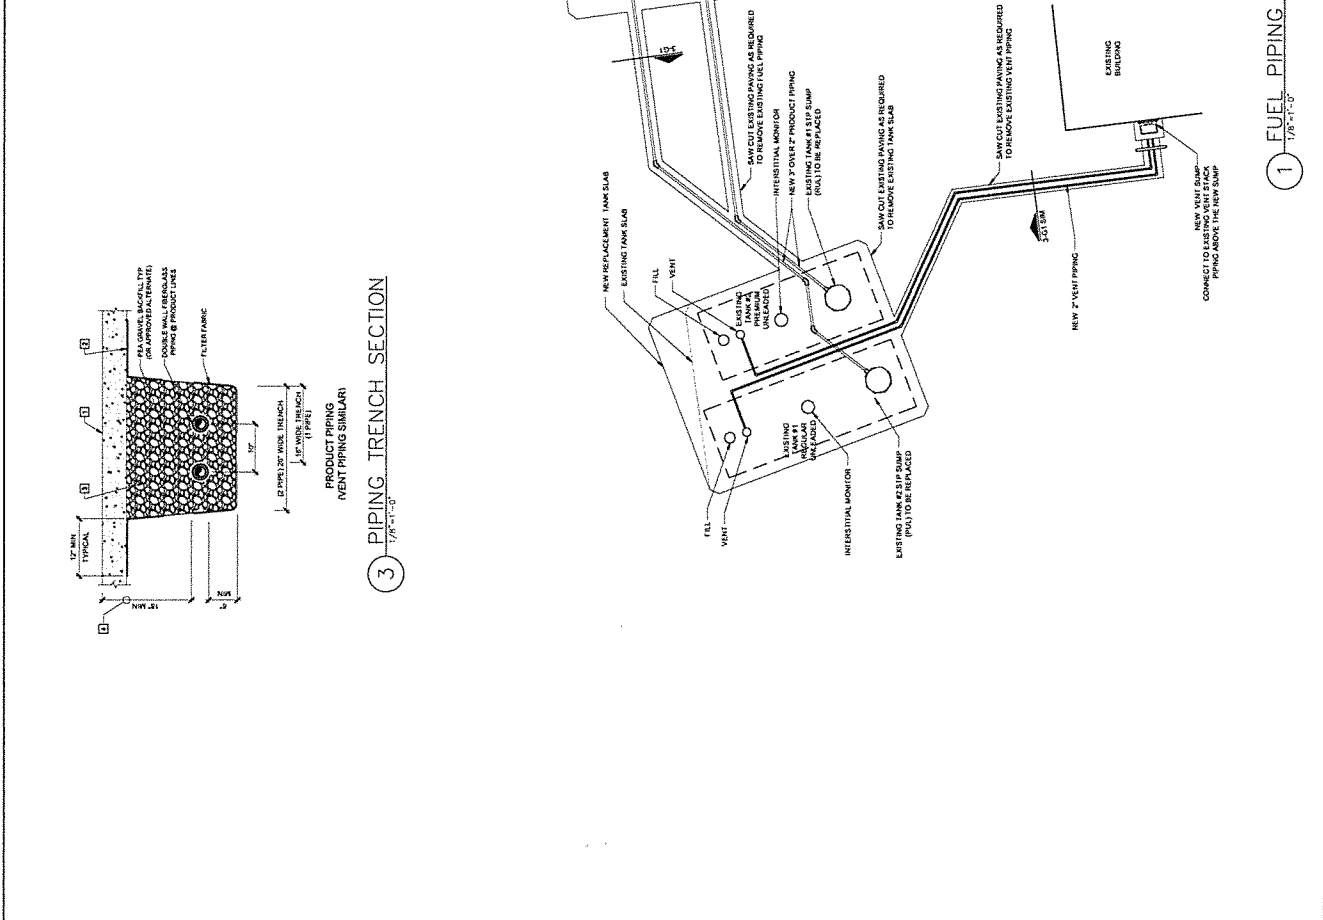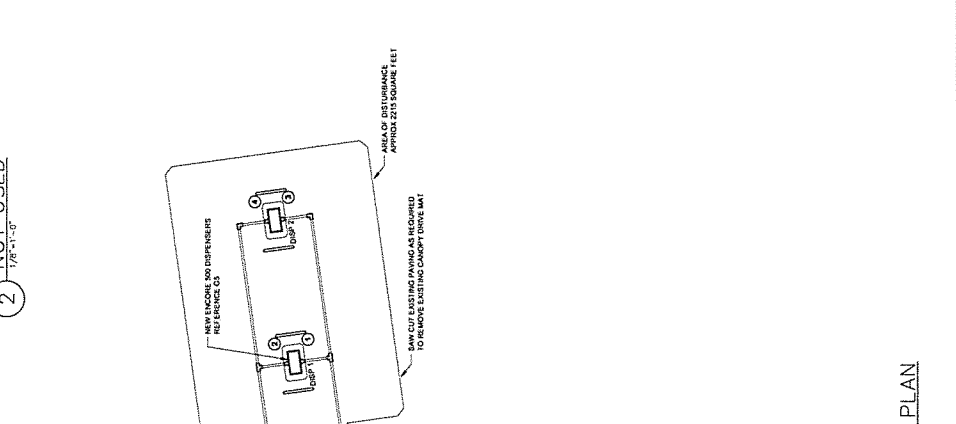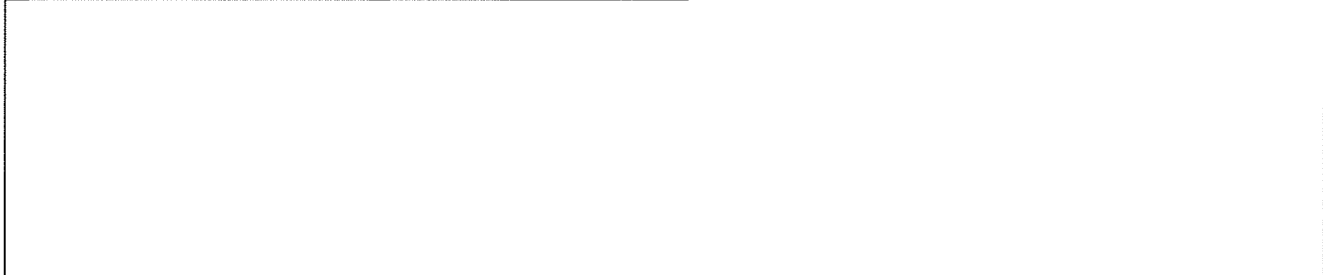

1 FUEL PIPING PLAN
 1/8\"/>