



1 Foundation
A5.1 SCALE: 1/4" = 1'-0"

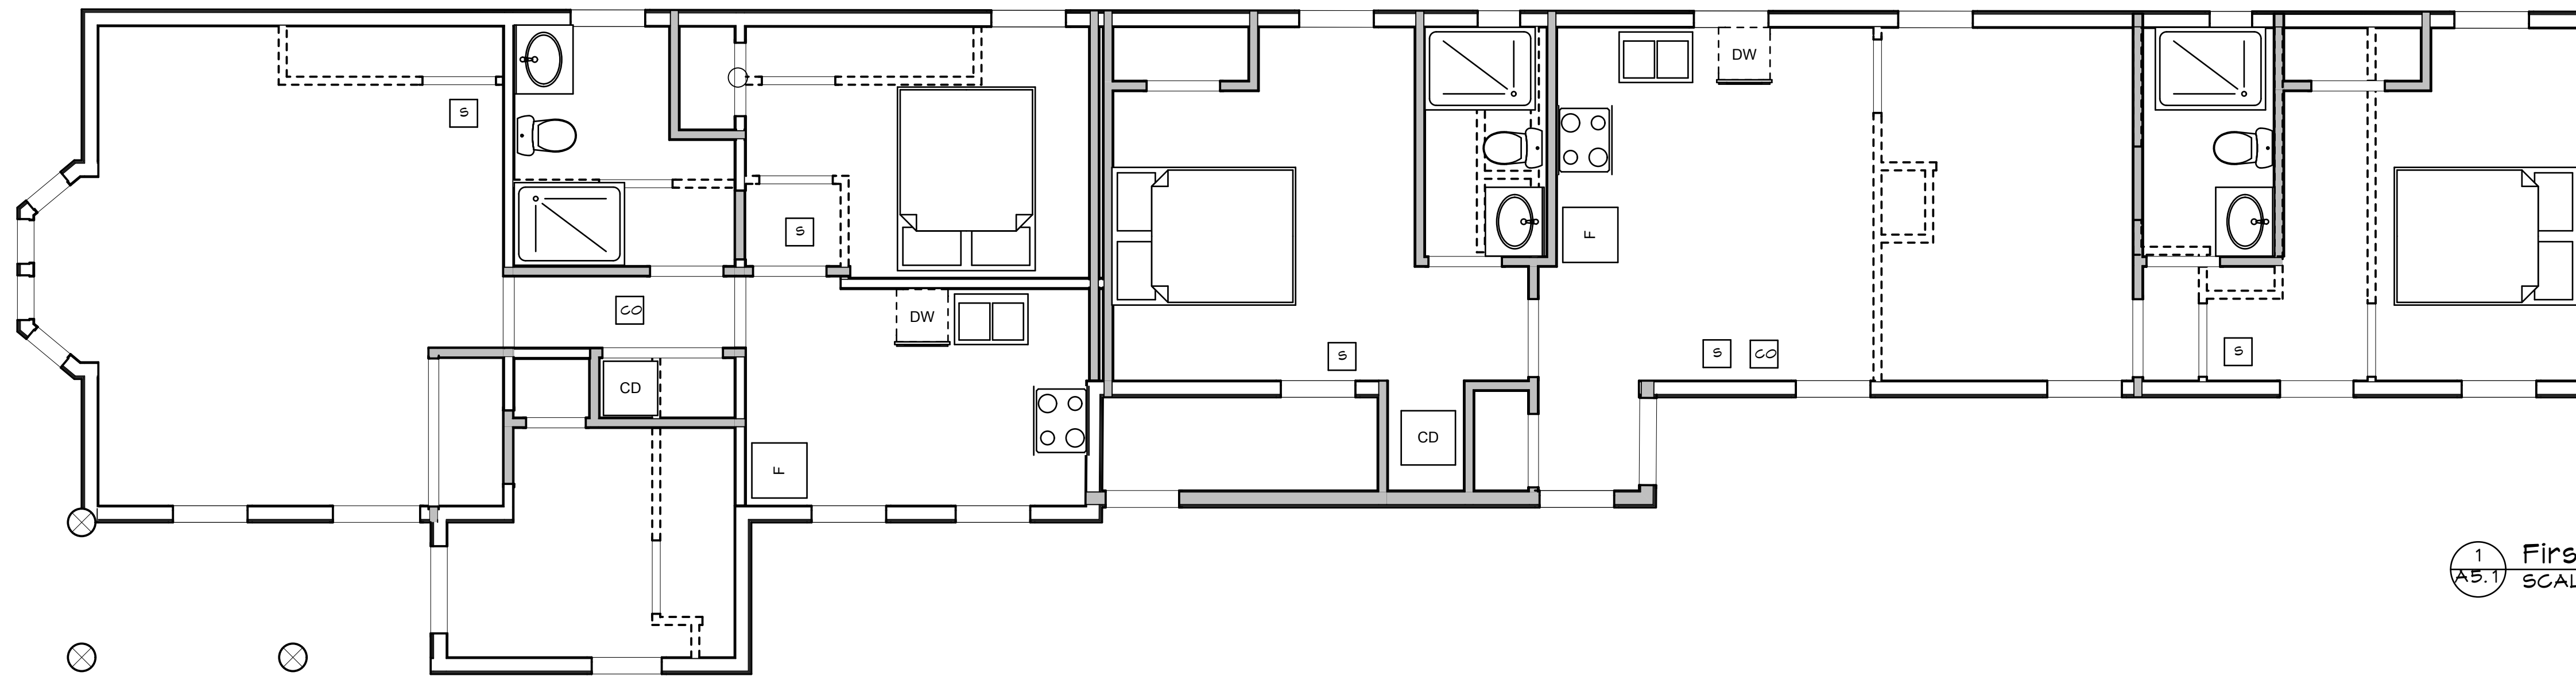

1 First Floor Ceiling Plan
A5.1 SCALE: 1/4" = 1'-0"

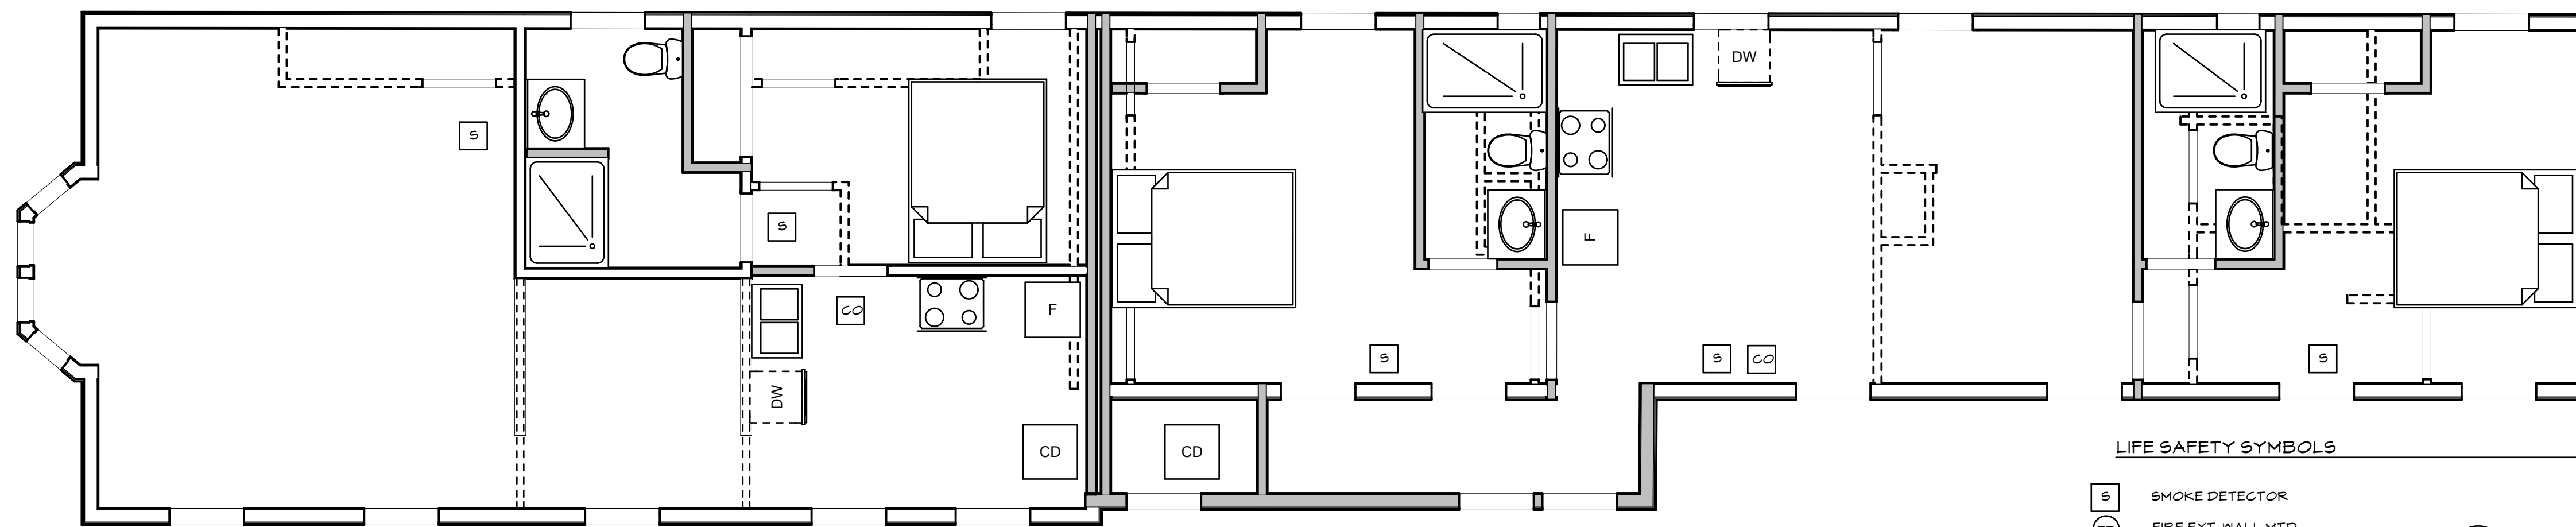


- LIFE SAFETY SYMBOLS
- S SMOKE DETECTOR
 - FE FIRE EXT. WALL MTD.
 - CO CARBON MONOXIDE DETECTOR


1 Second Floor Ceiling Plan
A5.1 SCALE: 1/4" = 1'-0"



13 LEWIS STREET
 13 LEWIS STREET PORTLAND, MAINE

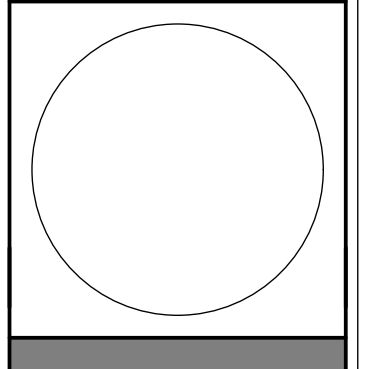

WHIPPLE —
CALLENDER
ARCHITECTS

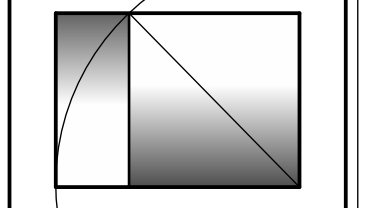

136 PLEASANT AVE.
PORTLAND, ME 04103
P 207.115.2616
F 207.115.5631
www.whipplecallender.com

| DATE | DESCRIPTION |
|------|-------------|
| | |
| | |
| | |
| | |

DATE: 10.22.13
CHECKED BY: JAD
DRAWN BY: JAD
JOB:

SHEET TITLE:
CEILING/FIRE PROTECTION PLAN

A5.1