



1 Foundation  
A5.1 SCALE: 1/4" = 1'-0"

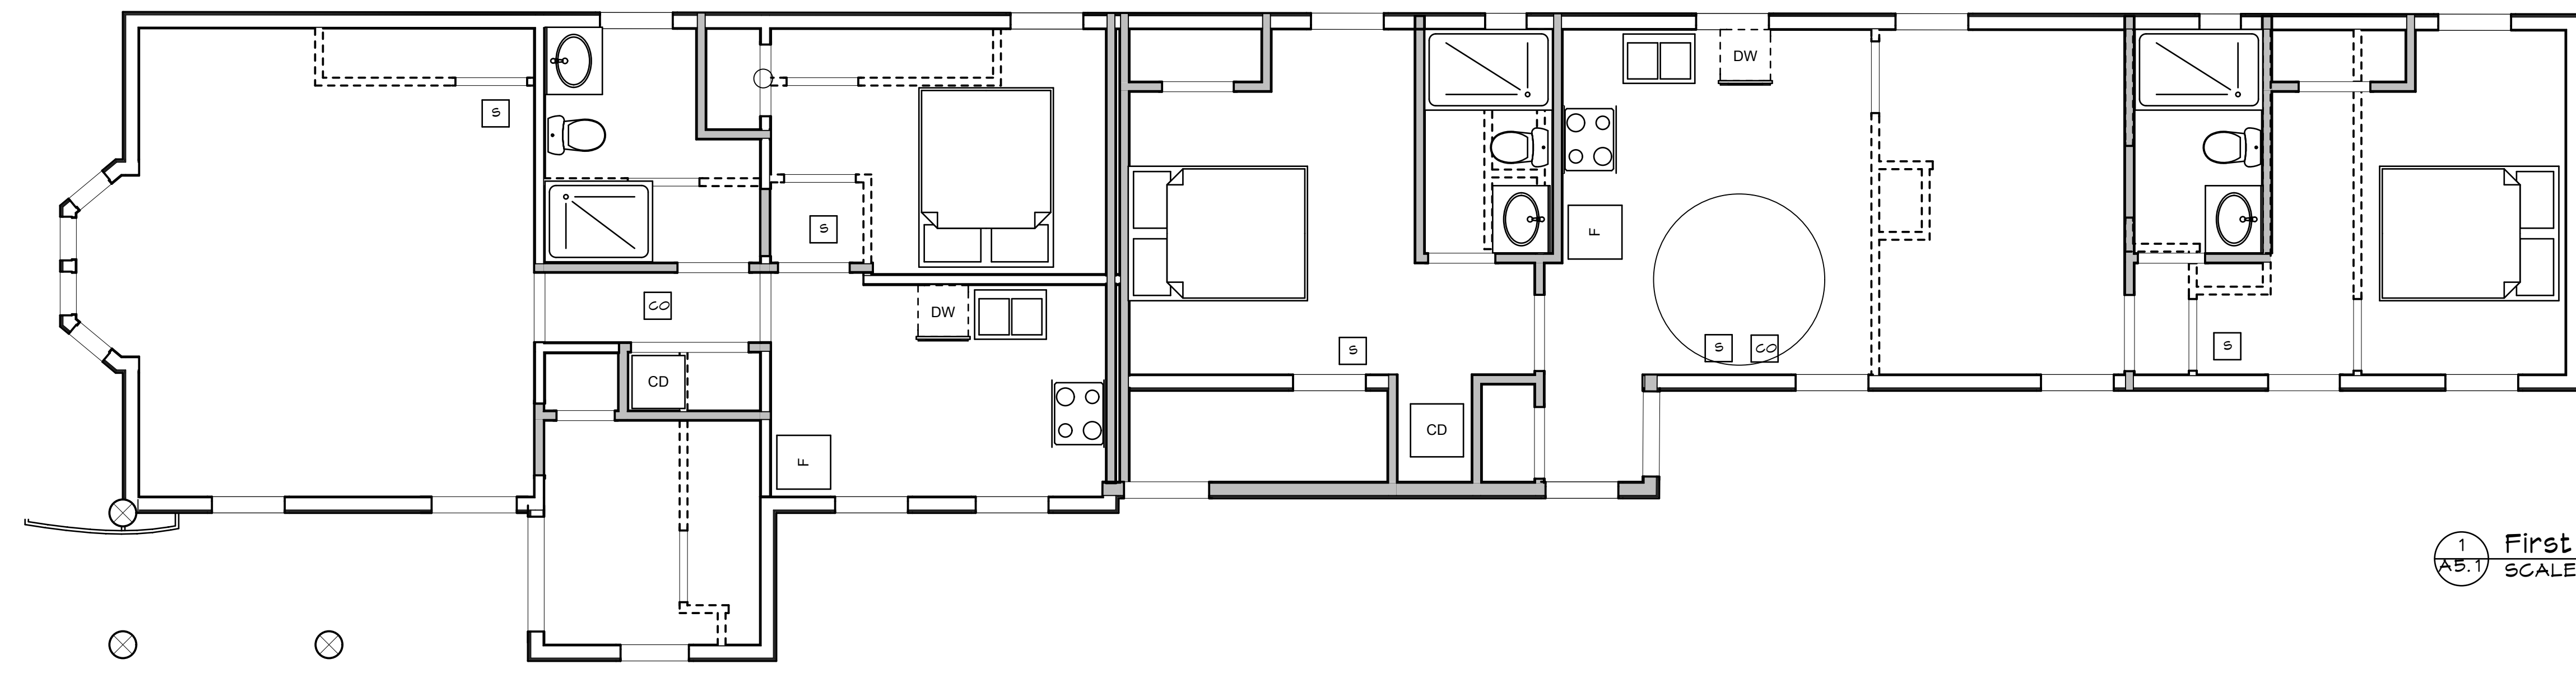

1 First Floor Ceiling Plan  
A5.1 SCALE: 1/4" = 1'-0"

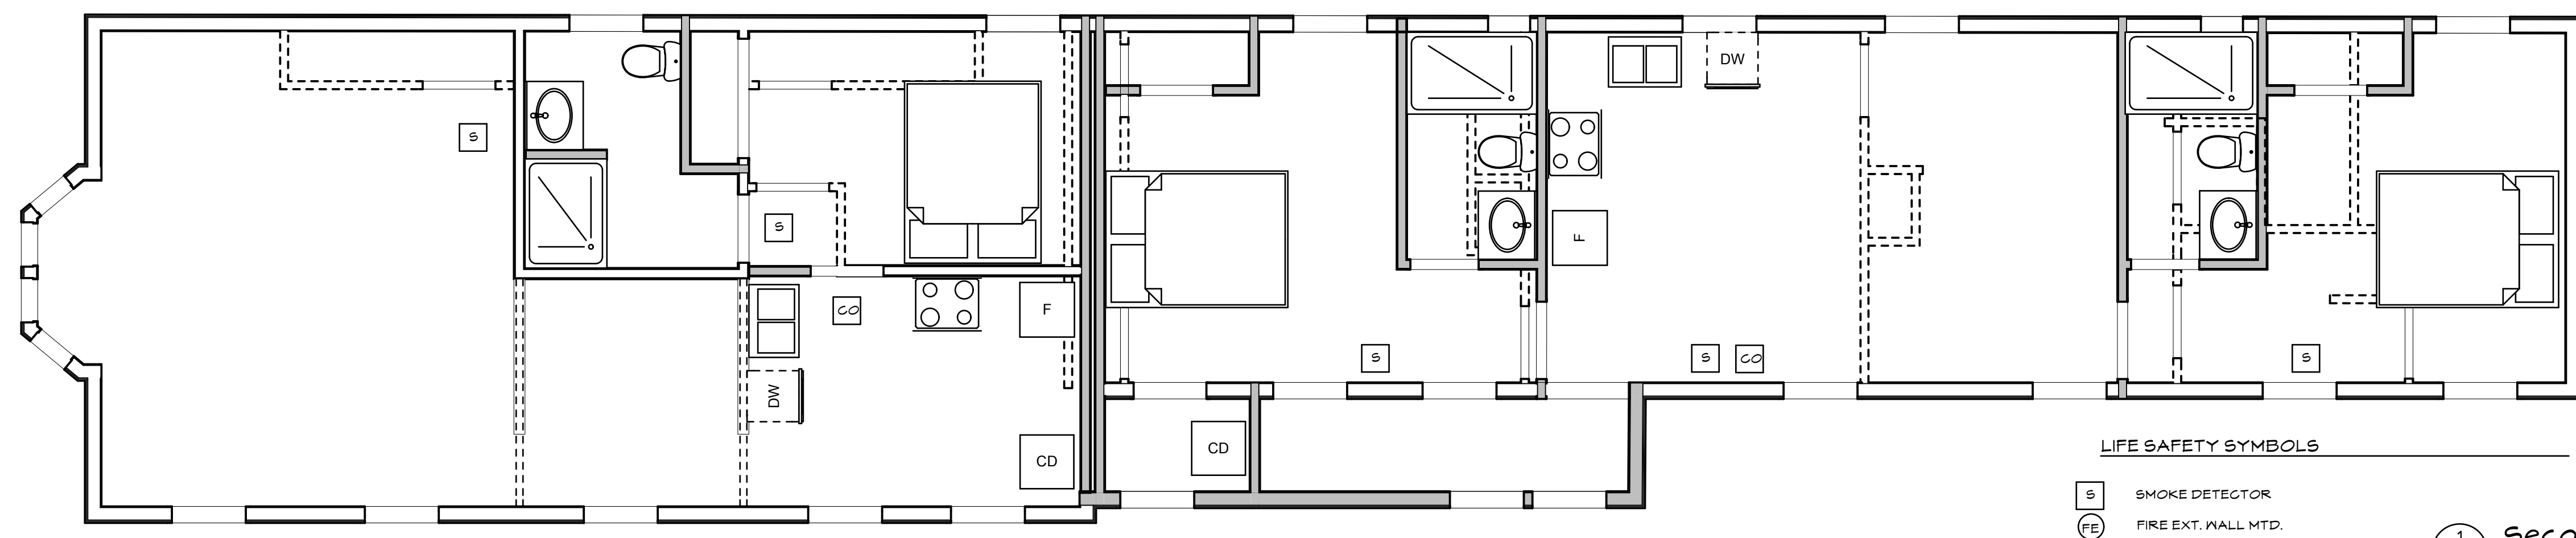

LIFE SAFETY SYMBOLS

- S SMOKE DETECTOR
- FE FIRE EXT. WALL MTD.
- CD CARBON MONOXIDE DETECTOR


1 Second Floor Ceiling Plan  
A5.1 SCALE: 1/4" = 1'-0"



THIS DRAWING IS AN INSTRUMENT OF SERVICE AND SHALL REMAIN THE PROPERTY OF WHIPPLE CALLENDER ARCHITECTS. IT SHALL NOT BE USED FOR ANY OTHER PURPOSE THAT FOR WHICH IT IS SPECIFICALLY FURNISHED.

13 LEWIS STREET  
13 LEWIS STREET PORTLAND, MAINE

WHIPPLE — CALLENDER ARCHITECTS

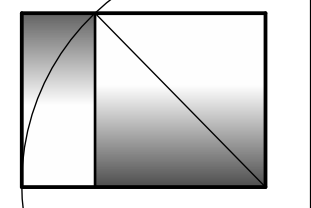

136 PLEASANT AVE.  
PORTLAND, ME 04103  
P 201.115.2616  
F 201.115.5631  
www.whipplecallender.com

MARK	DATE	DESCRIPTION
	11.5.13	CHECKED BY: JAD
		DRAWN BY: Initials
		JOB: ##-XXX
		SHEET TITLE: CEILING/FIRE PROTECTION PLAN

A5.1