



1 Foundation
A5.1 SCALE: 1/4" = 1'-0"

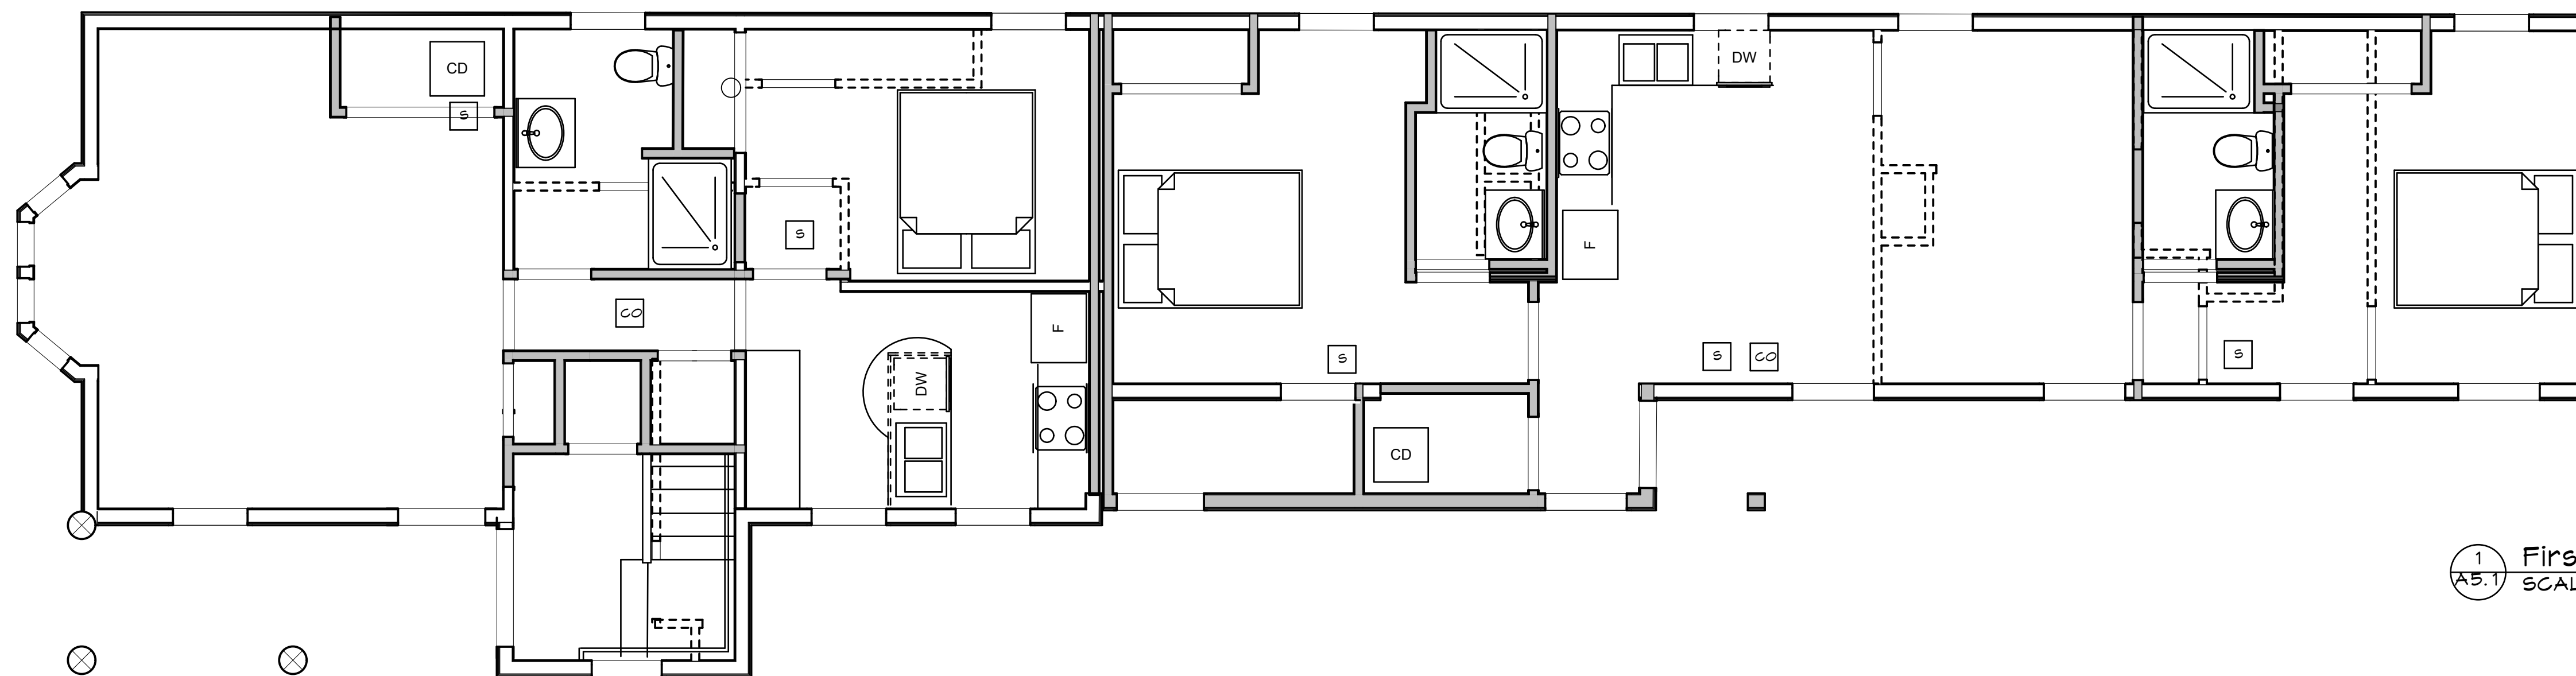


1 First Floor Ceiling Plan
A5.1 SCALE: 1/4" = 1'-0"

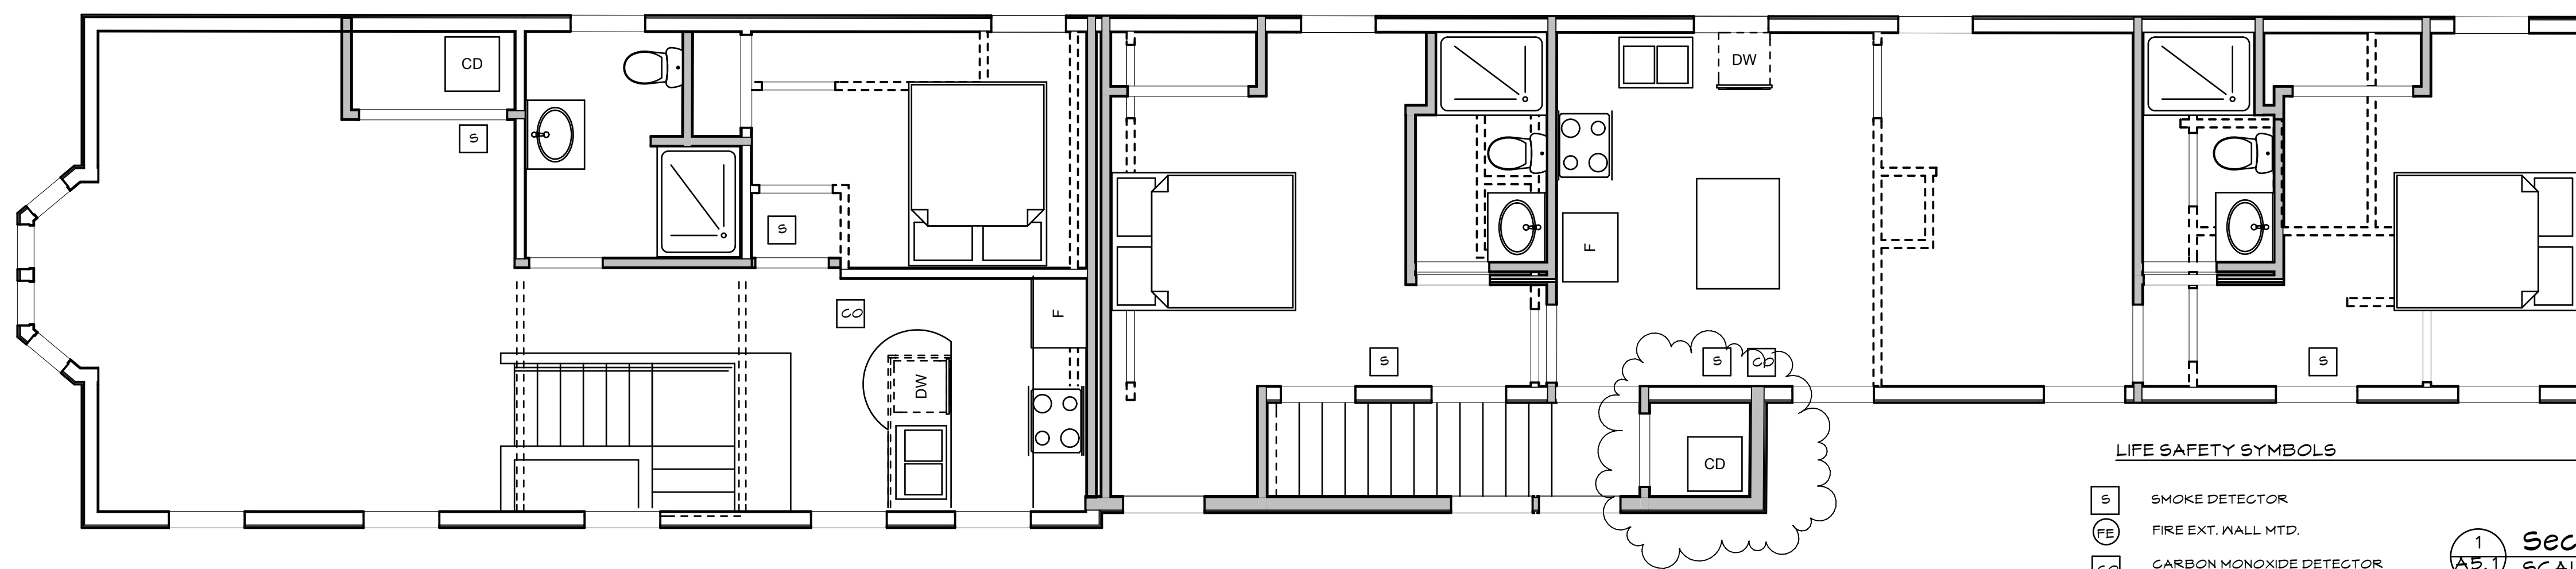


- LIFE SAFETY SYMBOLS
- S SMOKE DETECTOR
 - FE FIRE EXT. WALL MTD.
 - CO CARBON MONOXIDE DETECTOR

1 Second Floor Ceiling Plan
A5.1 SCALE: 1/4" = 1'-0"

13 LEWIS STREET
PORTLAND, MAINE

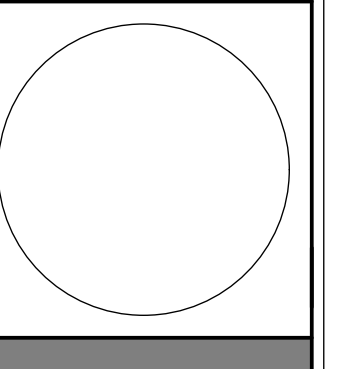

WHIPPLE —
CALLENDER
ARCHITECTS

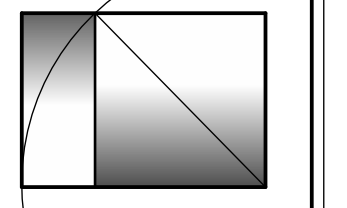

136 PLEASANT AVE.
PORTLAND, ME 04103
P 201.115.2616
F 201.115.5631
www.whipplecallender.com

DATE	DESCRIPTION
5.13.14	CHECKED BY: JAD
	DRAWN BY: JAD
	JOB: ##-XXX
	SHEET TITLE: CEILING/FIRE PROTECTION PLAN

A5.1