




Scott Simons Architects
75 York Street, Portland, Maine 04101
www.simonsarchitects.com
207.772.4656

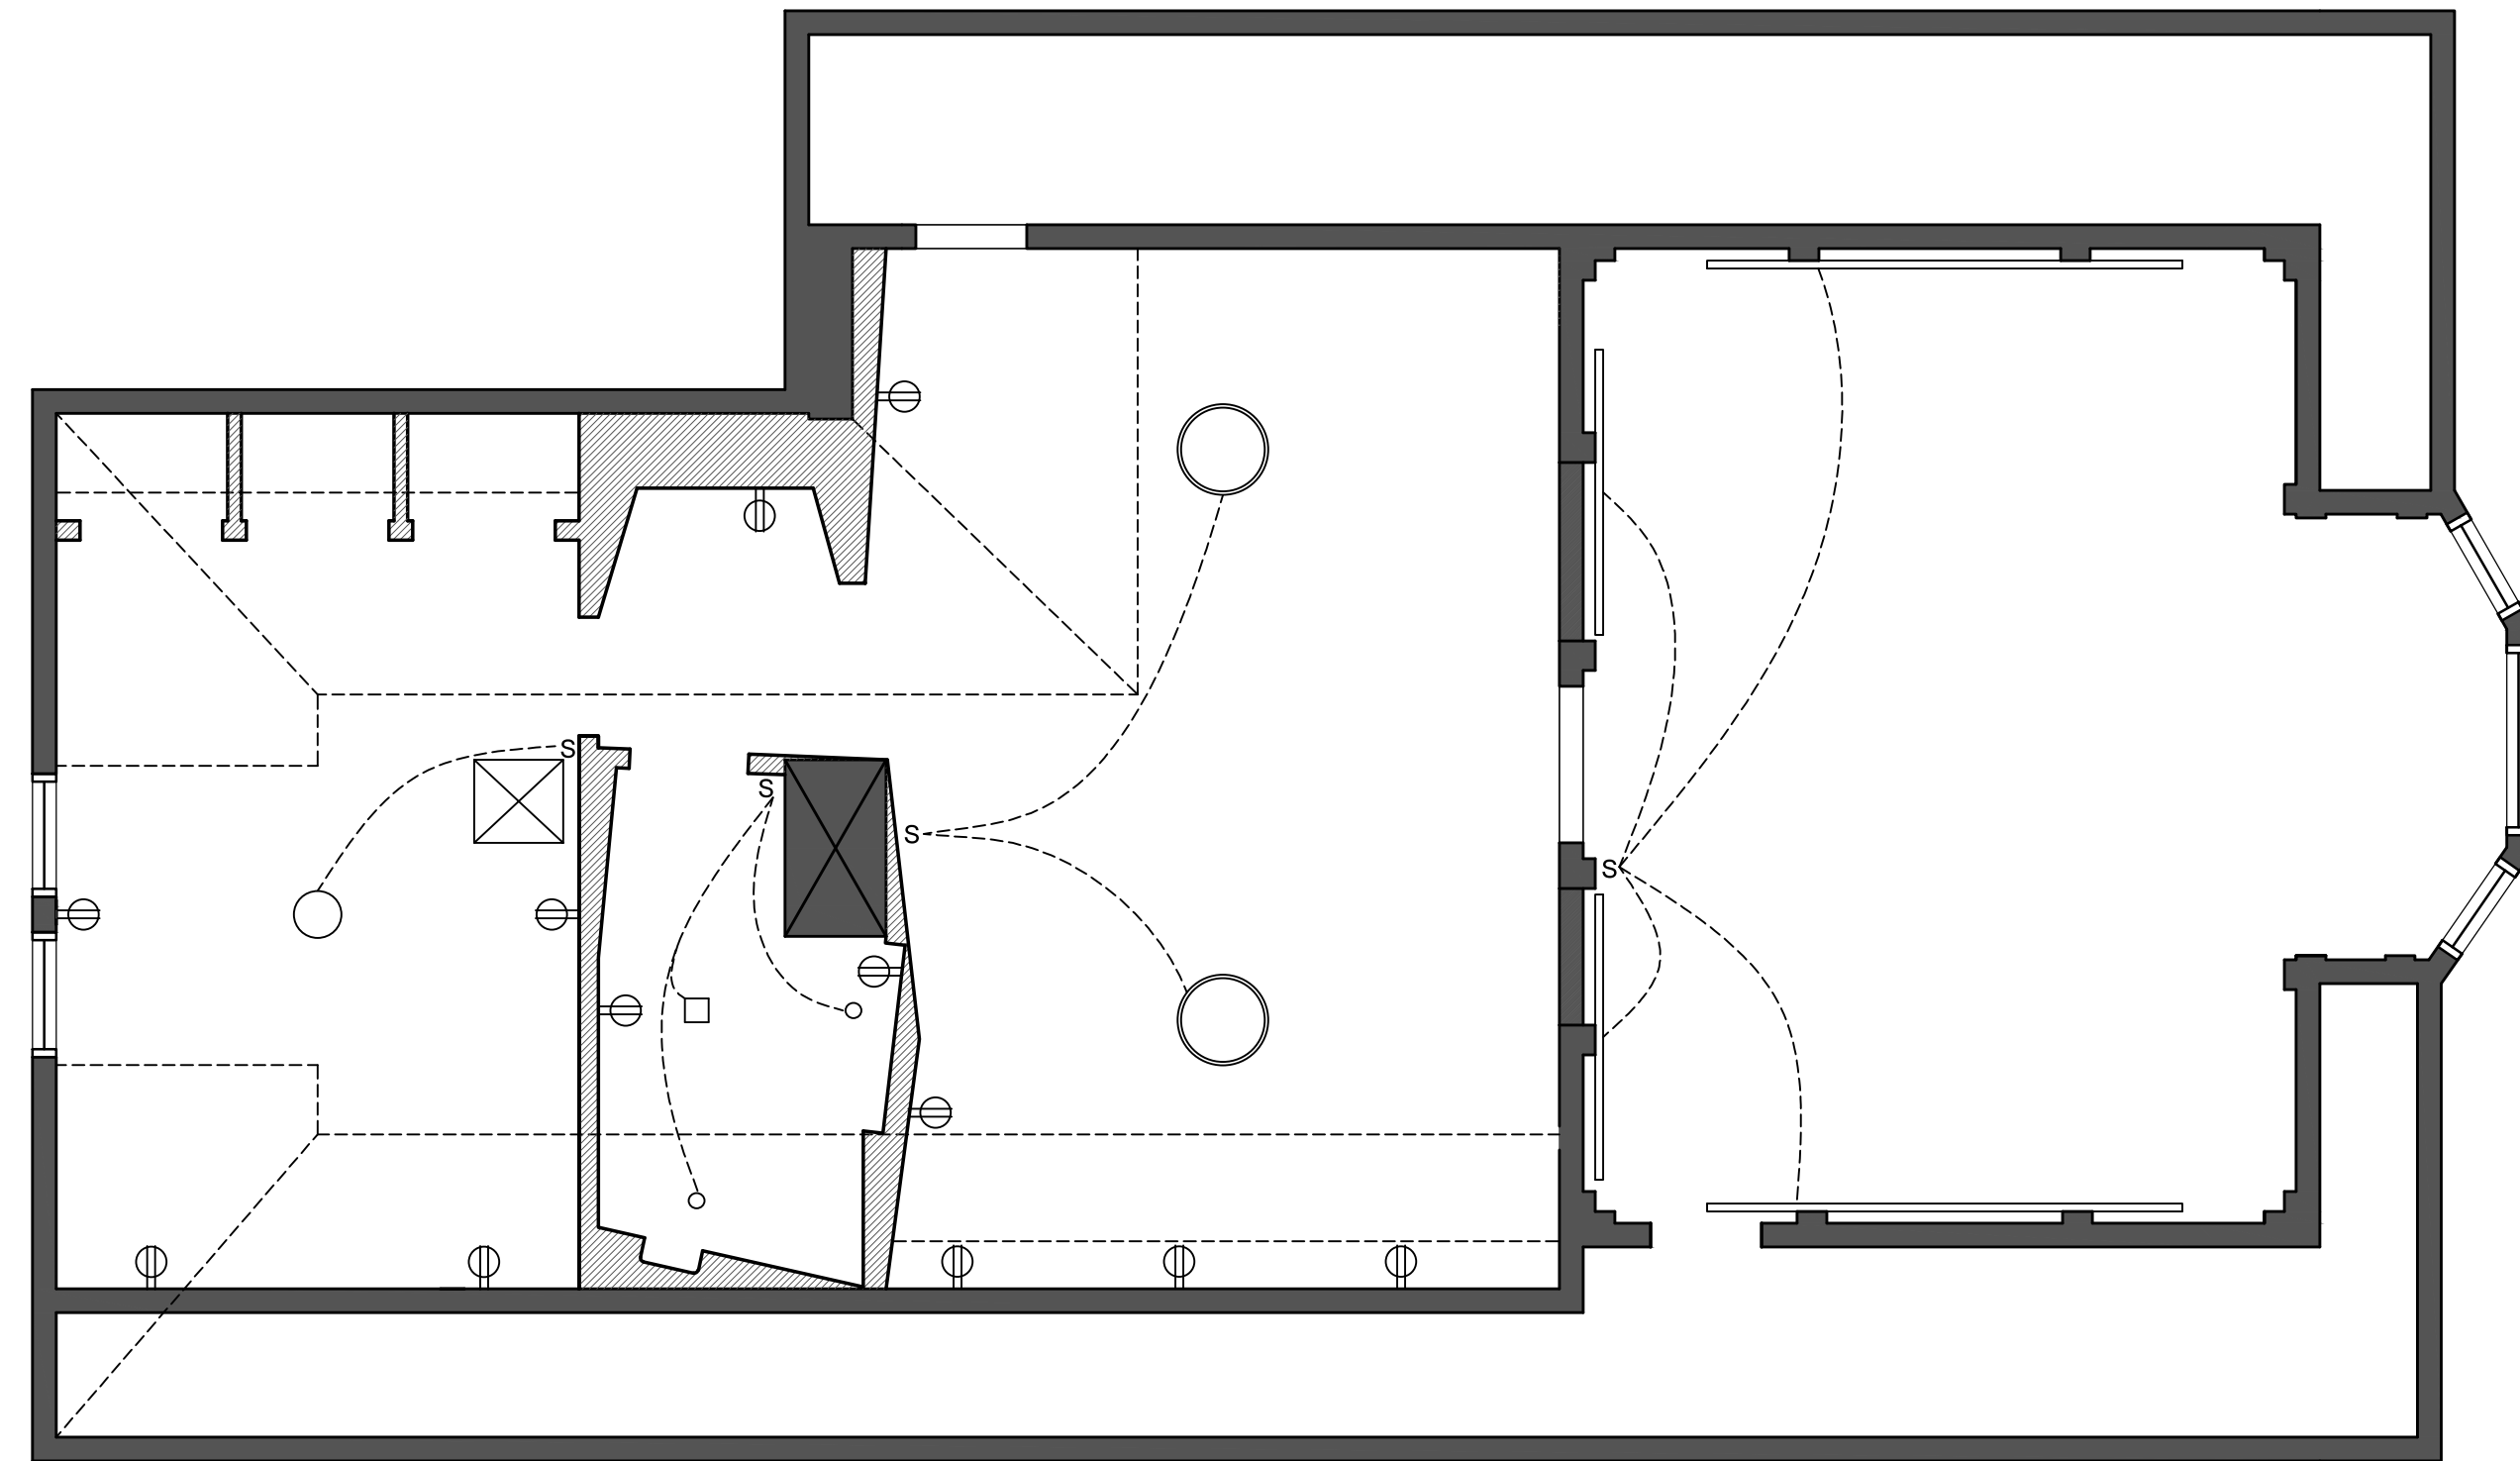


1 Electrical Plan
SCALE: 1/4" = 1'-0" 

PROJECT NAME:

**COLEMAN
RESIDENCE
RENOVATIONS**

CUSHMAN STREET
PORTLAND, MAINE

SEAL:

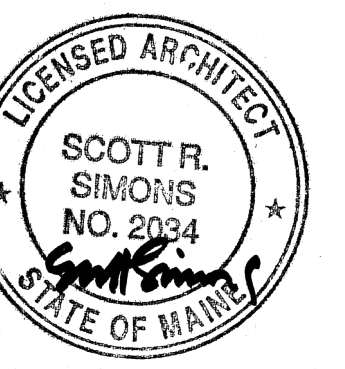

THIS DRAWING IS THE PROPERTY OF SCOTT SIMONS ARCHITECTS (SSA) AND IS NOT TO BE COPIED OR REPRODUCED IN PART OR WHOLE. 2012 © SCOTT SIMONS ARCHITECTS, LLC

REVISION:

DATE OF ISSUE: APRIL 03, 2015

PROJECT NUMBER: 2014-0040

STATUS: PROGRESS PRINT

**THIRD FLOOR
REFLECTED
CEILING PLAN**

A131