




EXISTING SECOND LEVEL

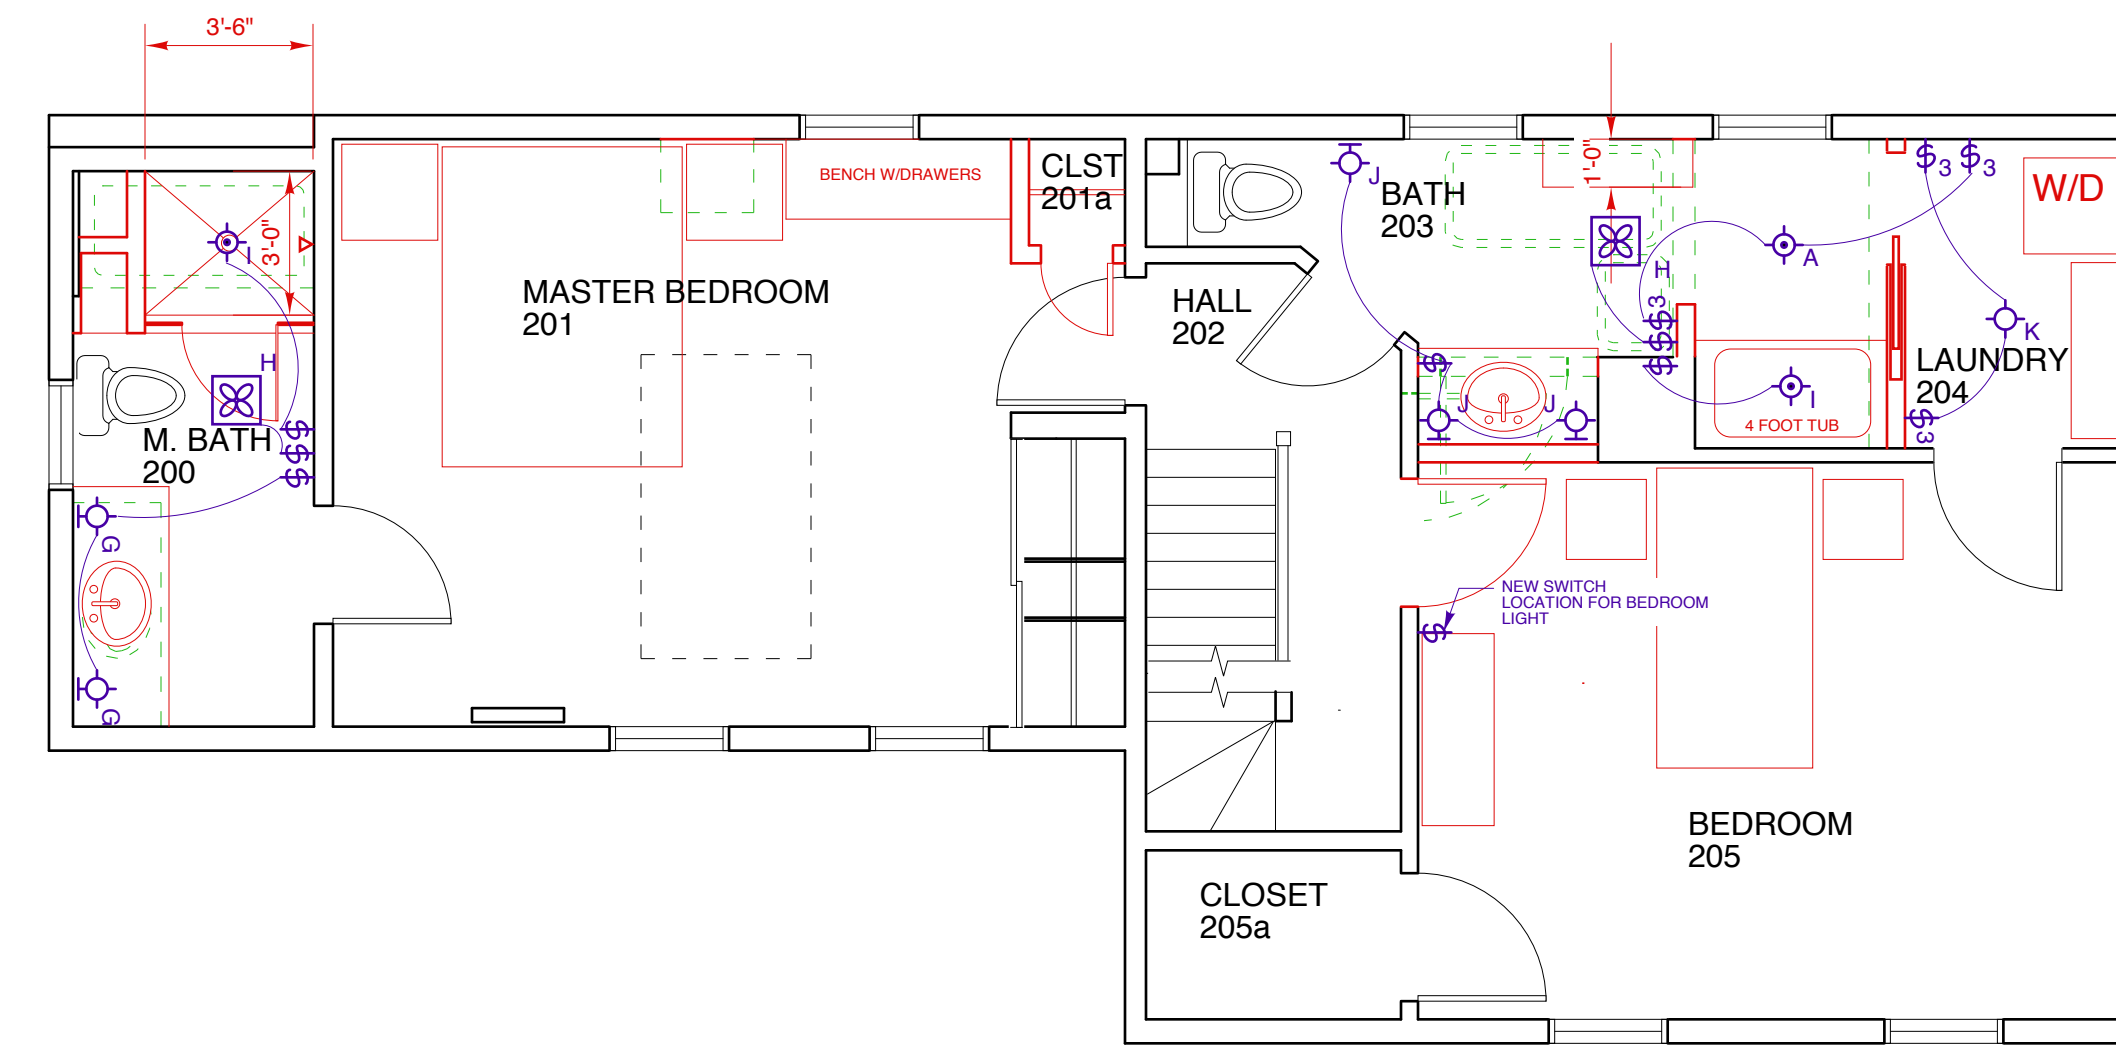

PROPOSED SECOND LEVEL

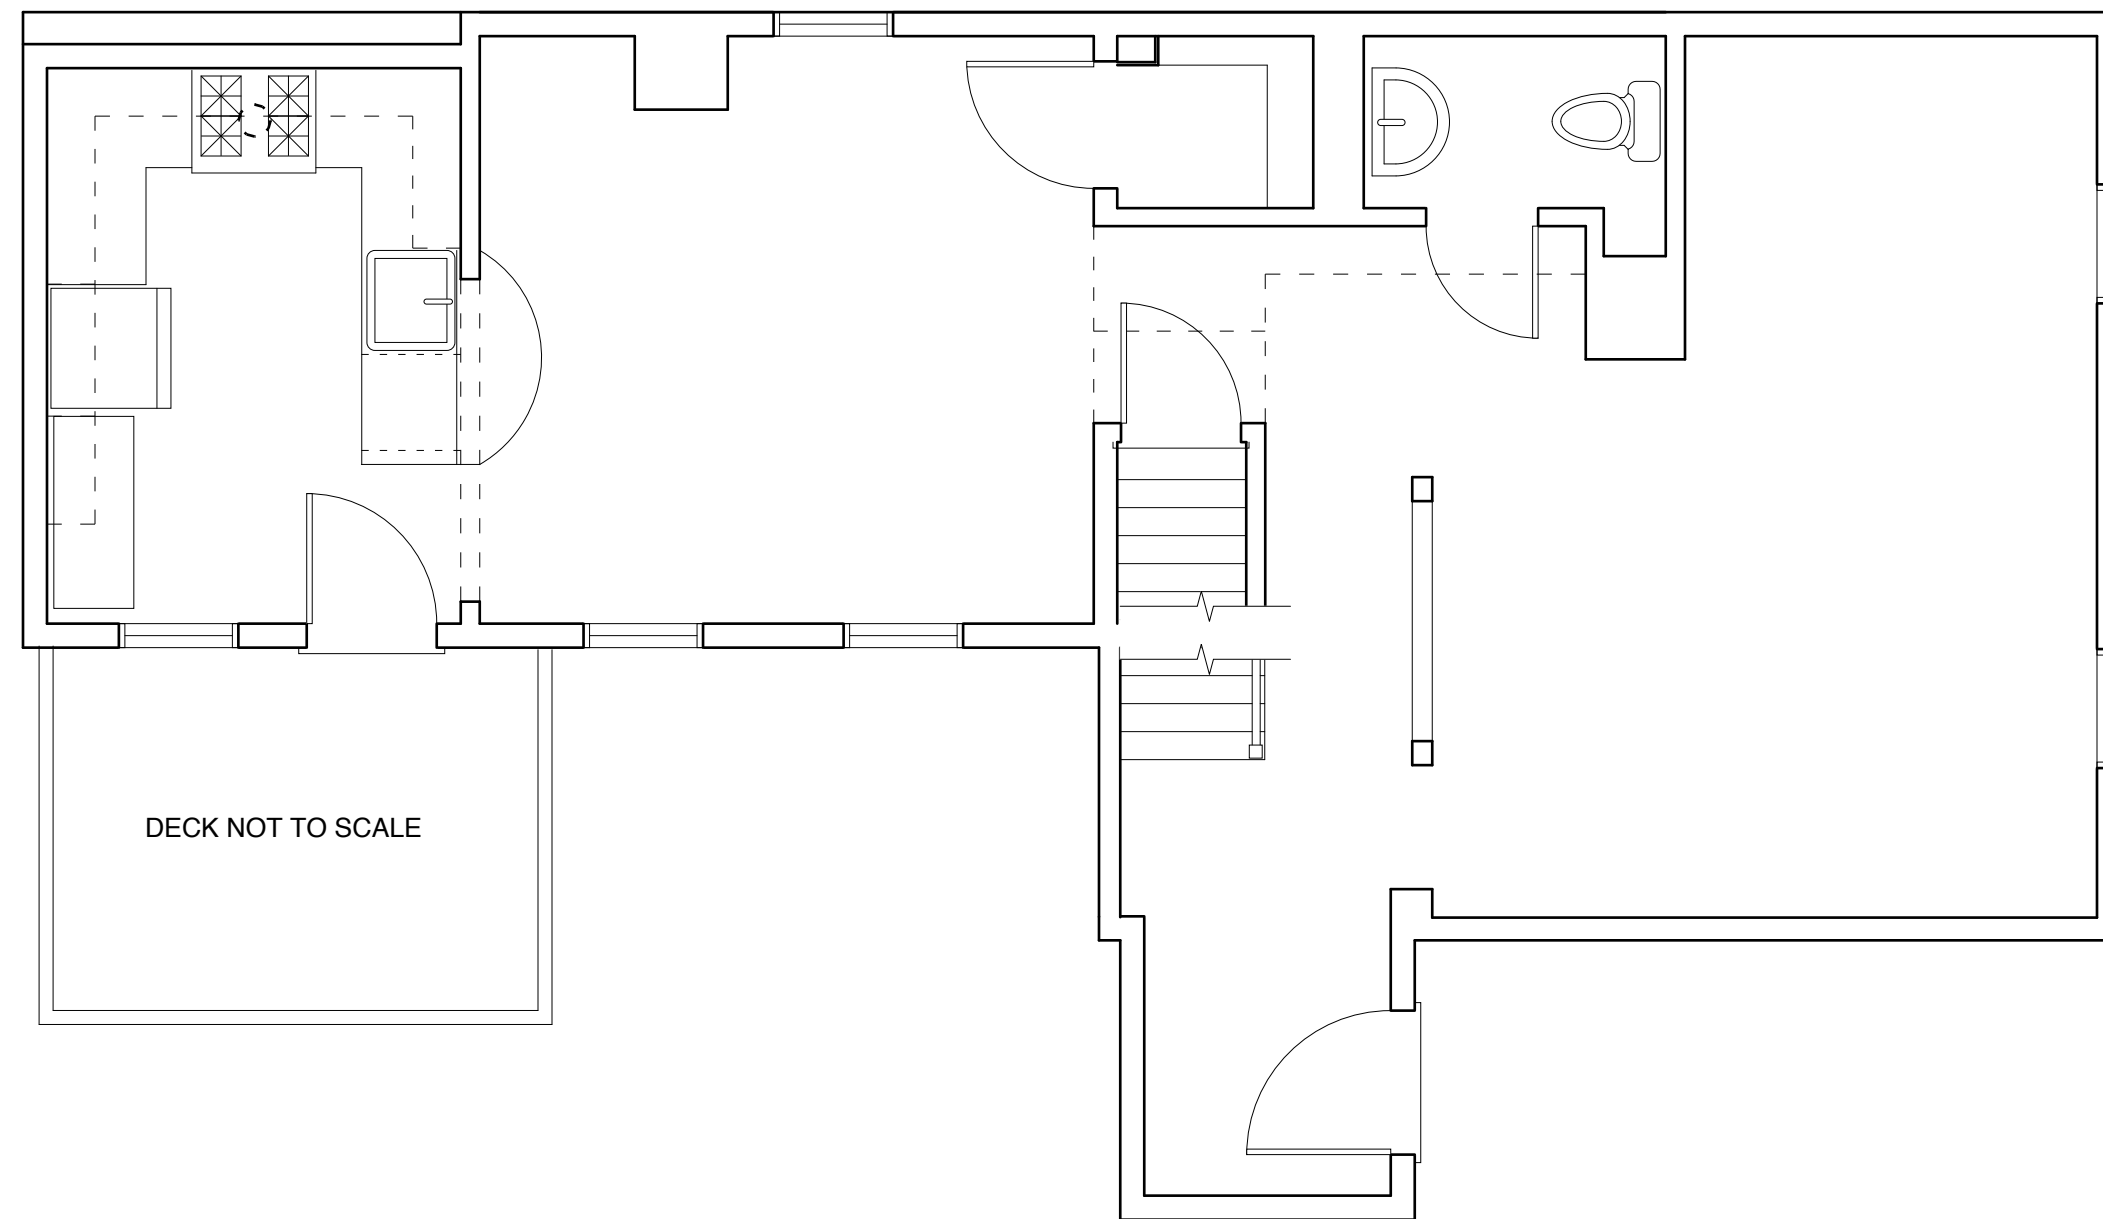

EXISTING MAIN LEVEL

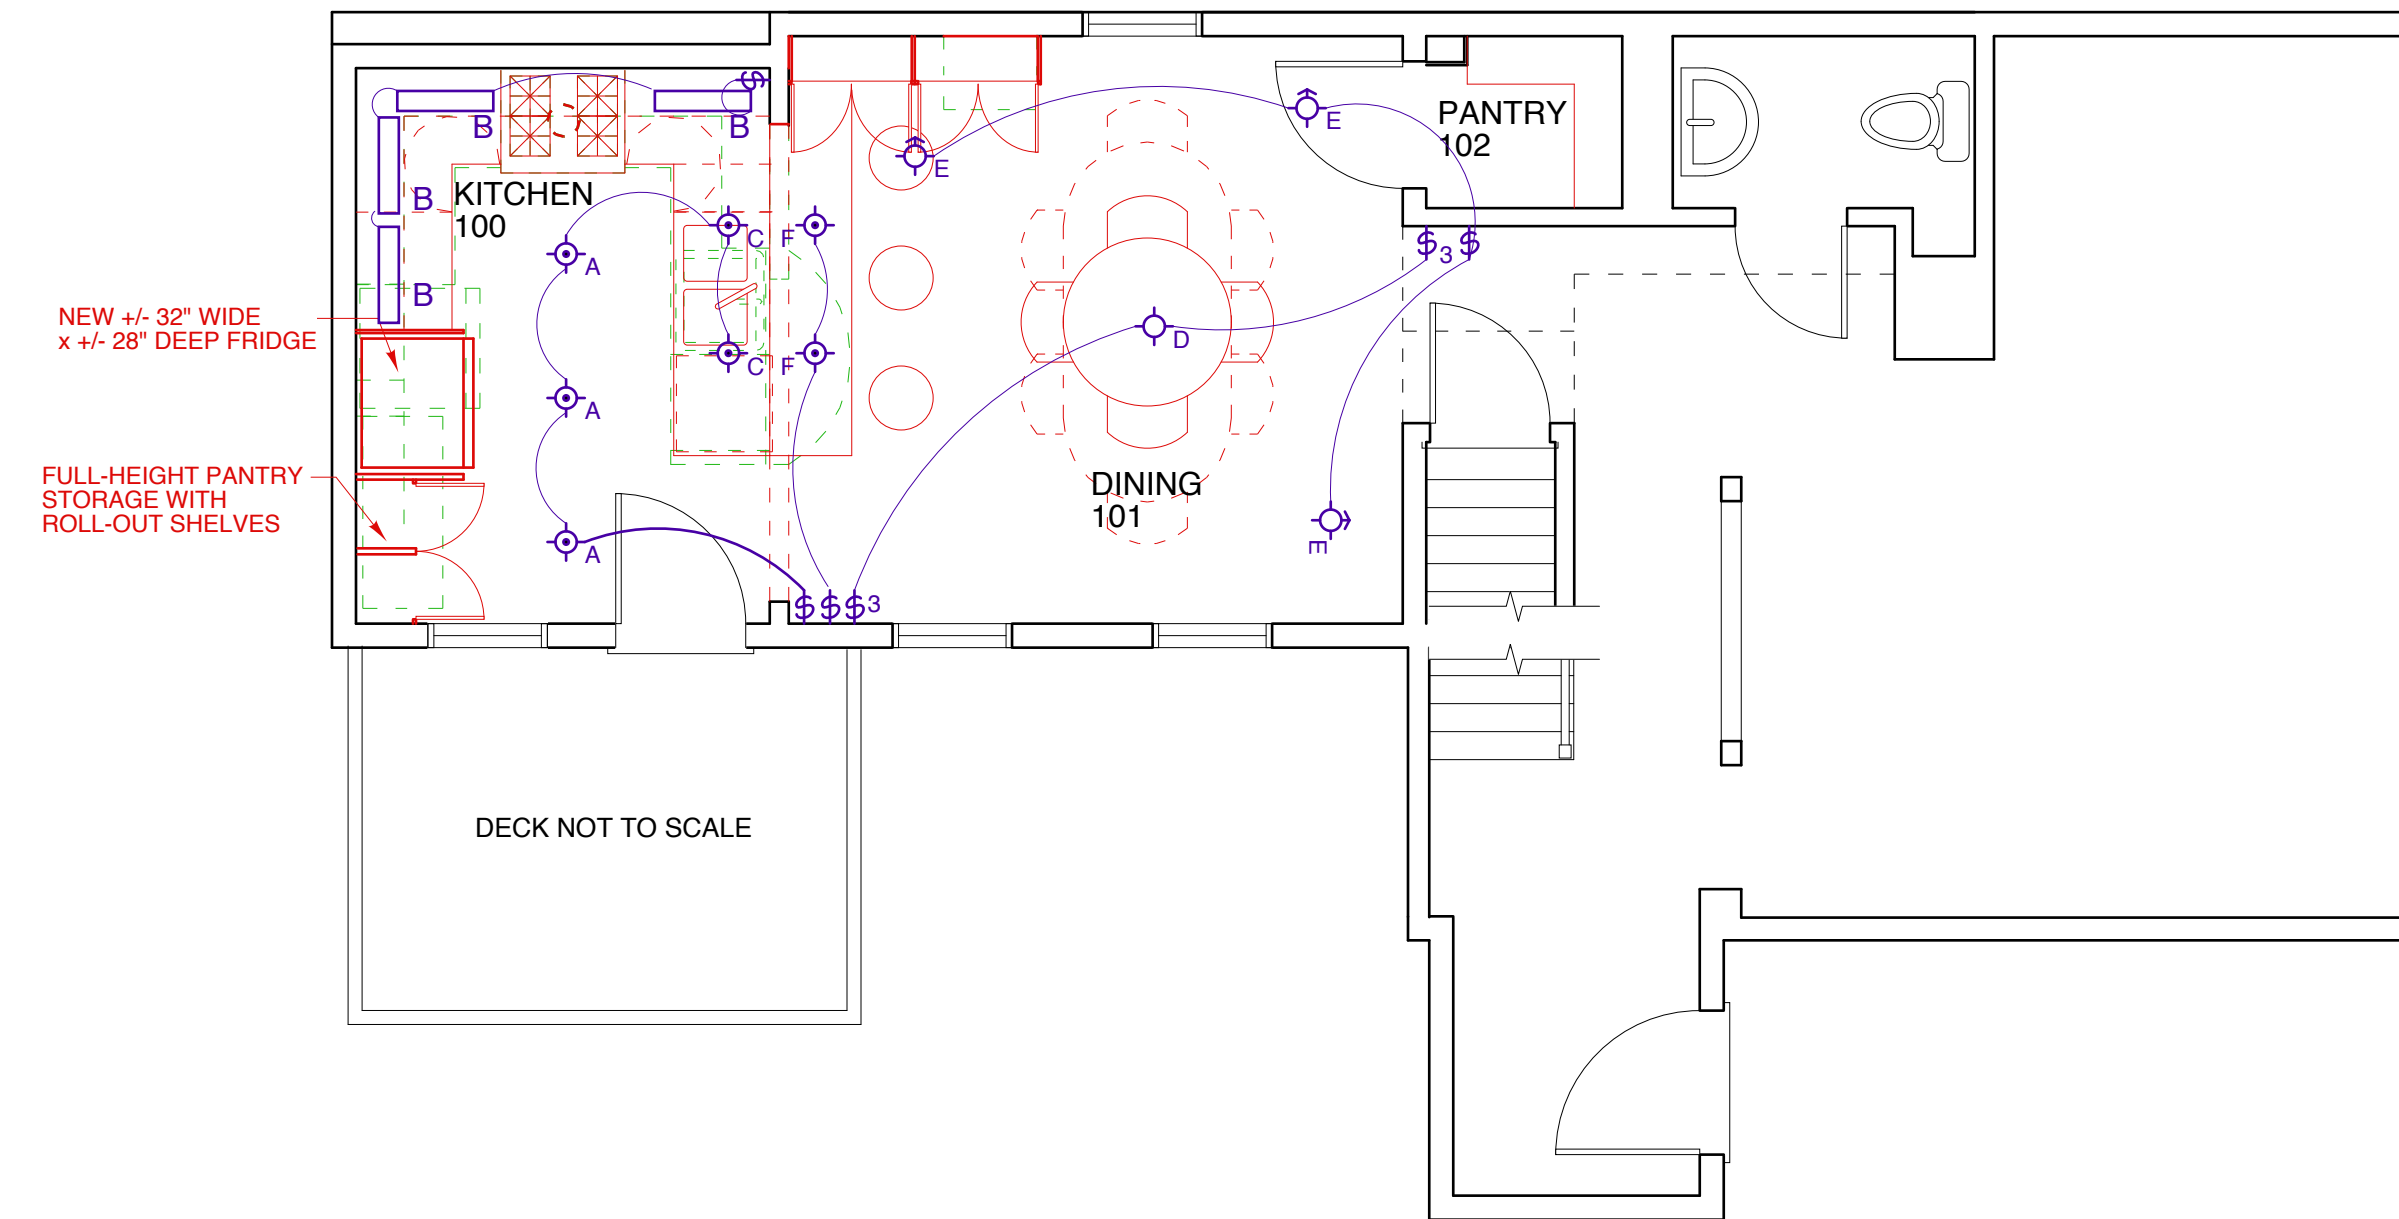

PROPOSED MAIN LEVEL

LIGHT/FAN SCHEDULE

LABEL	LOCATION	TYPE	MANUFACTURER	MODEL	NOTES
A	KITCHEN/BATH203	5" RECESSED DOWNLIGHT			
B	KITCHEN	UNDERCABINET LIGHT			
C	KITCHEN	3 3/4" RECESSED DOWNLIGHT			
D	DINING ROOM	PENDANT			
E	DINING ROOM	RECESSED WALLWASHER			
F	DINING ROOM	PENDANT			
G	MASTER BATH	WALL SCONCE			
H	BATHROOMS	EXHAUST FAN			
I	SHOWER	RECESSED LENSED DOWNLIGHT			
J	BATH 203	WALL SCONCE			
K	LAUNDRY	SURFACE CEILING LIGHT			

RIGBY RESIDENCE

63 Spruce Street
Portland, Maine

SCALE 1/4" = 1' - 0"

DRAWN BY: BBB

DATE: 11/24/13

Copyright 2013 by By Design. All rights reserved. All drawings and written material appearing herein constitute original work of the Architect and may not be duplicated, used, or disclosed without written consent of By Design.



EXISTING & PROPOSED PLANS

A100a