


Ramp Being Demolished

REICHE elementary school

DRAWING INDEX

- 1 SITE PLAN & DETAILS
- 2 FOUNDATION PLAN
- 3 FIRST FLOOR PLAN
- 4 SECOND FLOOR PLAN
- 5 DOOR & ROOM SCHEDULES
- 6 ELEVATIONS
- 7 ELEVATIONS & SECTIONS
- 8 WALL SECTIONS
- 9 WALL SECTIONS
- 10 WALL SECTIONS
- 11 STAIR & MISC. DETAILS
- 12 ROOF PLAN & DETAILS
- S-1 2ND FLOOR FRAMING PLAN
- S-2 ROOF FRAMING PLAN
- S-3 STRUCTURAL DETAILS
- S-4 BRIDGES & STEEL FRAMING DETAILS
- P-1 PLUMBING - 1ST FLOOR
- P-2 PLUMBING - 2ND FLOOR
- P-3 PLUMBING - TOILET DETAILS
- P-4 PLUMBING - DETAILS
- H-1 FIRST FLOOR - HVAC
- H-2 SECOND FLOOR - HVAC
- H-3 HEATING - PIPING
- H-4 HEATING - DETAILS
- E-1 FIRST FLOOR LIGHTING PLANS
- E-2 SECOND FLOOR LIGHTING PLANS
- E-3 FIRST FLOOR POWER PLANS
- E-4 SECOND FLOOR POWER PLANS
- E-5 RIGER DIAGRAM - SITE PLAN - DETAILS

STATE OF MAINE
APPROVE
[Signature]
3-27-72

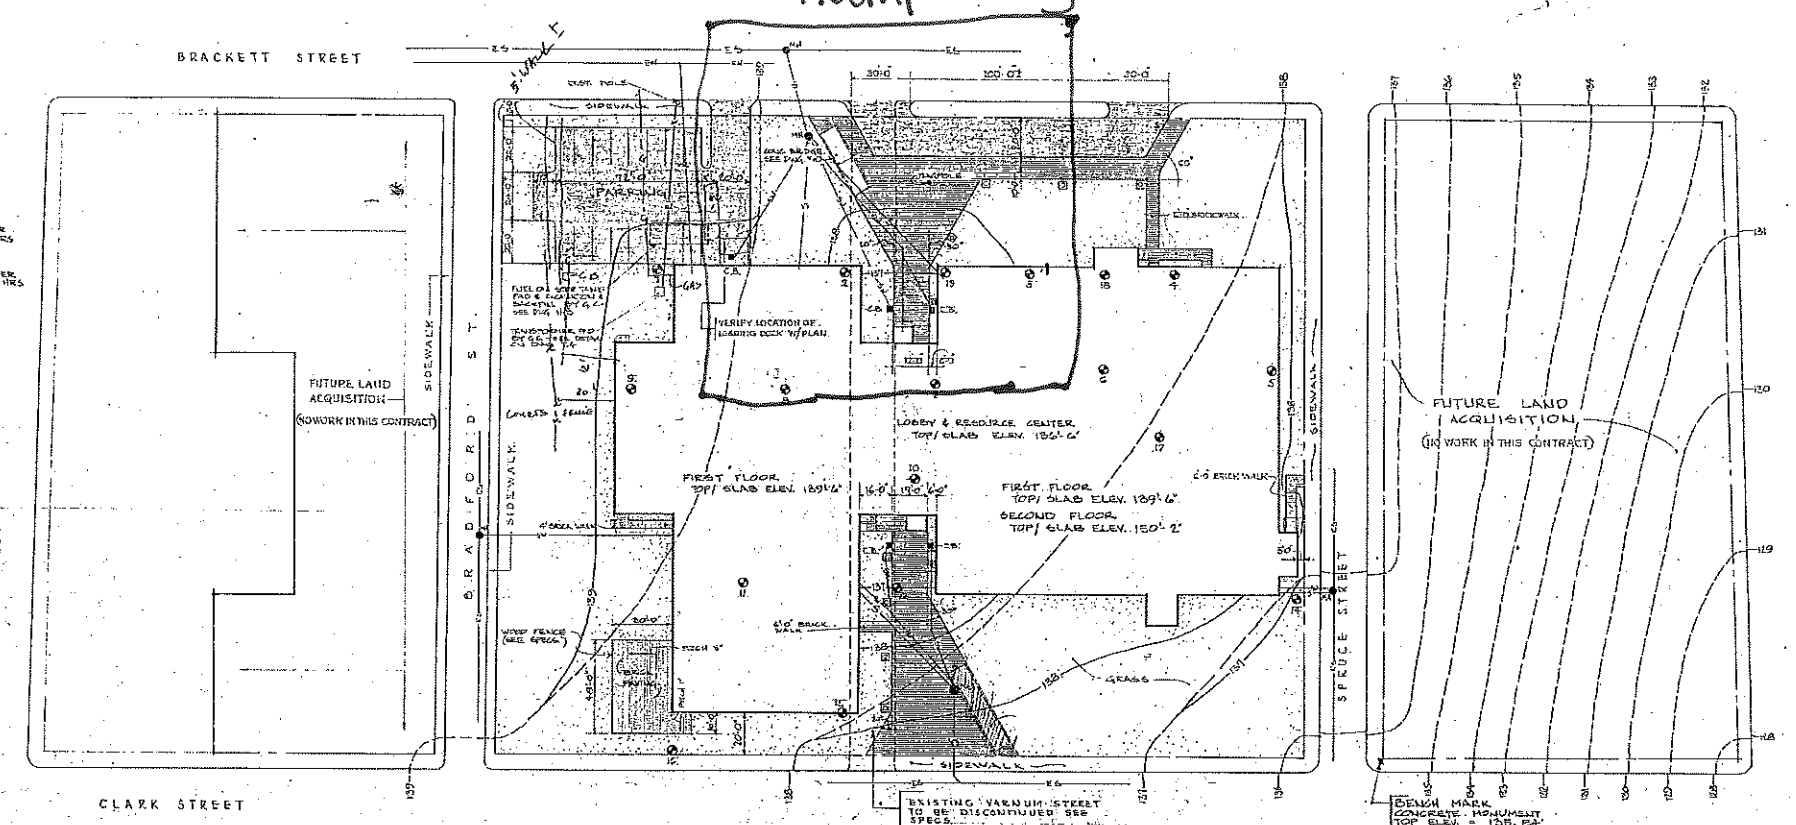

SITE PLAN

SCALE: 1" = 30'

SITE PLAN LEGEND

- GRASS
- BRICK PAVING
- MANHOLE (NEW BY G.C.)
- CATCH BASIN (NEW BY G.C.)
- BORING - BORINGS LOG IS AVAILABLE AT ARCHITECT OFFICE FOR REVIEW.
- YARD POST LIGHT - CONC. BASE BY G.C. (FOR BASE DETAIL SEE DWG. E-5) (FOR YARD LIGHTS ATTACHED TO BRIDGE RAILS SEE DRAWING # 10)
- EXISTING CONTOUR LINE
- NEW FINISH CONTOUR LINE
- PROPERTY LINE & CONTRACT LIMIT
- W - WATER SERVICE (EW - EXISTING WATER)
- E - ELECTRIC SERVICE
- S - SEWER (ES - EXISTING SEWER)
- SW - STORM WATER

ABBREVIATIONS

- ADJ. ADJUSTABLE
- A.F.F. ABOVE FINISH FLOOR
- ALUM. ALUMINUM
- BL. BLOCK
- C.L. CENTER LINE
- CB. CHALK BOARD
- CL. LAST IRON
- CONT. CONTINUOUS
- CONC. CONCRETE
- COL. COLUMN
- D. DEPTH
- DF. DRINKING FOUNTAIN
- DWG. DRAWING
- EXP. EXPANSION
- ELEV. ELEVATION
- ENG. ELECTRIC WATER COOLER
- FTG. FOOTING
- FDN. FOUNDATION
- FIN. FINISH
- H. HEIGHT
- JO. JOINT
- L.C. LEAD COATED COPPER
- LONG. LONG
- LAV. LAVATORY
- MIN. MINIMUM
- M. METAL
- M.O. MASONRY OPENING
- NTS. NOT TO SCALE
- IN C. NOT IN CONTRACT
- ON C. ON CENTERS
- PTD. PAINTED
- PRT. PARTICULAR
- ROOF. ROOF DRAIN
- SL. STEEL JOIST
- SIM. SIMILAR
- ST. STEEL
- STR. STRUCTURAL
- TYP. TYPICAL
- THOLD. THRESHOLD
- T.B. TACK BOARD
- UR. URINAL
- W. WITH
- W/O. WITHOUT
- W.W.M. WELDED WIRE MESH
- WOOD. WOOD
- WC. WATER CLOSET
- C.J. CONTROL JOINT

LEGEND


- CONCRETE
- BRICK
- MASONRY BLOCK
- RIGID INSULATION
- PLASTER ON GYPSUM LATH
- PLASTER ON WIRE LATH
- CEMENTITIOUS DECKING
- BATT INSULATION
- WOOD FRAMING OR BLOCKING
- FINISH WOOD (MILLWORK)
- STRUCTURAL STEEL
- METAL STUD & PLASTER PARTITION IN PLAN

SAMPLE BORING LOGS


WATER TABLE	WATER	WATER	WATER
8.5'	17'	17'	17'
10.5'	17'	17'	17'
12.5'	17'	17'	17'
14.5'	17'	17'	17'
16.5'	17'	17'	17'
18.5'	17'	17'	17'
20.5'	17'	17'	17'
22.5'	17'	17'	17'
24.5'	17'	17'	17'
26.5'	17'	17'	17'
28.5'	17'	17'	17'
30.5'	17'	17'	17'
32.5'	17'	17'	17'
34.5'	17'	17'	17'
36.5'	17'	17'	17'
38.5'	17'	17'	17'
40.5'	17'	17'	17'
42.5'	17'	17'	17'
44.5'	17'	17'	17'
46.5'	17'	17'	17'
48.5'	17'	17'	17'
50.5'	17'	17'	17'
52.5'	17'	17'	17'
54.5'	17'	17'	17'
56.5'	17'	17'	17'
58.5'	17'	17'	17'
60.5'	17'	17'	17'
62.5'	17'	17'	17'
64.5'	17'	17'	17'
66.5'	17'	17'	17'
68.5'	17'	17'	17'
70.5'	17'	17'	17'
72.5'	17'	17'	17'
74.5'	17'	17'	17'
76.5'	17'	17'	17'
78.5'	17'	17'	17'
80.5'	17'	17'	17'
82.5'	17'	17'	17'
84.5'	17'	17'	17'
86.5'	17'	17'	17'
88.5'	17'	17'	17'
90.5'	17'	17'	17'
92.5'	17'	17'	17'
94.5'	17'	17'	17'
96.5'	17'	17'	17'
98.5'	17'	17'	17'
100.5'	17'	17'	17'

NOTES:
THE ABOVE LOGS ARE INTENDED AS SAMPLES ONLY - COMPLETE LOGS SHOULD BE REFERRED TO PRIOR TO BIDDING.


TREES & SHRUBS:
THE GENERAL CONTRACTOR SHALL REMOVE ALL EXISTING TREES & SHRUBS EXCEPT THOSE SELECTED BY THE ARCHITECT TO REMAIN.

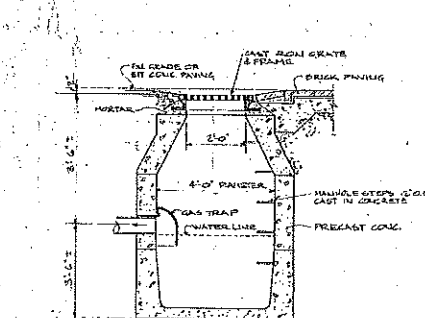


SECTION

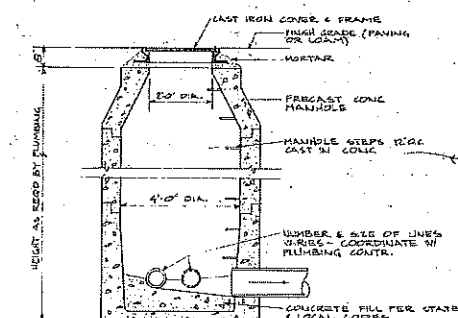


SECTION

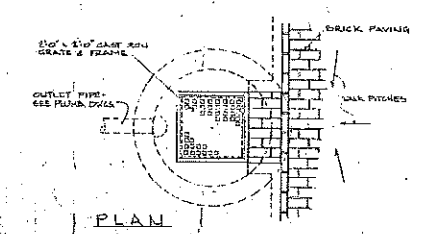


PLAN CATCH BASIN DETAILS

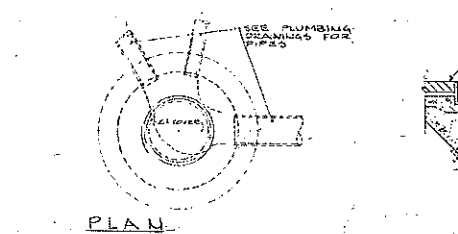

PLAN MANHOLE DETAILS

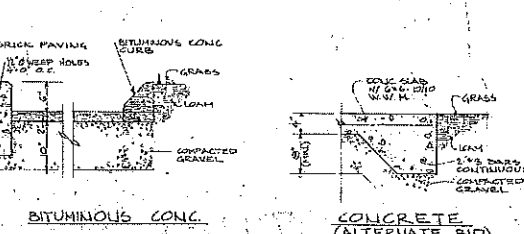

BITUMINOUS CONC. PAVING DETAILS

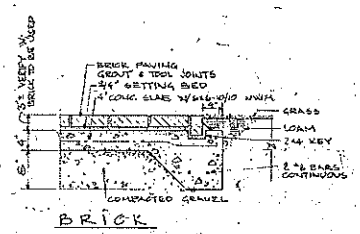

BRICK PAVING DETAILS

SITE PLAN & DETAILS

REICHE ARCHITECTS
WILBUR R. INGALLS ARCHITECT
PORTLAND, MAINE