

© 2016 RYAN SENATORE ARCHITECTURE

LITTLE GIANT RESTAURANT
 211 DANFORTH STREET
 PORTLAND, MAINE



RYAN SENATORE
 ARCHITECTURE
 565 CONGRESS STREET
 PORTLAND, MAINE 04101
 207-650-6414
 senatorearchitecture.com

CONSULTANTS:

REVISIONS:

DATE: NOVEMBER 29, 2016

PROJECT No. 1640

DRAWN BY: RRT, RJS

CHECKED BY: RJS

SCALE: AS NOTED

SHEET TITLE:
 FIRST FLOOR
 REFLECTED
 CEILING PLAN

A1-3


REFLECTED CEILING PLAN NOTES

1.) SEE ELECTRICAL PLANS FOR LIGHTING

2.) SUPPLY VENTILATION GRILLS (NOT SHOWN). G.C. TO COORDINATE FINAL LOCATION WITH ARCHITECT

REFLECTED CEILING PLAN AND LIGHTING LEGEND

SYMBOL	TAG	DESCRIPTION
●	A	SURFACE MOUNT - TBD
○	B	SURFACE MOUNTED - TBD
○	C	SURFACE MOUNT - IN CLOSETS
□	D	SURFACE MOUNTED ON WALL ABOVE DOOR
□	E	WALL SCONCE IN BATHROOM OVER VANITY
○	F	SURFACE MOUNT - WET LOCATION
○	G	SCONCE ON UNIT ENTRY DOOR
○	H	SURFACE MOUNT CENTER IN BEDROOMS
○	J	SURFACE MOUNT - WET LOCATION
□	K	1' X 4' FLORESCENT
■		CEILING GRILLE

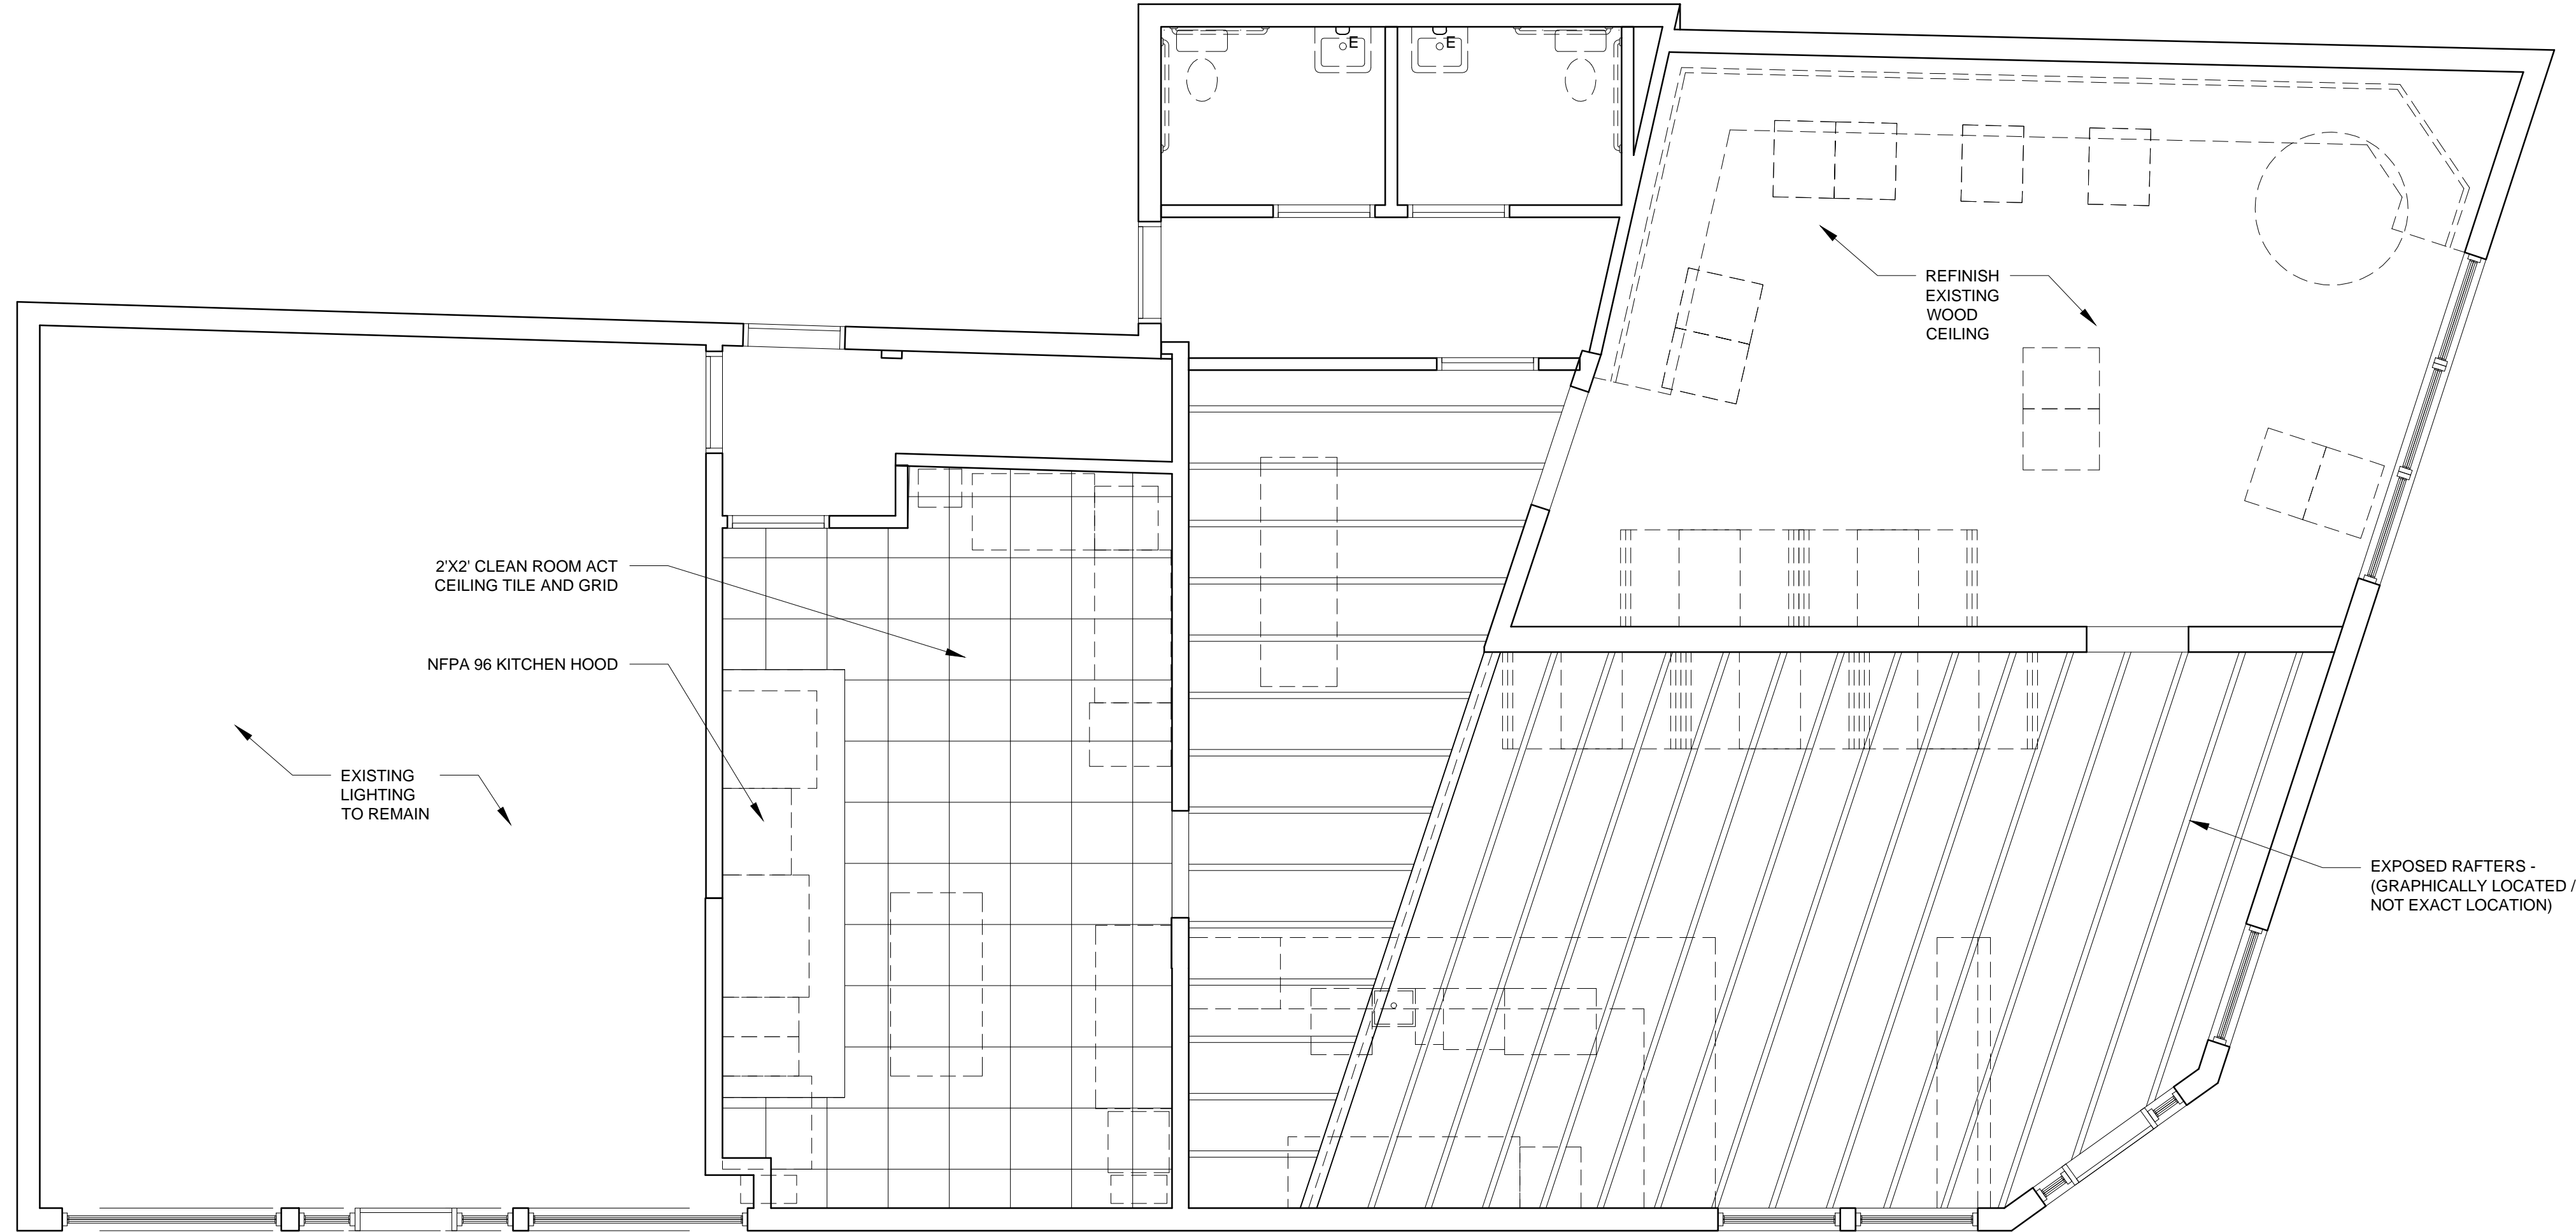

1 FIRST FLOOR REFLECTED CEILING PLAN
 1/4" = 1'-0"