


**WATER HEATER PIPING SCHEMATIC**


NTS

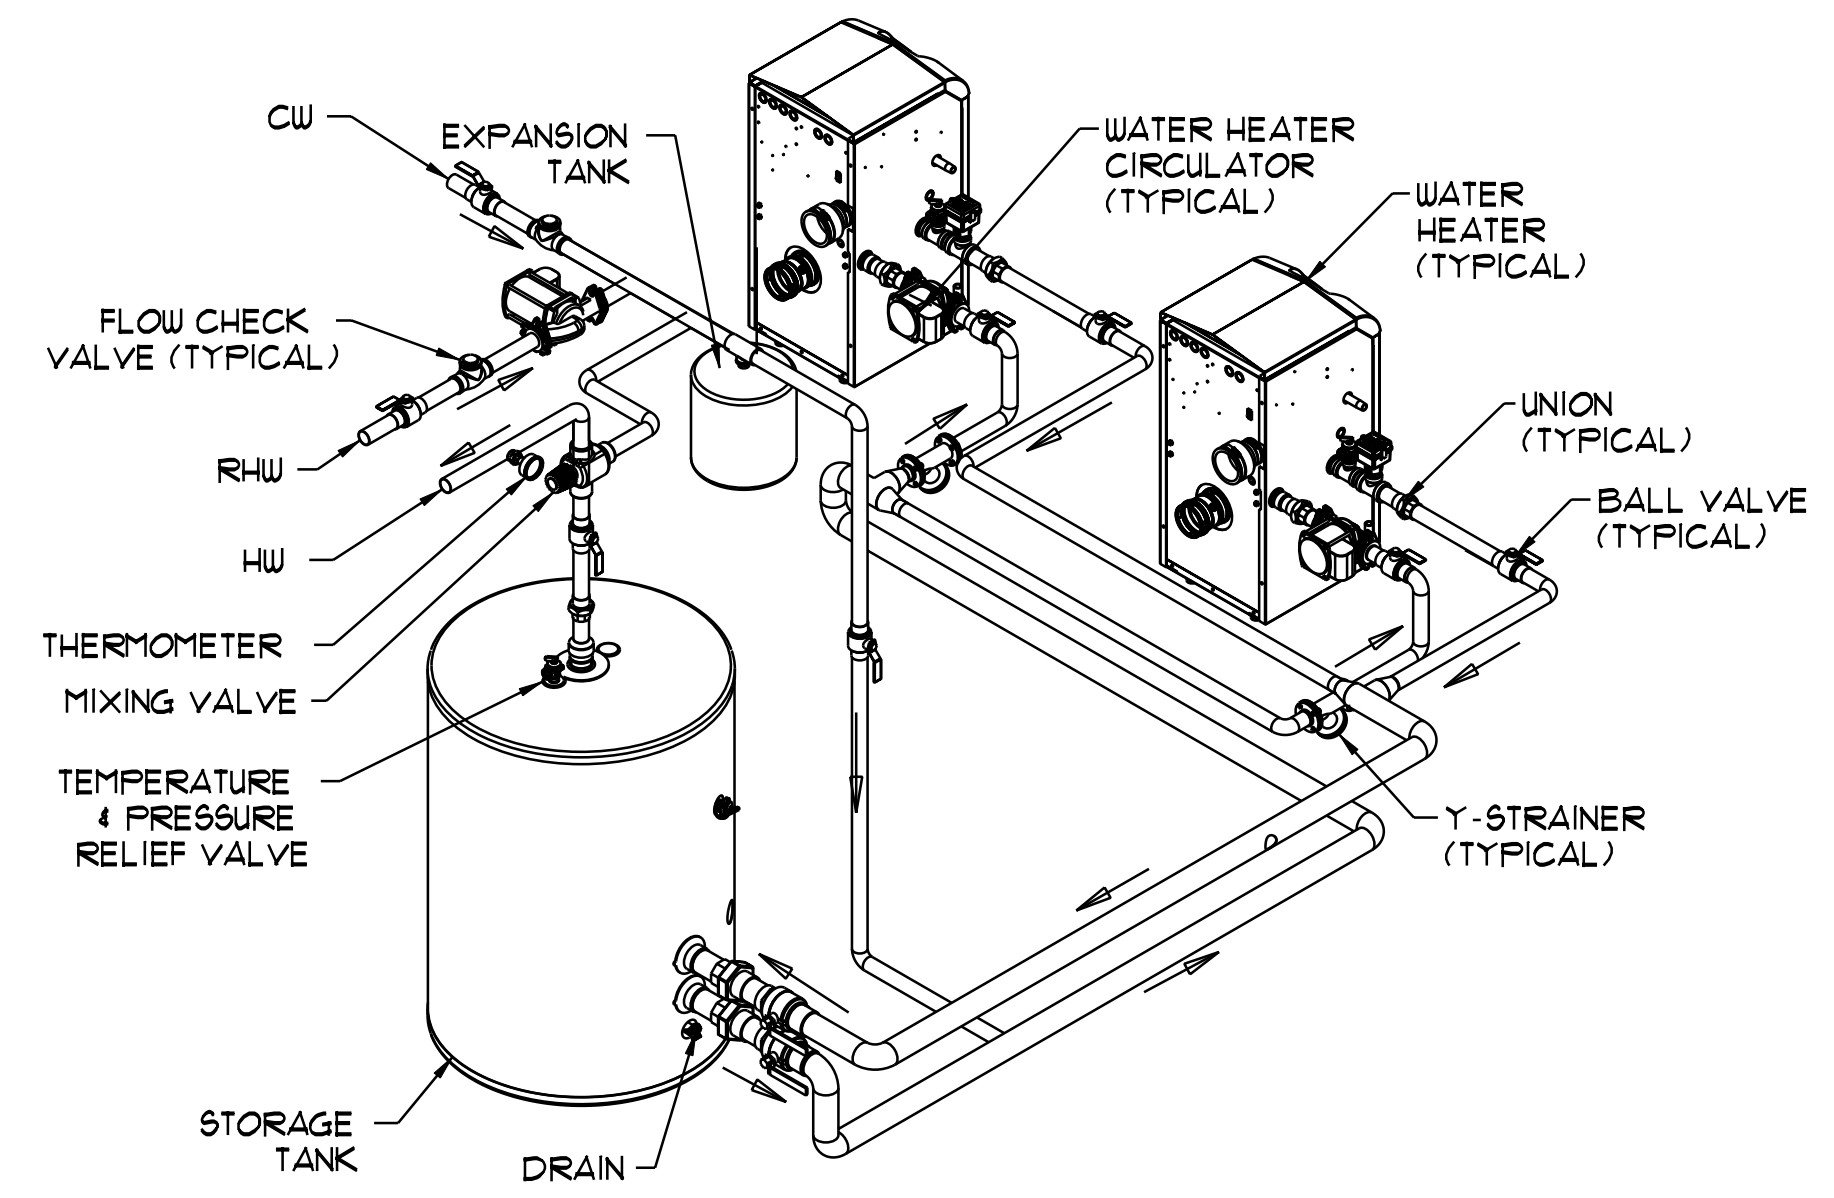

**WATER HEATING ISOMETRIC**



NTS

NOTE - GENERIC MANUFACTURERS DETAIL, SEE DHW PIPING SCHEMATIC.

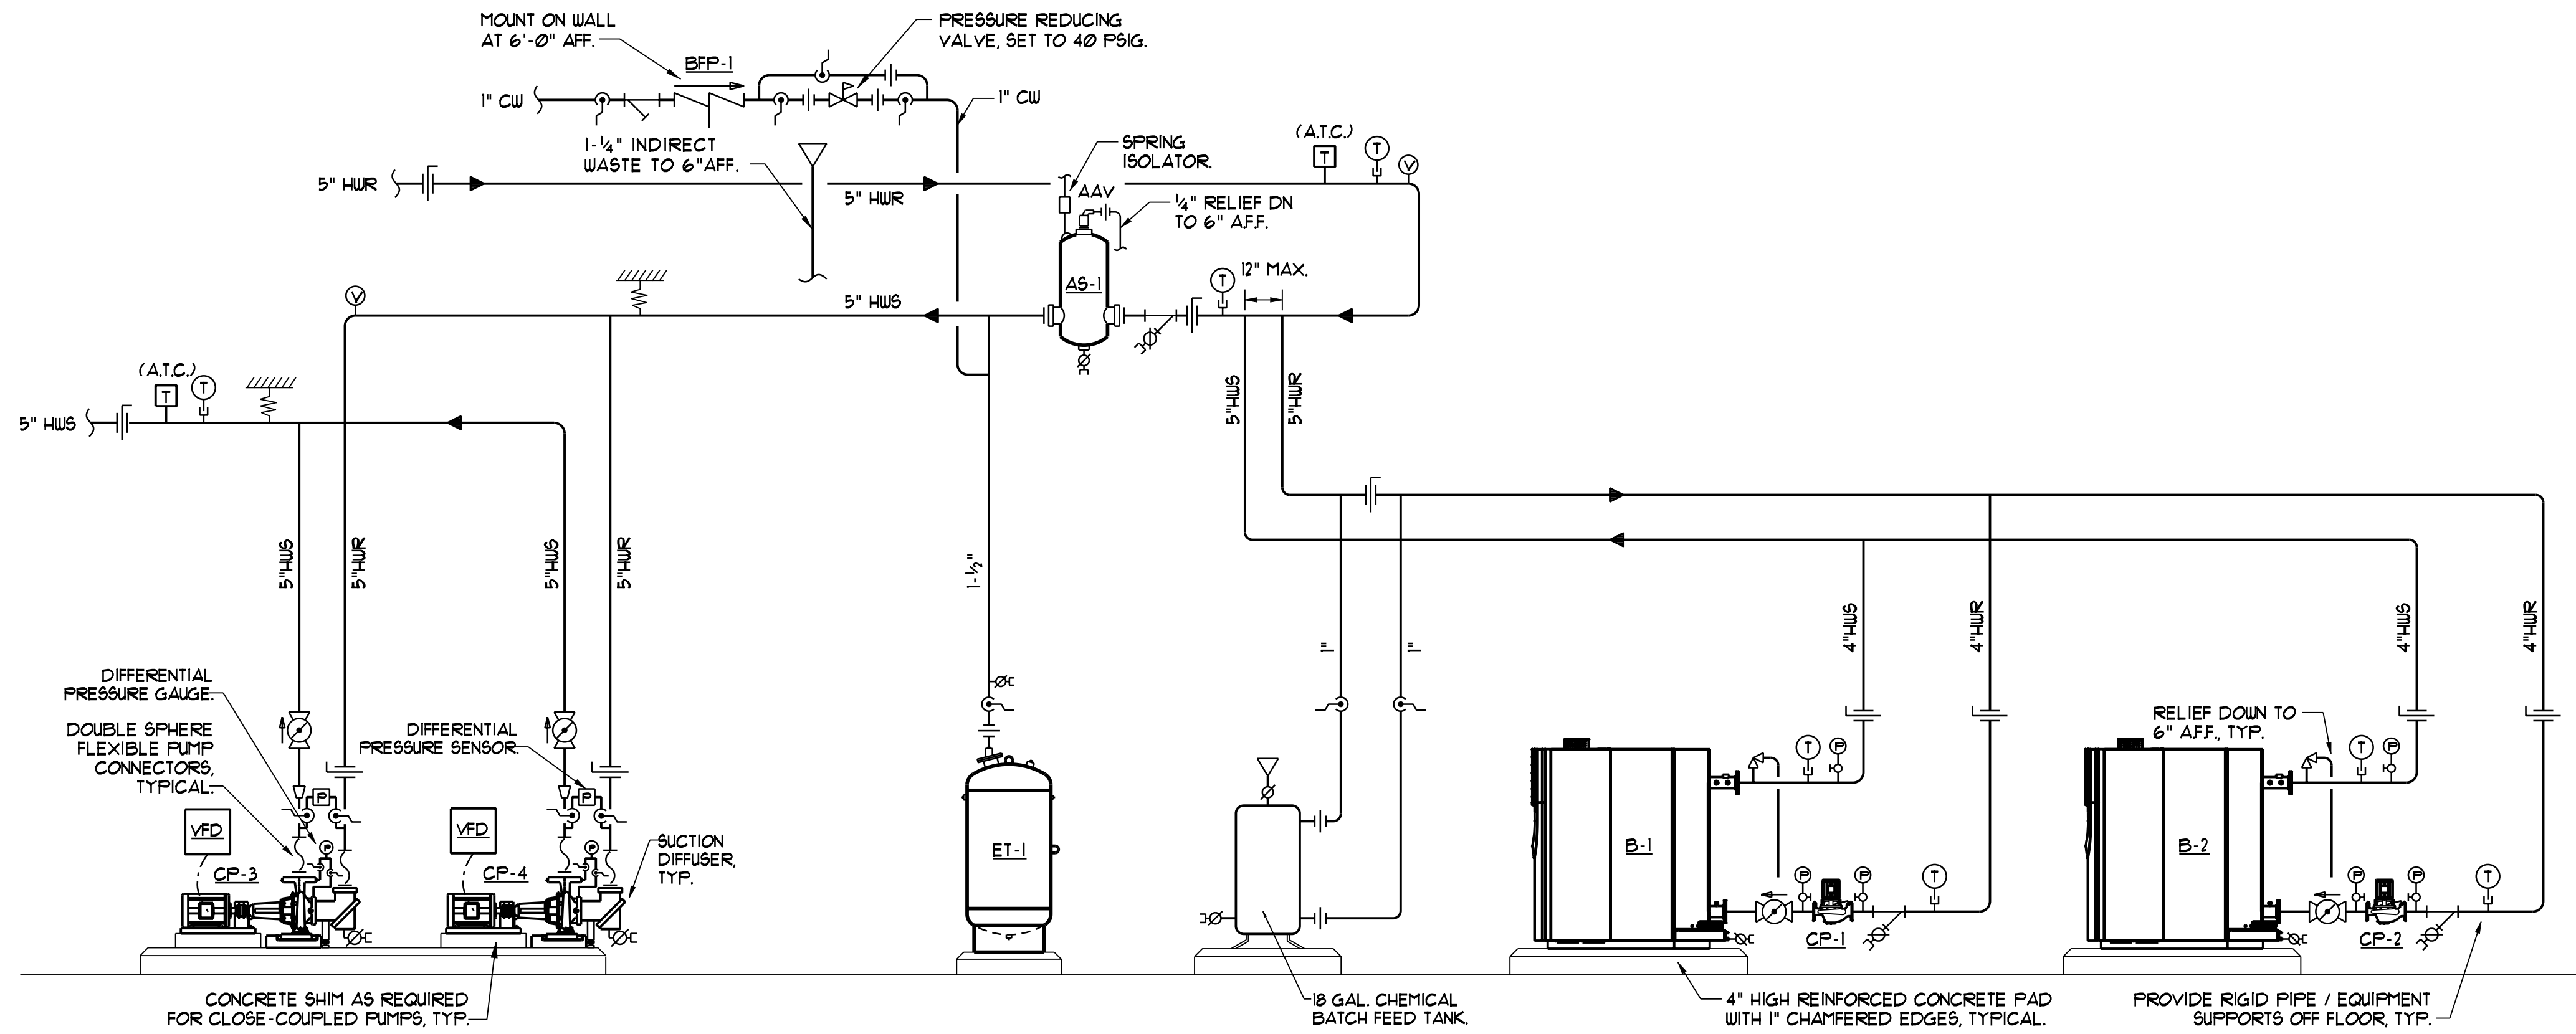

**BOILER PIPING SCHEMATIC**

NTS

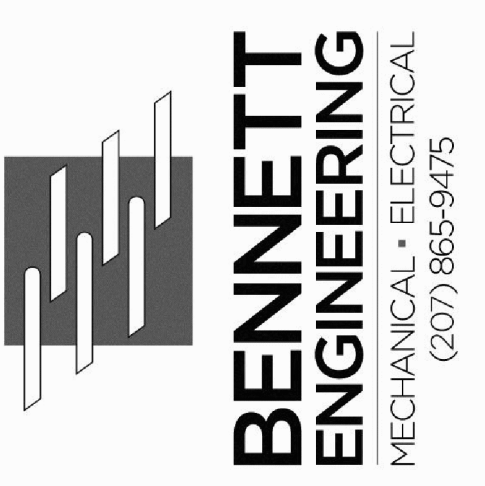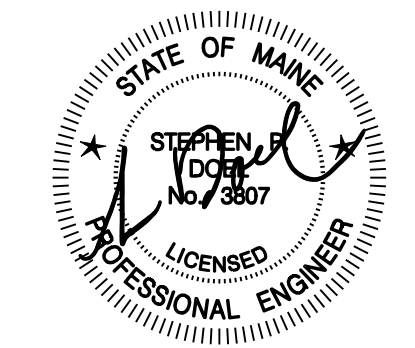

Portland Housing Authority  
 14 Baxter Boulevard  
 Portland, Maine 04101

HARBOR TERRACE  
 BOILER REPLACEMENT  
 284 Danforth Street, Portland, ME  
 Mechanical Details

Date Drawn - 11/21/12

Drawn By - SMR

Revised - 12/07/12 - ISSUED FOR BID

Project # 3348

Scale - As Noted

Sheet Number - M3.2