


NOTES:

- SEE SHEET FA-001 FOR LEGEND, ABBREVIATIONS, AND GENERAL NOTES.

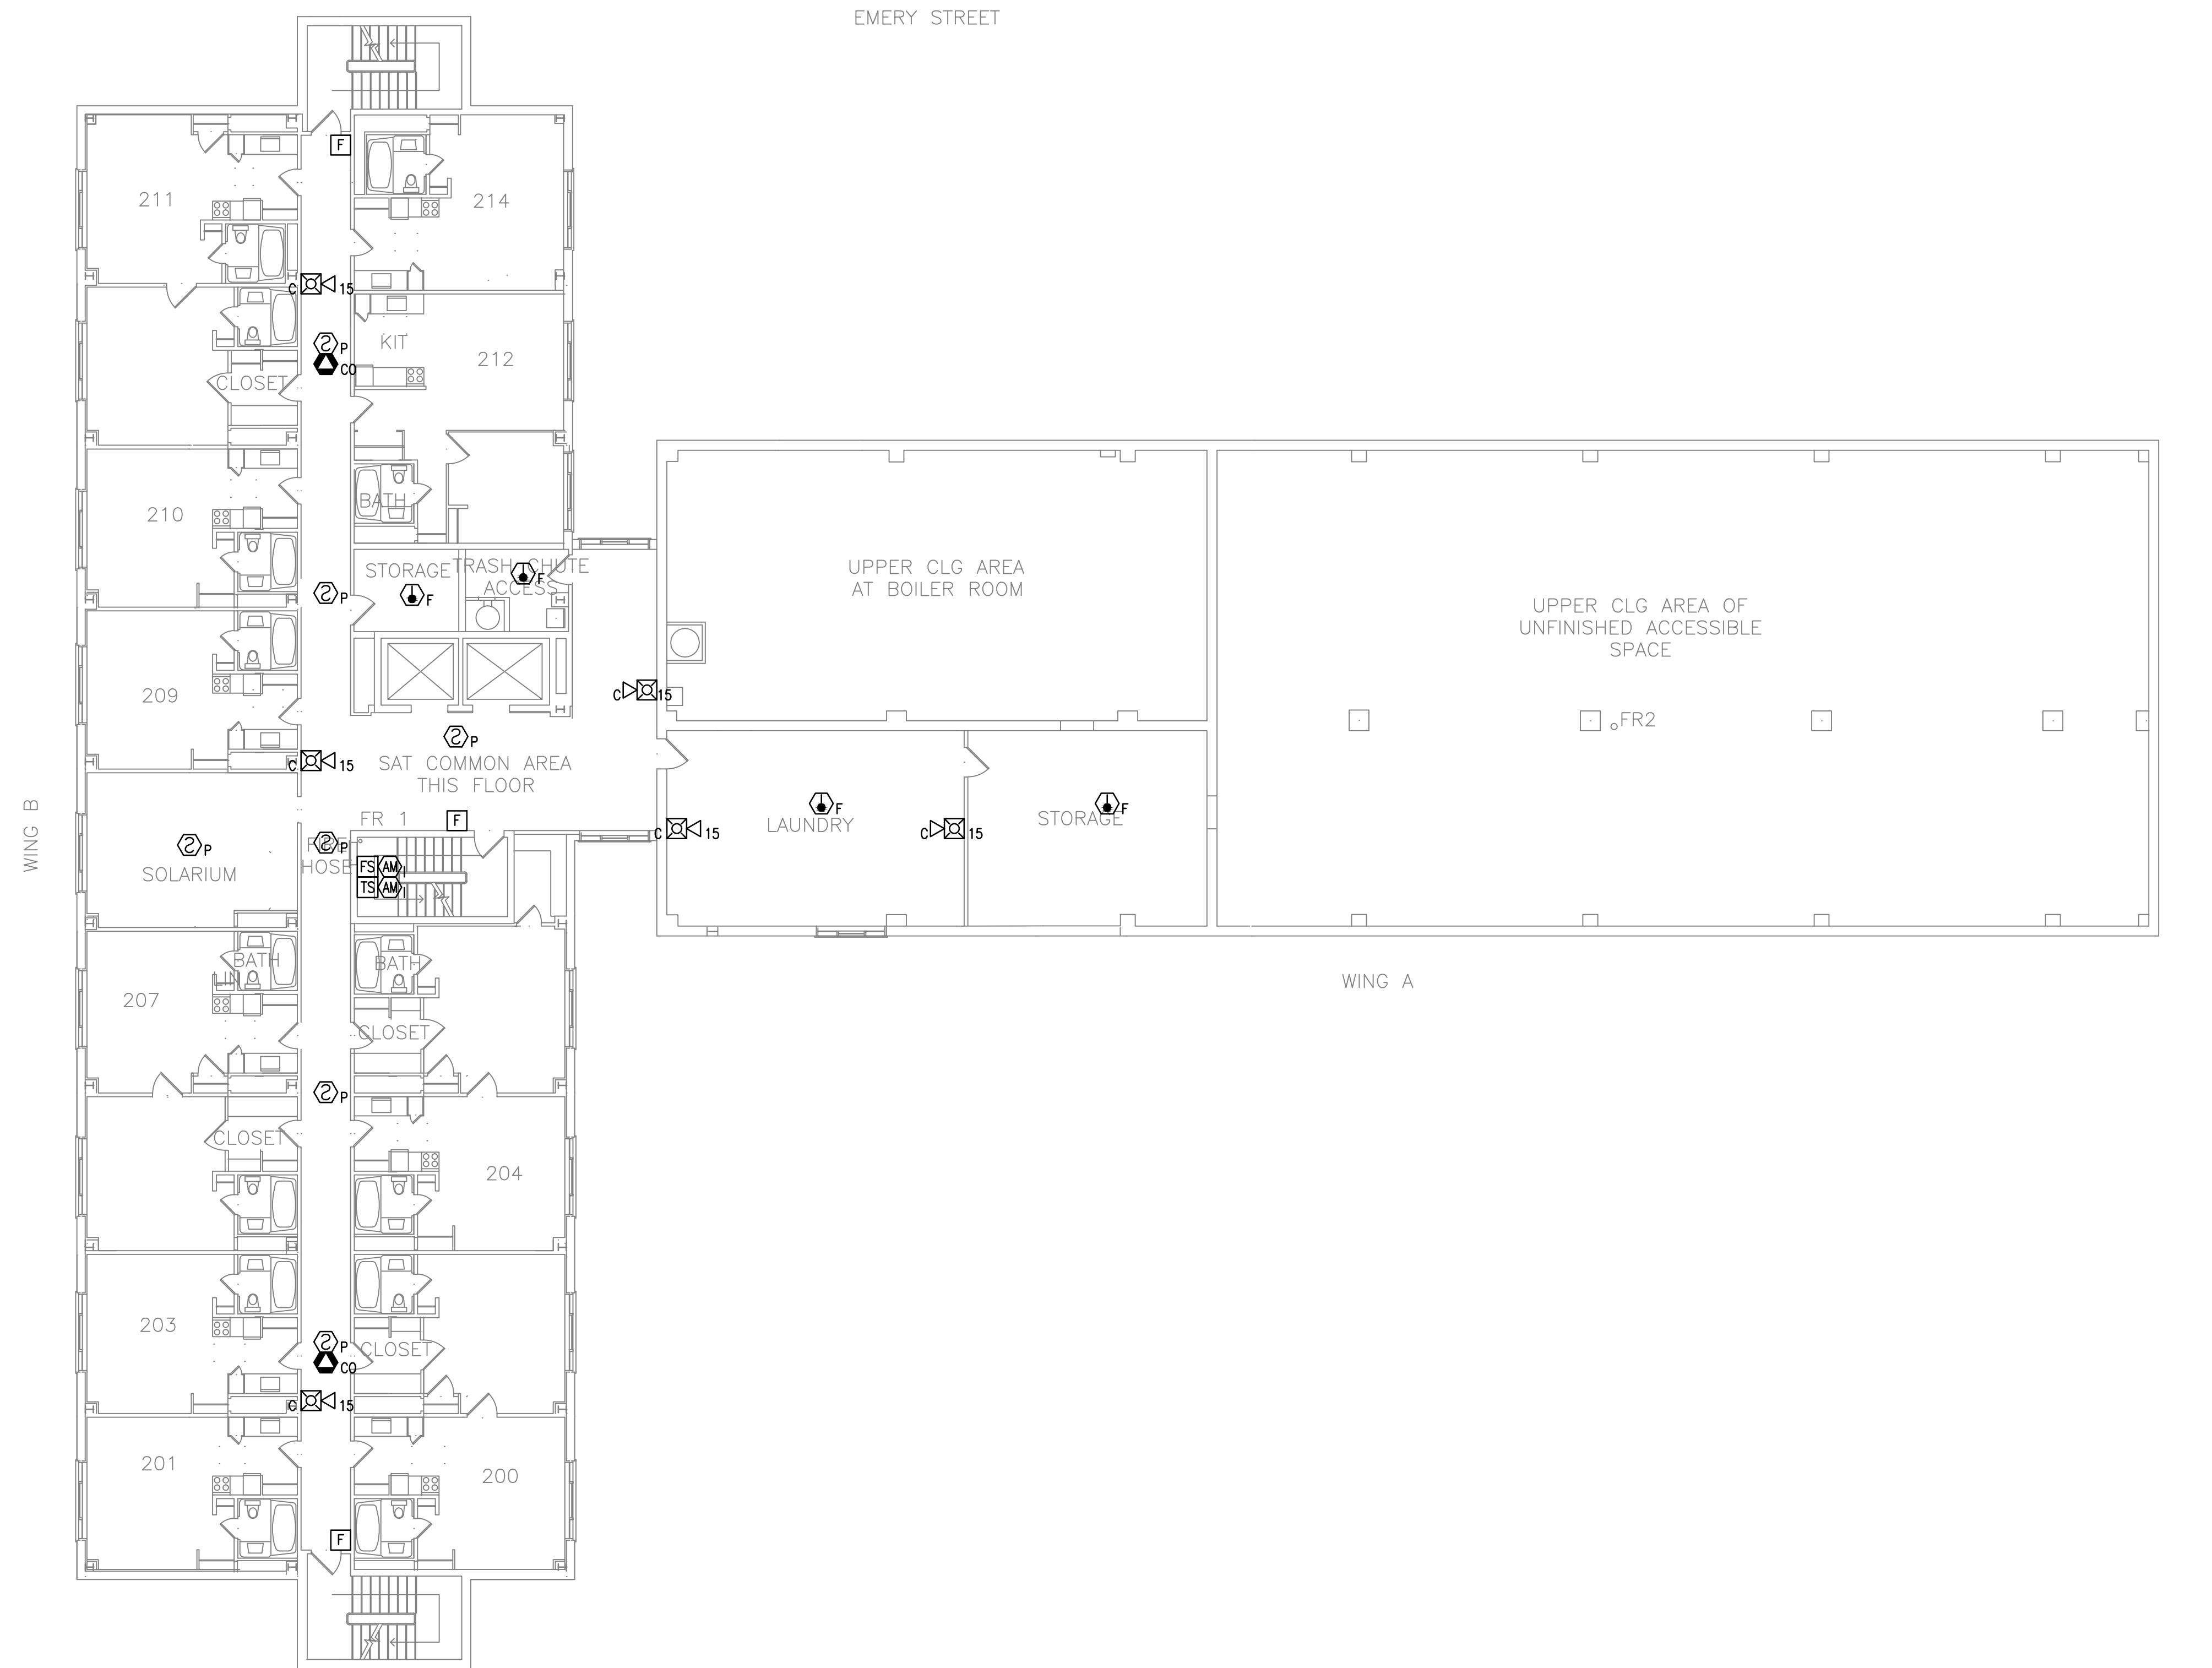


 
SECOND FLOOR FIRE ALARM PLAN

SCALE: 3/32" = 1'-0"

PROJECT



NORTH

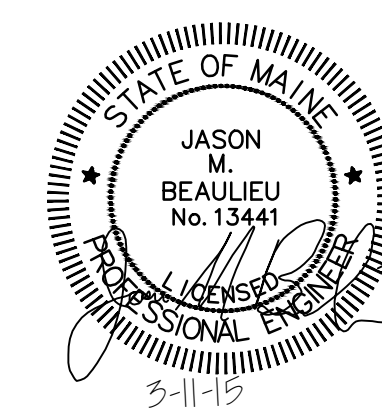

				PORTLAND HOUSING AUTHORITY PORTLAND, MAINE			
				HARBOR TERRACE FIRE ALARM UPGRADE			
				SECOND FLOOR FIRE ALARM PLAN			
A	ISSUED FOR CONSTRUCTION	BVD	MRL	3/11/15			
REV	DESCRIPTION	DWN	APP	DATE			

PLEASE NOTE: THIS DOCUMENT MAY NOT ACCURATELY REPRESENT THE FINAL DOCUMENT. ONLY AN ENGINEER, ARCHITECT OR SURVEYOR SIGNED, SEALED AND DATED PAPER COPY, PROVIDED BY THIS OFFICE, MAY BE UTILIZED FOR BIDDING OR CONSTRUCTION PURPOSES.

Colby Company
engineering
474 York Street
Portland, Maine 04101
207.533.7753
colbycoengineering.com

SIZE: ANSI D
DATE: 03-11-2015
DES BY: JMB
DWN BY: BVD
CKD BY: MRL

PROJECT NO.
218.006.002
SHEET
11 OF 17

DRAWING NO.
FA-110