


**NOTES:**

- SEE SHEET FA-001 FOR LEGEND, ABBREVIATIONS, AND GENERAL NOTES.

**KEYED NOTES:**


- PROVIDE A WEATHER RATED EXTERIOR STROBE VISIBLE FROM THE STREET.

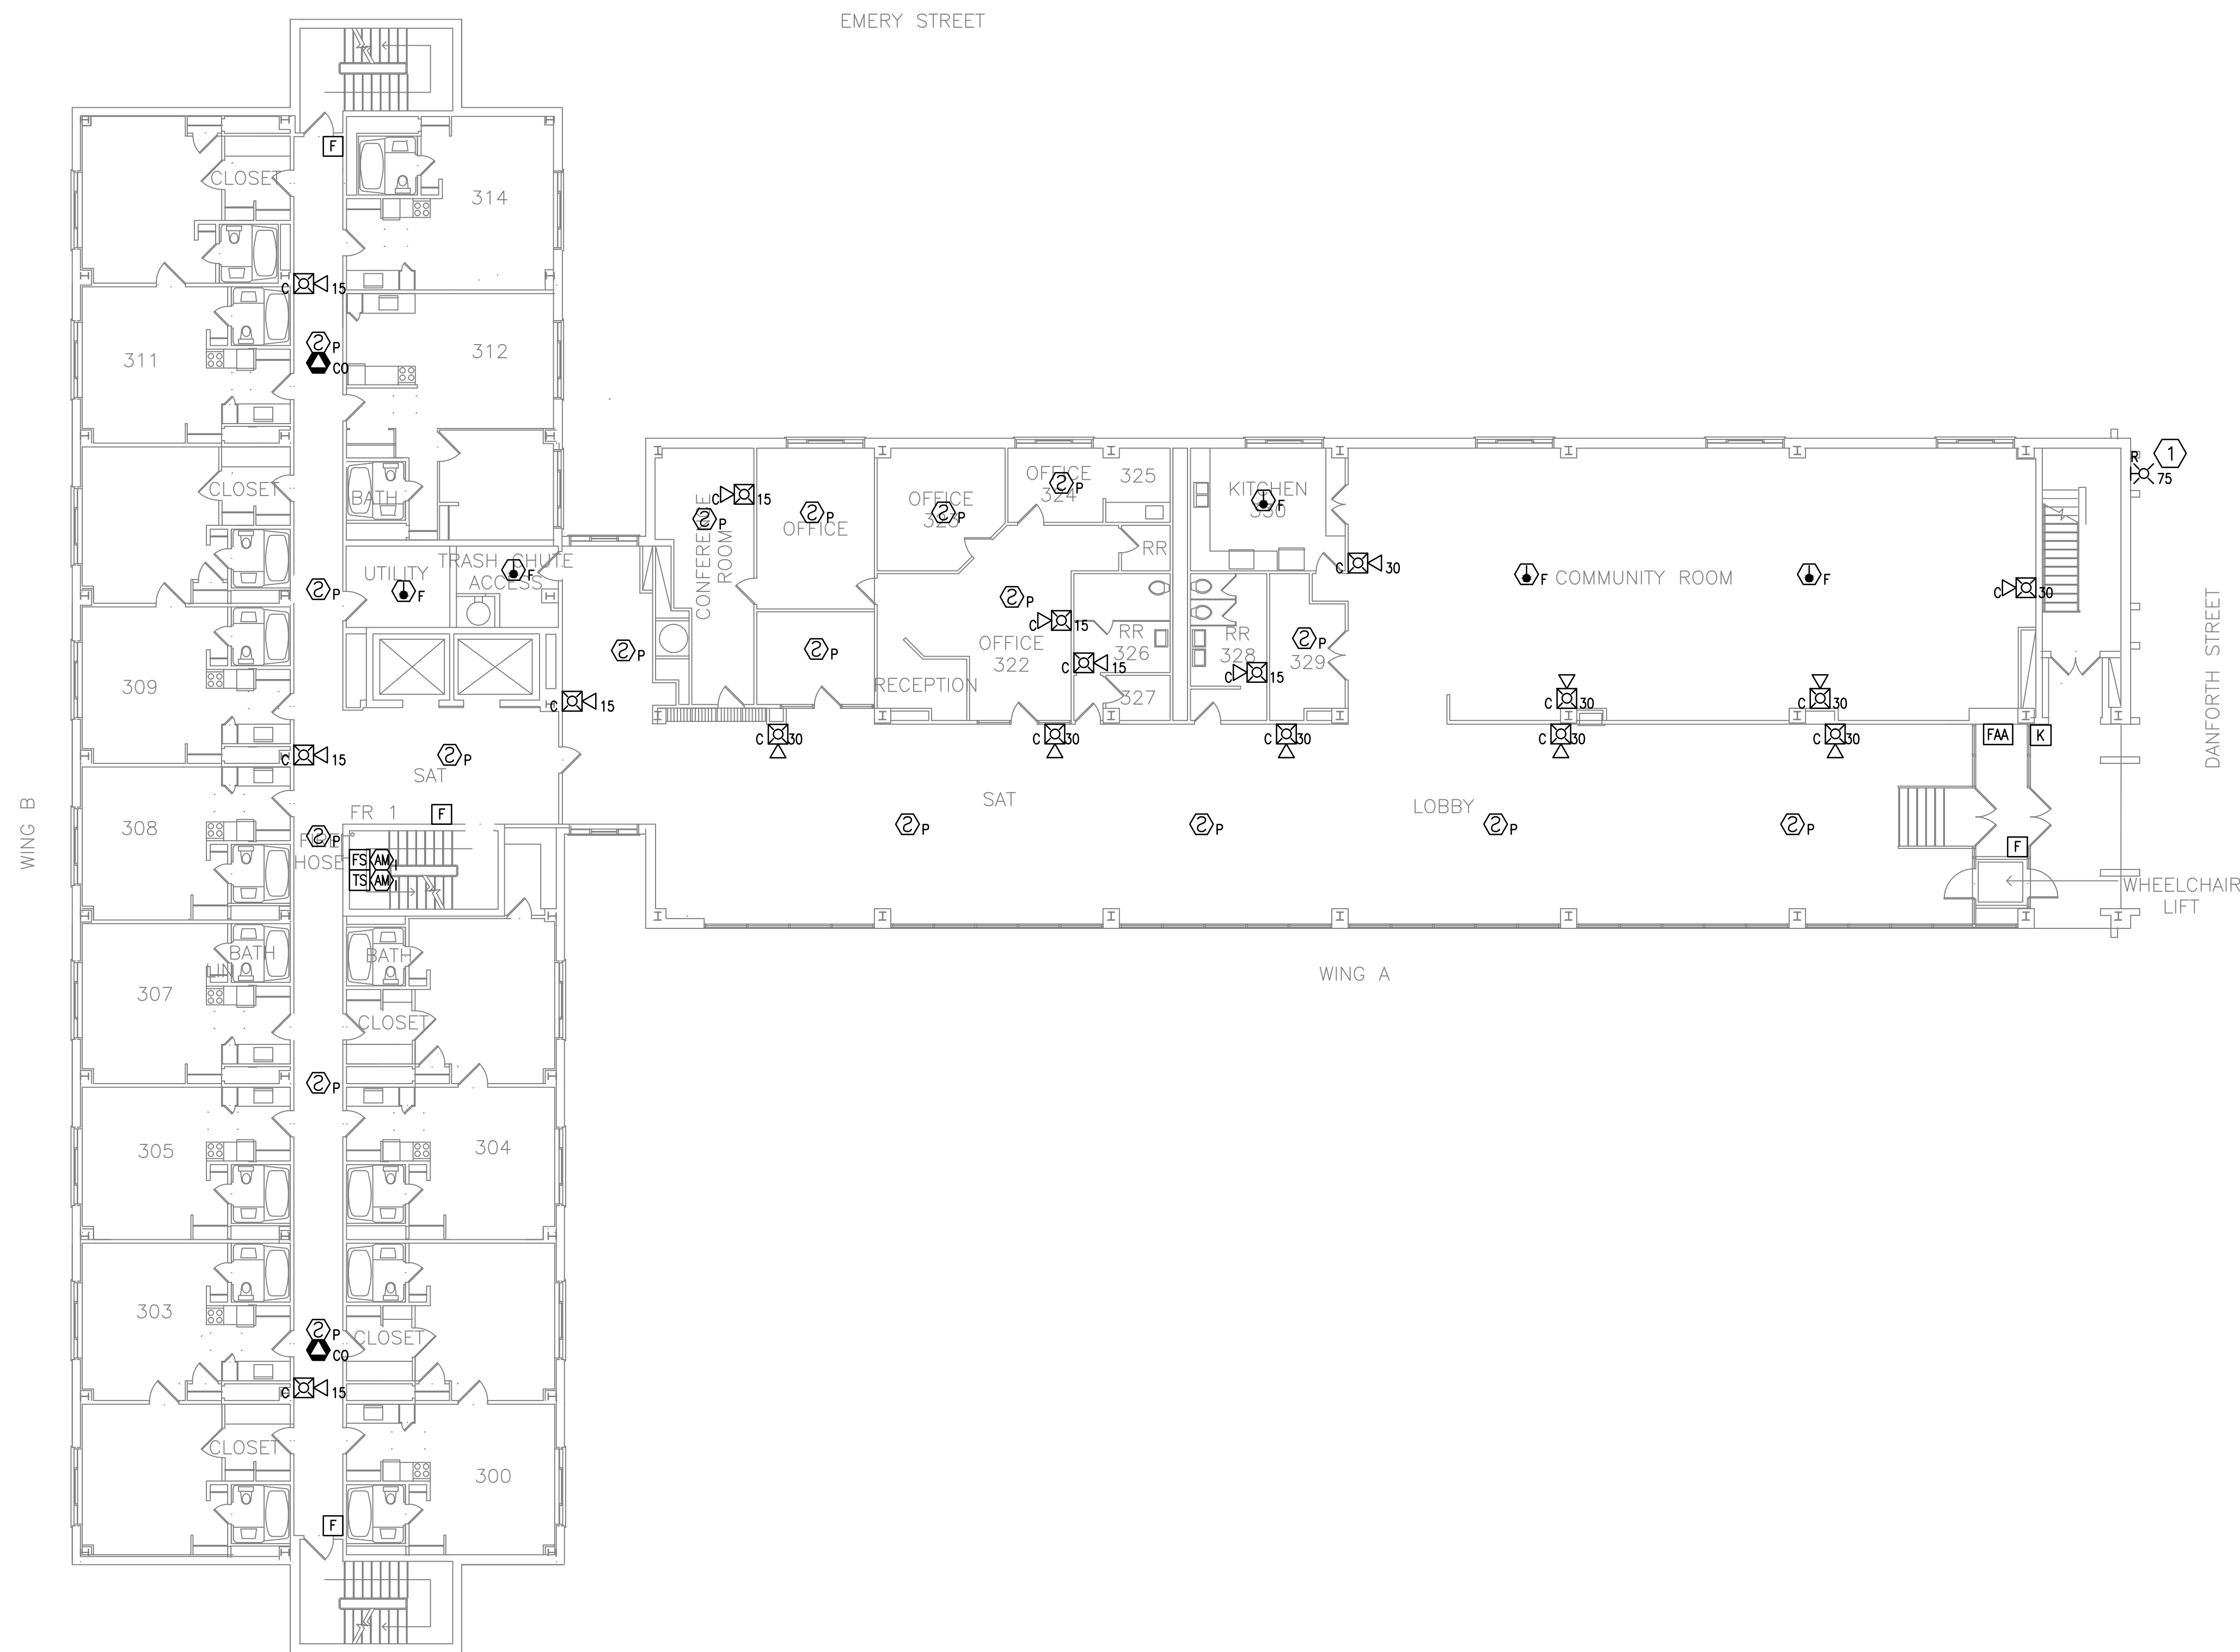



**THIRD FLOOR FIRE ALARM PLAN**

SCALE: 3/32" = 1'-0"

PROJECT

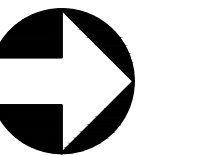

NORTH

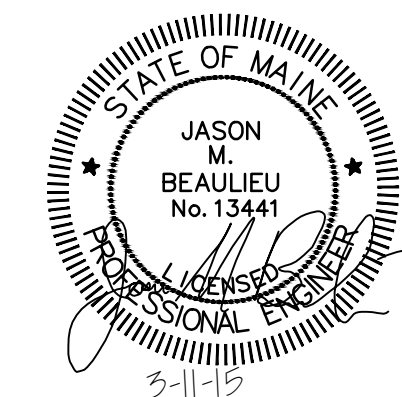 

				PORTLAND HOUSING AUTHORITY PORTLAND, MAINE	
				HARBOR TERRACE FIRE ALARM UPGRADE	
				THIRD FLOOR FIRE ALARM PLAN	
A	ISSUED FOR CONSTRUCTION	BVD	MRL	3/11/15	
REV	DESCRIPTION	DWN	APP	DATE	
PLEASE NOTE: THIS DOCUMENT MAY NOT ACCURATELY REPRESENT THE FINAL DOCUMENT. ONLY AN ENGINEER, ARCHITECT OR SURVEYOR SIGNED, SEALED AND DATED PAPER COPY, PROVIDED BY THIS OFFICE, MAY BE UTILIZED FOR BIDDING OR CONSTRUCTION PURPOSES.		Colby Company engineering		47A York Street Portland, Maine 04101 207.533.7753 colbycoengineering.com	SIZE: ANSI D DATE: 03-11-2015 DES BY: JMB DWN BY: BVD CKD BY: MRL
		PROJECT NO. 218.006.002		DRAWING NO. FA-111	
		SHEET 12 OF 17			