


NOTES:


- SEE SHEET FA-001 FOR LEGEND, ABBREVIATIONS, AND GENERAL NOTES.

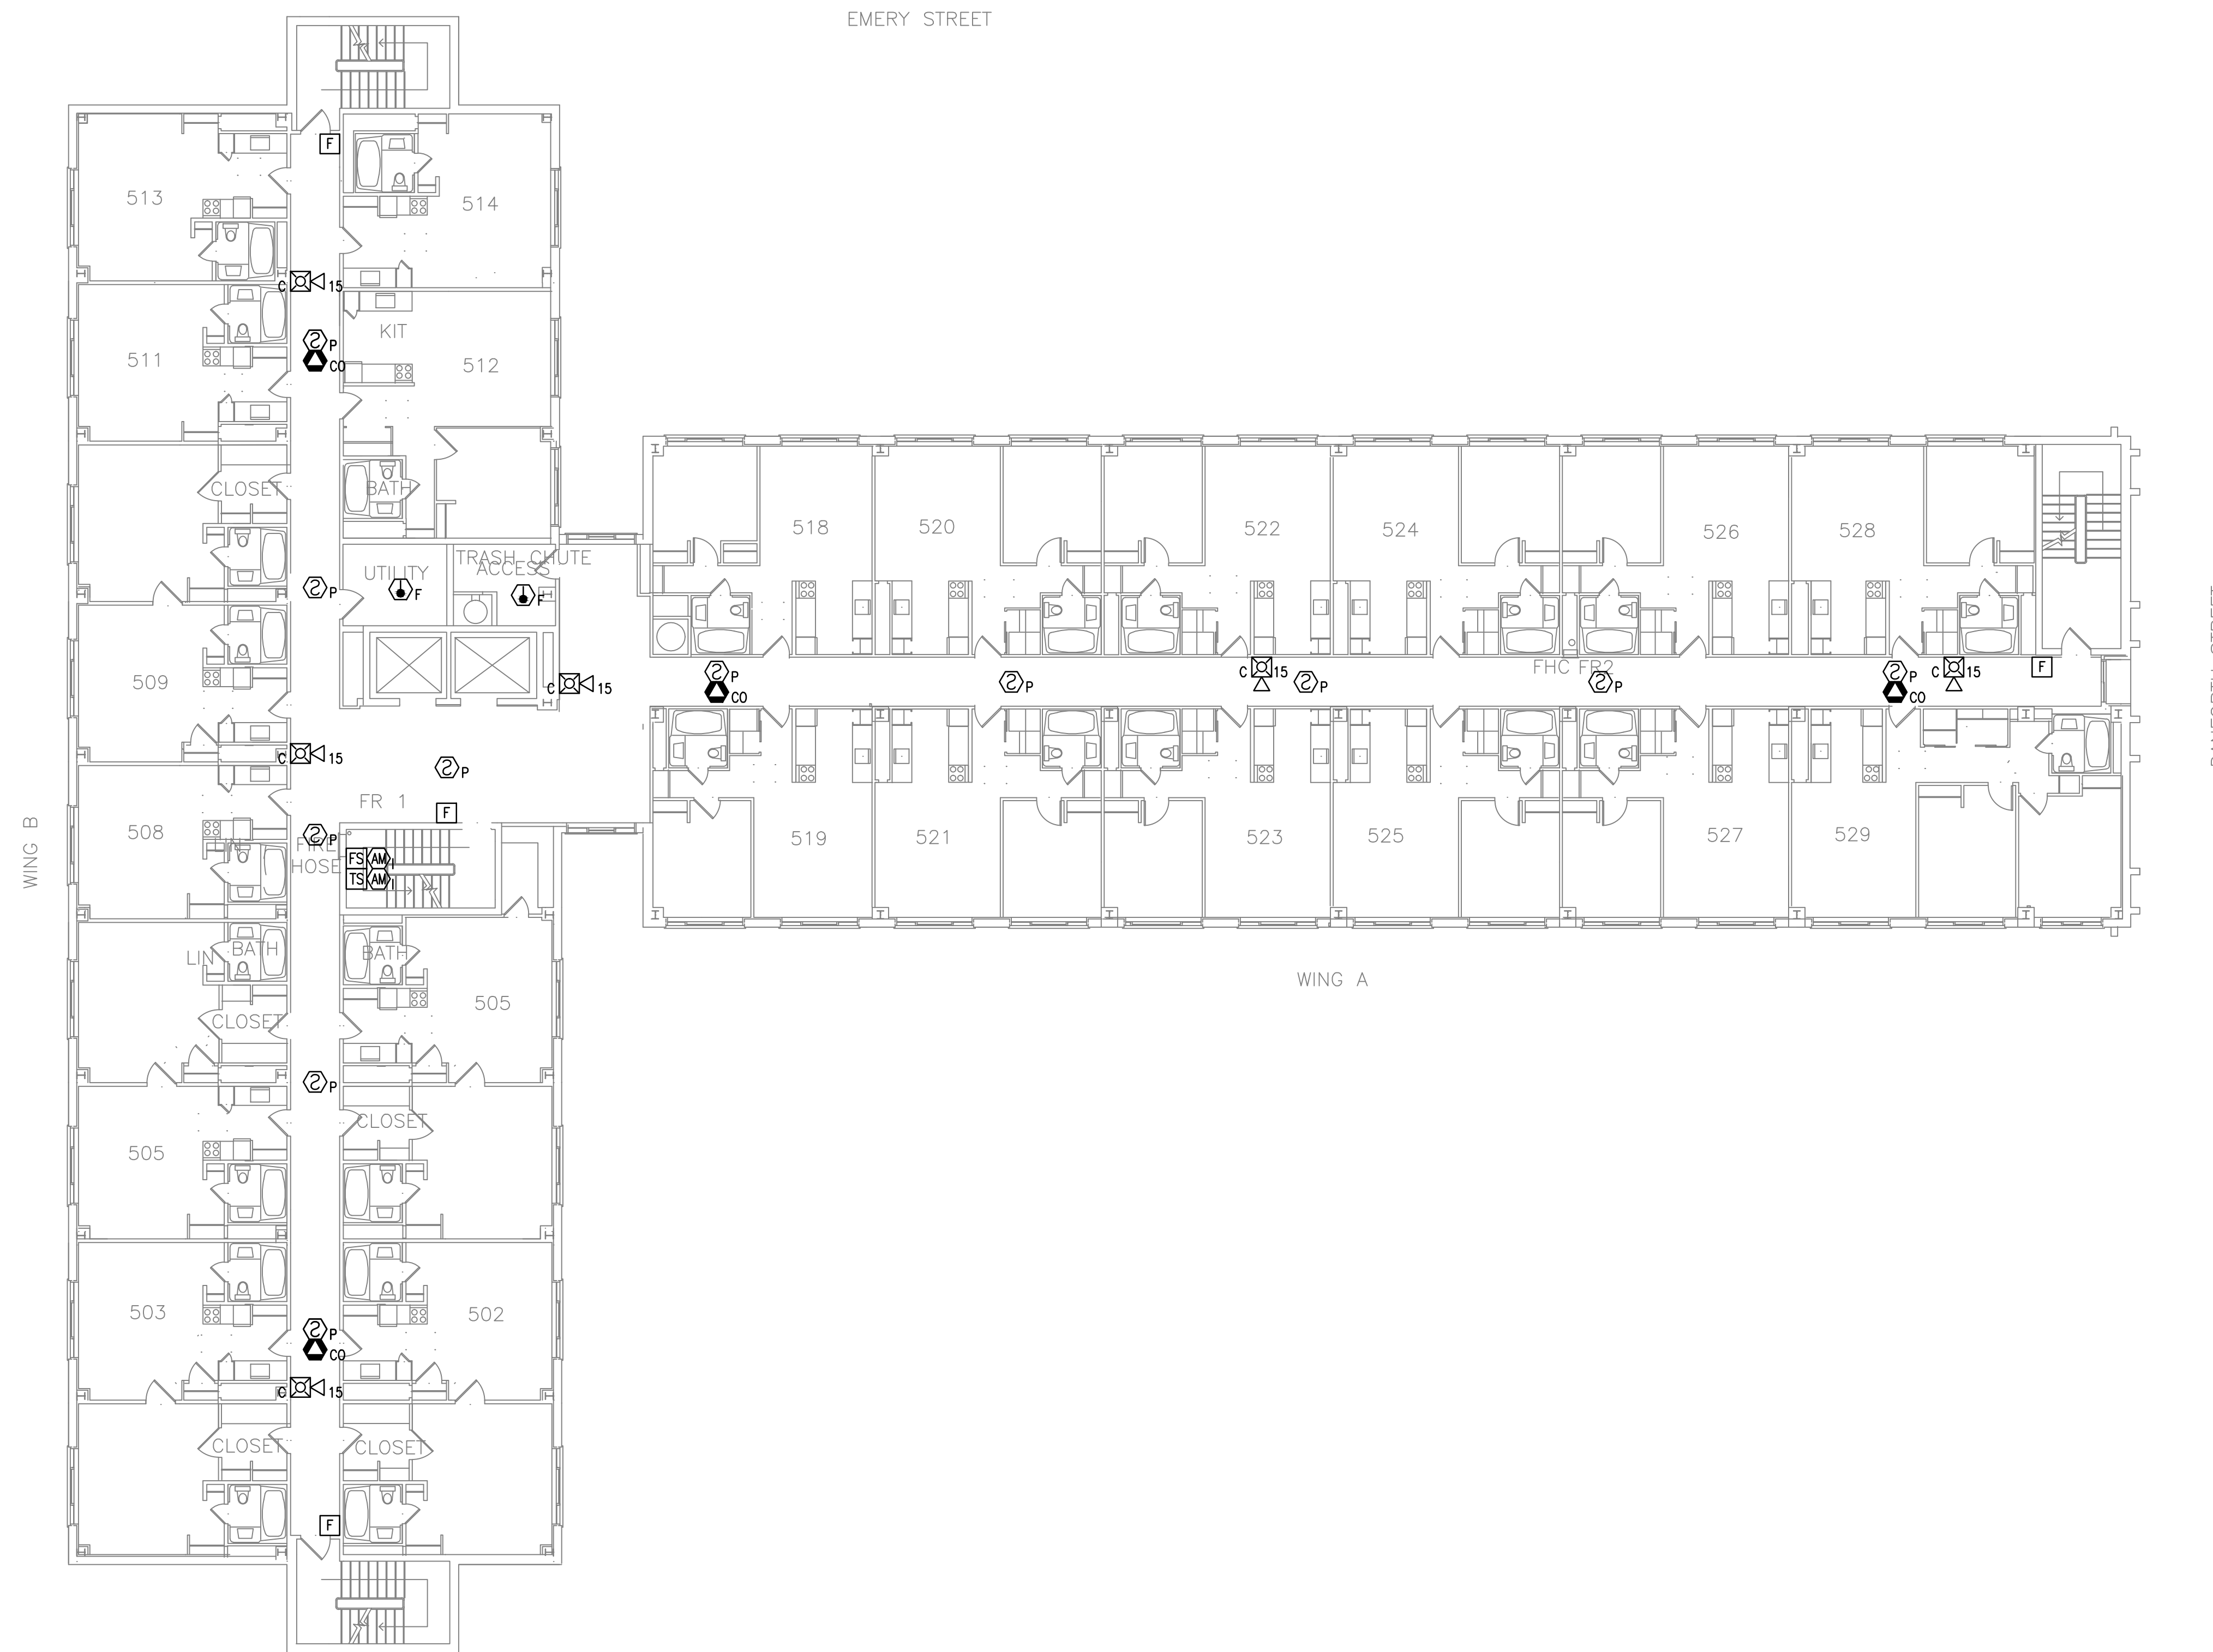



FIFTH FLOOR FIRE ALARM PLAN

SCALE: 3/32" = 1'-0"

PROJECT

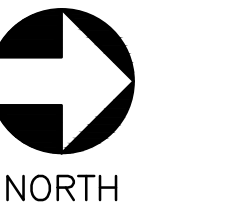

NORTH

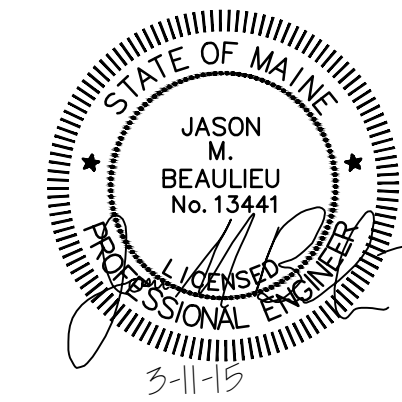 

				PORTLAND HOUSING AUTHORITY PORTLAND, MAINE			
				HARBOR TERRACE FIRE ALARM UPGRADE			
				FIFTH FLOOR FIRE ALARM PLAN			
REV	DESCRIPTION	DWN	APP	DATE	SIZE:	ANSI D	PROJECT NO.
A	ISSUED FOR CONSTRUCTION	BVD	MRL	3/11/15	DATE:	03-11-2015	218.006.002
					DES BY:	JMB	SHEET
					DWN BY:	BVD	14 OF 17
					CKD BY:	MRL	

PLEASE NOTE: THIS DOCUMENT MAY NOT ACCURATELY REPRESENT THE FINAL DOCUMENT. ONLY AN ENGINEER, ARCHITECT OR SURVEYOR SIGNED, SEALED AND DATED PAPER COPY, PROVIDED BY THIS OFFICE, MAY BE UTILIZED FOR BIDDING OR CONSTRUCTION PURPOSES.

Colby Company
engineering
47A York Street
Portland, Maine 04101
207.533.7753
colbycoengineering.com

FA-113