


NOTES:

- SEE SHEET FA-001 FOR LEGEND, ABBREVIATIONS, AND GENERAL NOTES.

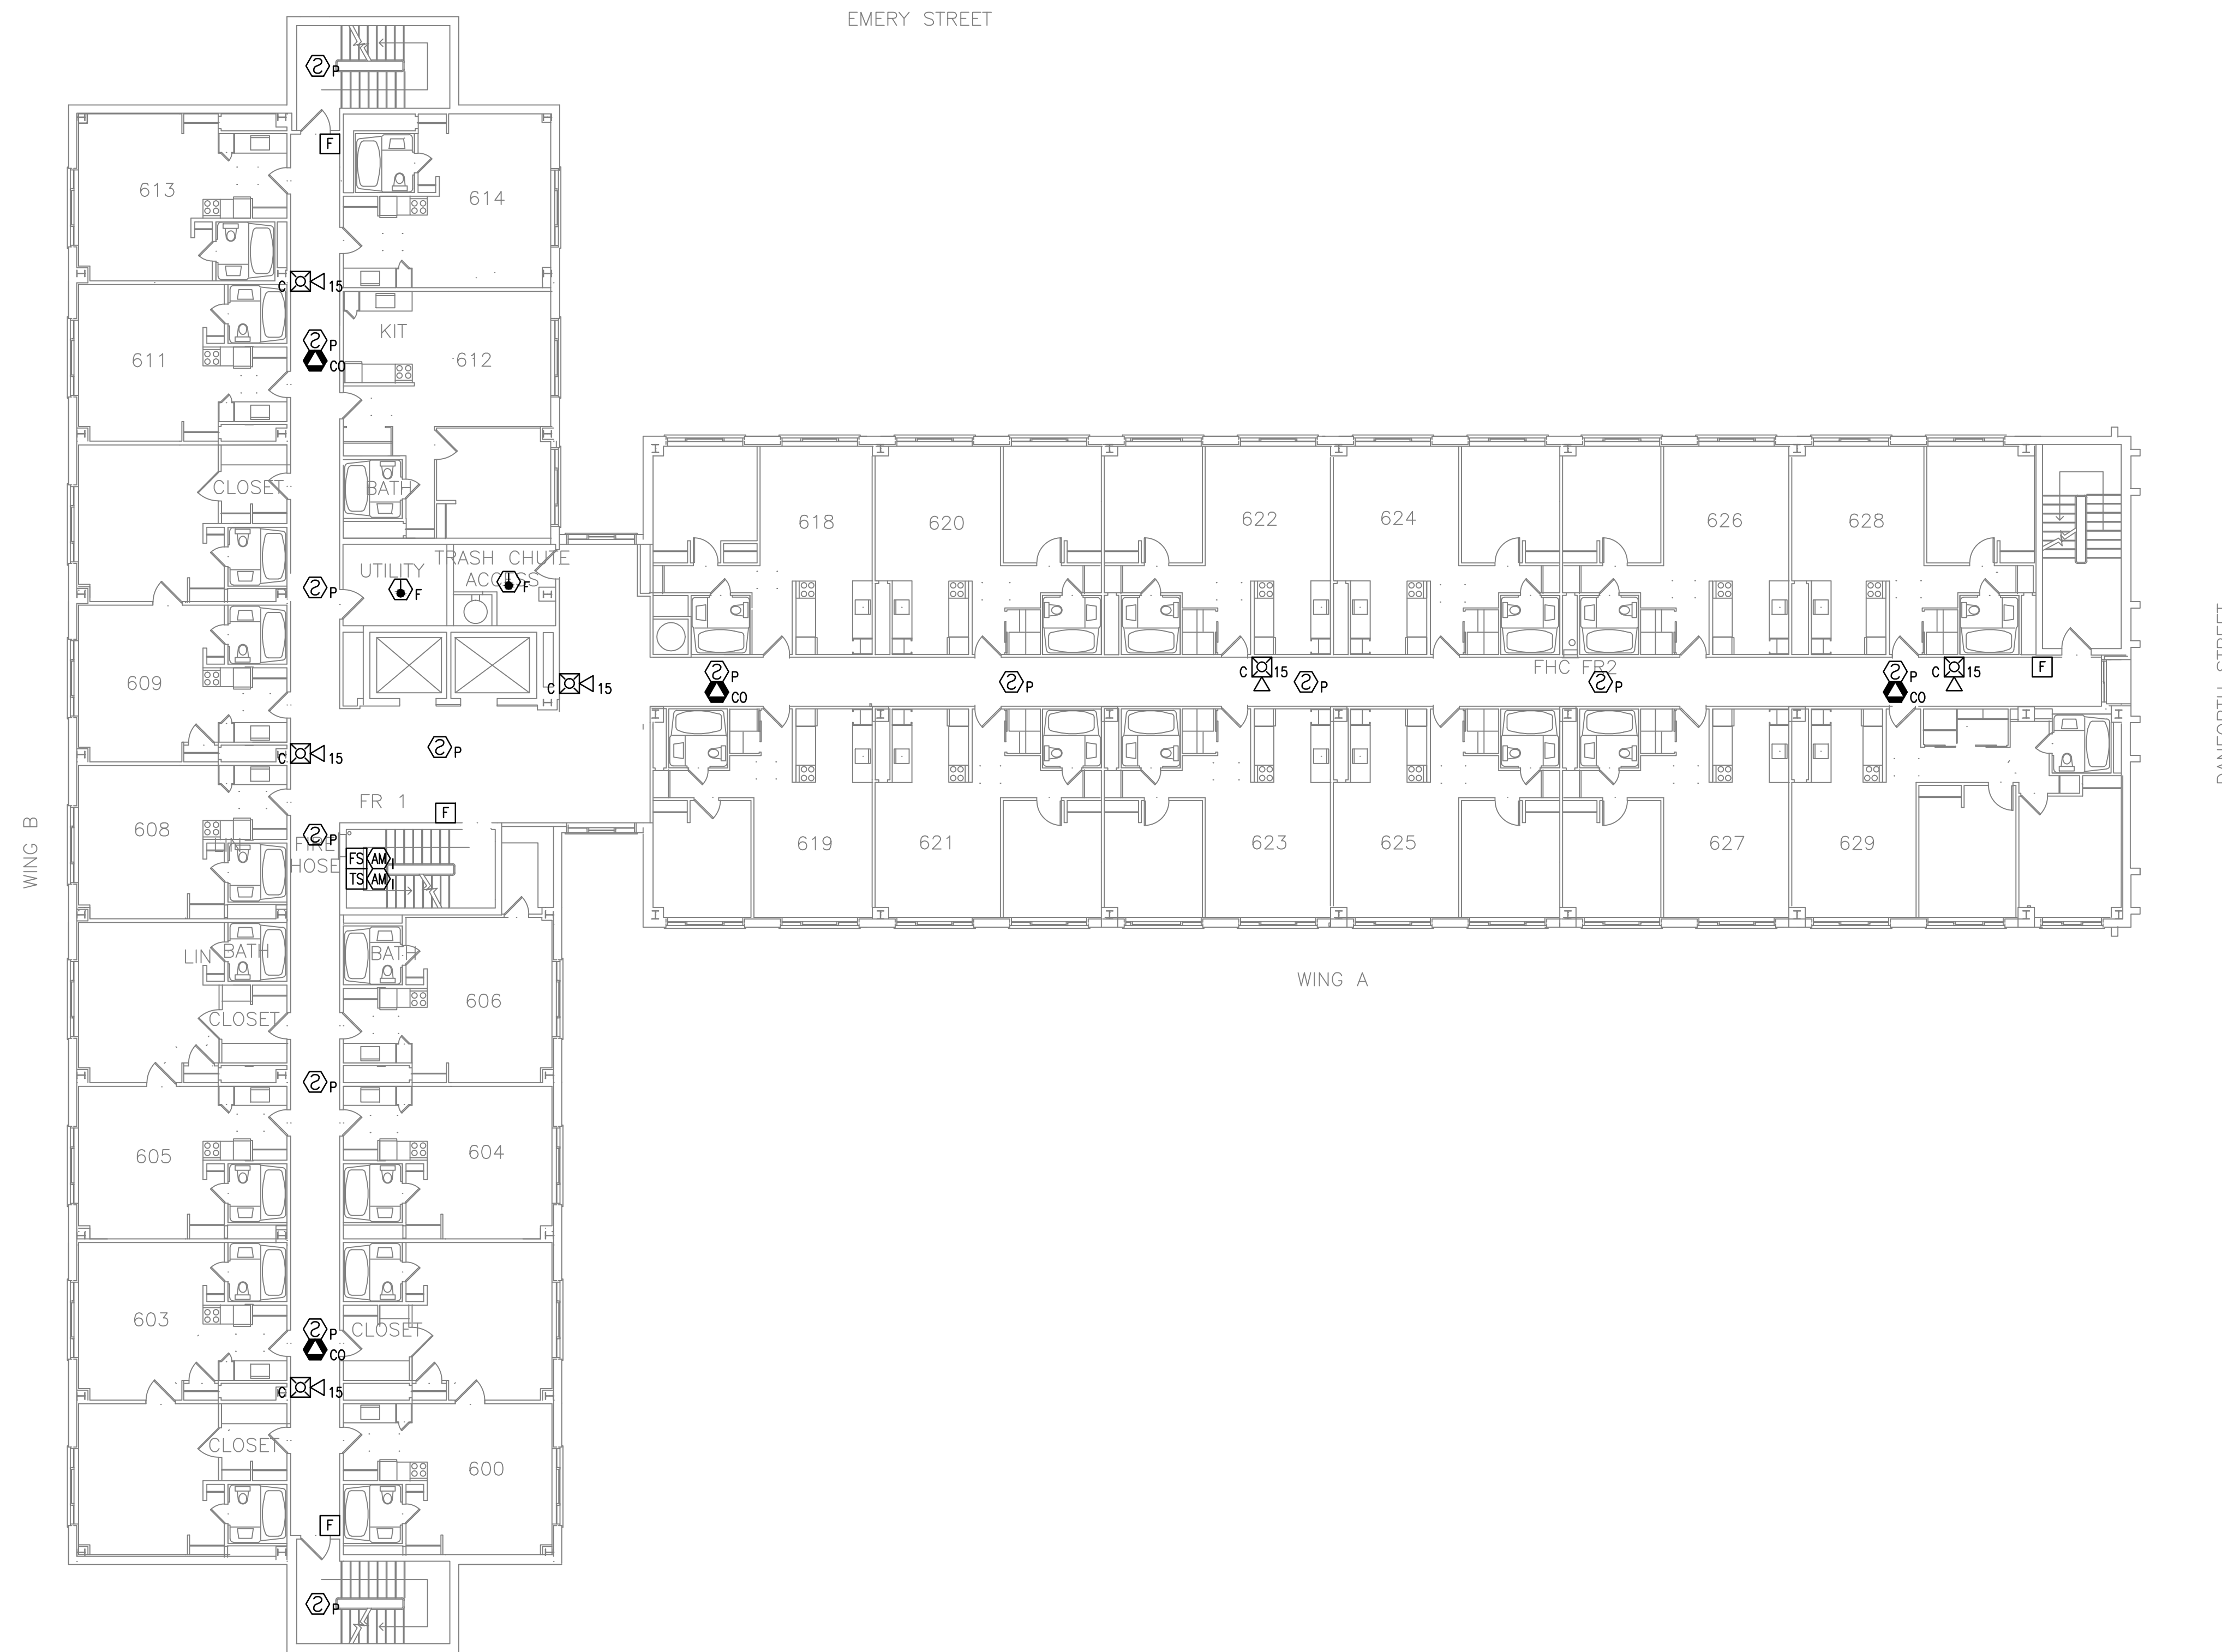


 
SIXTH FLOOR FIRE ALARM PLAN

SCALE: 3/32" = 1'-0"


PROJECT



NORTH

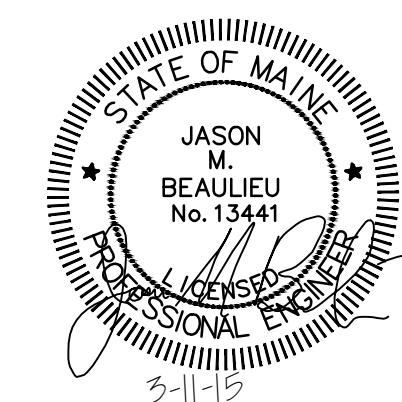

				PORTLAND HOUSING AUTHORITY PORTLAND, MAINE	
				HARBOR TERRACE FIRE ALARM UPGRADE	
				SIXTH FLOOR FIRE ALARM PLAN	
A	ISSUED FOR CONSTRUCTION	BVD	MRL	3/11/15	
REV	DESCRIPTION	DWN	APP	DATE	
PLEASE NOTE: THIS DOCUMENT MAY NOT ACCURATELY REPRESENT THE FINAL DOCUMENT. ONLY AN ENGINEER, ARCHITECT OR SURVEYOR SIGNED, SEALED AND DATED PAPER COPY, PROVIDED BY THIS OFFICE, MAY BE UTILIZED FOR BIDDING OR CONSTRUCTION PURPOSES.		SIZE: ANSI D		PROJECT NO.	DRAWING NO.
		DATE: 03-11-2015		218.006.002	FA-114
		DES BY: JMB		SHEET	
		DWN BY: BVD		15 OF 17	
		CKD BY: MRL			

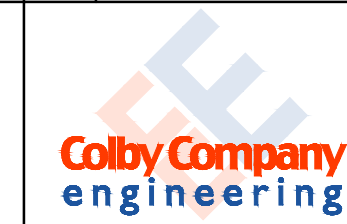

47A York Street
Portland, Maine 04101
207.533.7753
colbycoengineering.com