


NOTES:


- SEE SHEET FA-001 FOR LEGEND, ABBREVIATIONS, AND GENERAL NOTES.

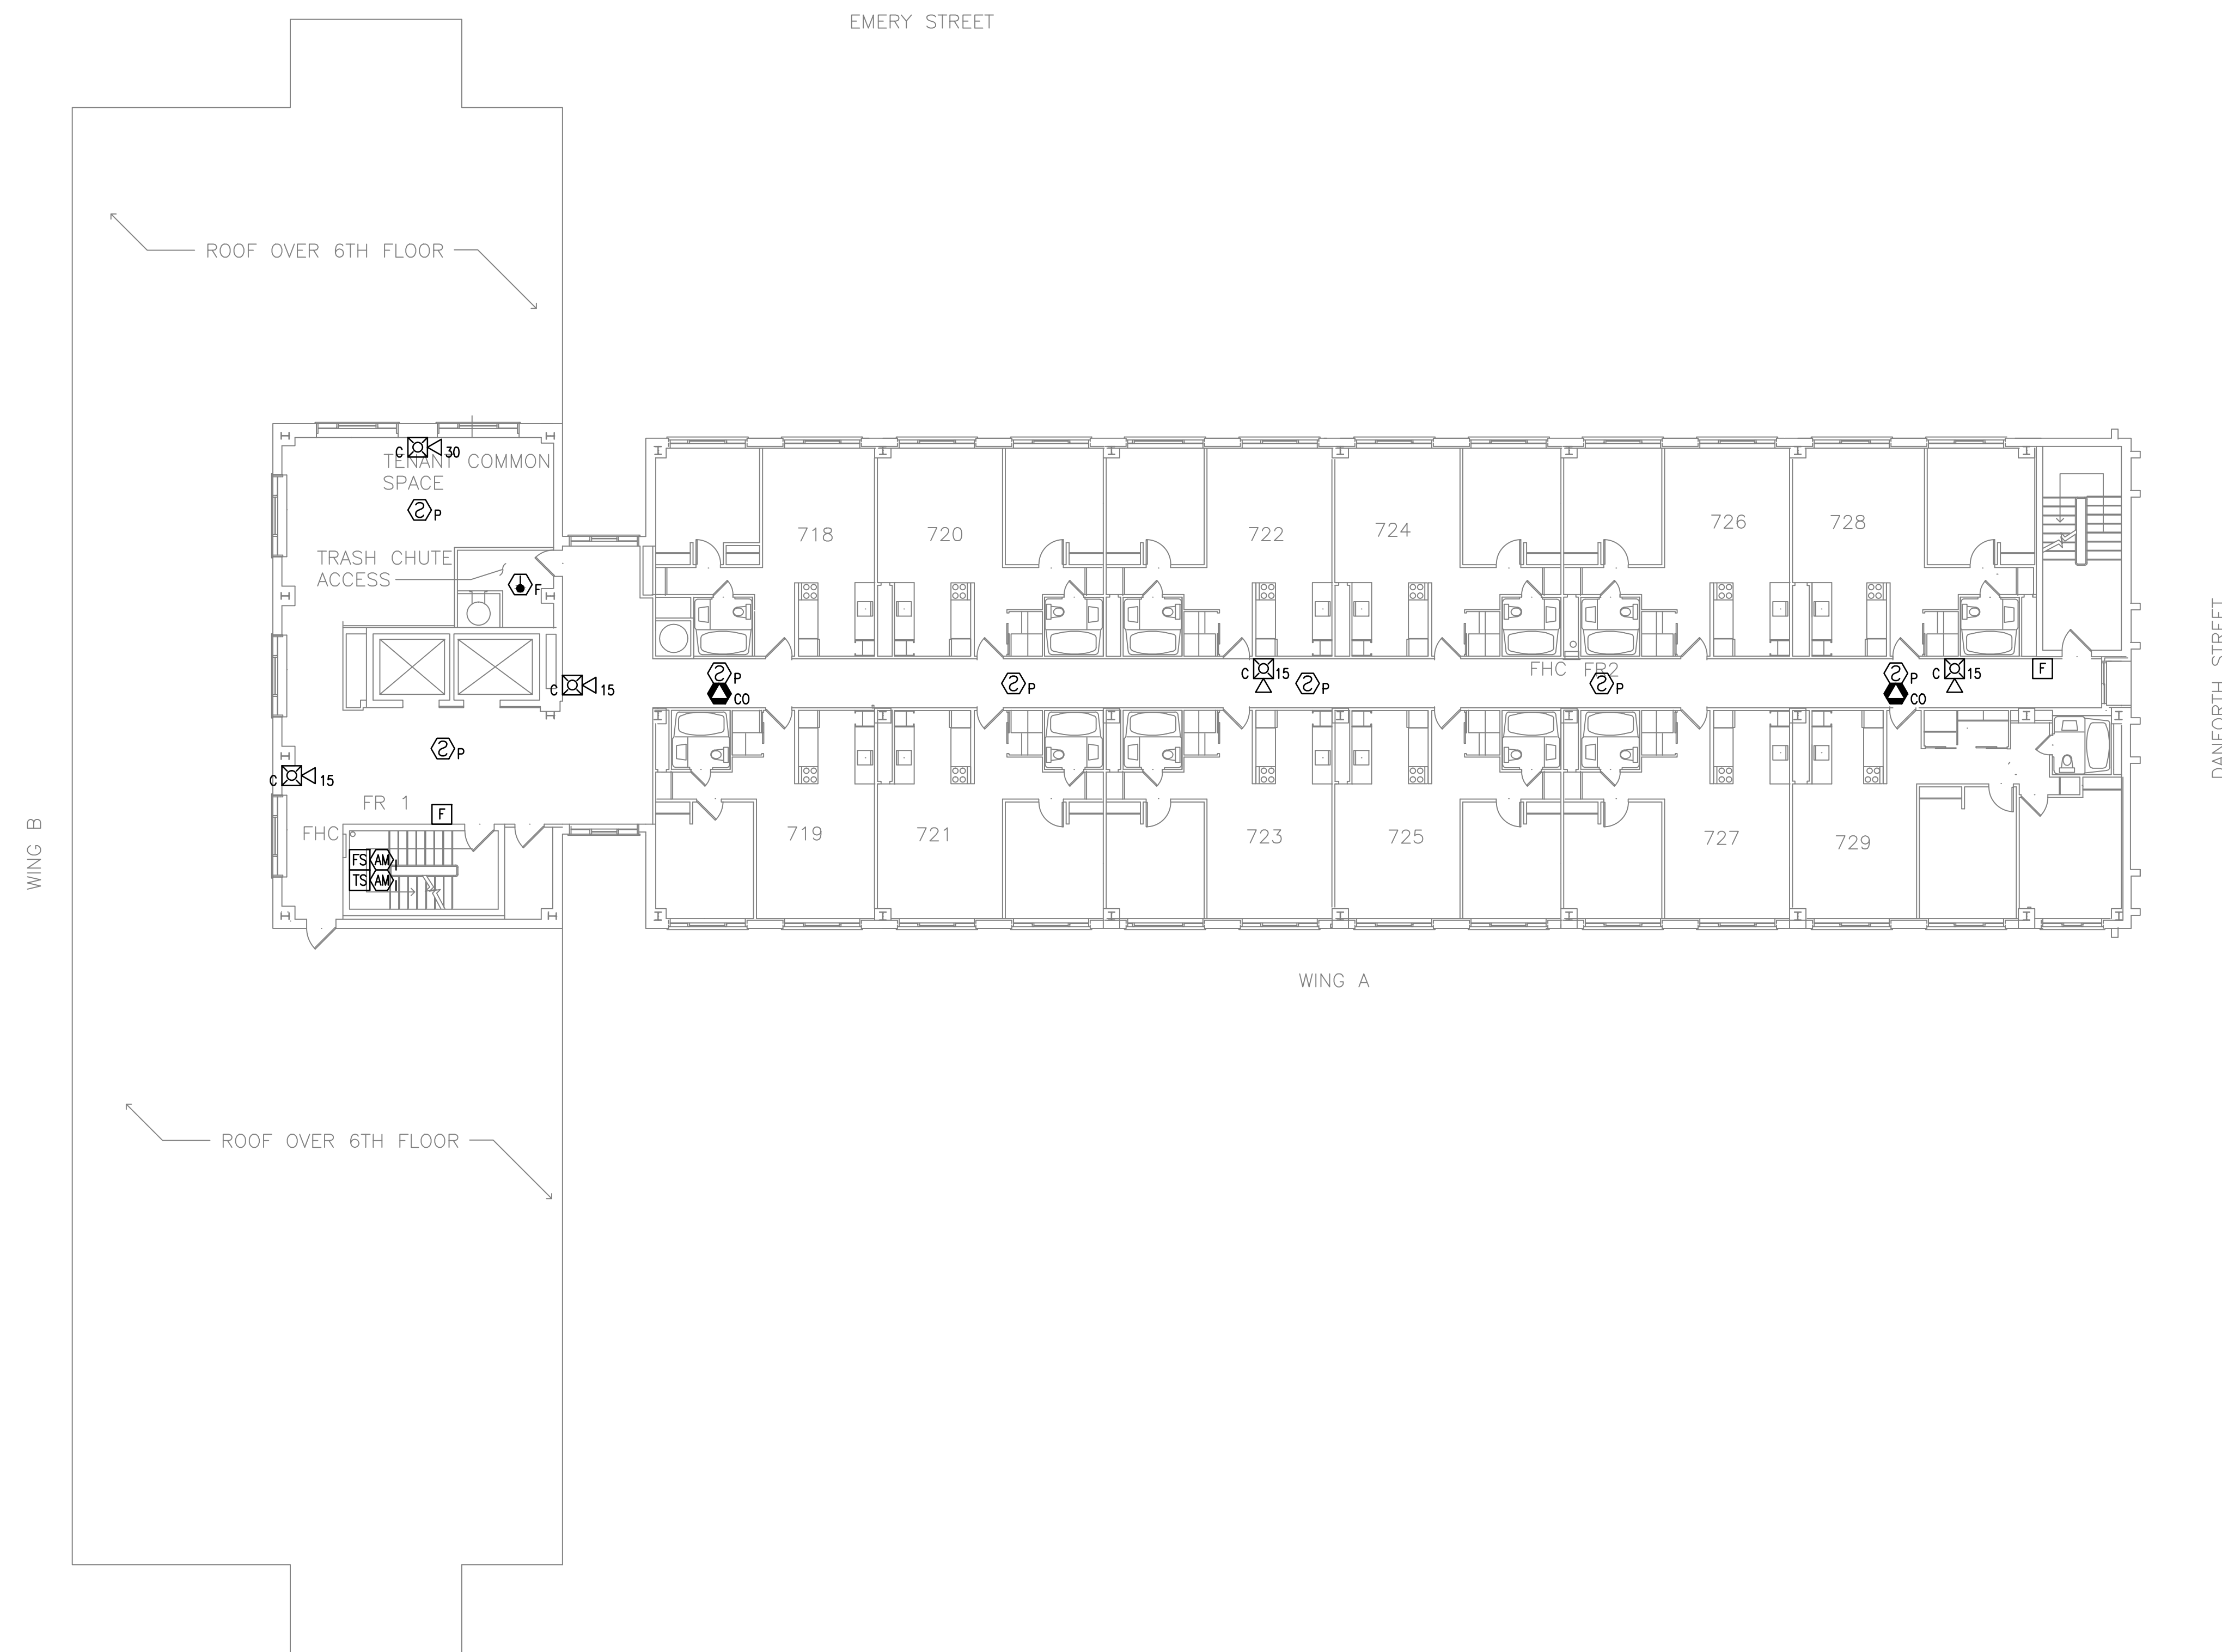



SEVENTH FLOOR FIRE ALARM PLAN

SCALE: 3/32" = 1'-0"

PROJECT

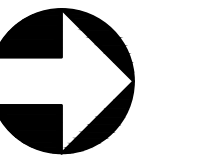

NORTH

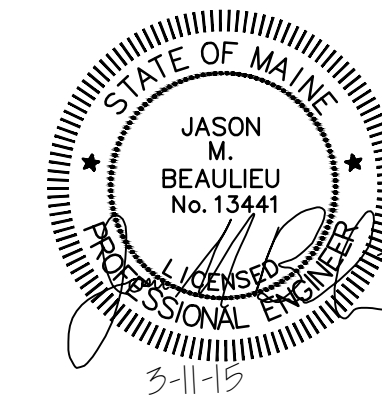 

				PORTLAND HOUSING AUTHORITY PORTLAND, MAINE	
				HARBOR TERRACE FIRE ALARM UPGRADE	
				SEVENTH FLOOR FIRE ALARM PLAN	
A	ISSUED FOR CONSTRUCTION	BVD	MRL	3/11/15	
REV	DESCRIPTION	DWN	APP	DATE	
		SIZE:	ANSI D		PROJECT NO.
		DATE:	03-11-2015		218.006.002
		DES BY:	JMB		SHEET
		DWN BY:	BVD		16 OF 17
		CKD BY:	MRL		

PLEASE NOTE: THIS DOCUMENT MAY NOT ACCURATELY REPRESENT THE FINAL DOCUMENT. ONLY AN ENGINEER, ARCHITECT OR SURVEYOR SIGNED, SEALED AND DATED PAPER COPY, PROVIDED BY THIS OFFICE, MAY BE UTILIZED FOR BIDDING OR CONSTRUCTION PURPOSES.

Colby Company
engineering
47A York Street
Portland, Maine 04101
207.533.7753
colbycoengineering.com

FA-115