


011	STAFF BREAK	PAINT	VCT	VINYL BASE	ACOUSTICAL CEILING TILE	10'-2"	<p>KITCHENETTE: PROVIDE 36"W X 32.5"H SINK BASE CABINET W/HANDICAP REMOVABLE FRONT AND 36"W X 32.5" W (2 DOOR/ 2 DRAWER) BASE CABINET; PROVIDE 72"W X 30"H WALL CABINETS ABOVE (4 DOORS); LAUNDRY AREA: PROVIDE 54"W X 32.5"H BASE CABINETS (3 DOORS/ 3 DRAWERS); PROVIDE 54"W X 30"H WALL CABINETS ABOVE (3 DOORS)</p>	011	STAFF BREAK	3'-0" X 7'-0" WITH NARROW LITE	LEVER PASSAGE SET	
-----	-------------	-------	-----	---------------	-------------------------------	--------	---------------------------------------------------------------------------------------------------------------------------------------------------------------------------------------------------------------------------------------------------------------------------------------------------------------------------------------	-----	-------------	--------------------------------------	----------------------	--


FLOOR PLAN

1/8" = 1'-0"

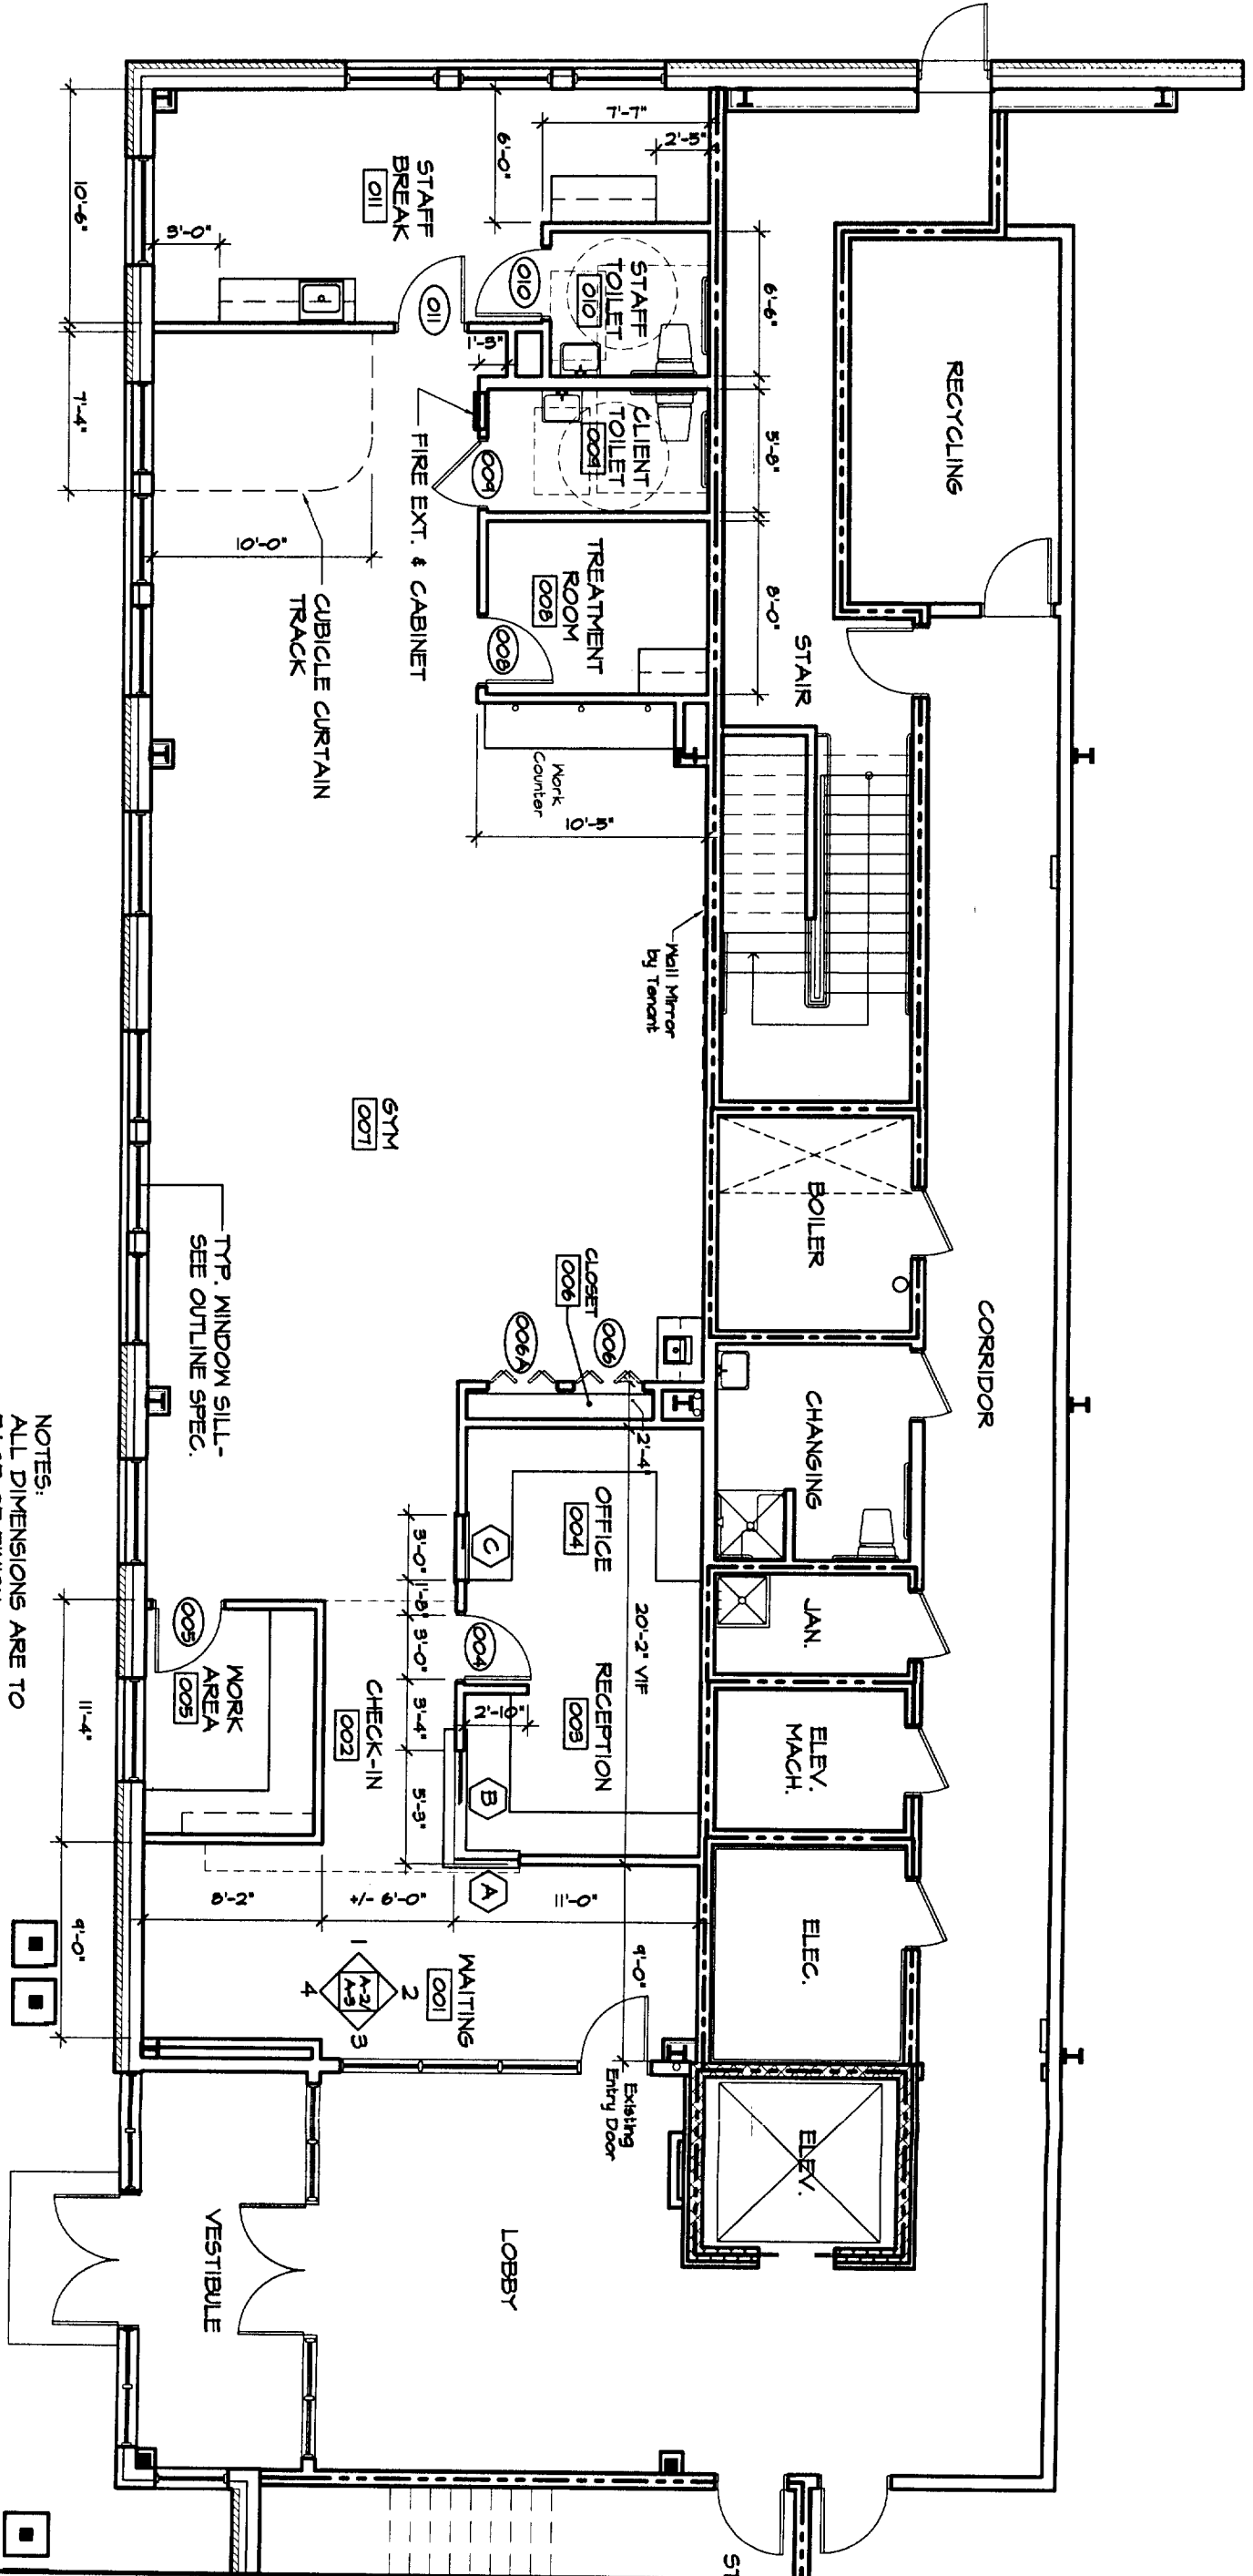


NOTES:
 ALL DIMENSIONS ARE TO FACE OF FINISH.
 PROVIDE WOOD BLOCKING FOR WALL MOUNTED ITEMS AS REQUIRED.
 SEE INTERIOR ELEVATIONS FOR ADDITIONAL DIMENSIONS AND INFORMATION.



TYP. WINDOW SILL - SEE OUTLINE SPEC.

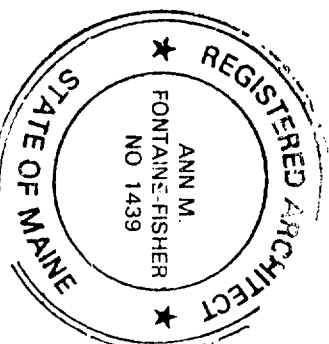

ARCHITECTURE
 INTERIOR DESIGN
 PLANNING
P D T A R C H I T E C T S
 49 DARTMOUTH STREET
 PORTLAND, ME 04101
 207 775-1059
 207 775-2604 FAX

ADVANCED PHYSICAL THERAPY 50 SEWALL STREET, PORTLAND		JOB # 06-006 DATE MARCH 28, 2006 SCALE 1/8"=1'-0"	SHEET A-1
TITLE FLOOR PLAN			

 

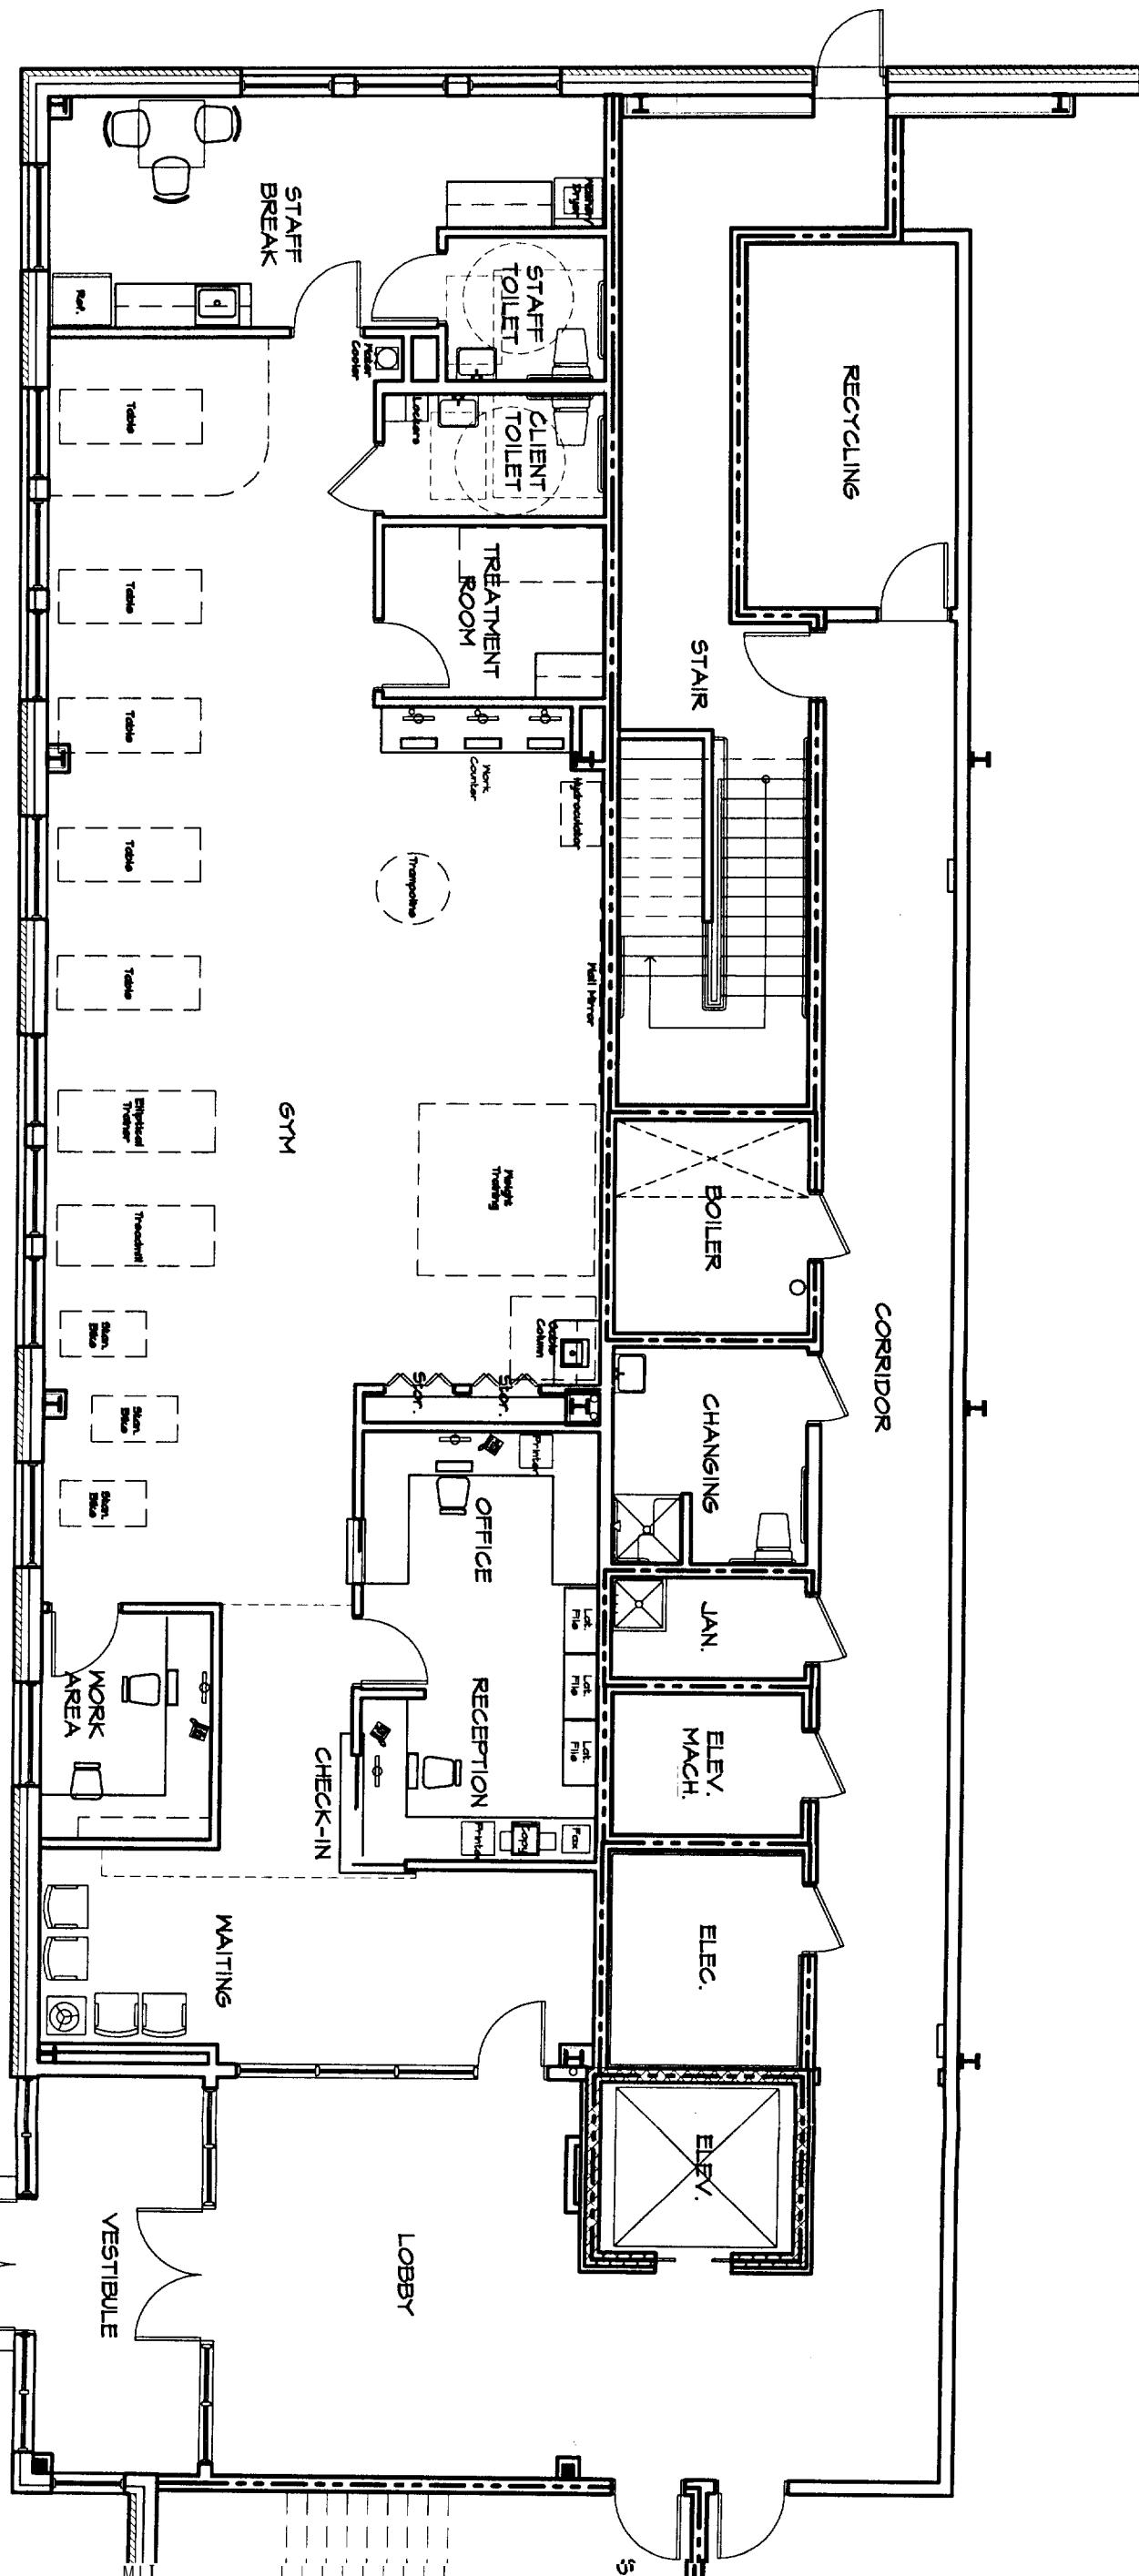 

FURNITURE & EQ

ARCHITECTURE
INTERIOR DESIGN
PLANNING

P D T A R C H I T E C T S

49 DARTMOUTH STREET
PORTLAND, ME 04101
207 775-1059
207 775-2694 FAX


© 2002 P D T Architects

ADVANCED PHYSICAL THERAPY
50 SEWALL STREET, PORTLAND


TITLE
FURNITURE & EQUIPMENT
PLAN

JOB #	06-006
DATE	March 28, 2006
SCALE	1/8"=1'-0"


SHEET
F&E-1

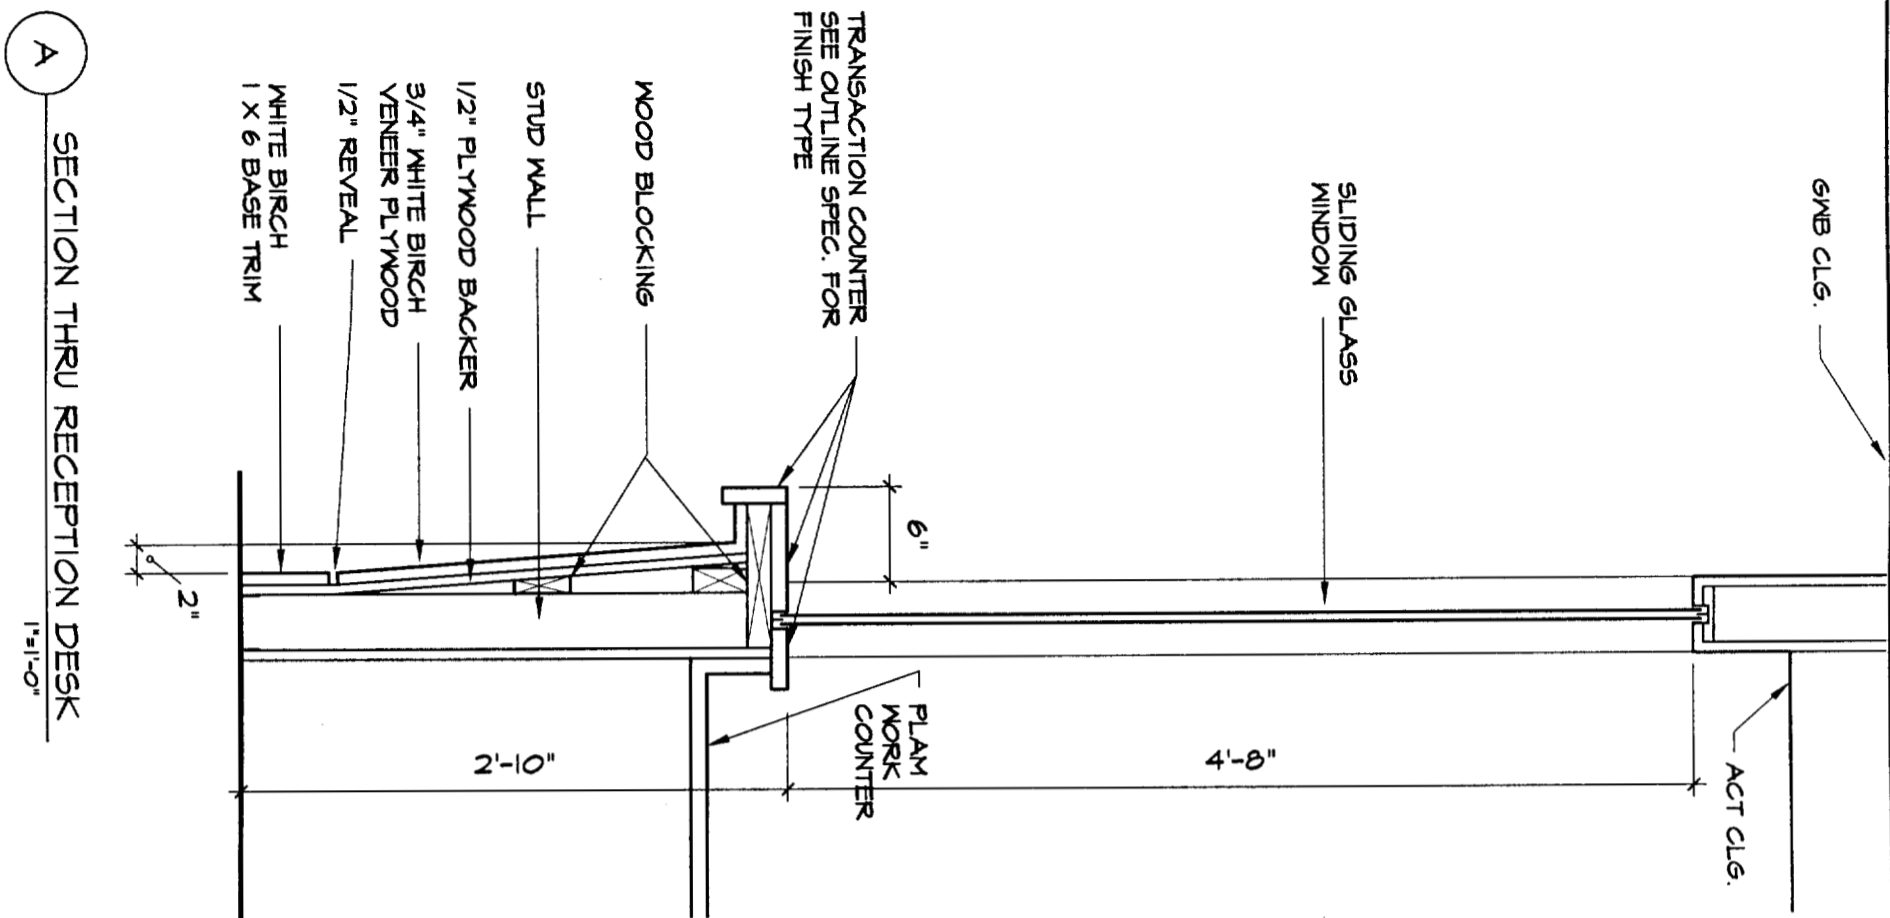


A SECTION THRU RECEPTION DESK
1/4" = 1'-0"

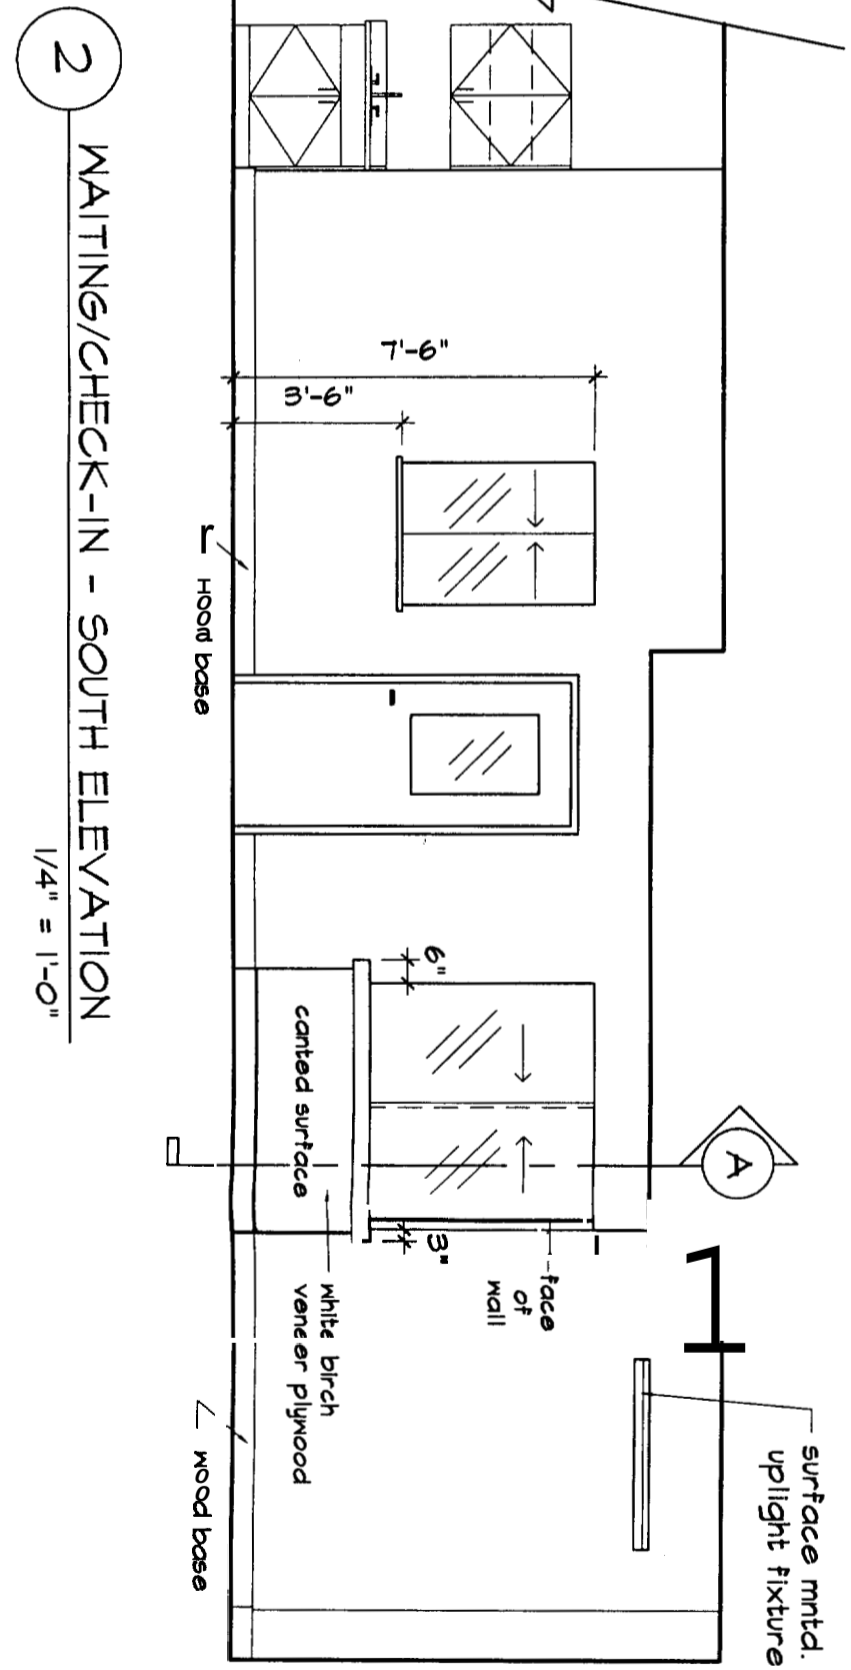


2 WAITING/CHECK-IN - SOUTH ELEVATION
1/4" = 1'-0"

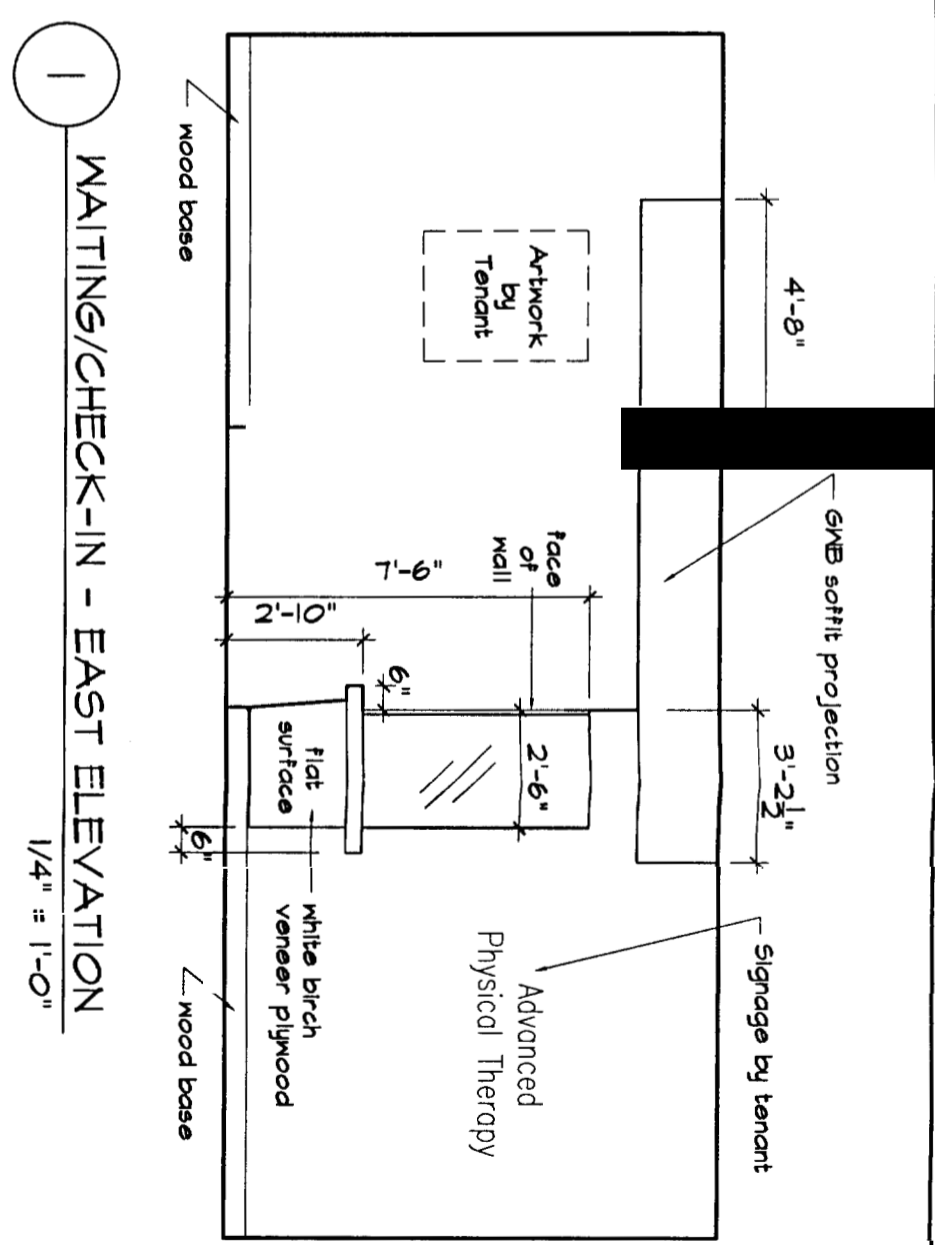


1 WAITING/CHECK-IN - EAST ELEVATION
1/4" = 1'-0"

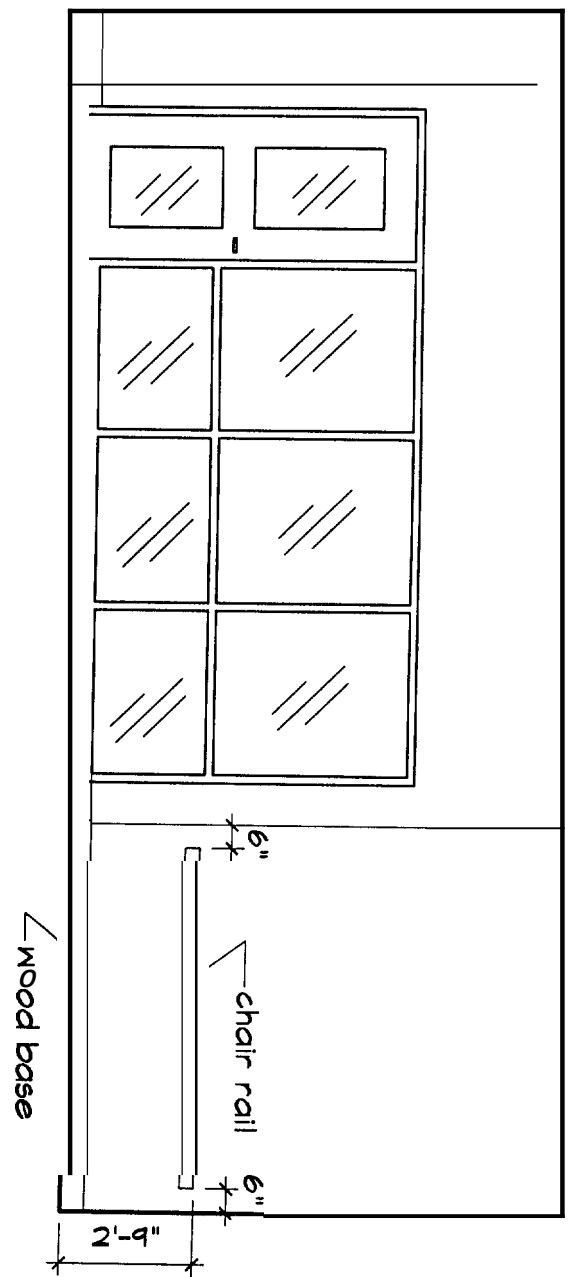


3 WAITING/CHECK-IN - WEST ELEVATION
1/4" = 1'-0"

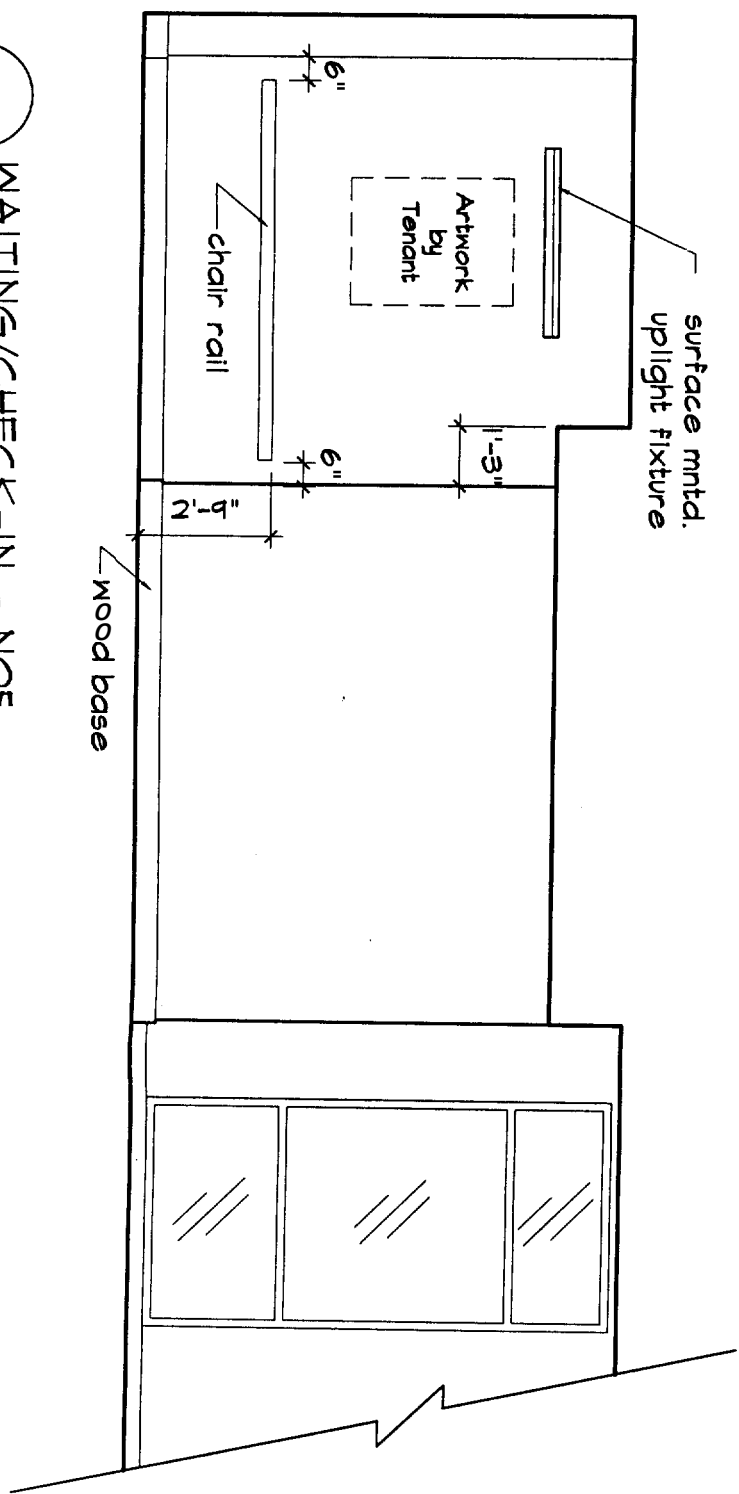

4 WAITING/CHECK-IN - NOF
1/4" = 1'-0"

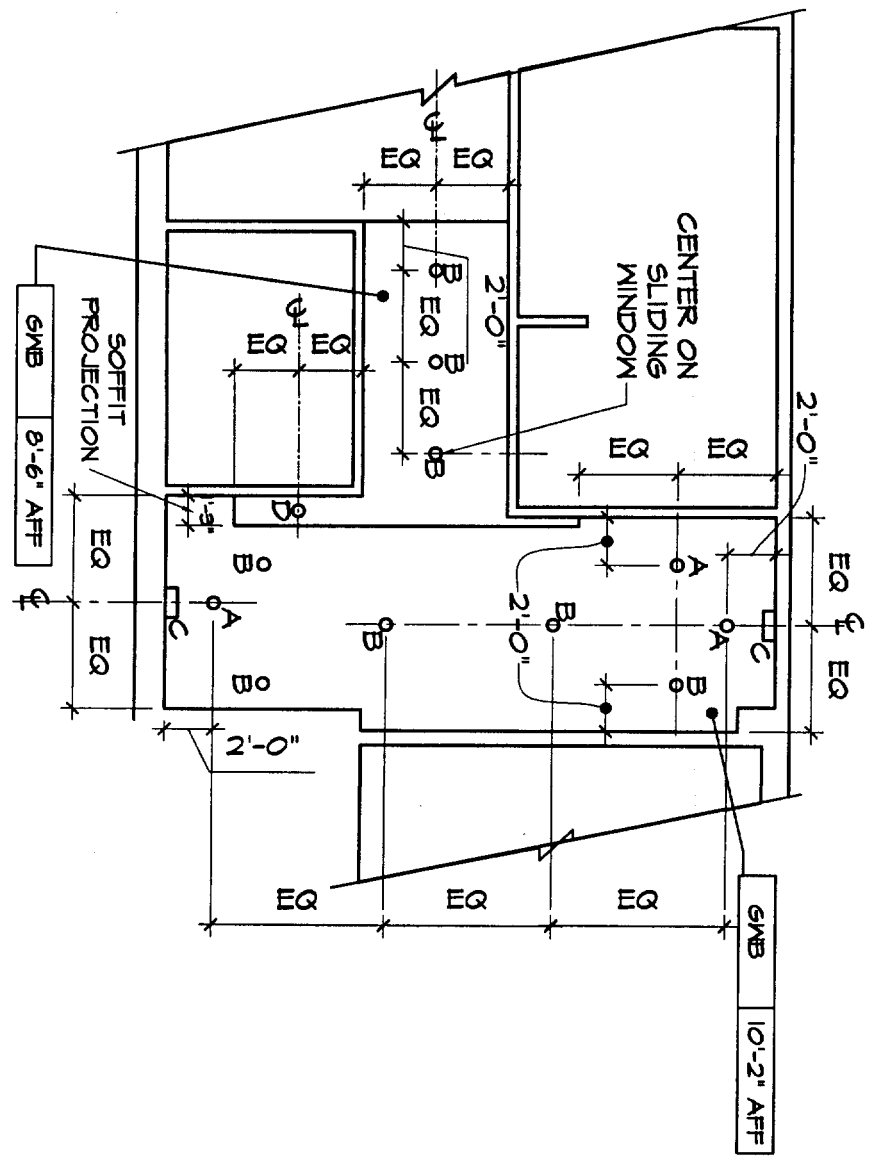

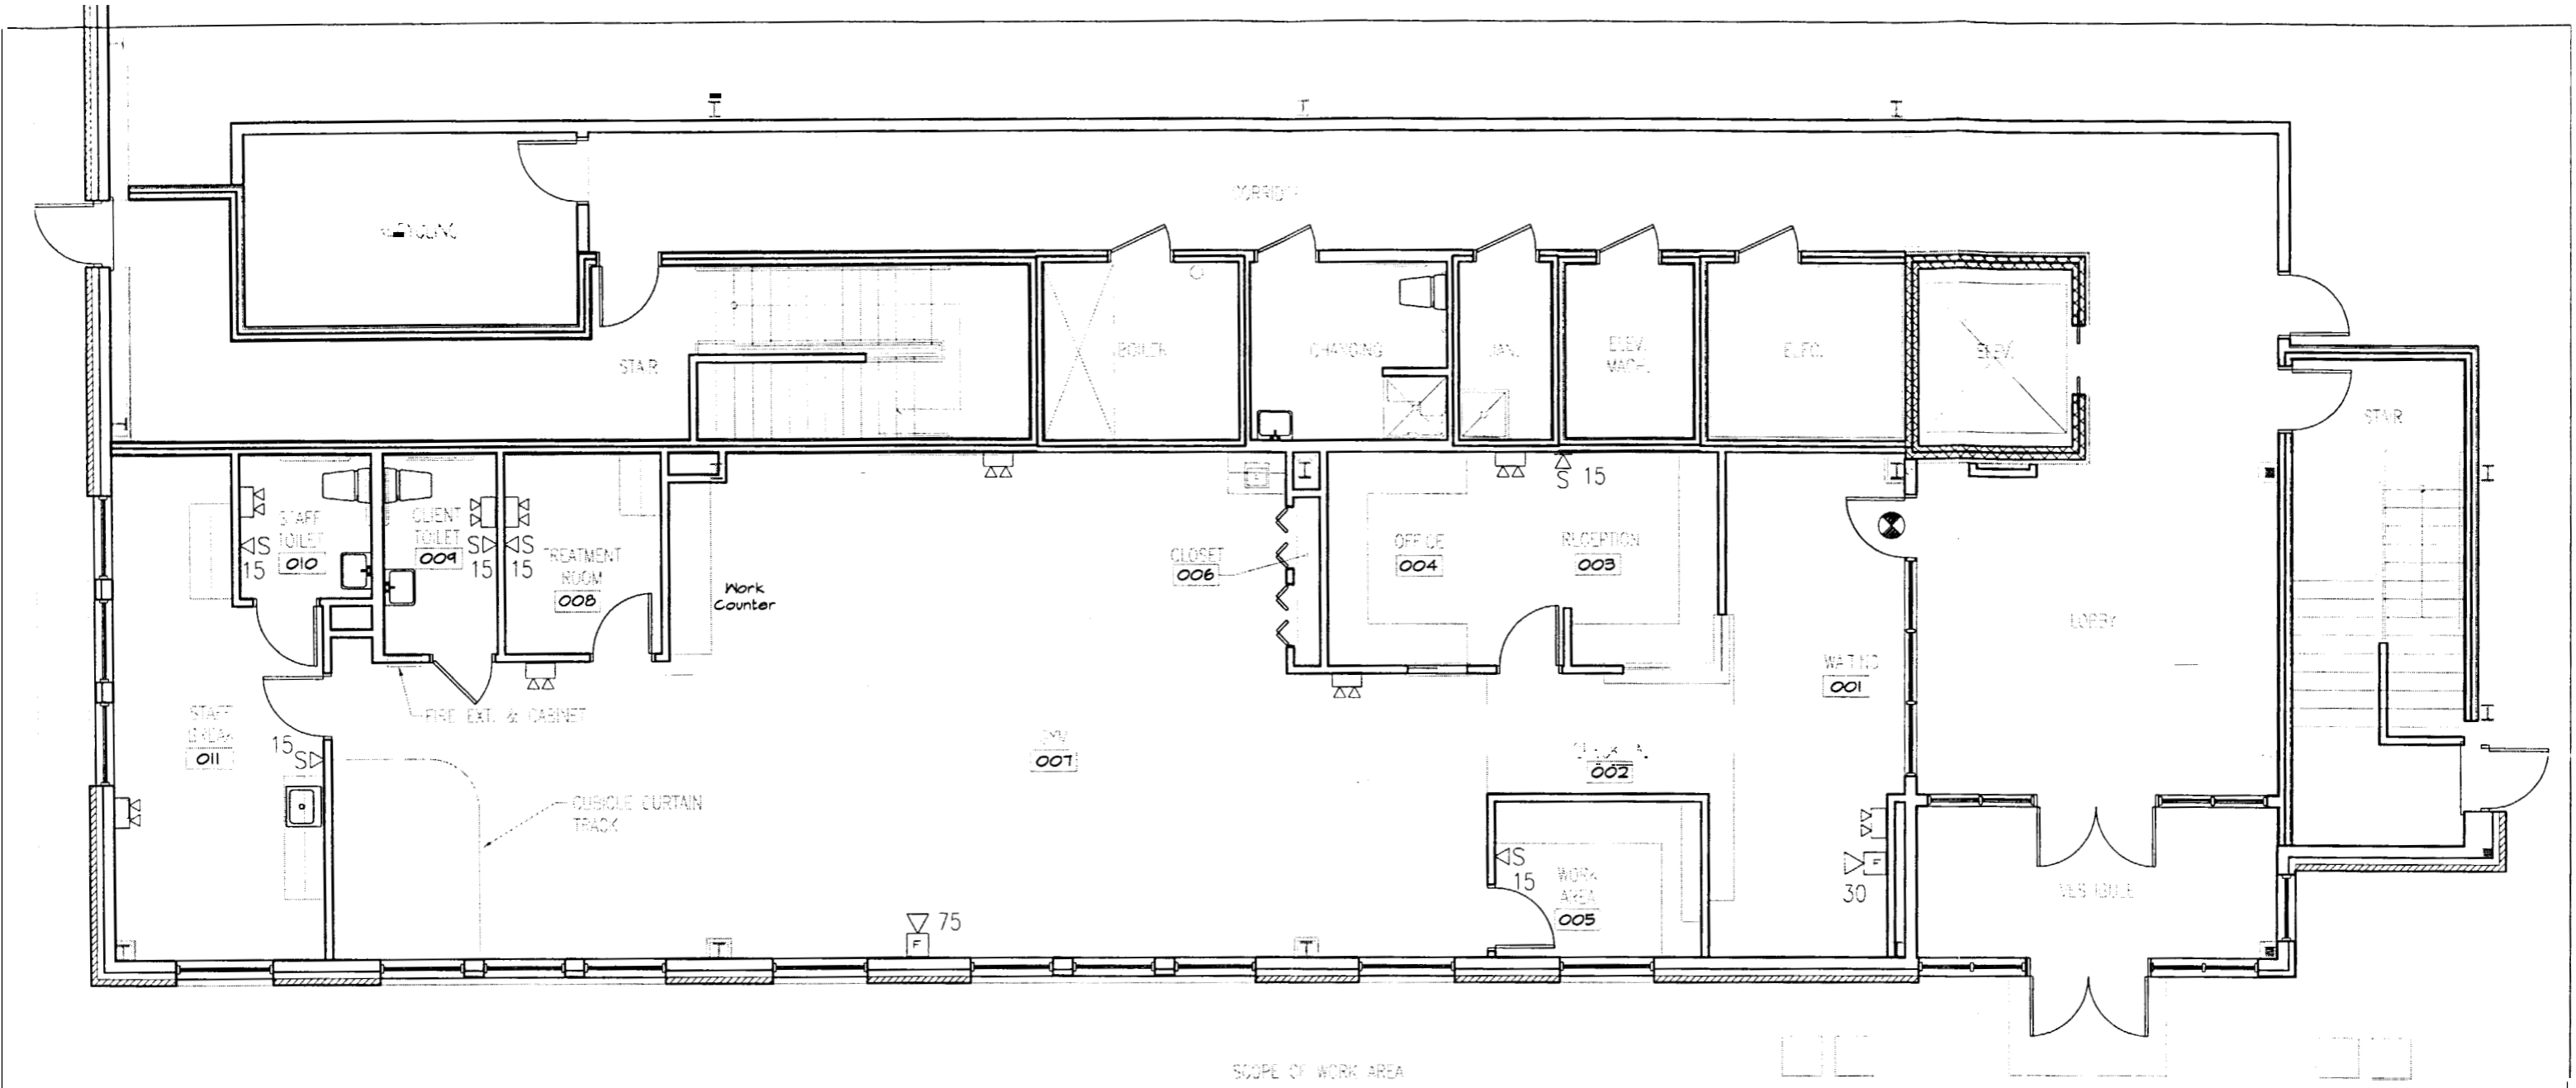



CONCEPT LIGHTING LAYOUT
AT WAITING #001/CHECK-IN #002
1/8" = 1'-0"



ELECTRICAL LIFE SAFETY PLAN

SCALE: 1/8"=1'-0"

  SYMBOL LEGEND

-  EXIT LIGHT FIXTURE-UNSWITCHED
-  EMERGENCY BATTERY UNIT - WITH TWO HEADS MOUNT AT 6'-8" AFF
-  FIRE ALARM AUDIO/VISUAL, MOUNT 6'-8" AFF NUMERALS DENOTE CANDELA RATING
-  FIRE ALARM VISUAL STROBE ONLY NUMERALS DENOTE CANDELA RATING MOUNT 6'-8" AFF