



LEGEND	
EXISTING	PROPOSED
— —	BOUNDARY LINE
---XXX---	CONTOUR MAJOR
---	CONTOUR MINOR
-D-	DRAINAGE
-E-	EASEMENT
-E-	ELECTRIC
-X-X-	FENCE CHAIN LINK
-O-O-	FENCE POST
-□-□-	FENCE STOCKADE
- - -	EDGE OF GRAVEL
- - -	EDGE OF PAVEMENT
- - -	EDGE OF RIVER
- - -	EDGE OF WETLAND
-G-	GAS
-□-□-	GUARDRAIL
-OHW-	OVER HEAD WIRES
-OHE-	OVER HEAD TELEPHONE
-OHE-	OVER HEAD ELECTRIC
- -	PROPERTY LINE
- - -	RETAINING WALL
-ROW-	RIGHT OF WAY
-S-	SEWER
-SF-	SILT FENCE
- - -	STONEWALL
- - -	STREAM
-T-	TELEPHONE
- - -	TREELINE
-W-	WATER
-L-	LIGHT

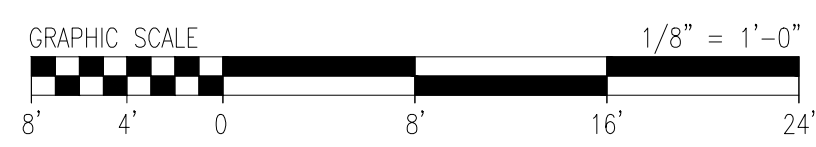


ISSUED FOR BID

REV	BY	DATE	DESCRIPTION	DWG NO.	REFERENCE DRAWINGS	SEAL AND SIGNATURE

PRJ MANAGER: MARK D. WOOD	CLIENT INFORMATION
PRJ ENGINEER: MARK D. WOOD	 ME GAS OPERATIONS
PRJ NAME: WEST COMMERCIAL STREET	
PRJ NUMBER: 5183	
PRJ MILESTONE: ISSUED FOR BID	
PRJ PHASE: ISSUED FOR BID	
DESIGNED BY: MDW 05/20/16	DESIGN MANAGER: TIM BICKFORD
DRAFTED BY: RPC 05/20/16	REVIEWED BY:
CHECKED BY: SMR 05/20/16	DESIGN ENGINEER: BOB SCHUMMRICK
APPROVED BY: MDW 05/20/16	AUTH NO: 6039 167616
	CHECKED BY:
	APPROVED BY:

SHEET TITLE	ENLARGED SITE PLAN
PROJECT NAME	WEST COMMERCIAL STREET REGULATOR STATION
PROJECT LOCATION	PORTLAND, ME 04101



1600 Providence Highway
Walpole, MA 02081
781.829.0524
processpipelineservices.com

FILE NAME: 5183_C00.DWG	SIZE	SHEET	REV
PLOT DATE: 05/25/2016 2:56 PM	22X34	A05	F
SCALE: 1/8" = 1'-0"	SHEET 10 OF 35		