



NOTES:

- SEE DRAWING G-001 FOR GENERAL NOTES.

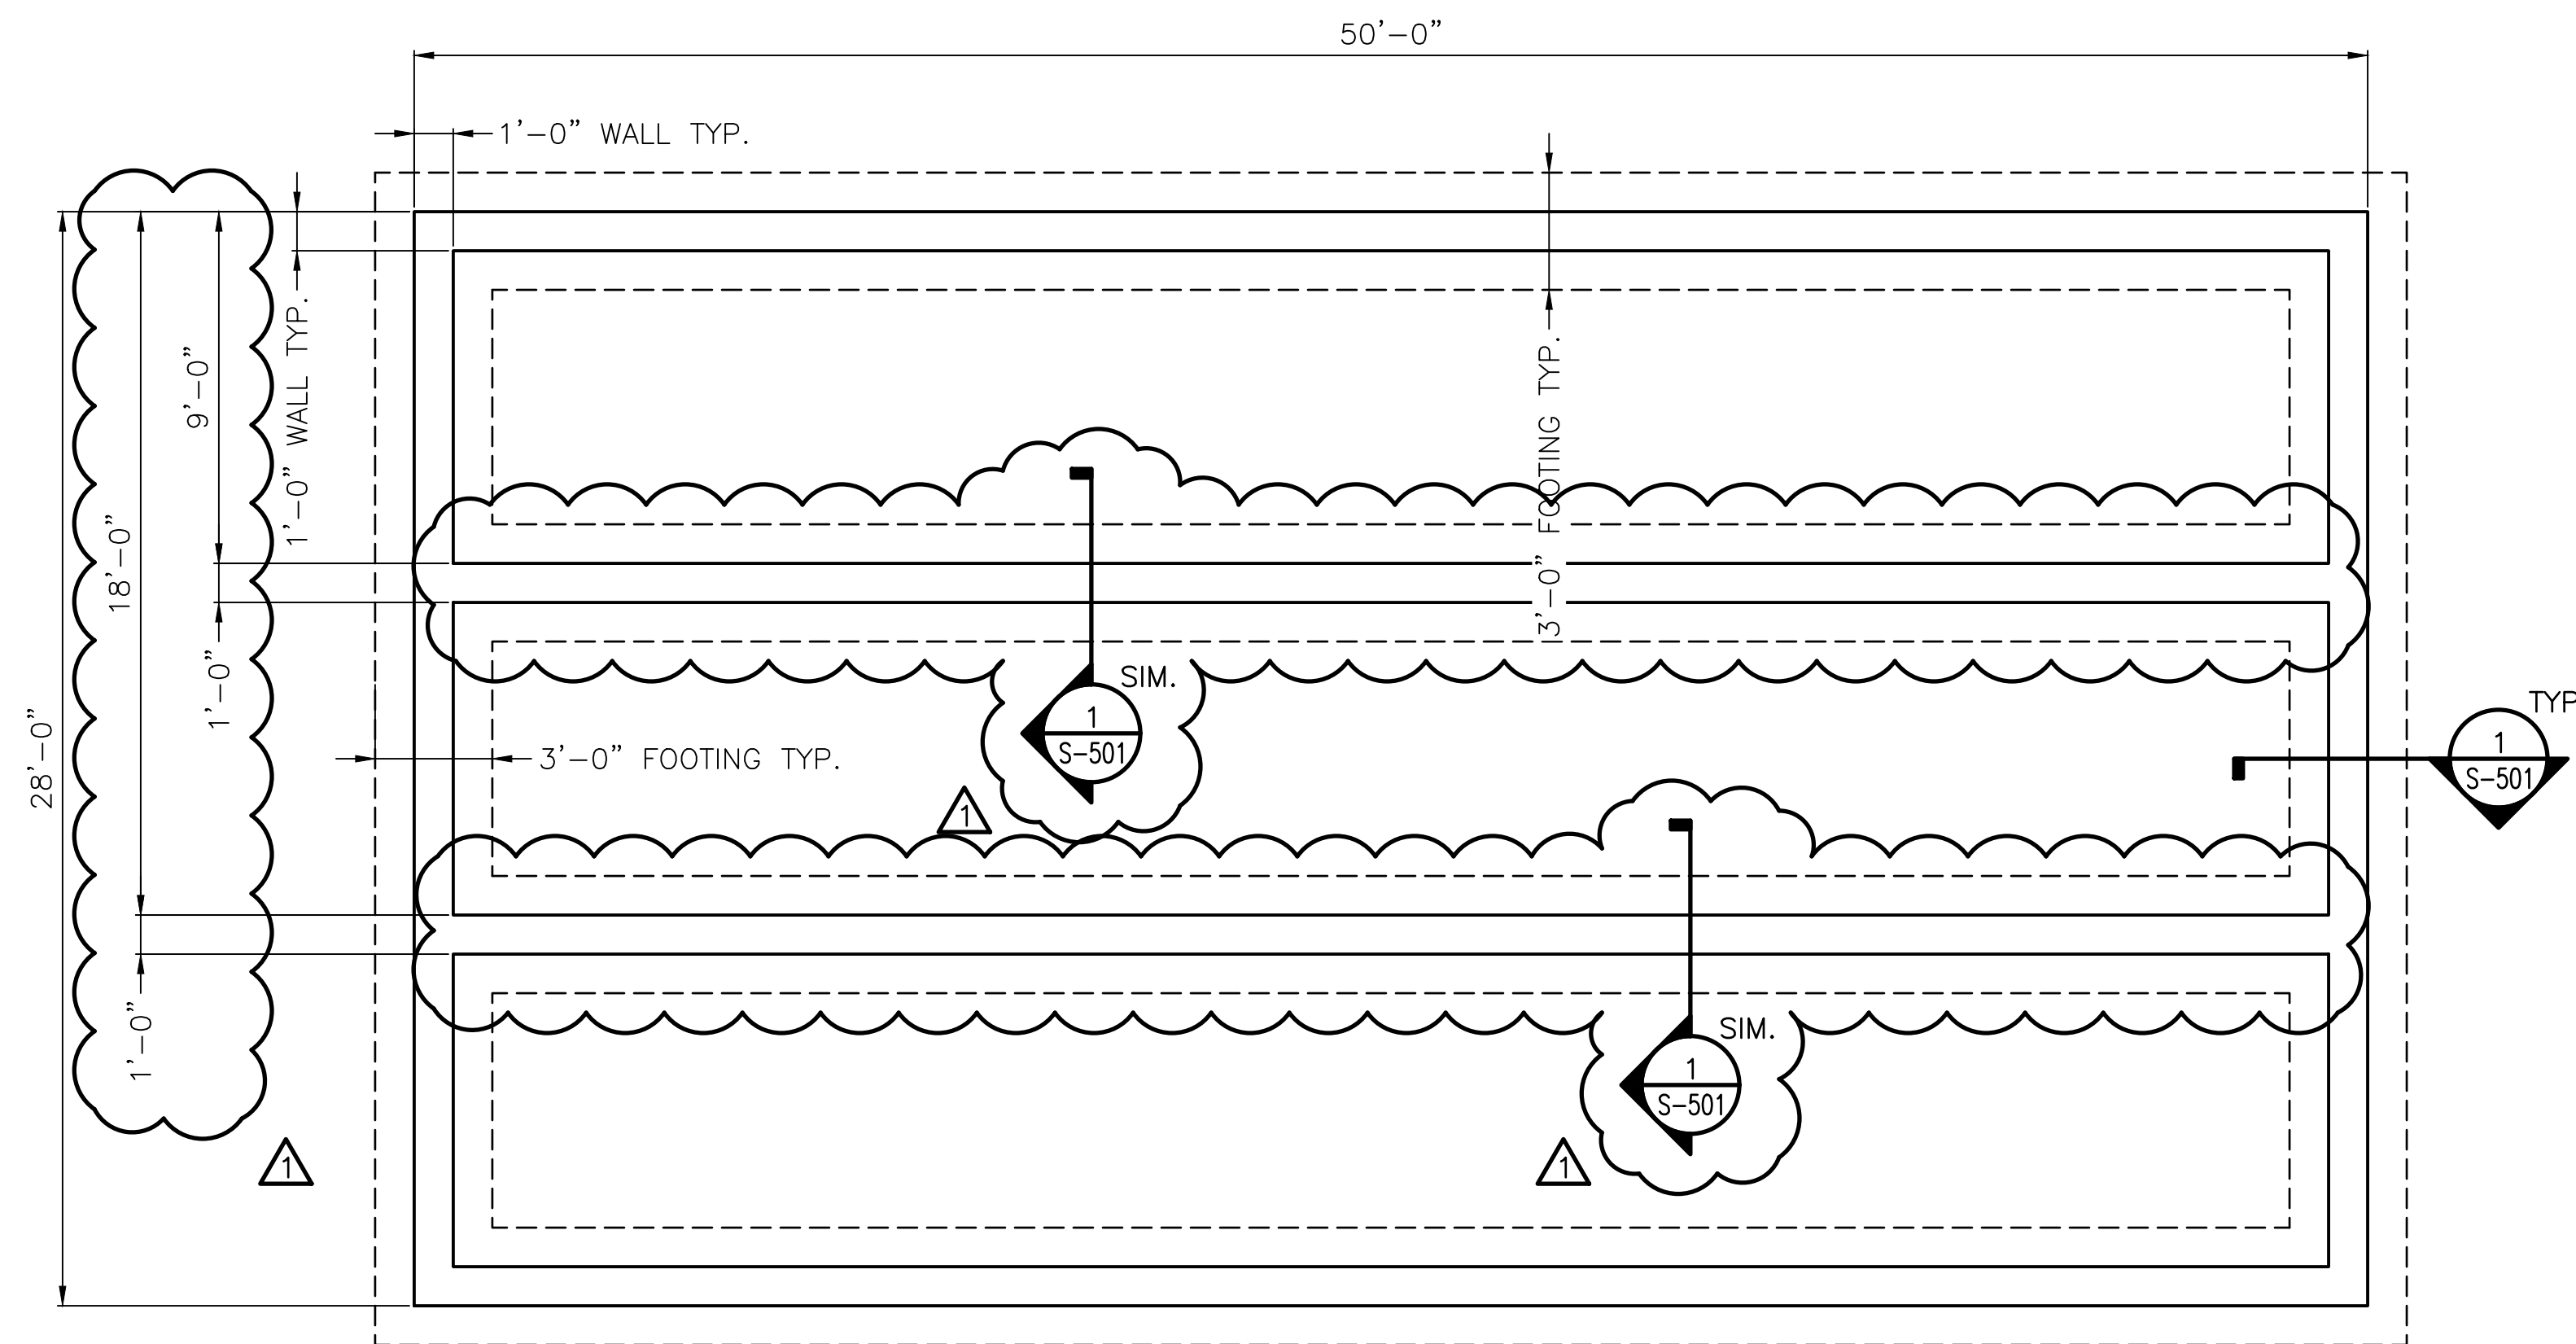



REGULATOR BUILDING FOUNDATION PLAN

SCALE: 1/4"=1'-0"

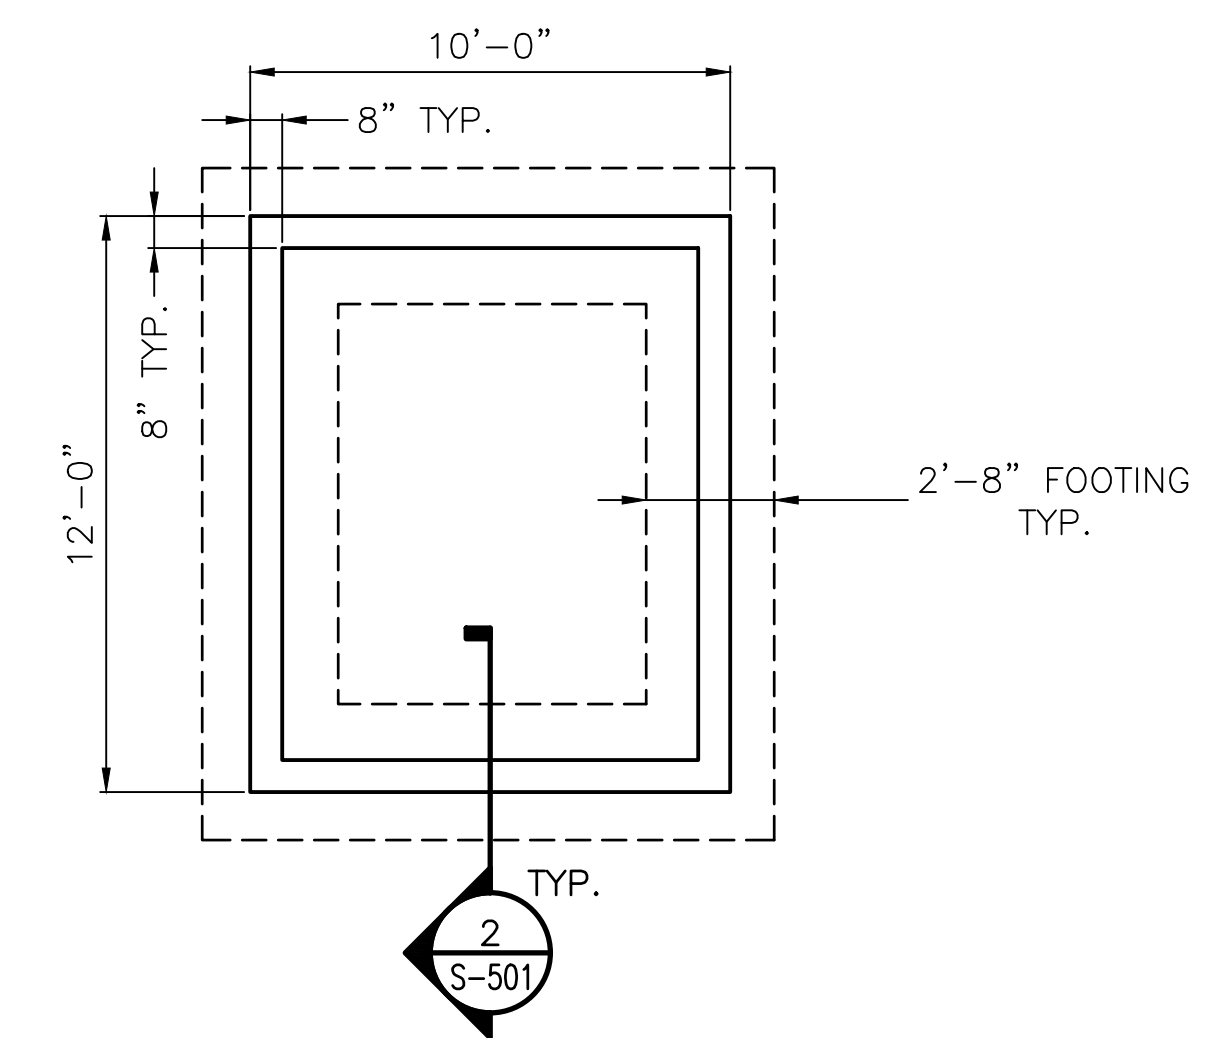


DAC BUILDING FOUNDATION PLAN

 SCALE: 1/4"=1'-0"

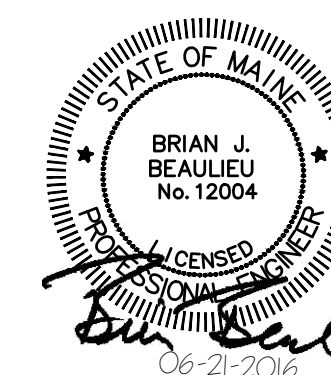

PLEASE NOTE: THIS DOCUMENT MAY NOT ACCURATELY REPRESENT THE FINAL DOCUMENT. ONLY AN ENGINEER, ARCHITECT OR SURVEYOR SIGNED, SEALED AND DATED PAPER COPY, PROVIDED BY THIS OFFICE, MAY BE UTILIZED FOR BIDDING OR CONSTRUCTION PURPOSES.

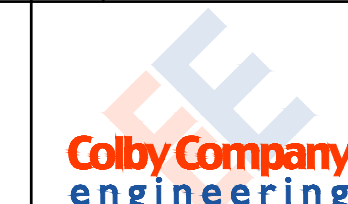

47A York Street
Portland, Maine 04101
207.533.7753
colbycoengineering.com

ANSI D
DATE: _____
DES BY: AKG
DWN BY: AKG
CKD BY: BJB

PROJECT NO.
312.002.001
SHEET
2 OF 4

DRAWING NO.

S-101

| | | | | PROCESS PIPELINE SERVICES | | | |
|-----|---------------------------|-----|-----|--|--|--|--|
| | | | | 232 WEST COMMERCIAL STREET PRESSURE REGULATING STATION FOUNDATION | | | |
| | | | | REGULATOR & DAC BLDG. FOUNDATIONS | | | |
| REV | DESCRIPTION | DWN | APP | DATE | | | |
| 1 | ADDITIONAL INTERIOR WALLS | AKG | BJB | 06/21/16 | | | |
| 0 | ISSUED FOR CONSTRUCTION | BCH | BJB | 05/11/16 | | | |